



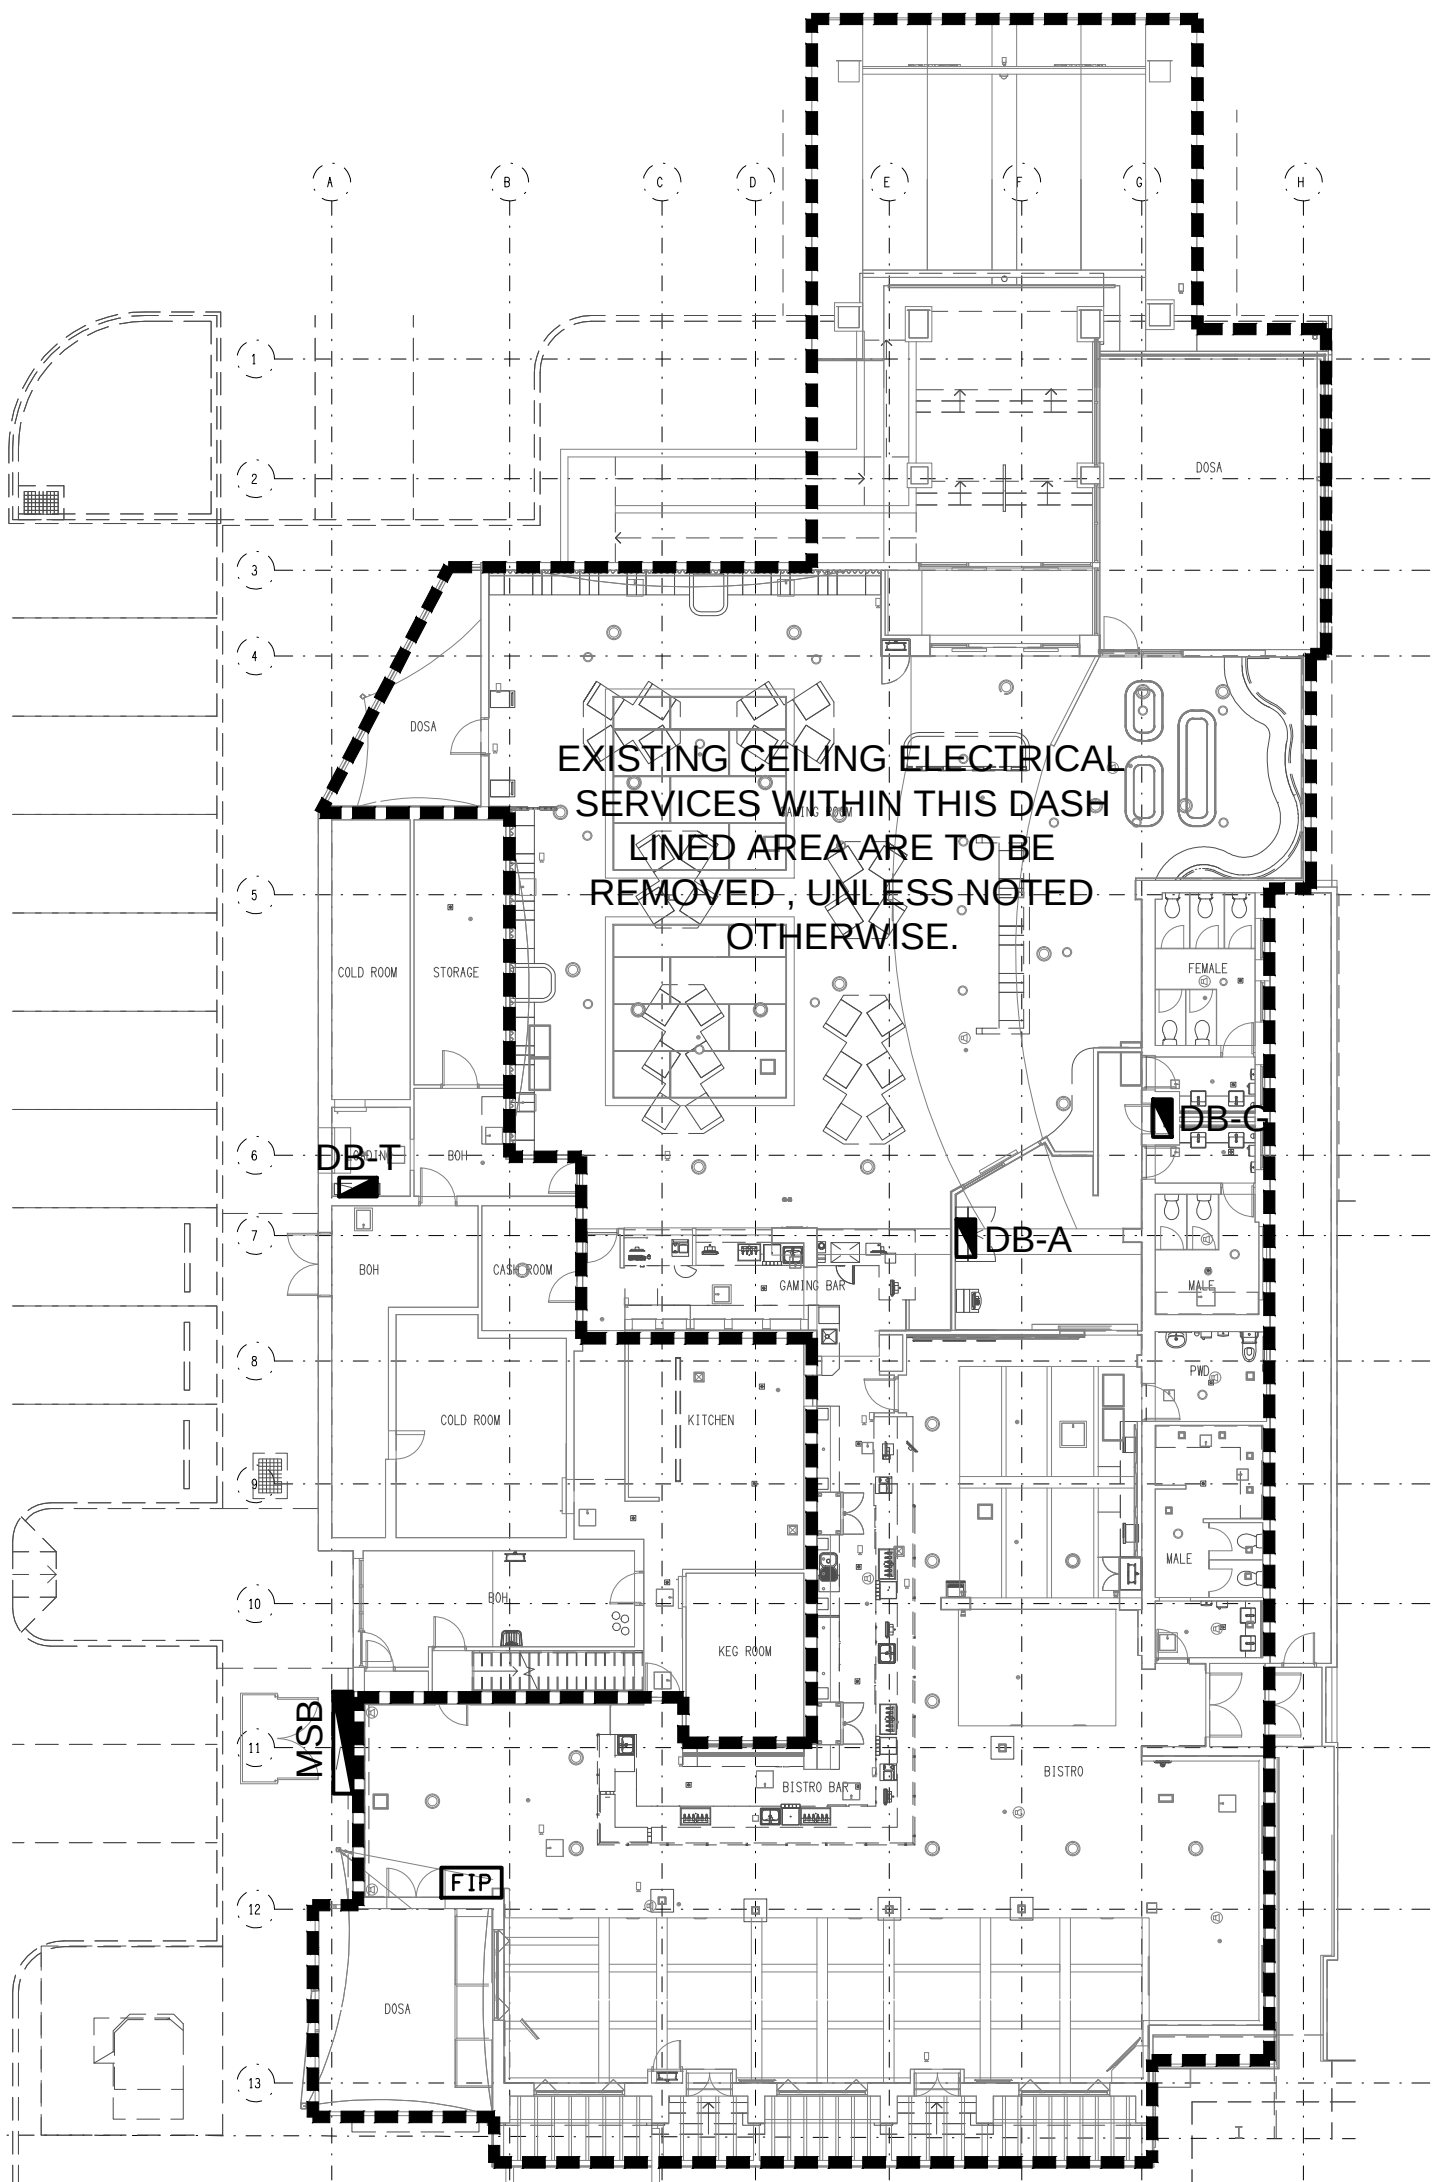

OVERALL CEILING PLAN
EXTENT OF WORKS
SCALE 1:200

NOTE:
REFER TO DRAWING C3556a-E05.dwg FOR ADDITIONAL
JOINERY & WALL LIGHTING PLAN & DETAILS.

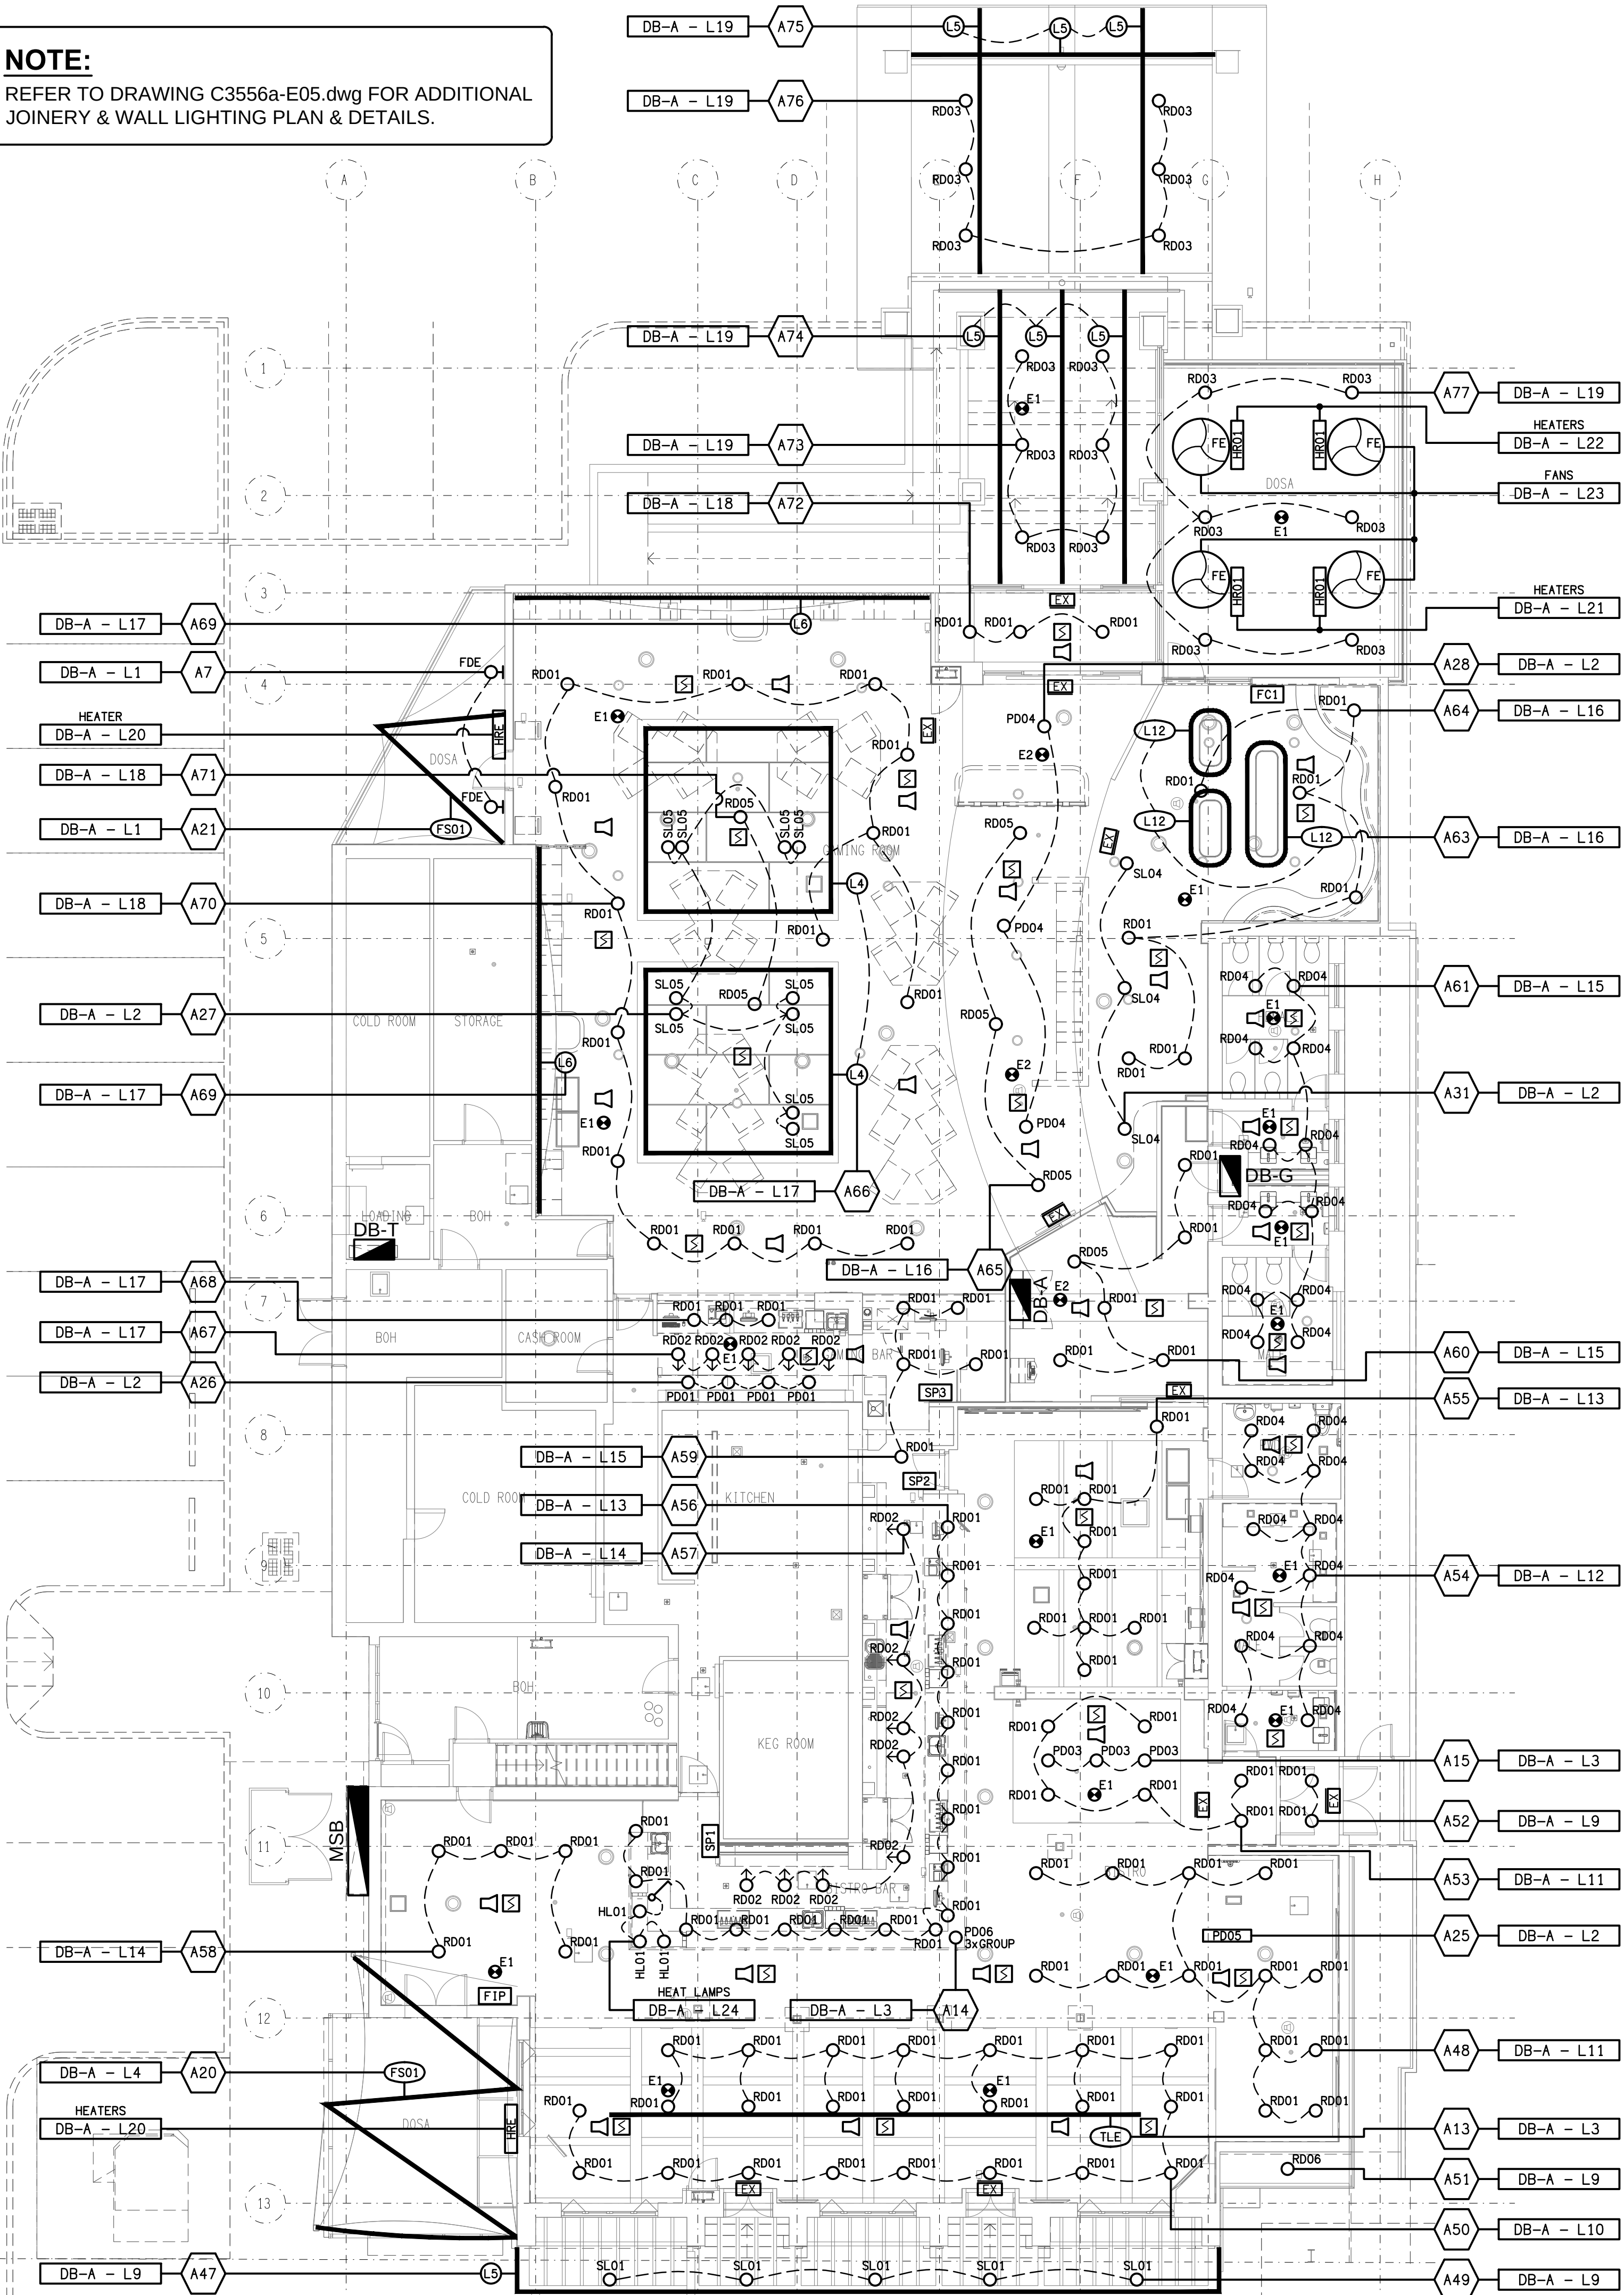

THE COPYRIGHT OF THIS DRAWING REMAINS THE PROPERTY OF
THE ELECTRICAL DESIGN GROUP.

USE FIGURED DIMENSIONS IN PREFERENCE TO SCALE.

ALL DIMENSIONS TO BE VERIFIED ONSITE.

C	CONSTRUCTION	06/08/2025
REV:	DESCRIPTION:	DATE:

ELECTRICAL DESIGN GROUP
ELECTRICAL BUILDING SERVICES CONSULTANTS

BRISBANE: P.O. Box 15 Sherwood Qld 4075
Phone: (07) 3278 4375
Email: brisbane@edg.net.au
Web: www.edg.net.au

ELECTRICAL DESIGN GROUP BRISBANE PTY LTD
ACN 092 710 793

TRADING AS:
ELECTRICAL DESIGN
GROUP

PROJECT:
ROYAL HOTEL, BEENLEIGH

SITE ADDRESS:
**85 GEORGE STREET, BEENLEIGH
QUEENSLAND**

SCALE: 1:100 SHEET SIZE: A1

DRAWING TITLE:
**ELECTRICAL SERVICES
REFLECTED CEILING PLAN**

PROJECT NO: DRAWING NO: REVISION:
C3556a E04 C