


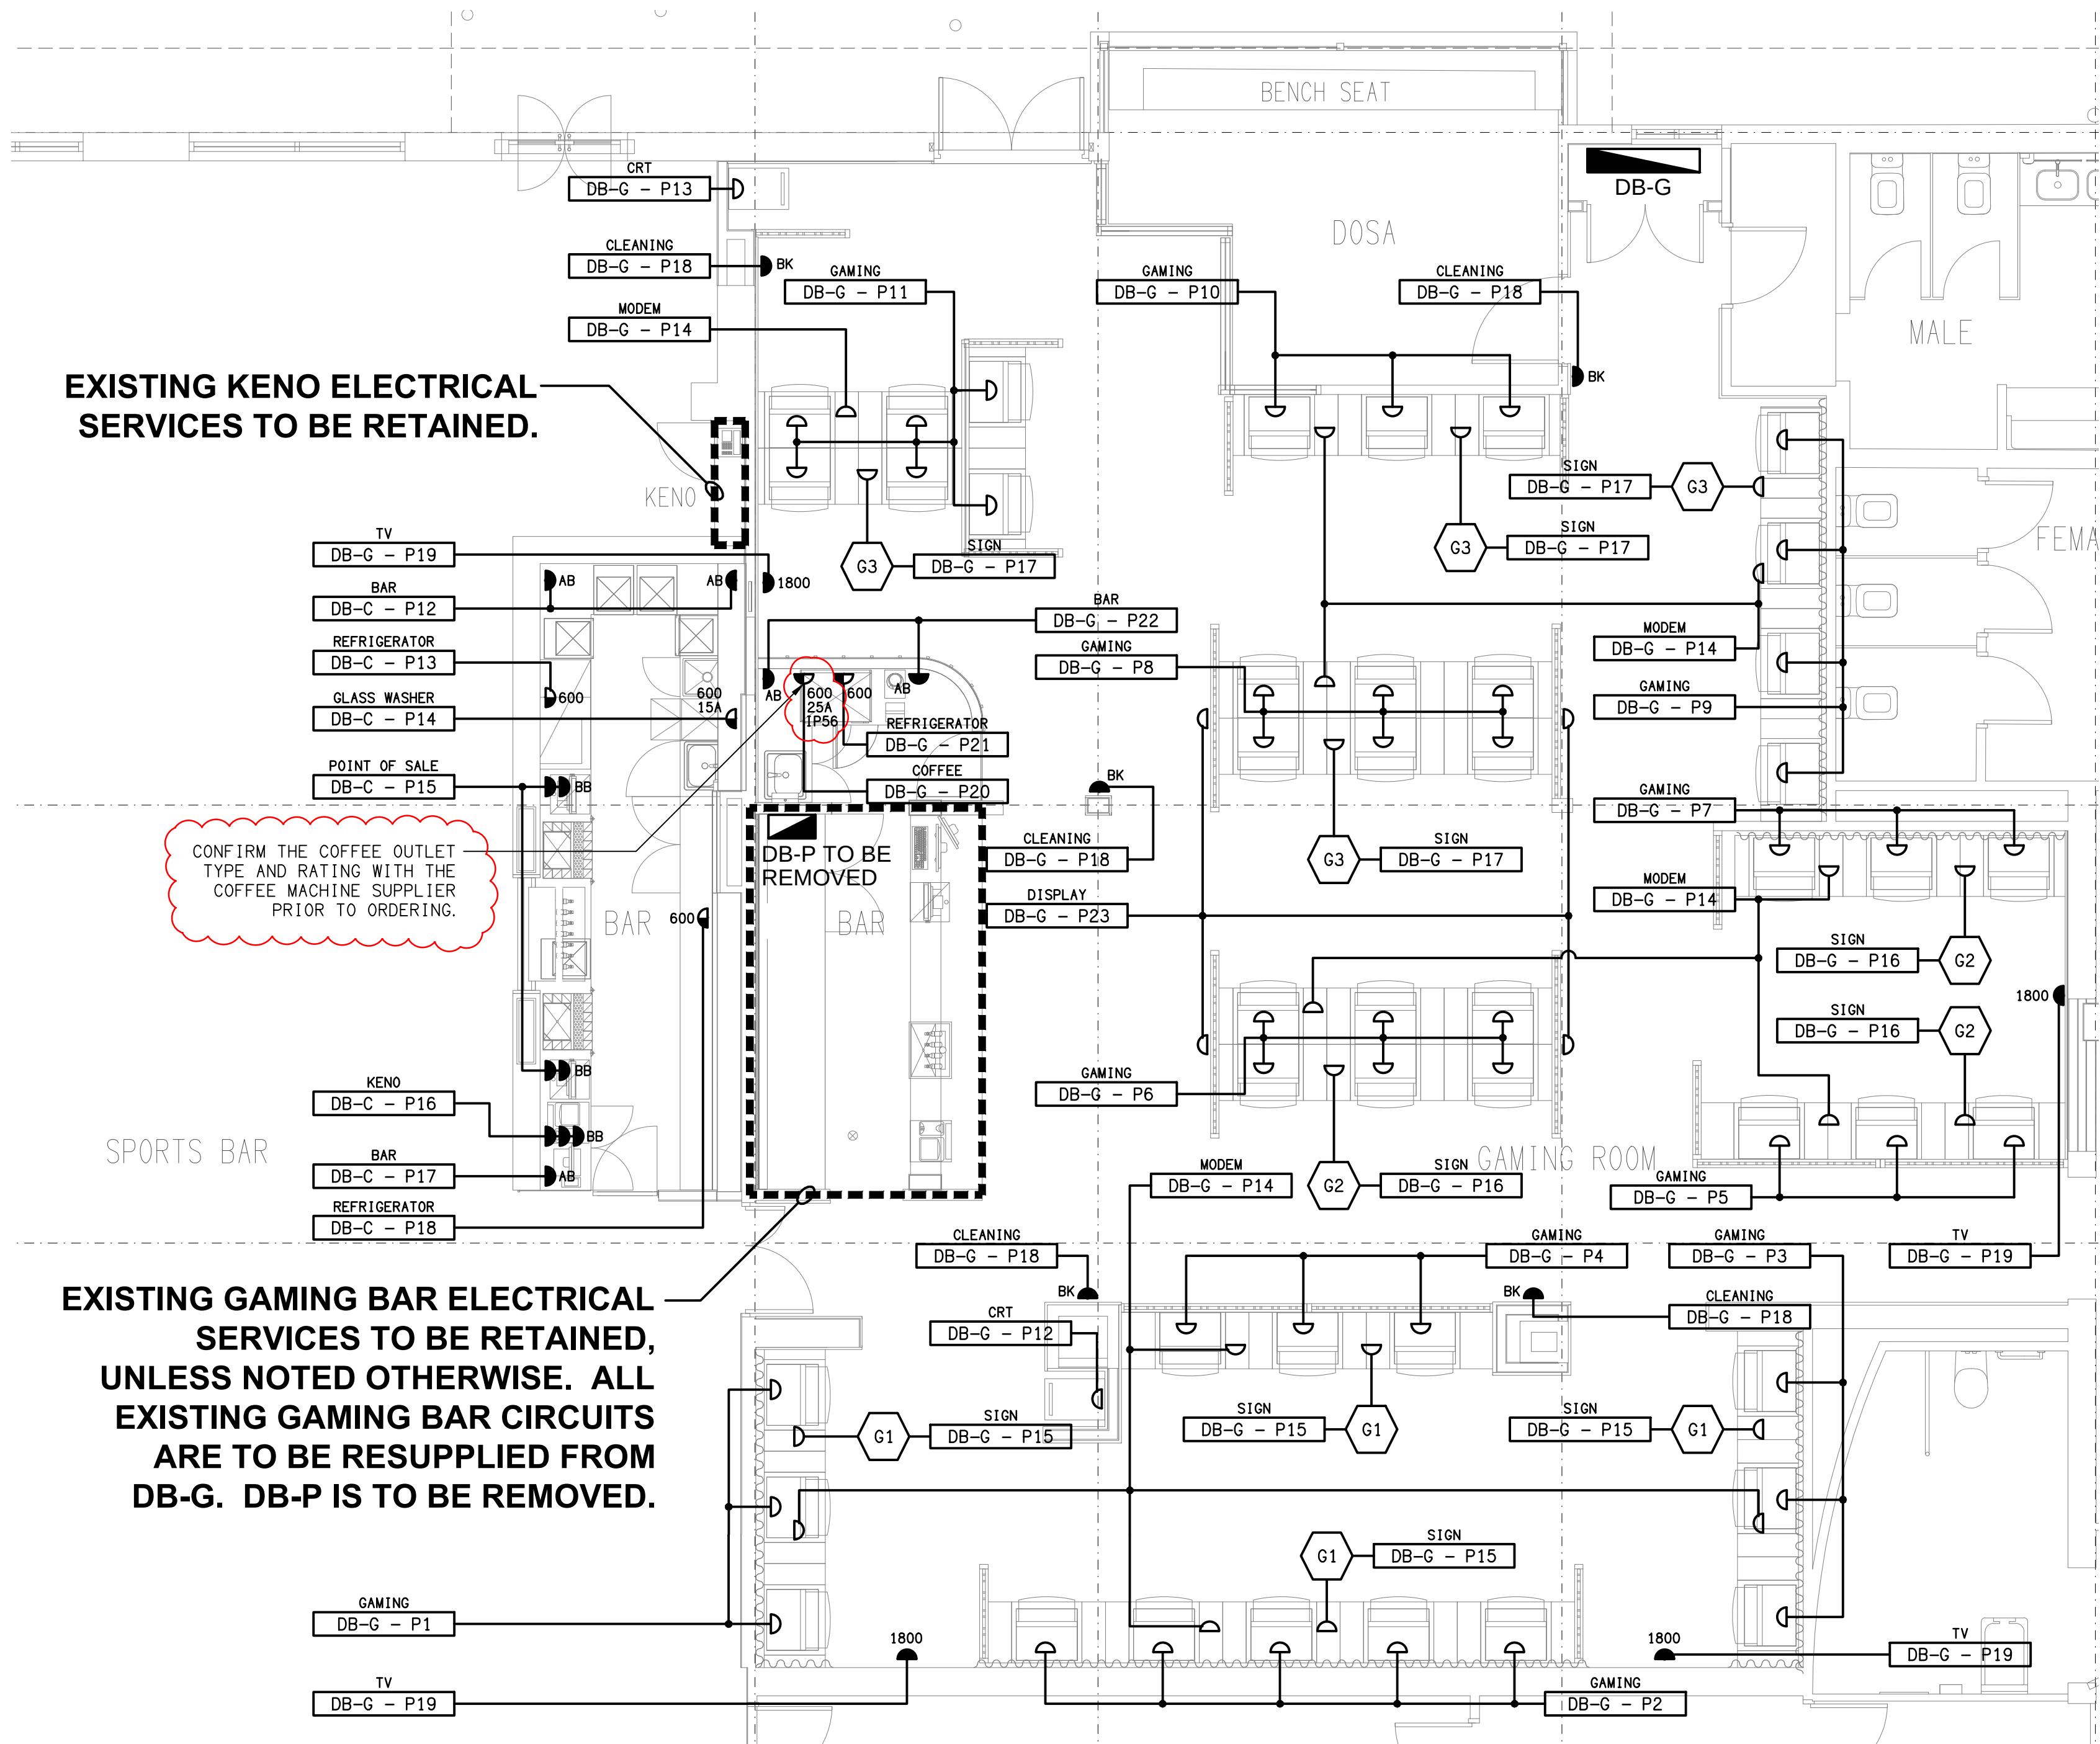

EXISTING KENO ELECTRICAL SERVICES TO BE RETAINED.

EXISTING GAMING BAR ELECTRICAL SERVICES TO BE RETAINED, UNLESS NOTED OTHERWISE. ALL EXISTING GAMING BAR CIRCUITS ARE TO BE RESUPPLIED FROM DB-G. DB-P IS TO BE REMOVED.

CONFIRM THE COFFEE OUTLET TYPE AND RATING WITH THE COFFEE MACHINE SUPPLIER PRIOR TO ORDERING.

D	CONSTRUCTION	22/09/2025
REV:	DESCRIPTION:	DATE:

ELECTRICAL DESIGN GROUP
ELECTRICAL BUILDING SERVICES CONSULTANTS

BRISBANE: P.O. Box 15 Sherwood Qld 4075
Phone: (07) 3278 4375
Email: brisbane@edg.net.au
Web: www.edg.net.au

ELECTRICAL DESIGN GROUP BRISBANE PTY LTD
ACN 092 710 793

TRADING AS:
ELECTRICAL DESIGN GROUP

PROJECT:

OXENFORD TAVERN

SITE ADDRESS:

179 OLD PACIFIC HIGHWAY,
OXENFORD, QUEENSLAND

SCALE: SHEET SIZE:

1:50 AT A1

DRAWING TITLE:

ELECTRICAL SERVICES
GAMING ROOM
FLOOR PLAN

PROJECT NO: DRAWING NO: REVISION:

C3585a E04 D