


THE COPYRIGHT OF THIS DRAWING REMAINS THE PROPERTY OF THE ELECTRICAL DESIGN GROUP.

USE FIGURED DIMENSIONS IN PREFERENCE TO SCALE.

ALL DIMENSIONS TO BE VERIFIED ONSITE.

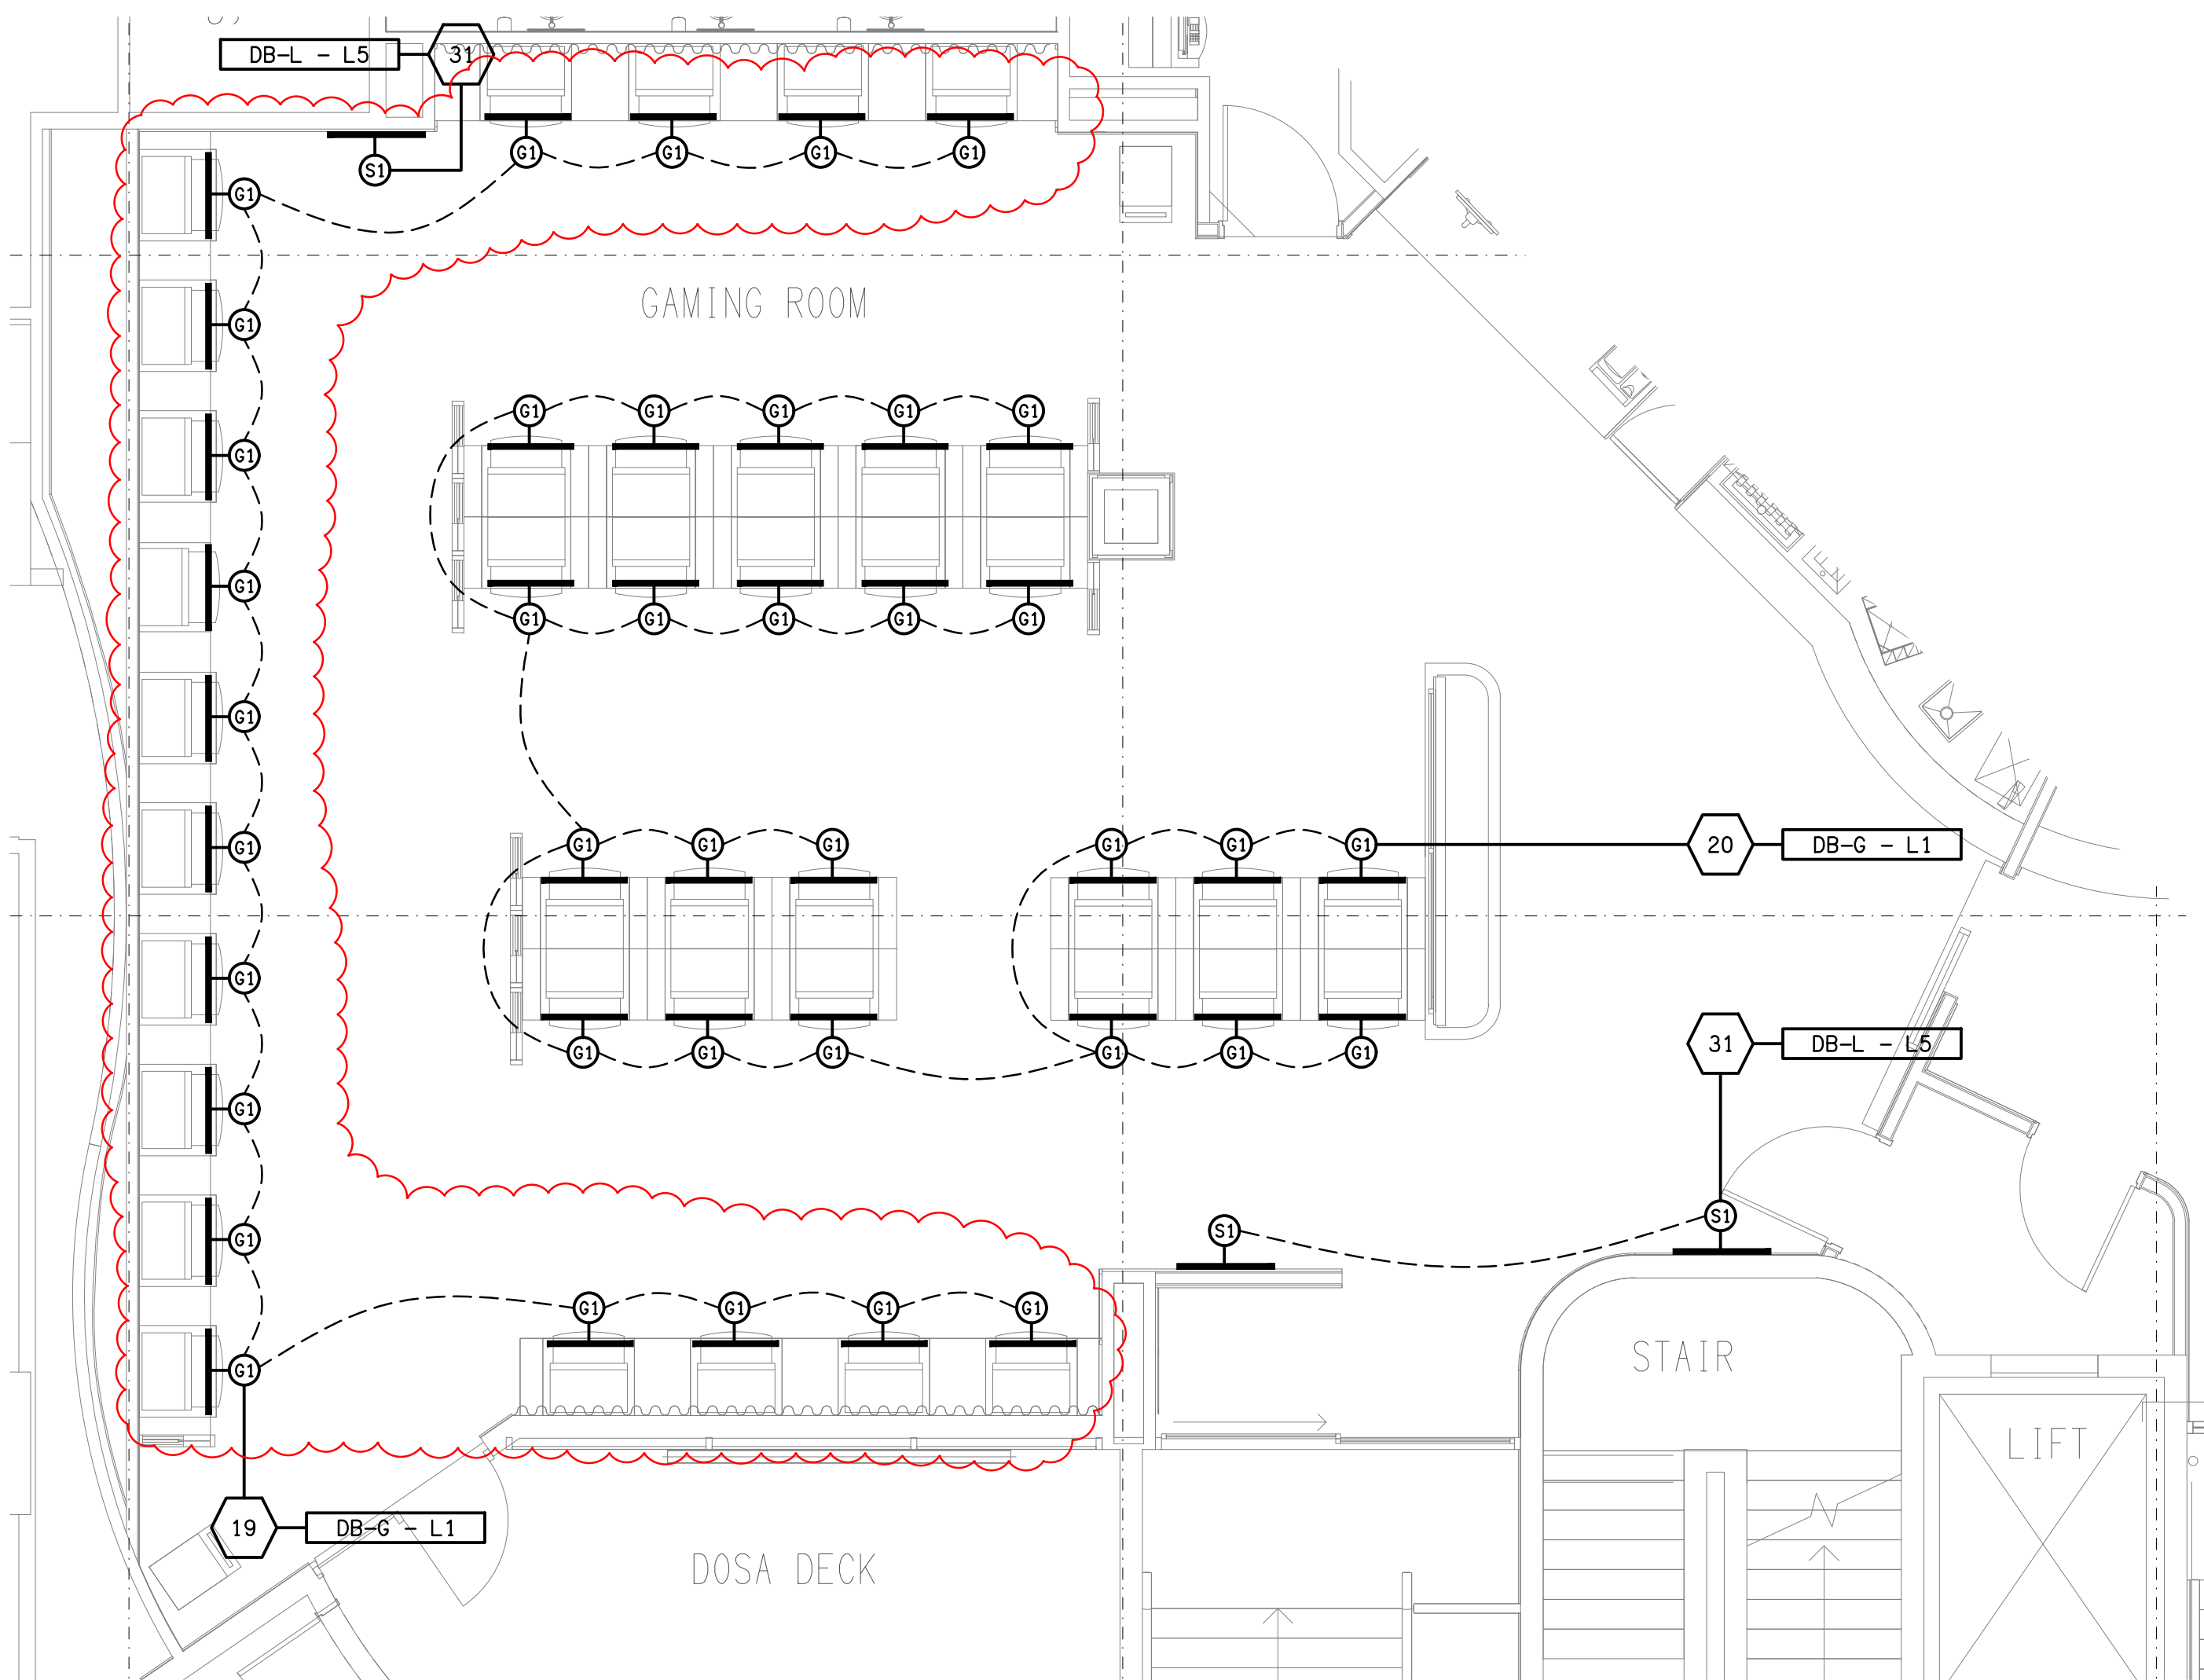


GAMING ROOM
LIGHTING PLAN
SCALE 1:50

**ADJUST / RELOCATE THE
EXISTING OUTLETS IN THIS
DASH LINED AREA TO
FACILITATE THE NEW WALL.**

NOTE:

THE LIGHTING CONTROL CHANNELS THAT
CONTROL THE DB-G CIRCUITS ARE TO CONTAIN
FACILITY IN DB-L TO ALLOW THE GAMING
ELECTRICIAN TO CONNECT THE CIRCUITS TO
THE CONTROLLERS IN DB-L.

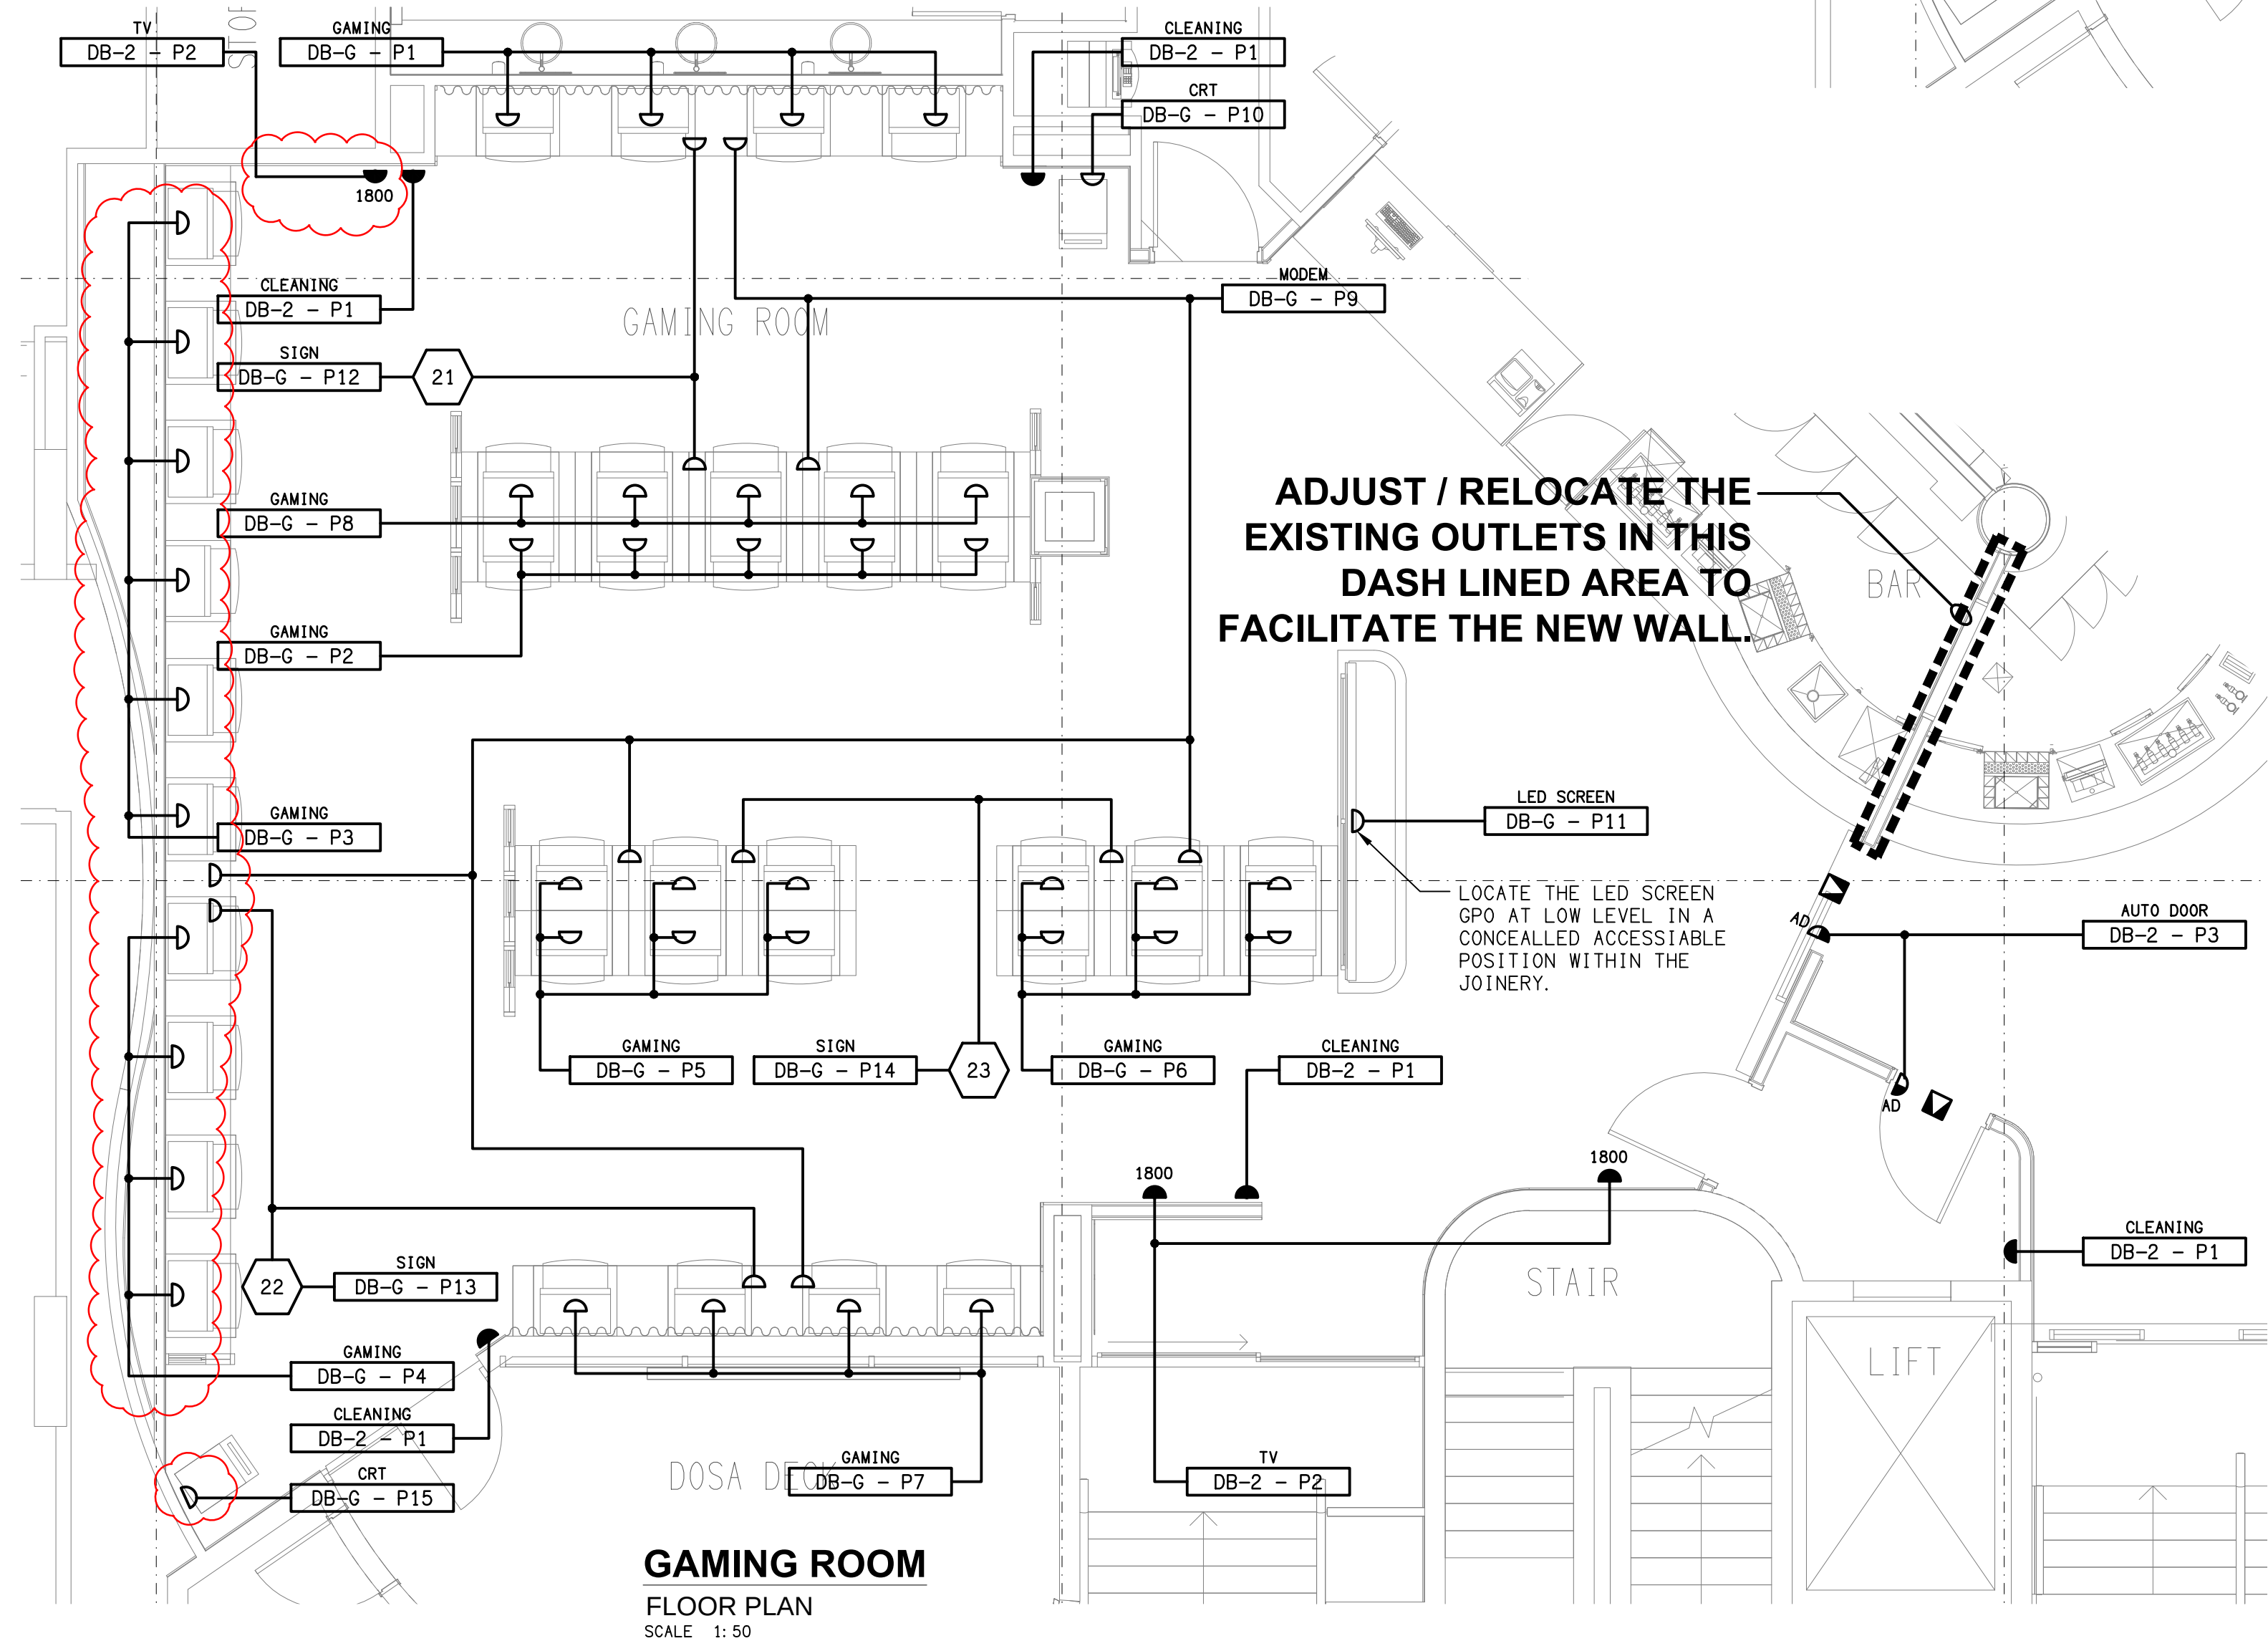

GAMING ROOM
FLOOR PLAN
SCALE 1:50

C	TENDER	05/11/2025
REV:	DESCRIPTION:	DATE:

ELECTRICAL DESIGN GROUP
ELECTRICAL BUILDING SERVICES CONSULTANTS

BRISBANE: P.O. Box 15 Sherwood Qld 4075
Phone: (07) 3278 4375
Email: brisbane@edg.net.au
Web: www.edg.net.au

ELECTRICAL DESIGN GROUP BRISBANE PTY LTD
ACN 092 710 793

TRADING AS:
ELECTRICAL DESIGN
GROUP

PROJECT:
BURLEIGH HEADS HOTEL

SITE ADDRESS:
**4 THE ESPLANADE, BURLEIGH HEADS
QUEENSLAND**

SCALE: 1:50 SHEET SIZE: A1
AT

DRAWING TITLE:

ELECTRICAL SERVICES
GAMING ROOM & BAR
FLOOR PLANS

PROJECT NO: DRAWING NO: REVISION:

C3591a E04 C