


EXISTING ELECTRICAL CEILING SERVICES WITHIN THIS AREA ARE TO BE REMOVED, UNLESS NOTED OTHERWISE.

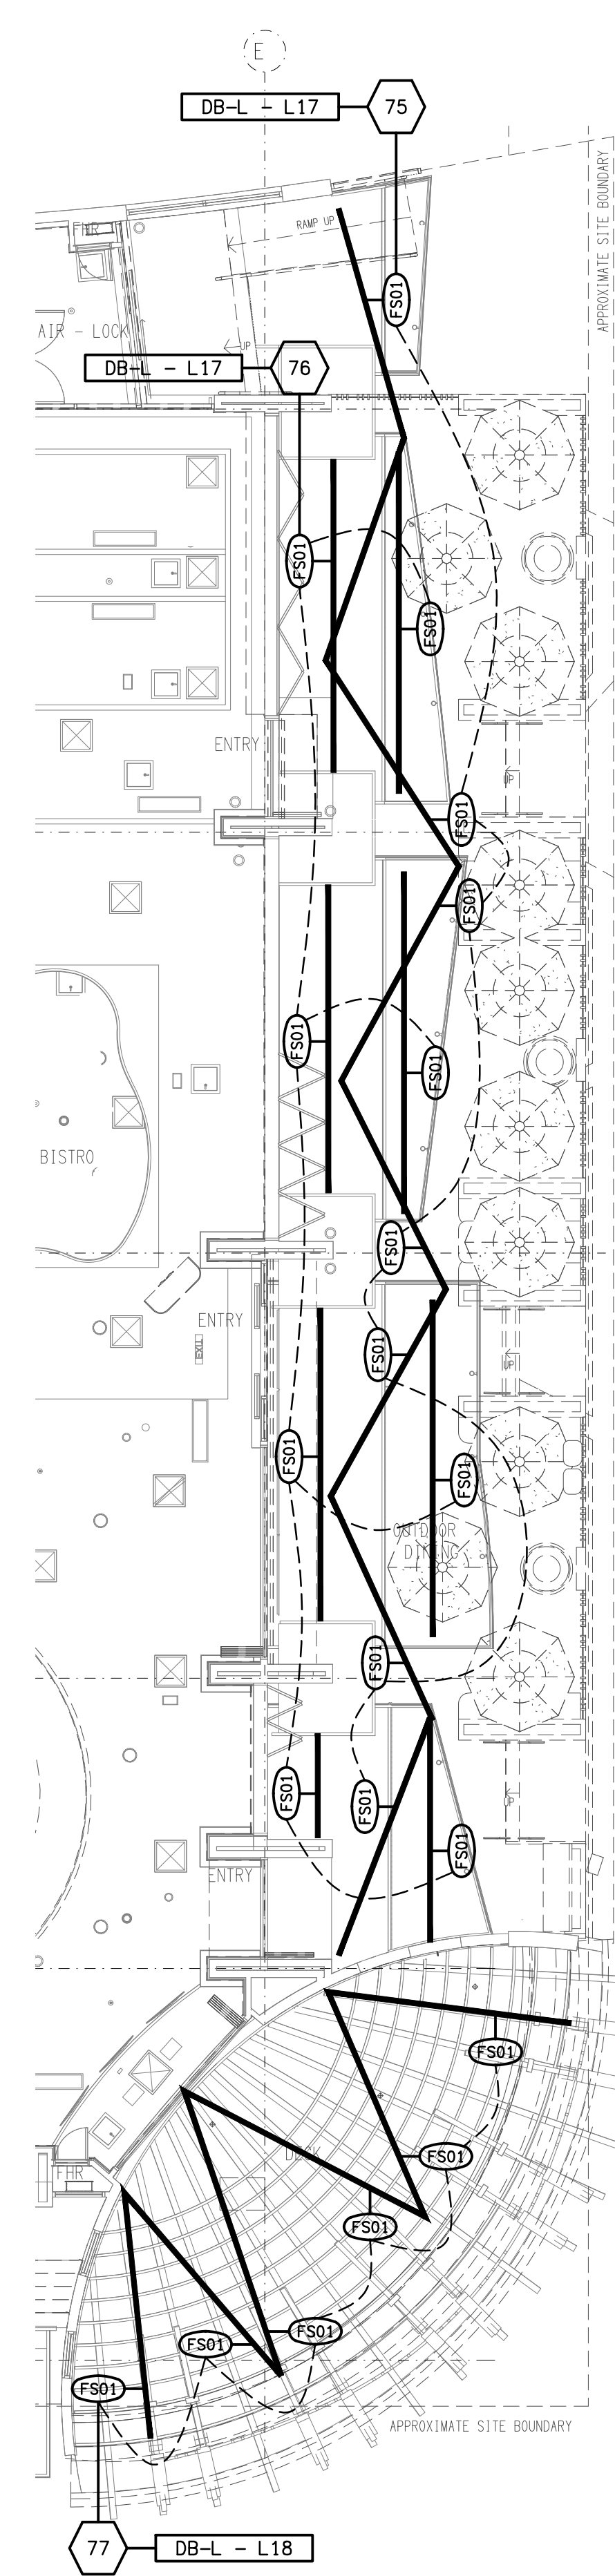

FESTOON LIGHTING
REFLECTED CEILING PLAN
SCALE 1:100

THE COPYRIGHT OF THIS DRAWING REMAINS THE PROPERTY OF THE ELECTRICAL DESIGN GROUP.

USE FIGURED DIMENSIONS IN PREFERENCE TO SCALE.

ALL DIMENSIONS TO BE VERIFIED ONSITE.

| | | |
|------|--------------|------------|
| B | TENDER | 01/10/2025 |
| REV: | DESCRIPTION: | DATE: |

ELECTRICAL DESIGN GROUP
ELECTRICAL BUILDING SERVICES CONSULTANTS

BRISBANE: P.O. Box 15 Sherwood Qld 4075
Phone: (07) 3278 4375
Email: brisbane@edg.net.au
Web: www.edg.net.au

ELECTRICAL DESIGN GROUP BRISBANE PTY LTD
ACN 092 710 793

TRADING AS:
ELECTRICAL DESIGN GROUP

PROJECT:
BURLEIGH HEADS HOTEL

SITE ADDRESS:
4 THE ESPLANADE, BURLEIGH HEADS QUEENSLAND

SCALE: 1:100 SHEET SIZE: A1

DRAWING TITLE:
ELECTRICAL SERVICES REFLECTED CEILING PLAN

PROJECT NO: DRAWING NO: REVISION:

C3591a E05 B