



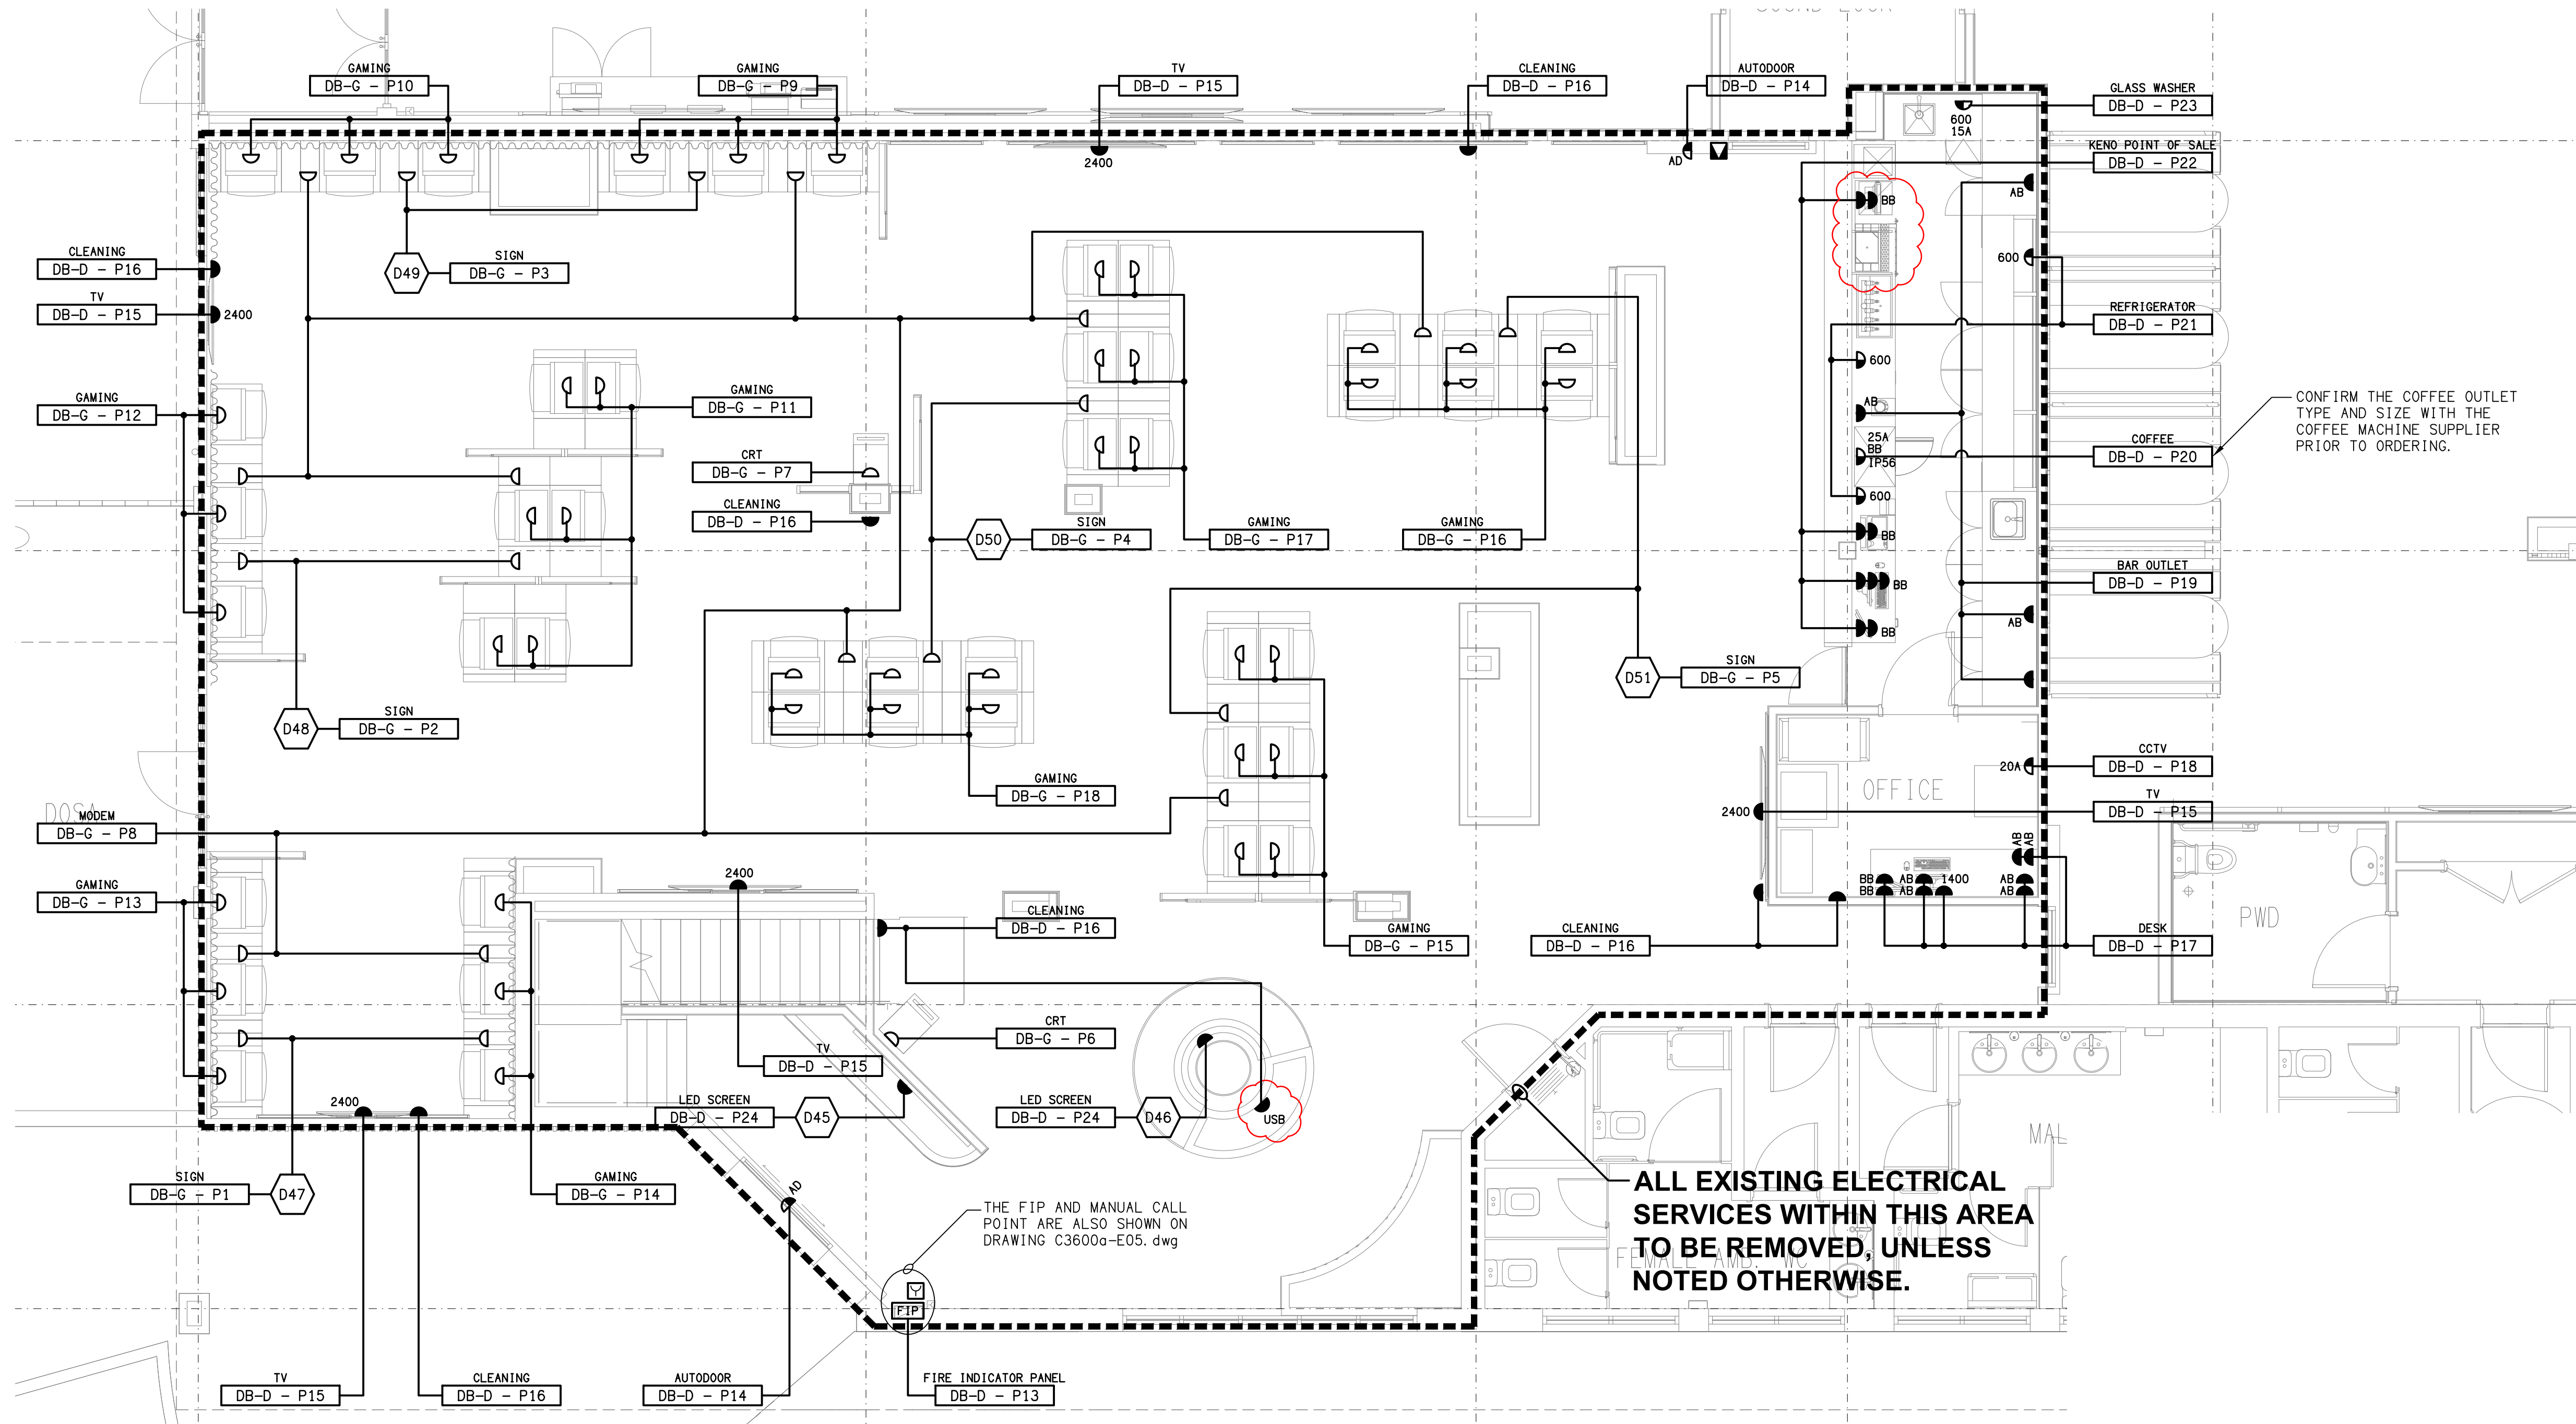

FLOOR PLAN
GAMING ROOM
SCALE 1:50

ALL EXISTING ELECTRICAL SERVICES WITHIN THIS AREA TO BE REMOVED, UNLESS NOTED OTHERWISE.

NOTE:
THE LIGHTING CONTROL CHANNELS THAT CONTROL THE DB-G CIRCUITS ARE TO CONTAIN FACILITY IN DB-D TO ALLOW THE GAMING ELECTRICIAN TO CONNECT THE CIRCUITS TO THE CONTROLLERS IN DB-D.

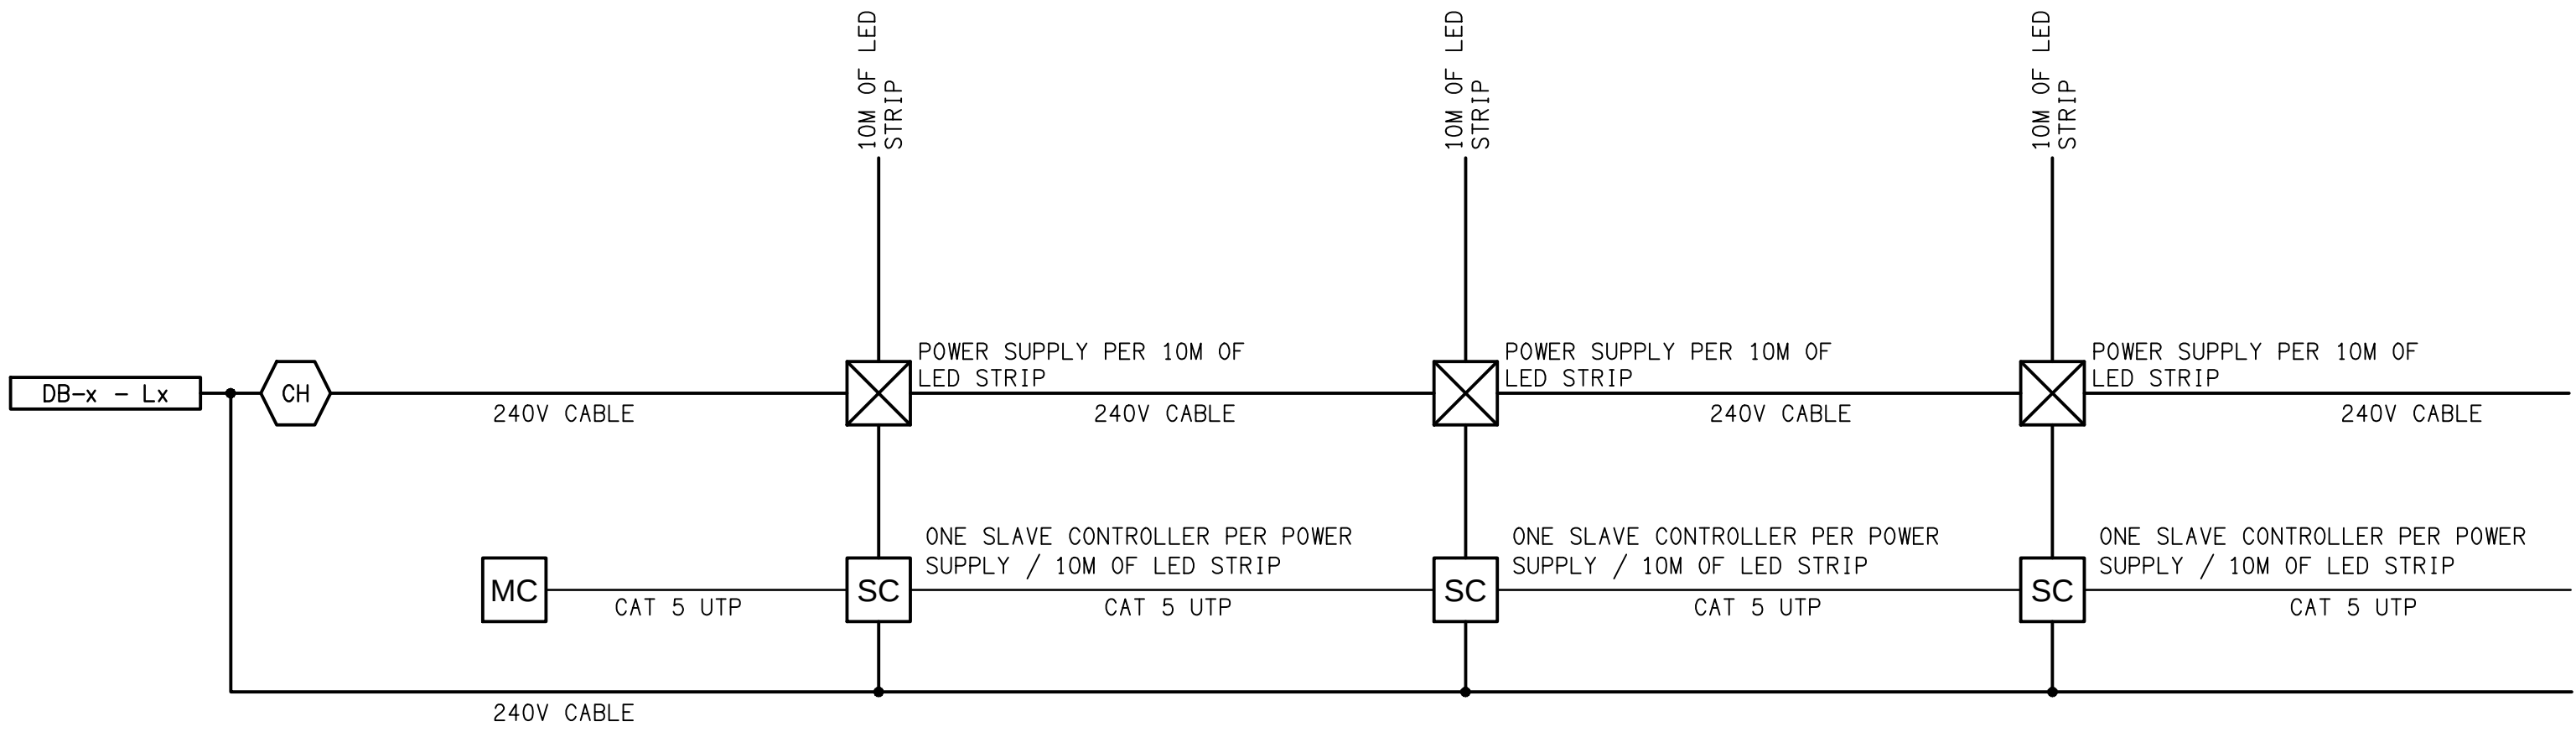

SCHEMATIC
RGB CONTROL
NOT TO SCALE

TO ADDITIONAL SLAVE CONTROLLERS AND POWER SUPPLIES AS REQUIRED.

ELECTRICAL DESIGN GROUP
ELECTRICAL BUILDING SERVICES CONSULTANTS

BRISBANE: P.O. Box 15 Sherwood Qld 4075
Phone: (07) 3278 4375
Email: brisbane@edg.net.au
Web: www.edg.net.au

ELECTRICAL DESIGN GROUP BRISBANE PTY LTD
ACN 092 710 793

TRADING AS:
ELECTRICAL DESIGN GROUP

PROJECT:

BENOWA TAVERN

SITE ADDRESS:

**117 ASHMORE ROAD, BENOWA
GOLD COAST**

SCALE: SHEET SIZE:

1:50 AT **A1**

DRAWING TITLE:

**ELECTRICAL SERVICES
GAMING ROOM
FLOOR PLAN**

PROJECT NO: DRAWING NO: REVISION:

C3600a E06 E