



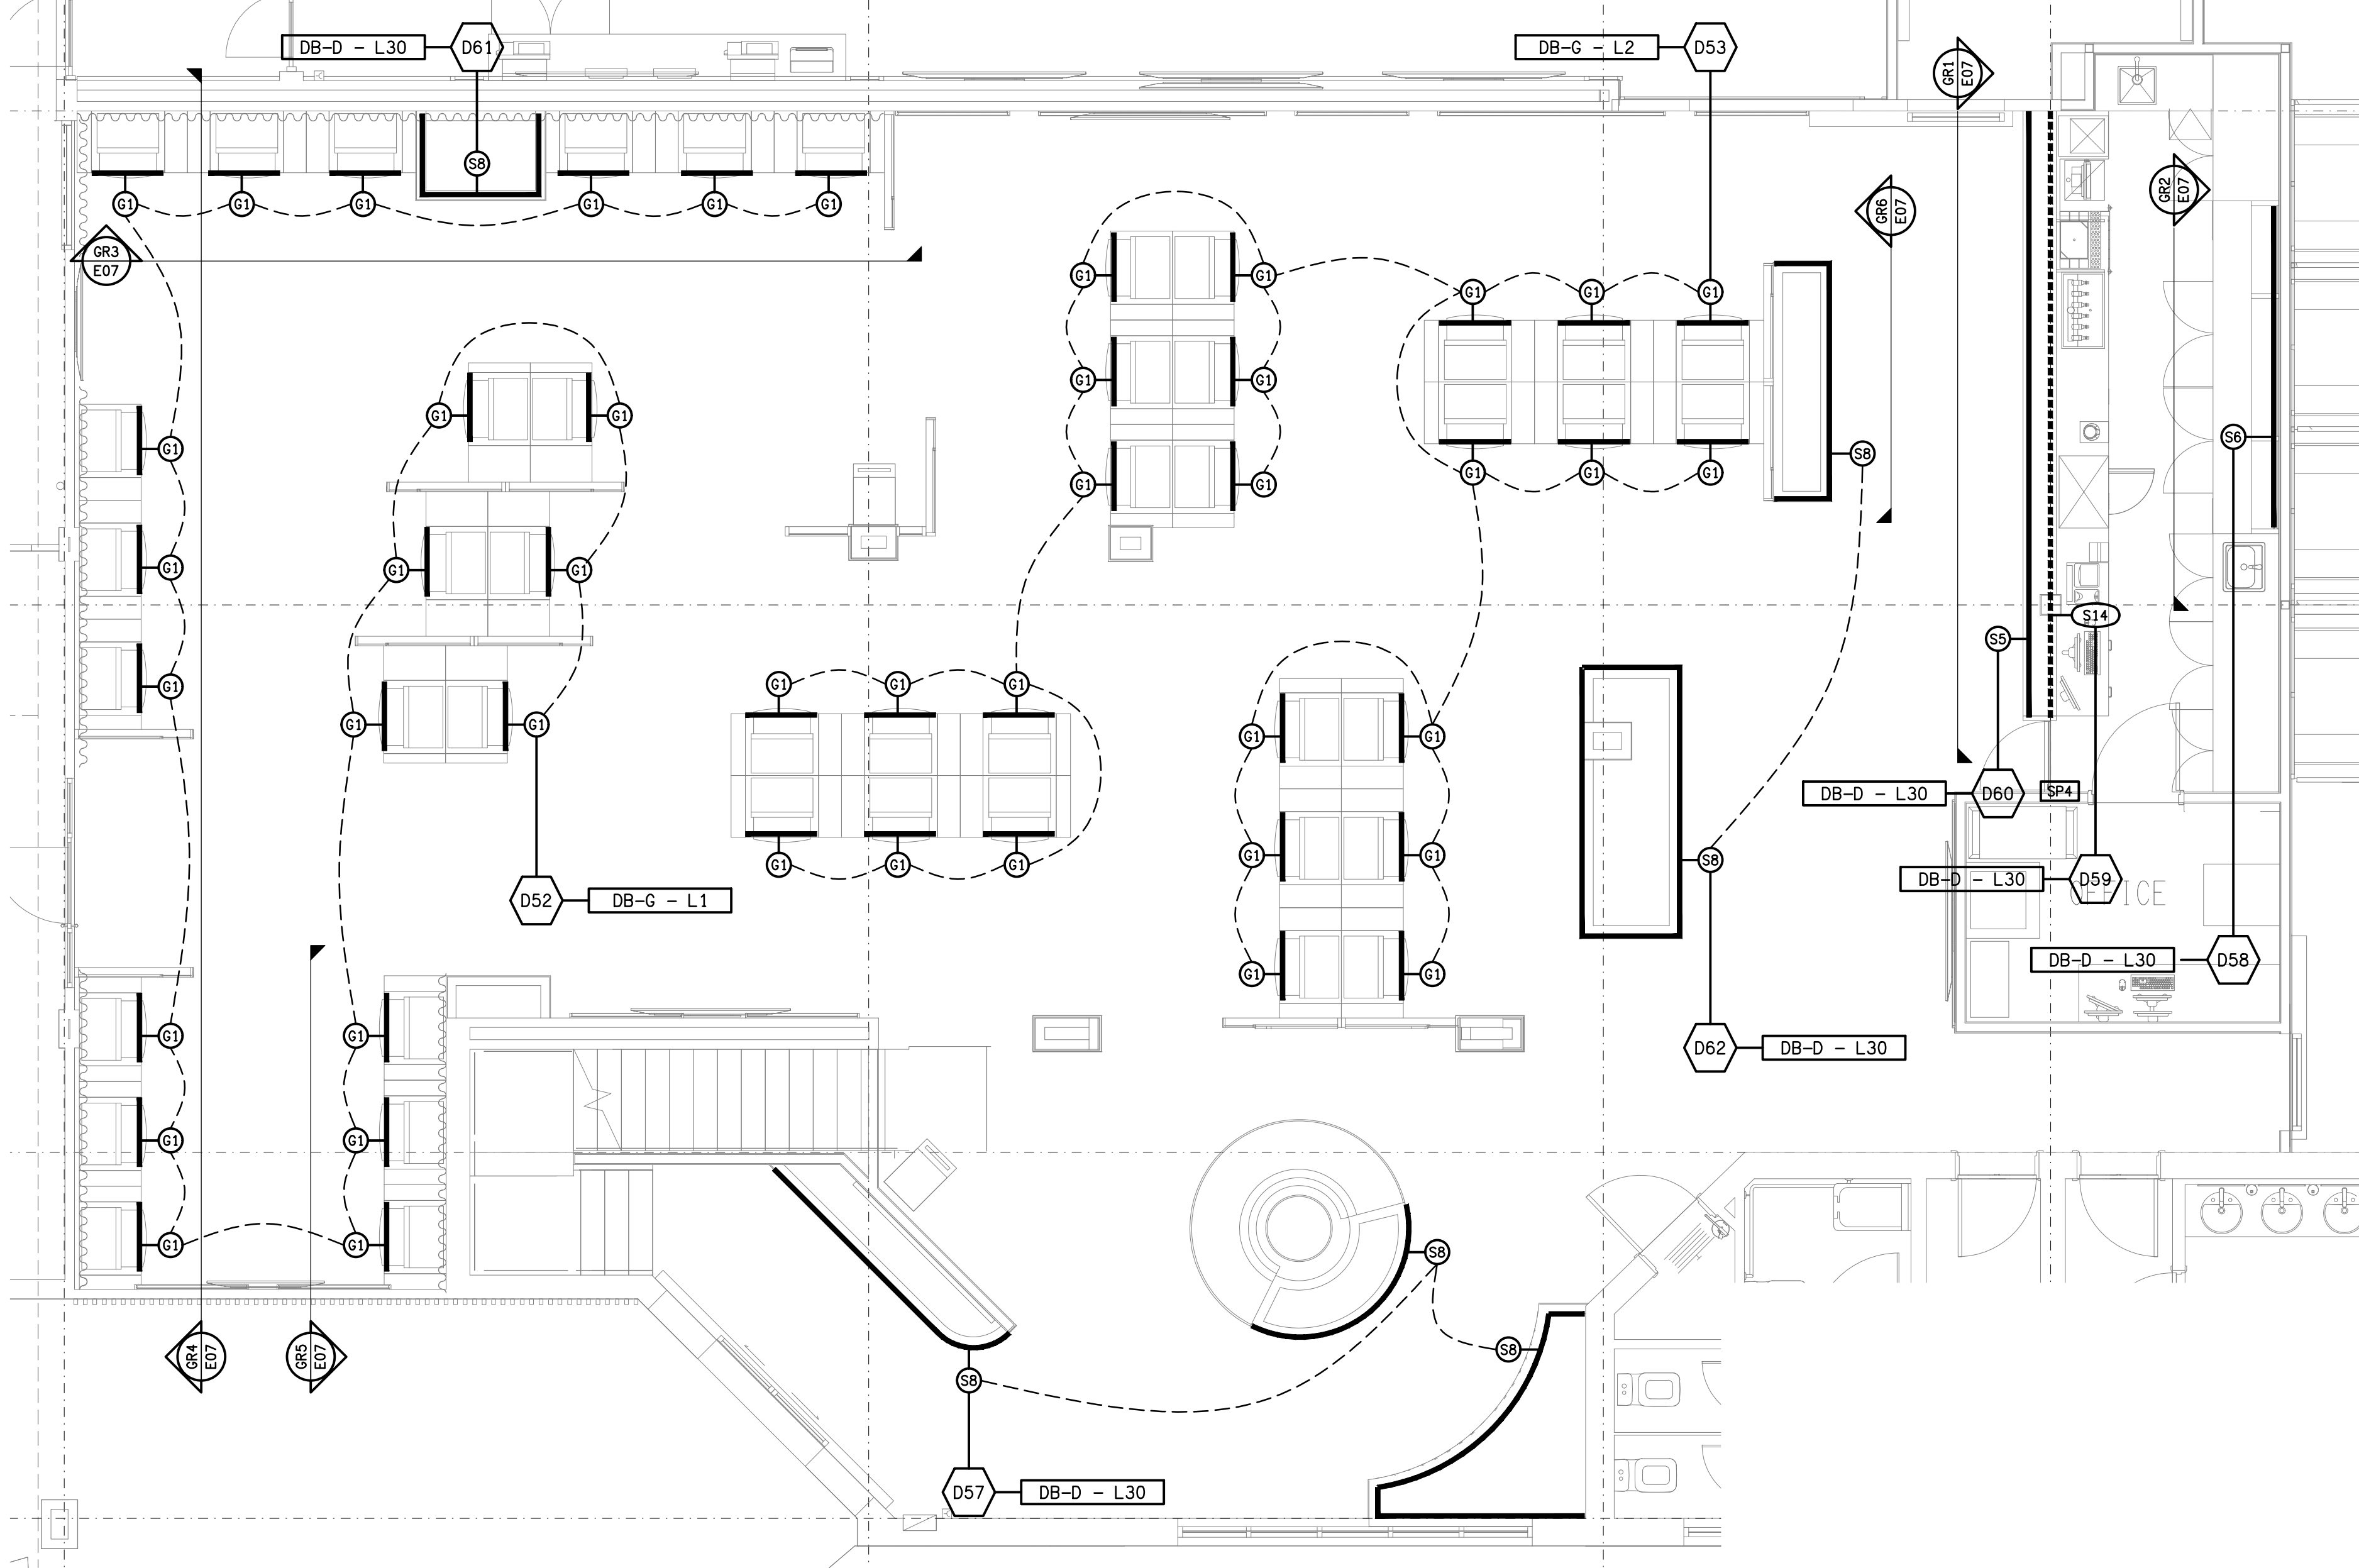


FLOOR PLAN
GAMING ROOM
SCALE 1: 50


NOTE:
THE LIGHTING CONTROL CHANNELS THAT CONTROL THE DB-G CIRCUITS ARE TO CONTAIN FACILITY IN DB-D TO ALLOW THE GAMING ELECTRICIAN TO CONNECT THE CIRCUITS TO THE CONTROLLERS IN DB-D.

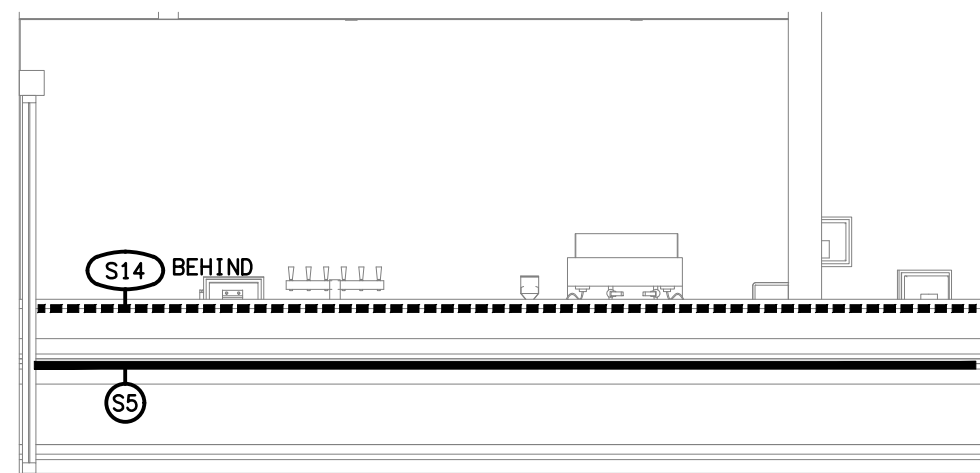


DETAIL GR1
GAMING BAR FRONT COUNTER
SCALE 1: 50

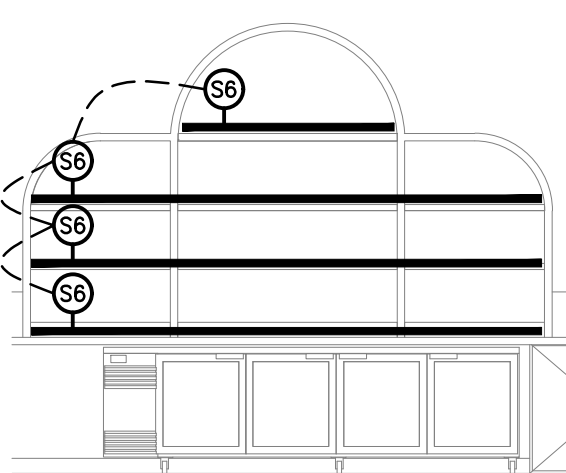


DETAIL GR2
GAMING BAR REAR WALL
SCALE 1: 50

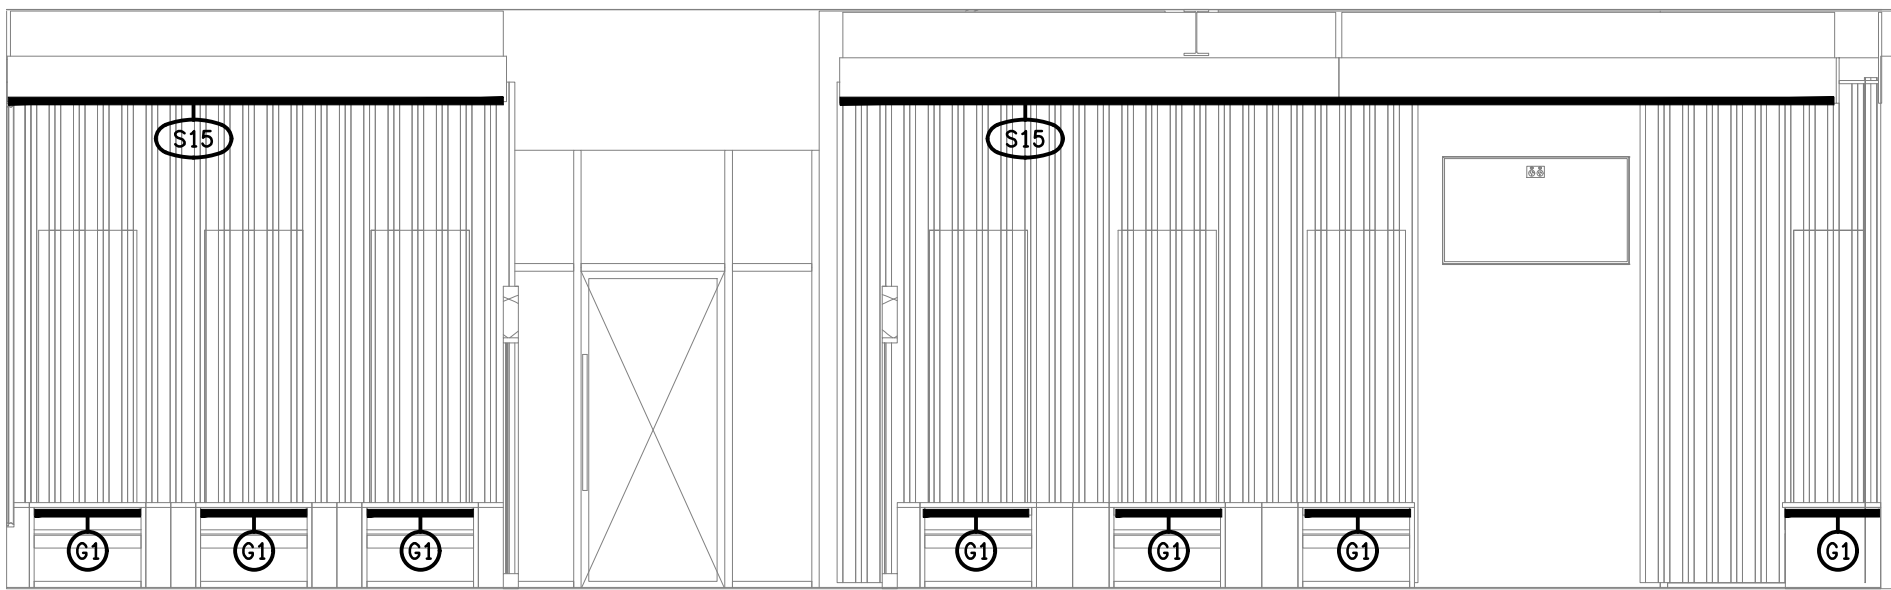


DETAIL GR4
GAMING BAR REAR WALL
SCALE 1: 50

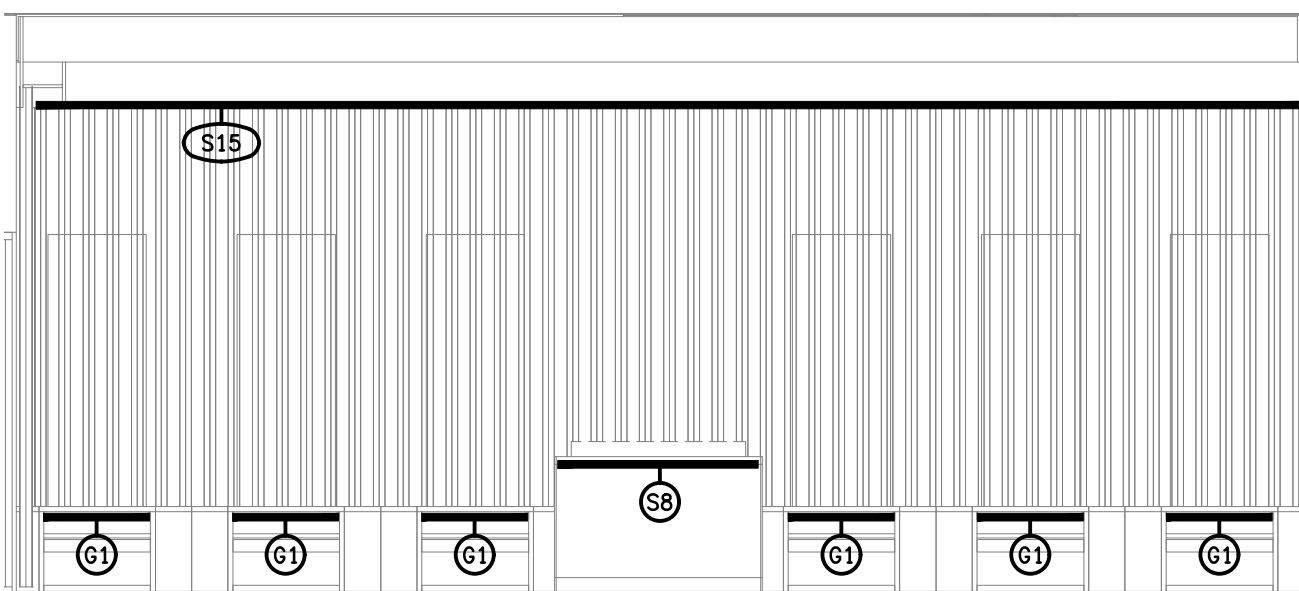

DETAIL GR3
GAMING BAR REAR WALL
SCALE 1: 50

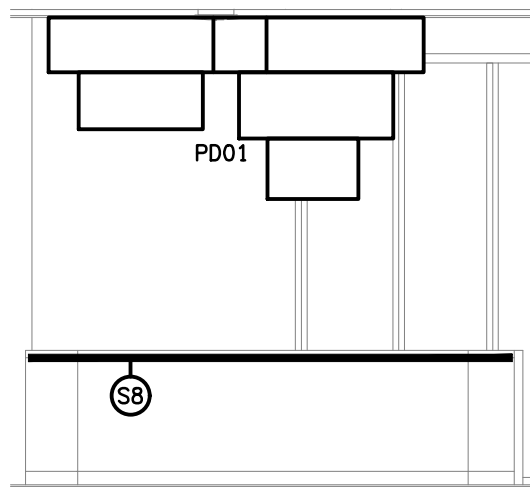

DETAIL GR6
GAMING BAR REAR WALL
SCALE 1: 50

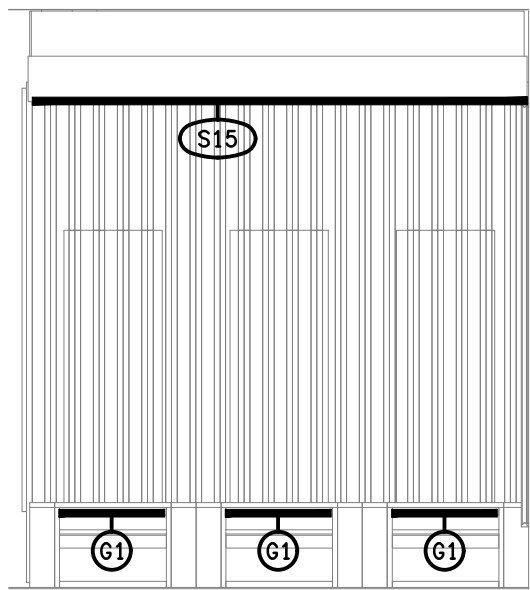

DETAIL GR5
GAMING BAR REAR WALL
SCALE 1: 50

THE COPYRIGHT OF THIS DRAWING REMAINS THE PROPERTY OF THE ELECTRICAL DESIGN GROUP.
USE FIGURED DIMENSIONS IN PREFERENCE TO SCALE.
ALL DIMENSIONS TO BE VERIFIED ONSITE.

E	CONSTRUCTION	14/01/2026
REV:	DESCRIPTION:	DATE:

ELECTRICAL DESIGN GROUP
ELECTRICAL BUILDING SERVICES CONSULTANTS

BRISBANE: P.O. Box 15 Sherwood Qld 4075
Phone: (07) 3278 4375
Email: brisbane@edg.net.au
Web: www.edg.net.au

ELECTRICAL DESIGN GROUP BRISBANE PTY LTD
ACN 092 710 793

TRADING AS:
ELECTRICAL DESIGN GROUP

PROJECT:

BENOWA TAVERN

SITE ADDRESS:
117 ASHMORE ROAD, BENOWA
GOLD COAST

SCALE: SHEET SIZE:

1:50 AT A1

DRAWING TITLE:

ELECTRICAL SERVICES
GAMING ROOM JOINERY
& WALL LIGHTING PLAN

PROJECT NO: DRAWING NO: REVISION:

C3600a E07 E