




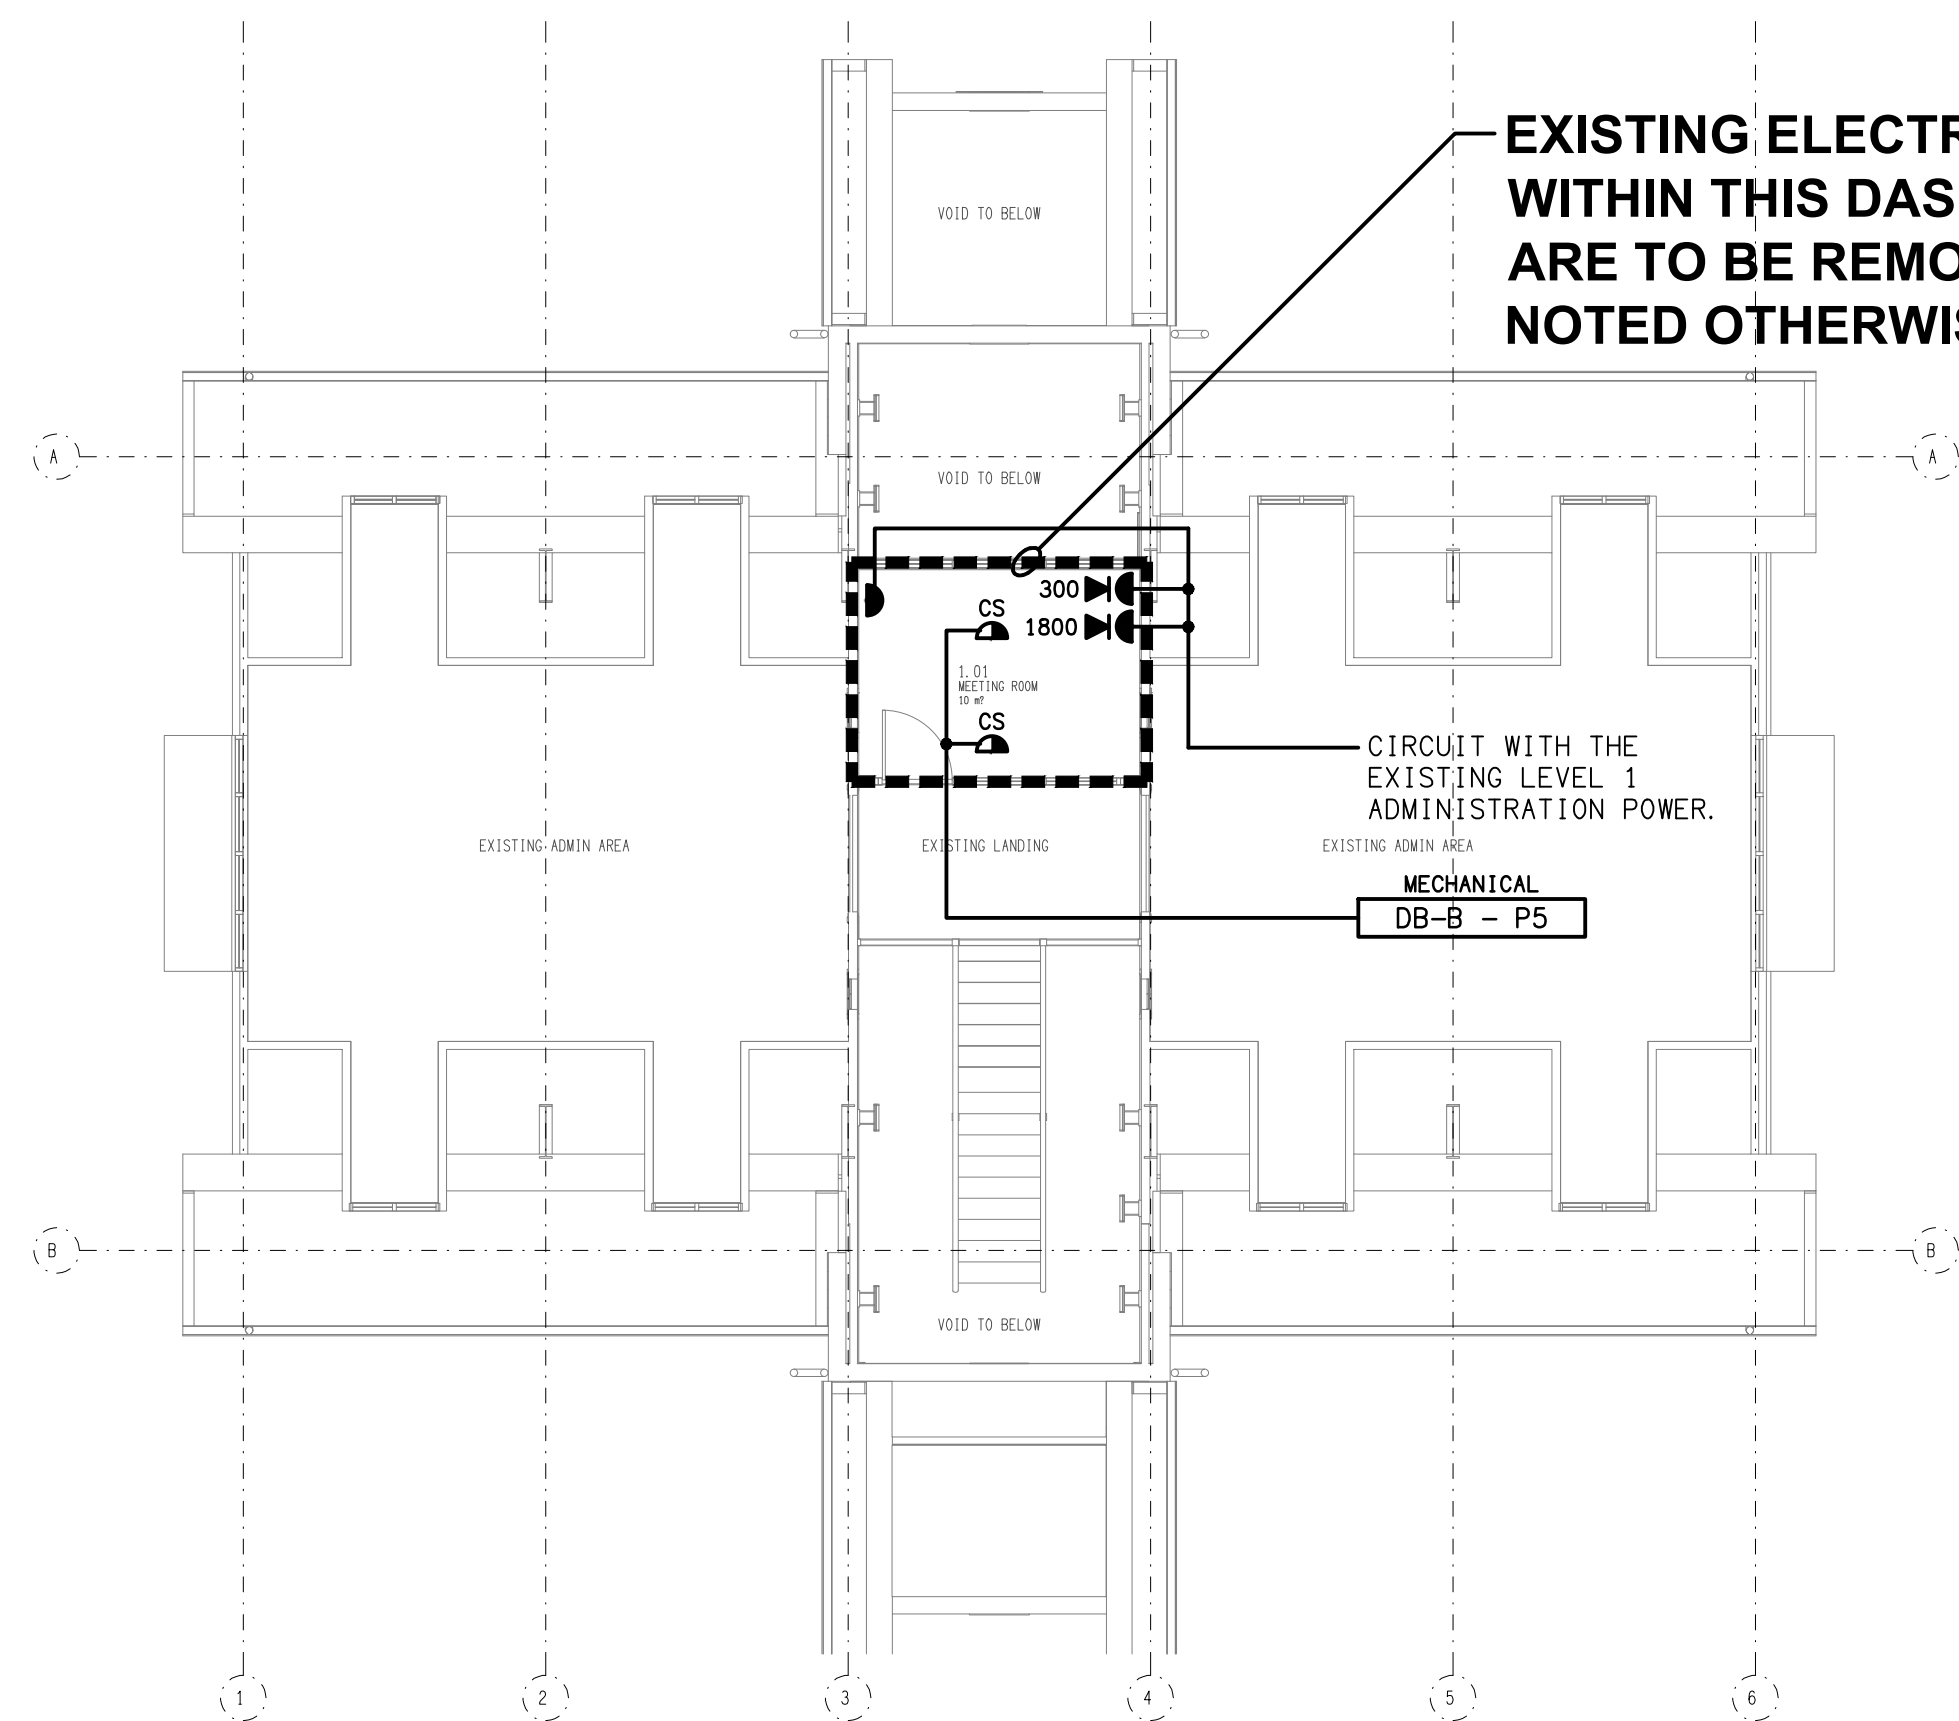


LEVEL 1
FLOOR PLAN
SCALE 1: 100

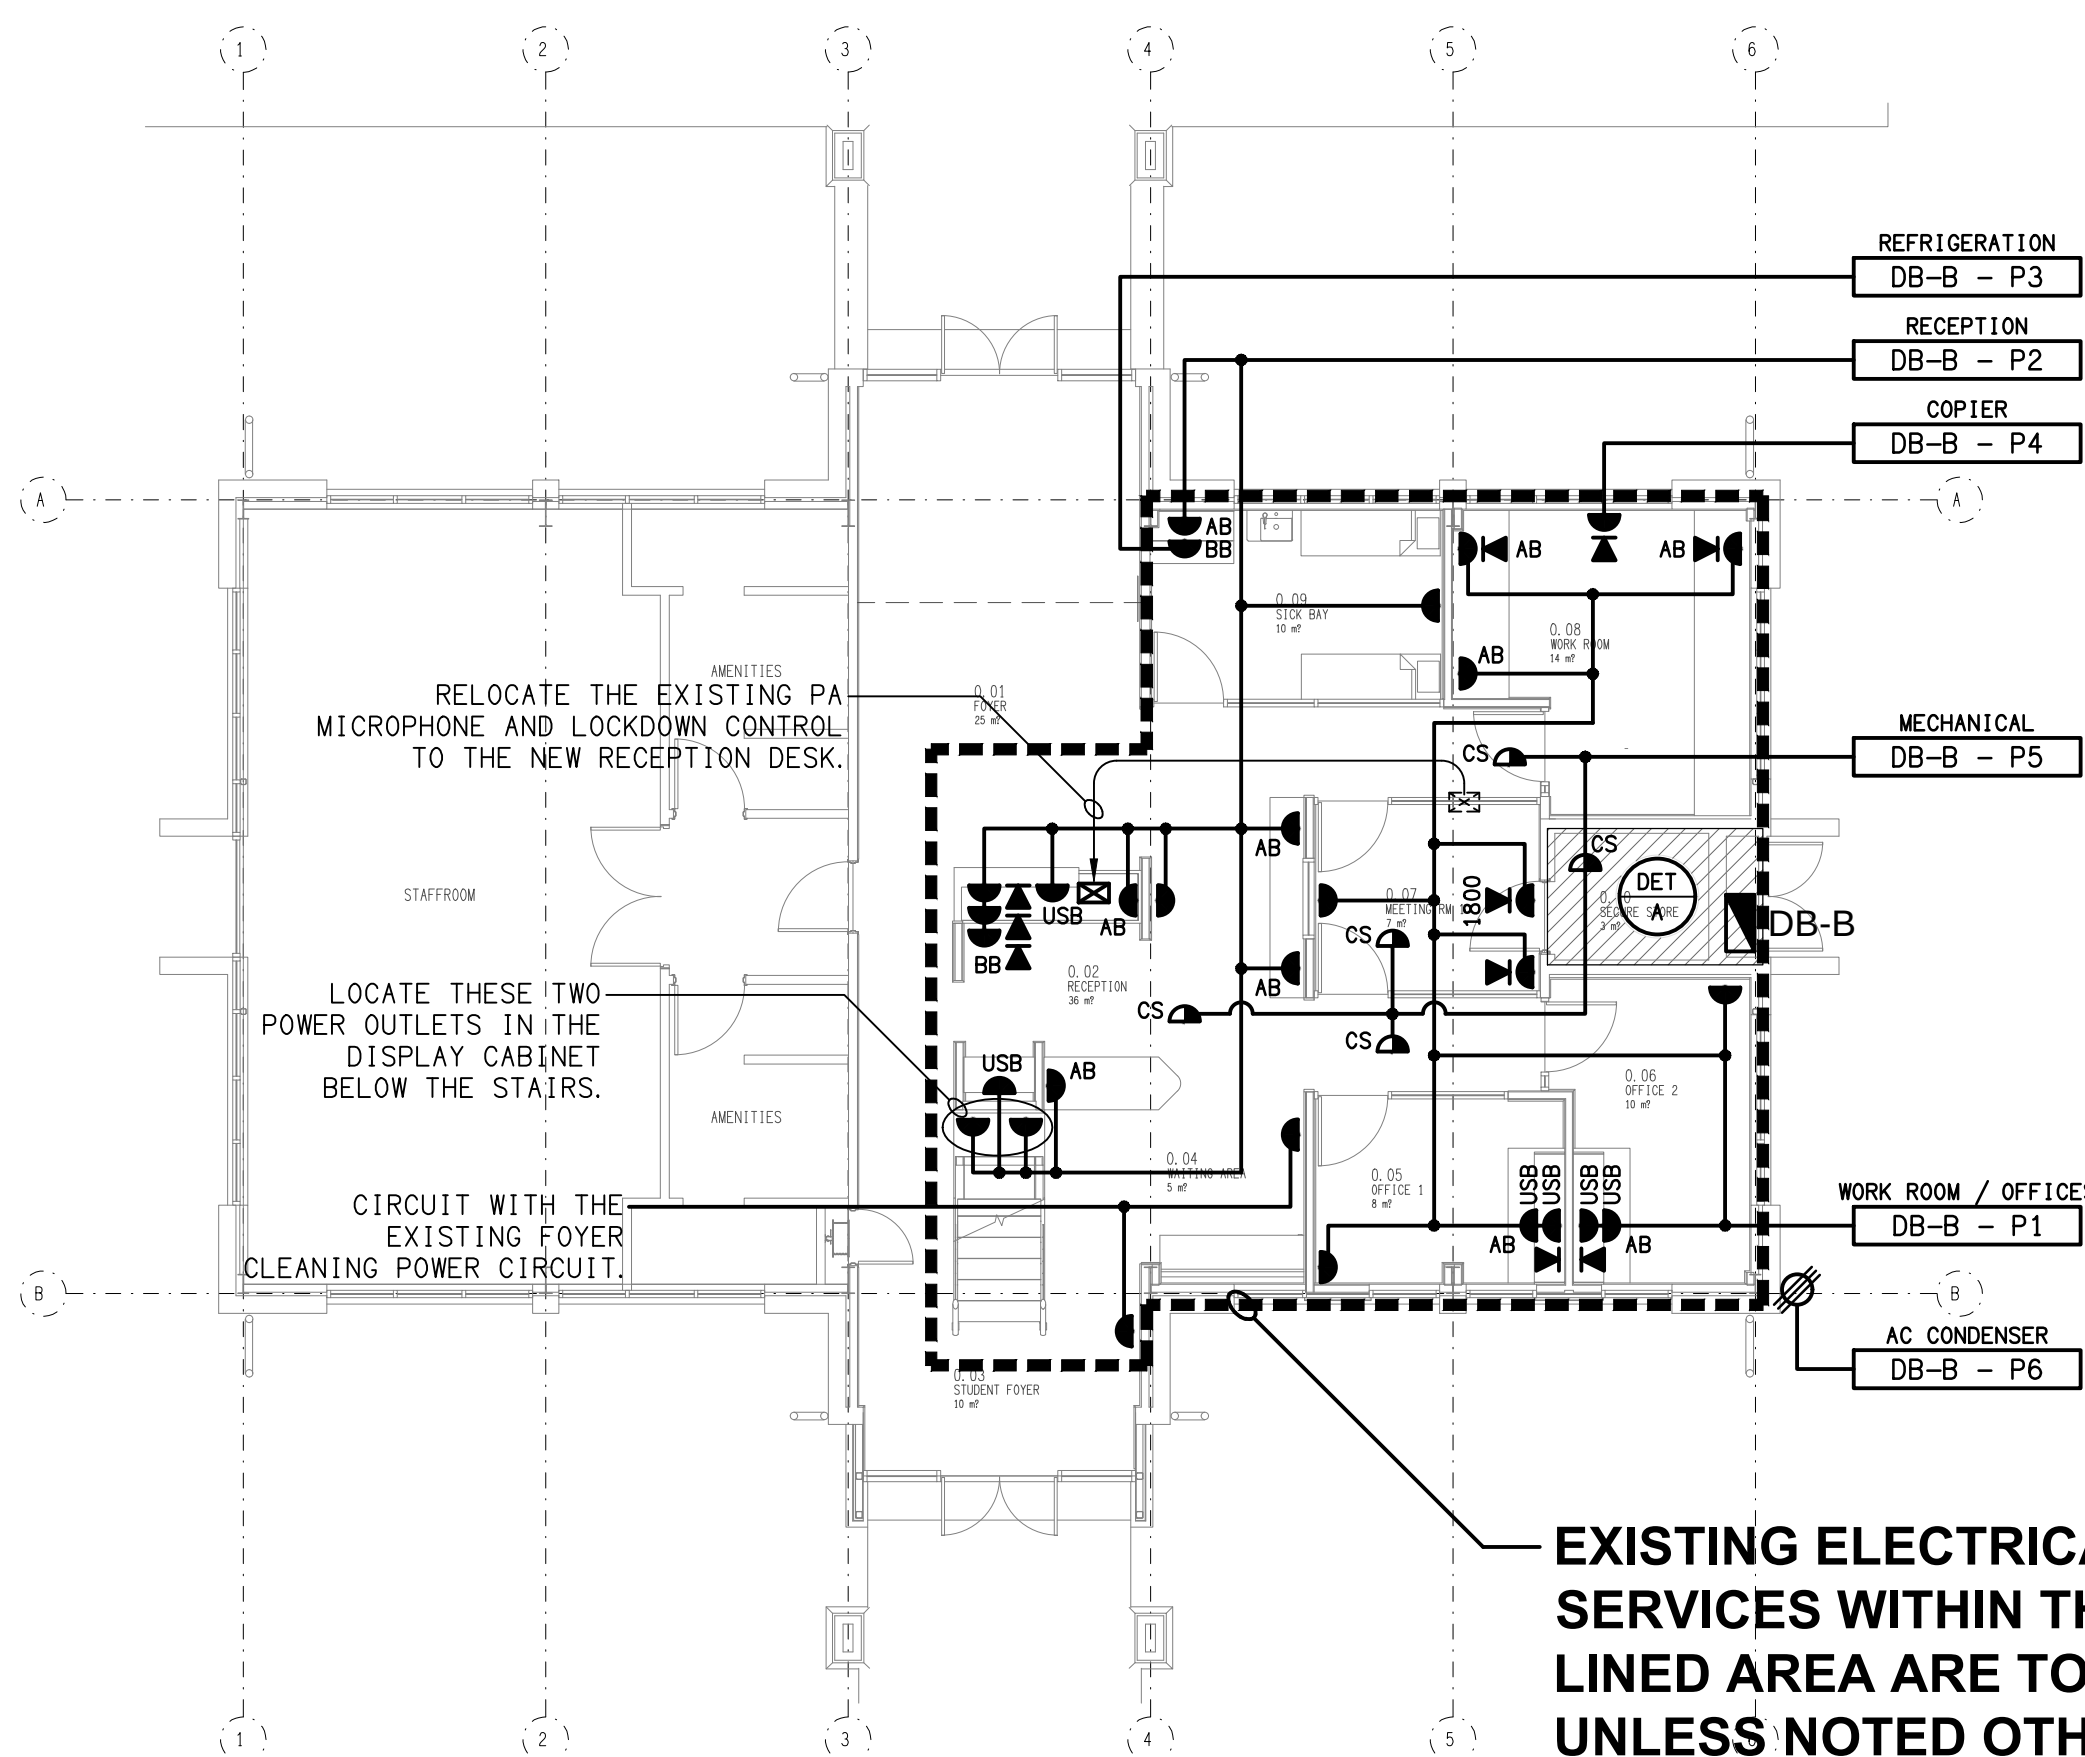


GROUND LEVEL
FLOOR PLAN
SCALE 1: 100

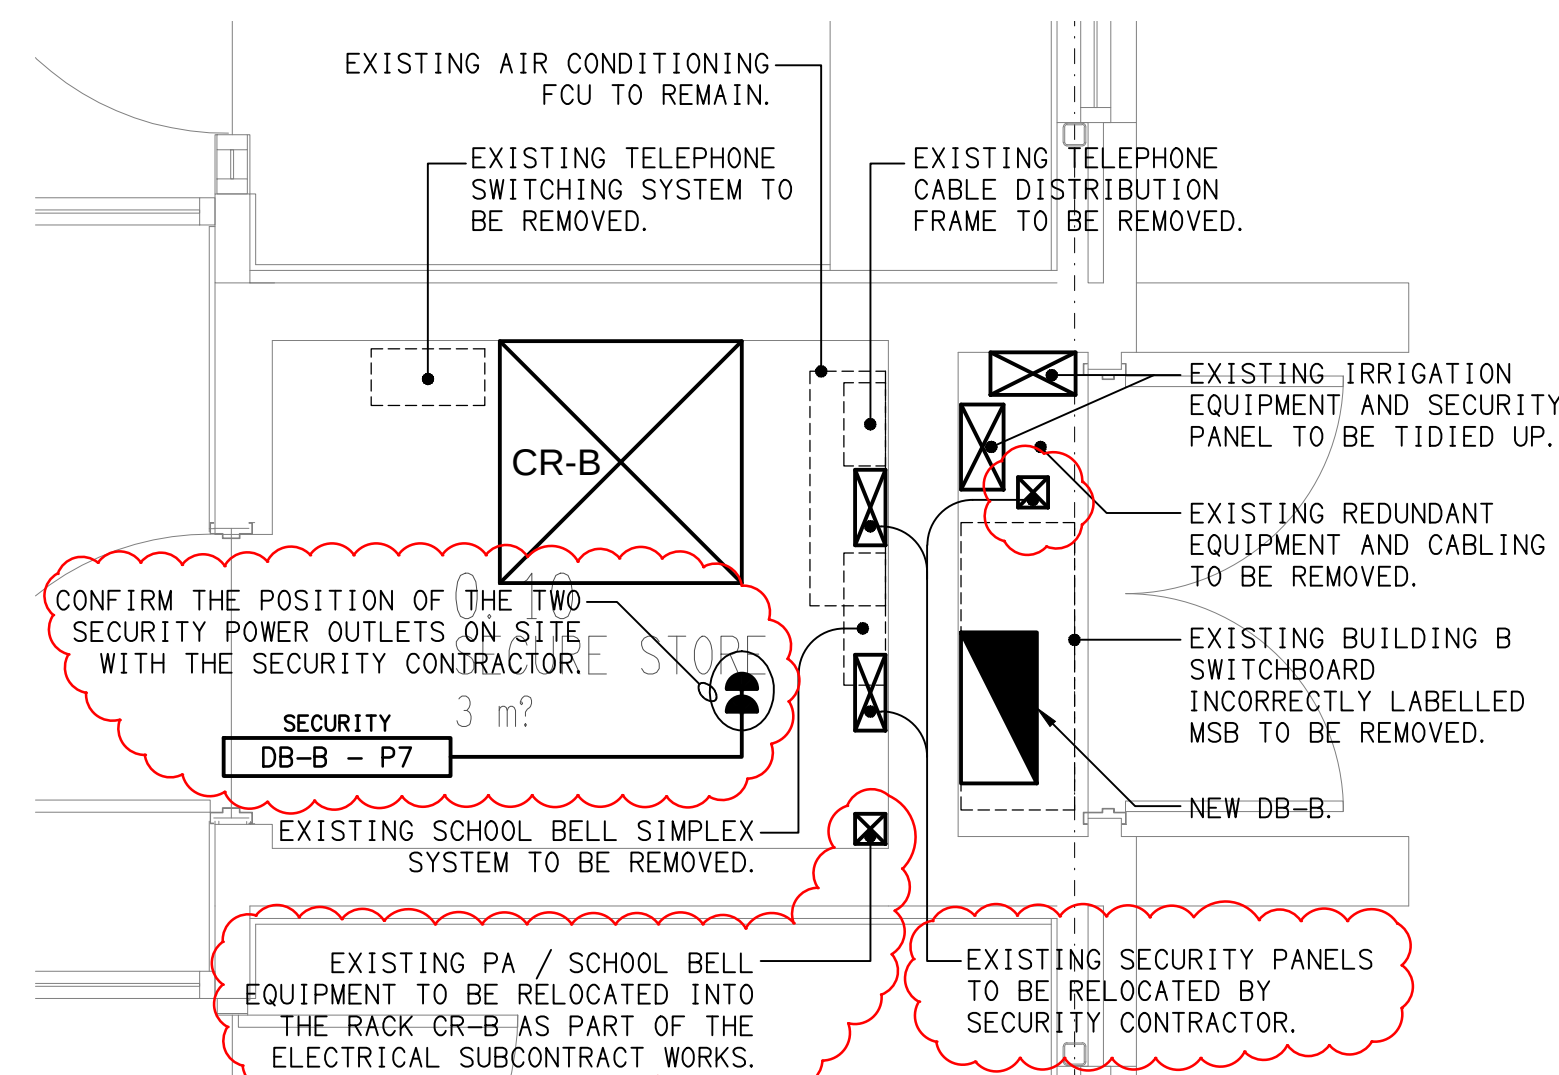

DETAIL A
SECURITY STORE RECONFIGURATION
SCALE 1: 25

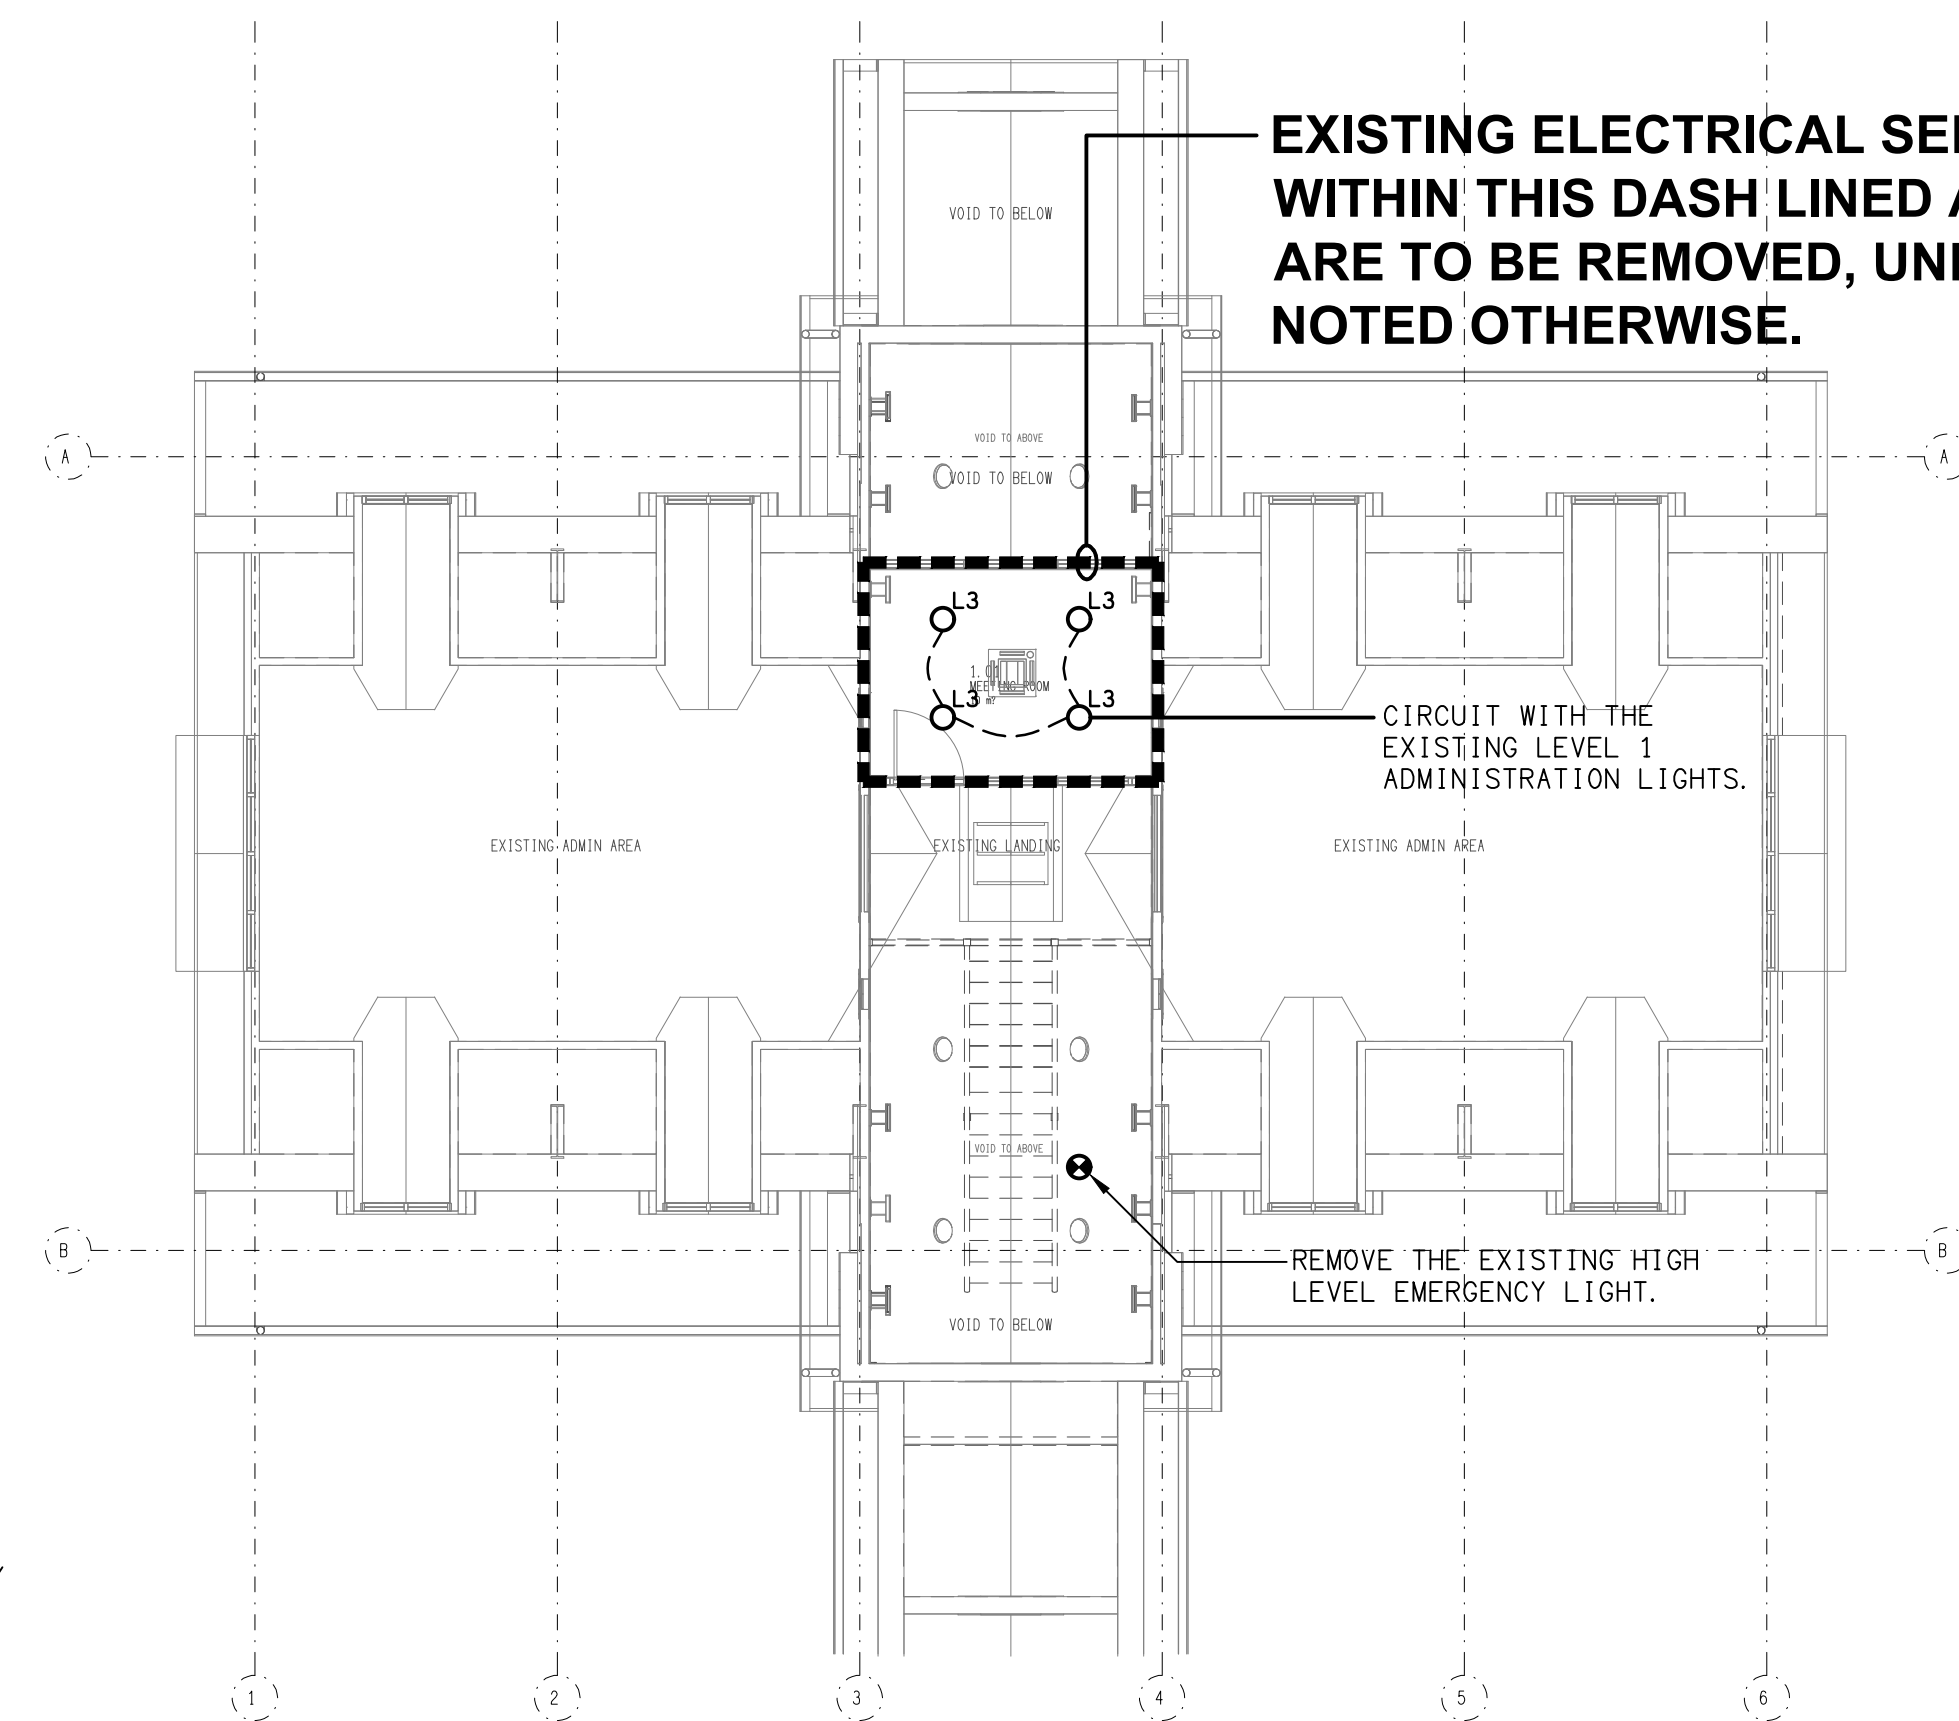

LEVEL 1
REFLECTED CEILING PLAN
SCALE 1: 100

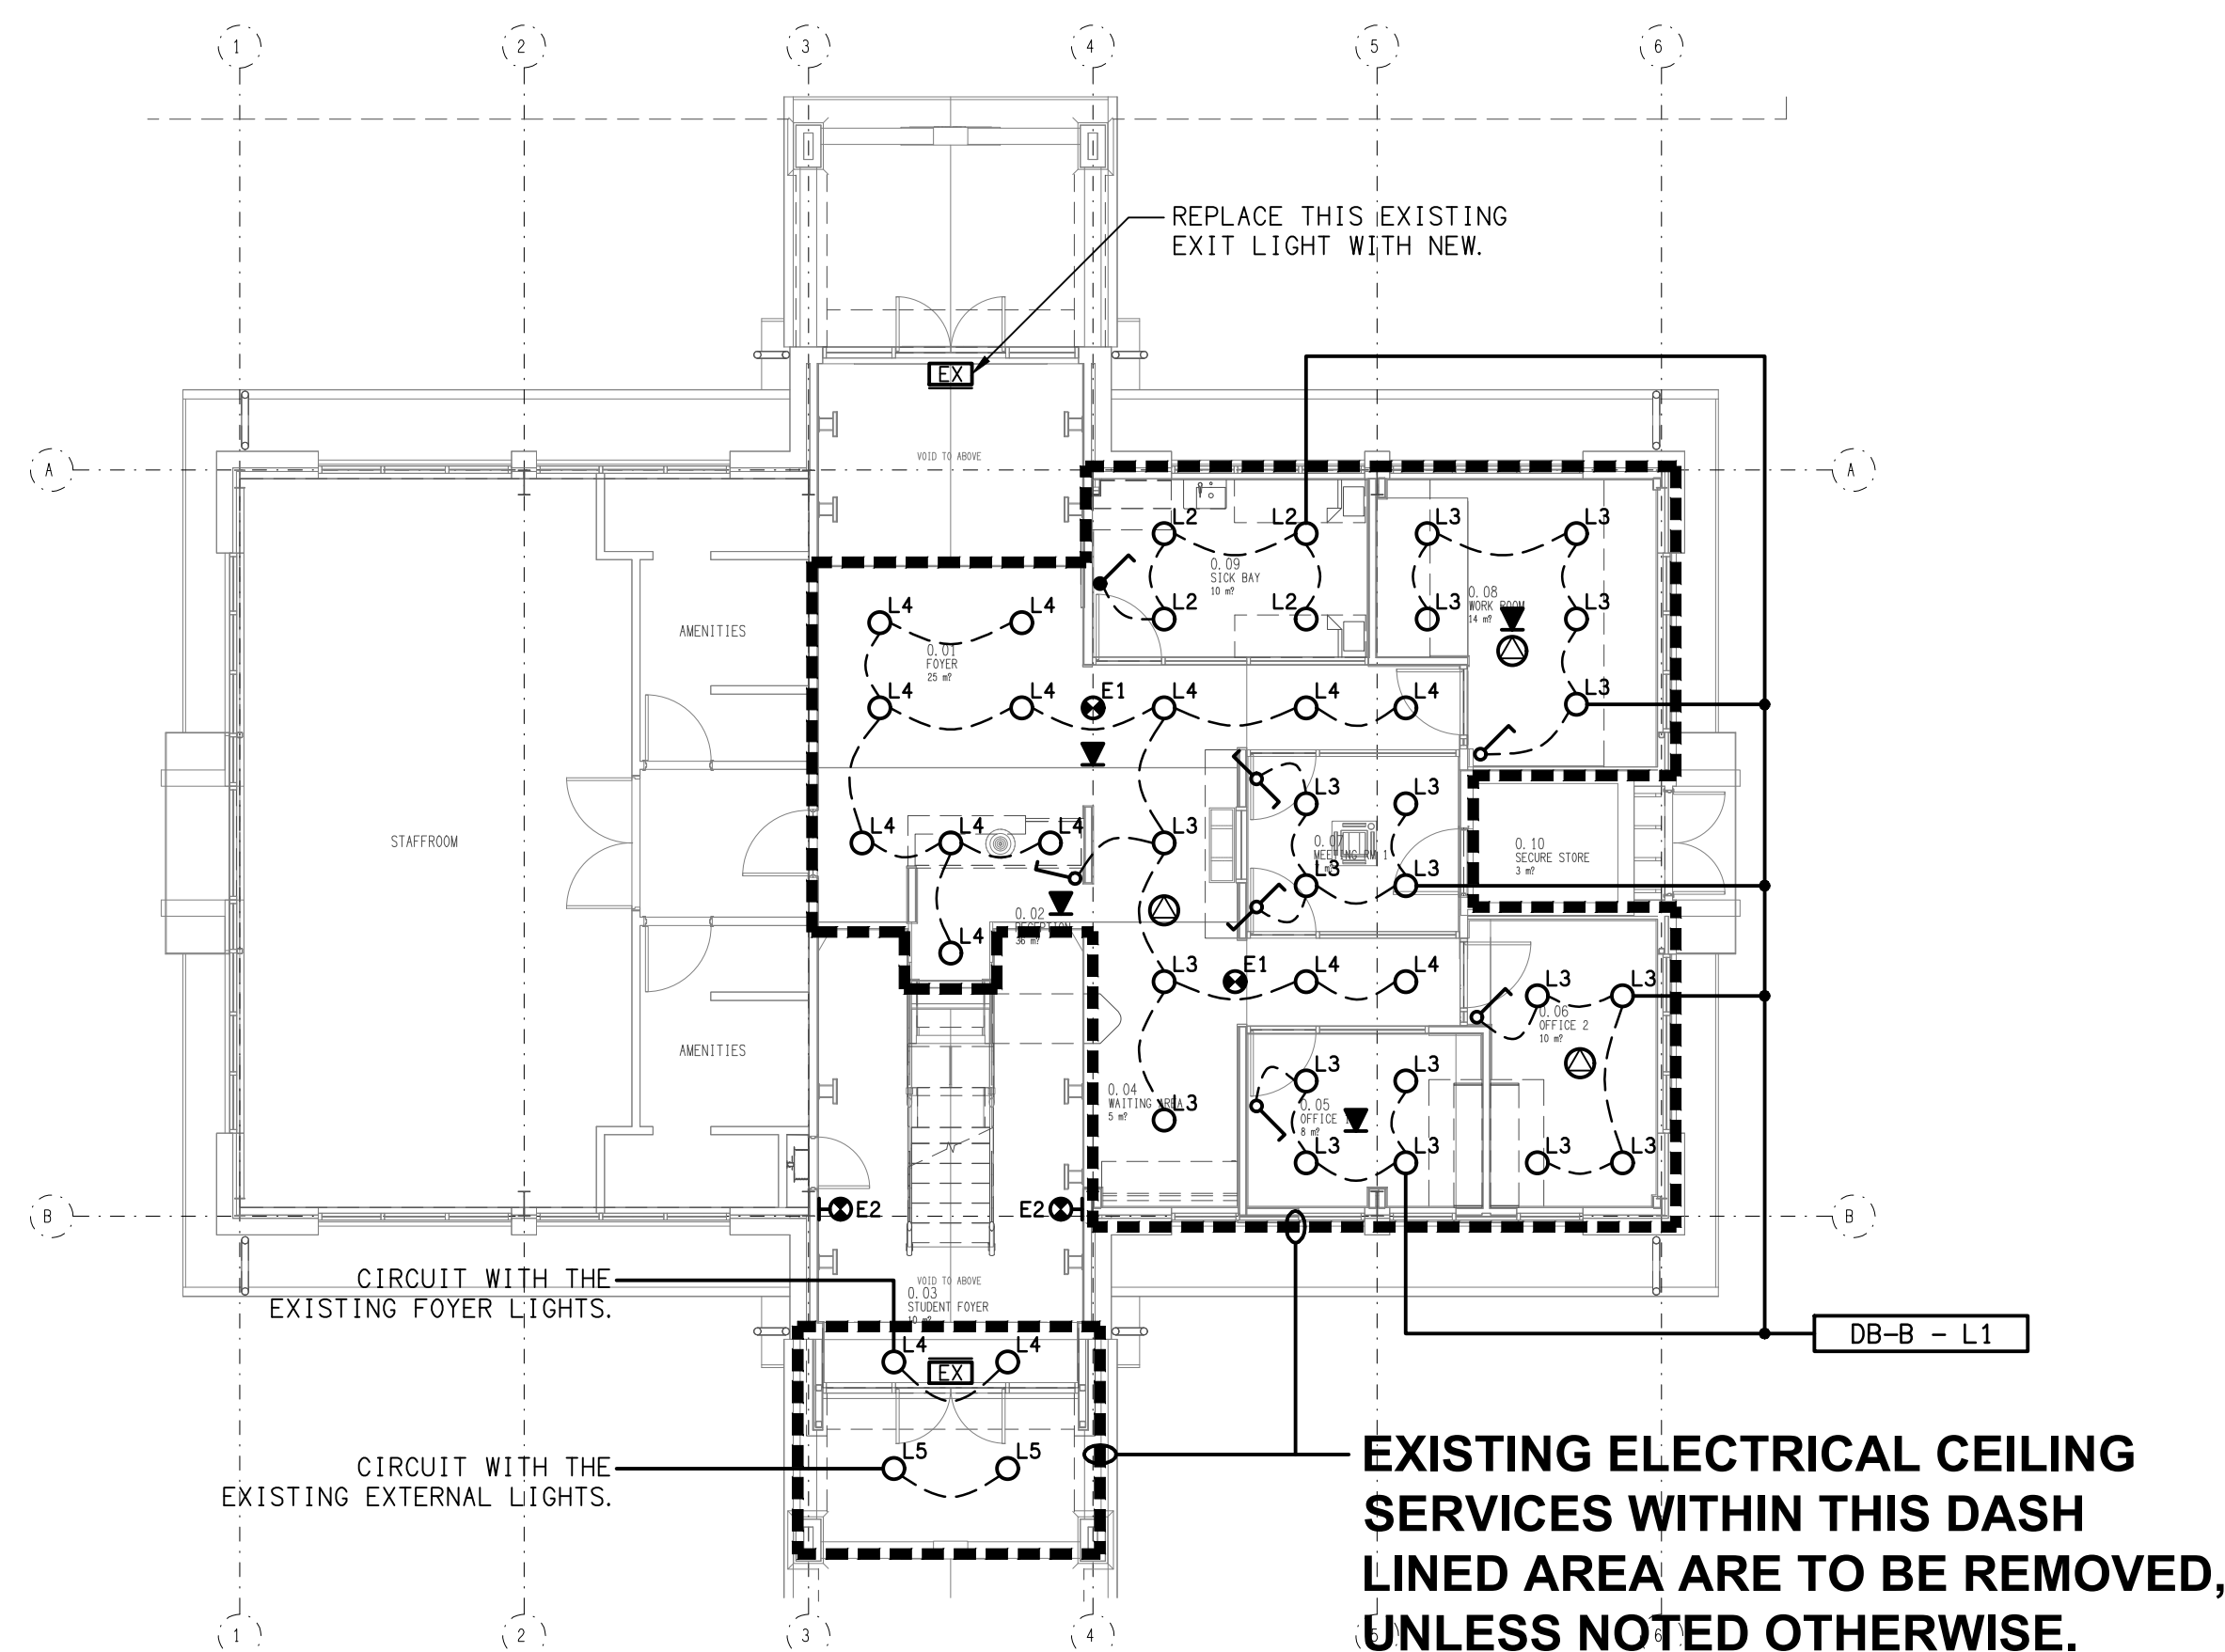

GROUND LEVEL
REFLECTED CEILING PLAN
SCALE 1: 100

ELECTRICAL DESIGN GROUP BRISBANE
PTY LTD
ACN 092 710 793
TRADING AS:
ELECTRICAL DESIGN GROUP

THE COPYRIGHT OF THIS DRAWING
REMAINS THE PROPERTY OF THE
ELECTRICAL DESIGN GROUP.
USE FIGURED DIMENSIONS
IN PREFERENCE TO SCALE.
ALL DIMENSIONS TO BE
VERIFIED ONSITE.

ELECTRICAL DESIGN GROUP
ELECTRICAL BUILDING SERVICES CONSULTANTS
BRISBANE GOLD COAST

P.O. Box 15, Sherwood Q. 4075
Phone: (07) 3278 4375
Email: brisbane@edg.net.au
Web: www.edg.net.au

PROJECT:
ST JOHNS ANGLICAN COLLEGE,
FOREST LAKE - JUNIOR CAMPUS
ADMINISTRATION UPGRADE
ALPINE PLACE, FOREST LAKE, QUEENSLAND

D	CONSTRUCTION	01/12/2025
REV:	DESCRIPTION:	DATE:

DRAWING:
ELECTRICAL SERVICES
GROUND & LEVEL 1 PLANS

SCALE:
1:100

AT A1

PROJECT NO:
C3613a

DRAWING NO:
E02

REVISION:
D