



DETAIL A
GAMING ROOM REAR WALL ELEVATION
SCALE 1: 50

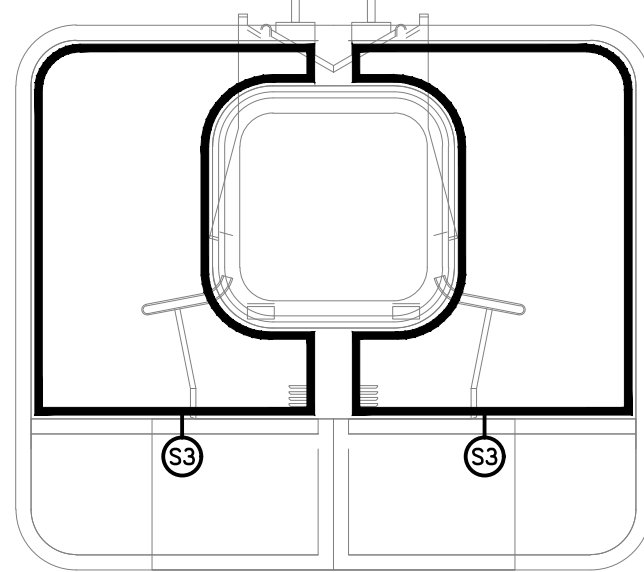

DETAIL B
TYPICAL GAMING SCREEN TYPE S3
SCALE 1: 50

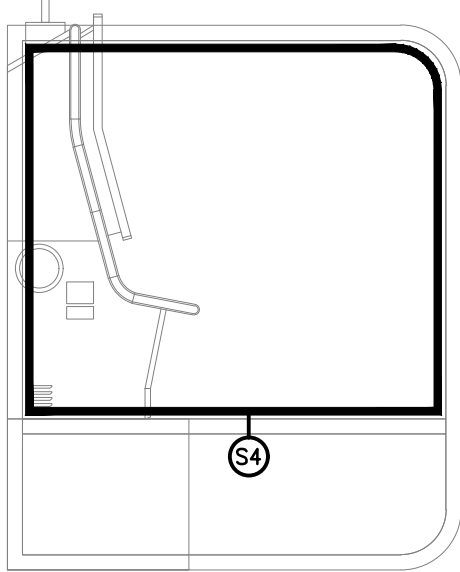


DETAIL C
TYPICAL GAMING SCREEN TYPE S4
SCALE 1: 50


THE COPYRIGHT OF THIS DRAWING REMAINS THE PROPERTY OF THE ELECTRICAL DESIGN GROUP.

USE FIGURED DIMENSIONS IN PREFERENCE TO SCALE.

ALL DIMENSIONS TO BE VERIFIED ONSITE.

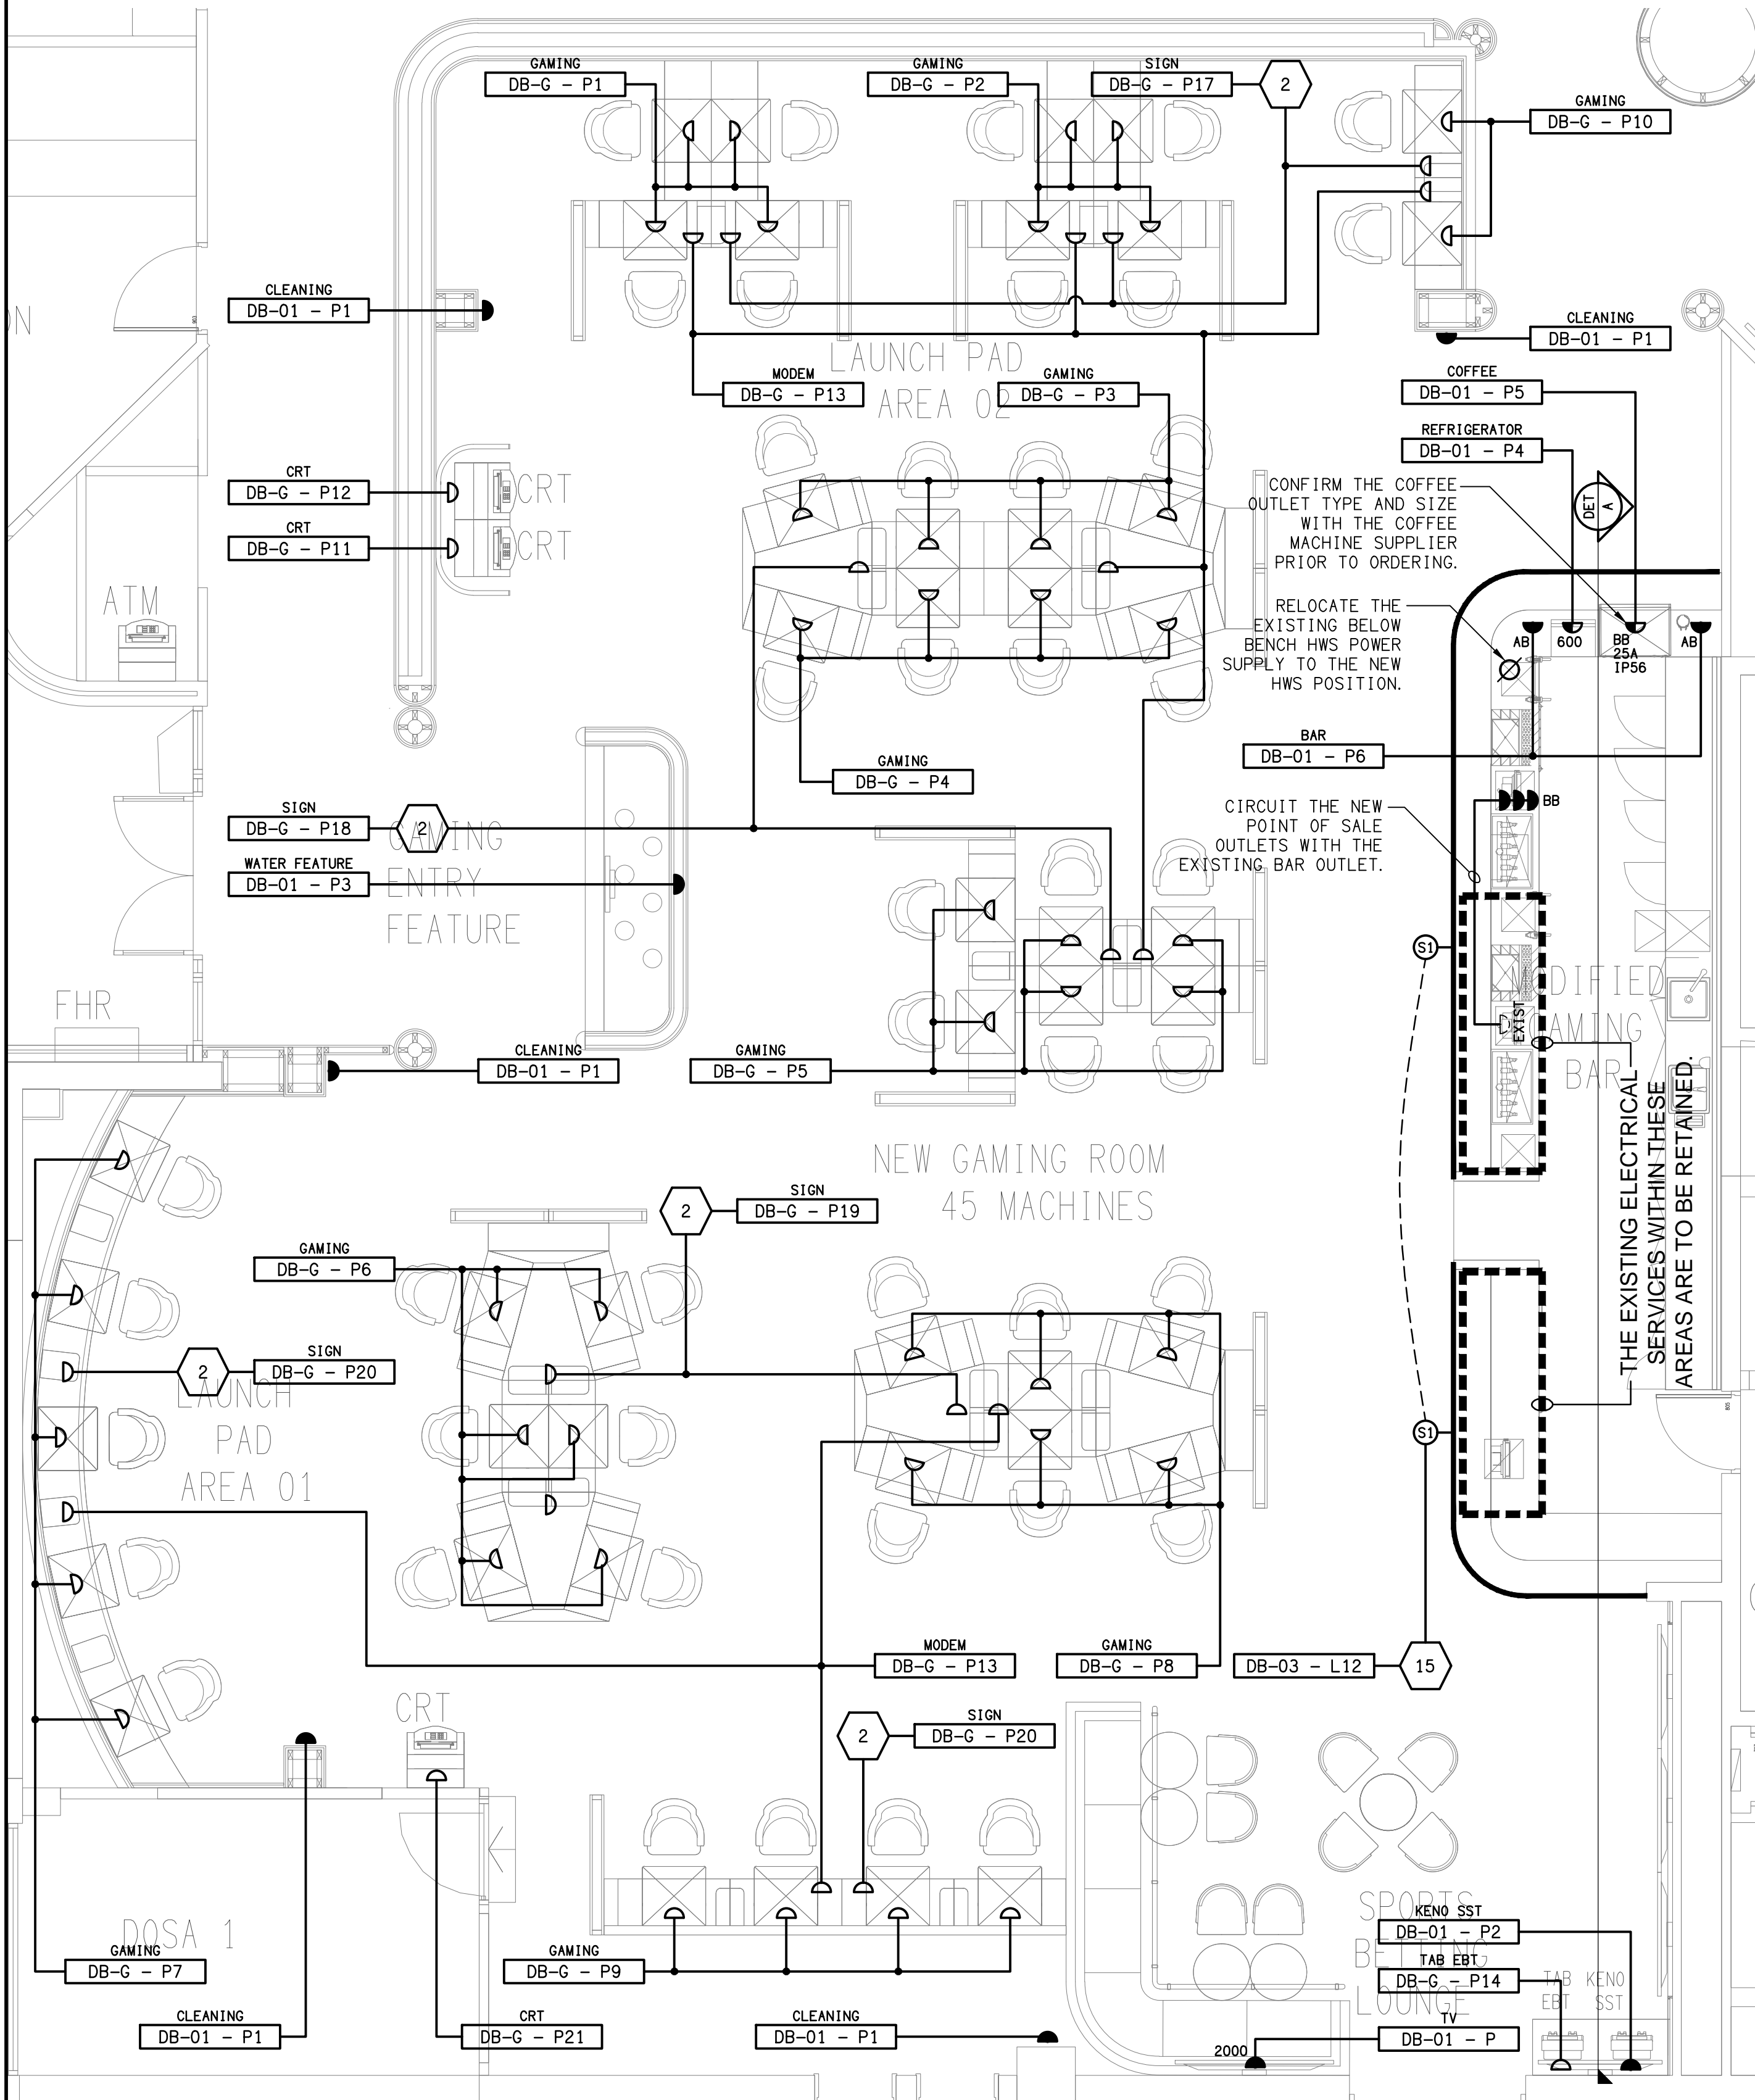

FLOOR PLAN
GAMING ROOM LAYOUT
SCALE 1: 50

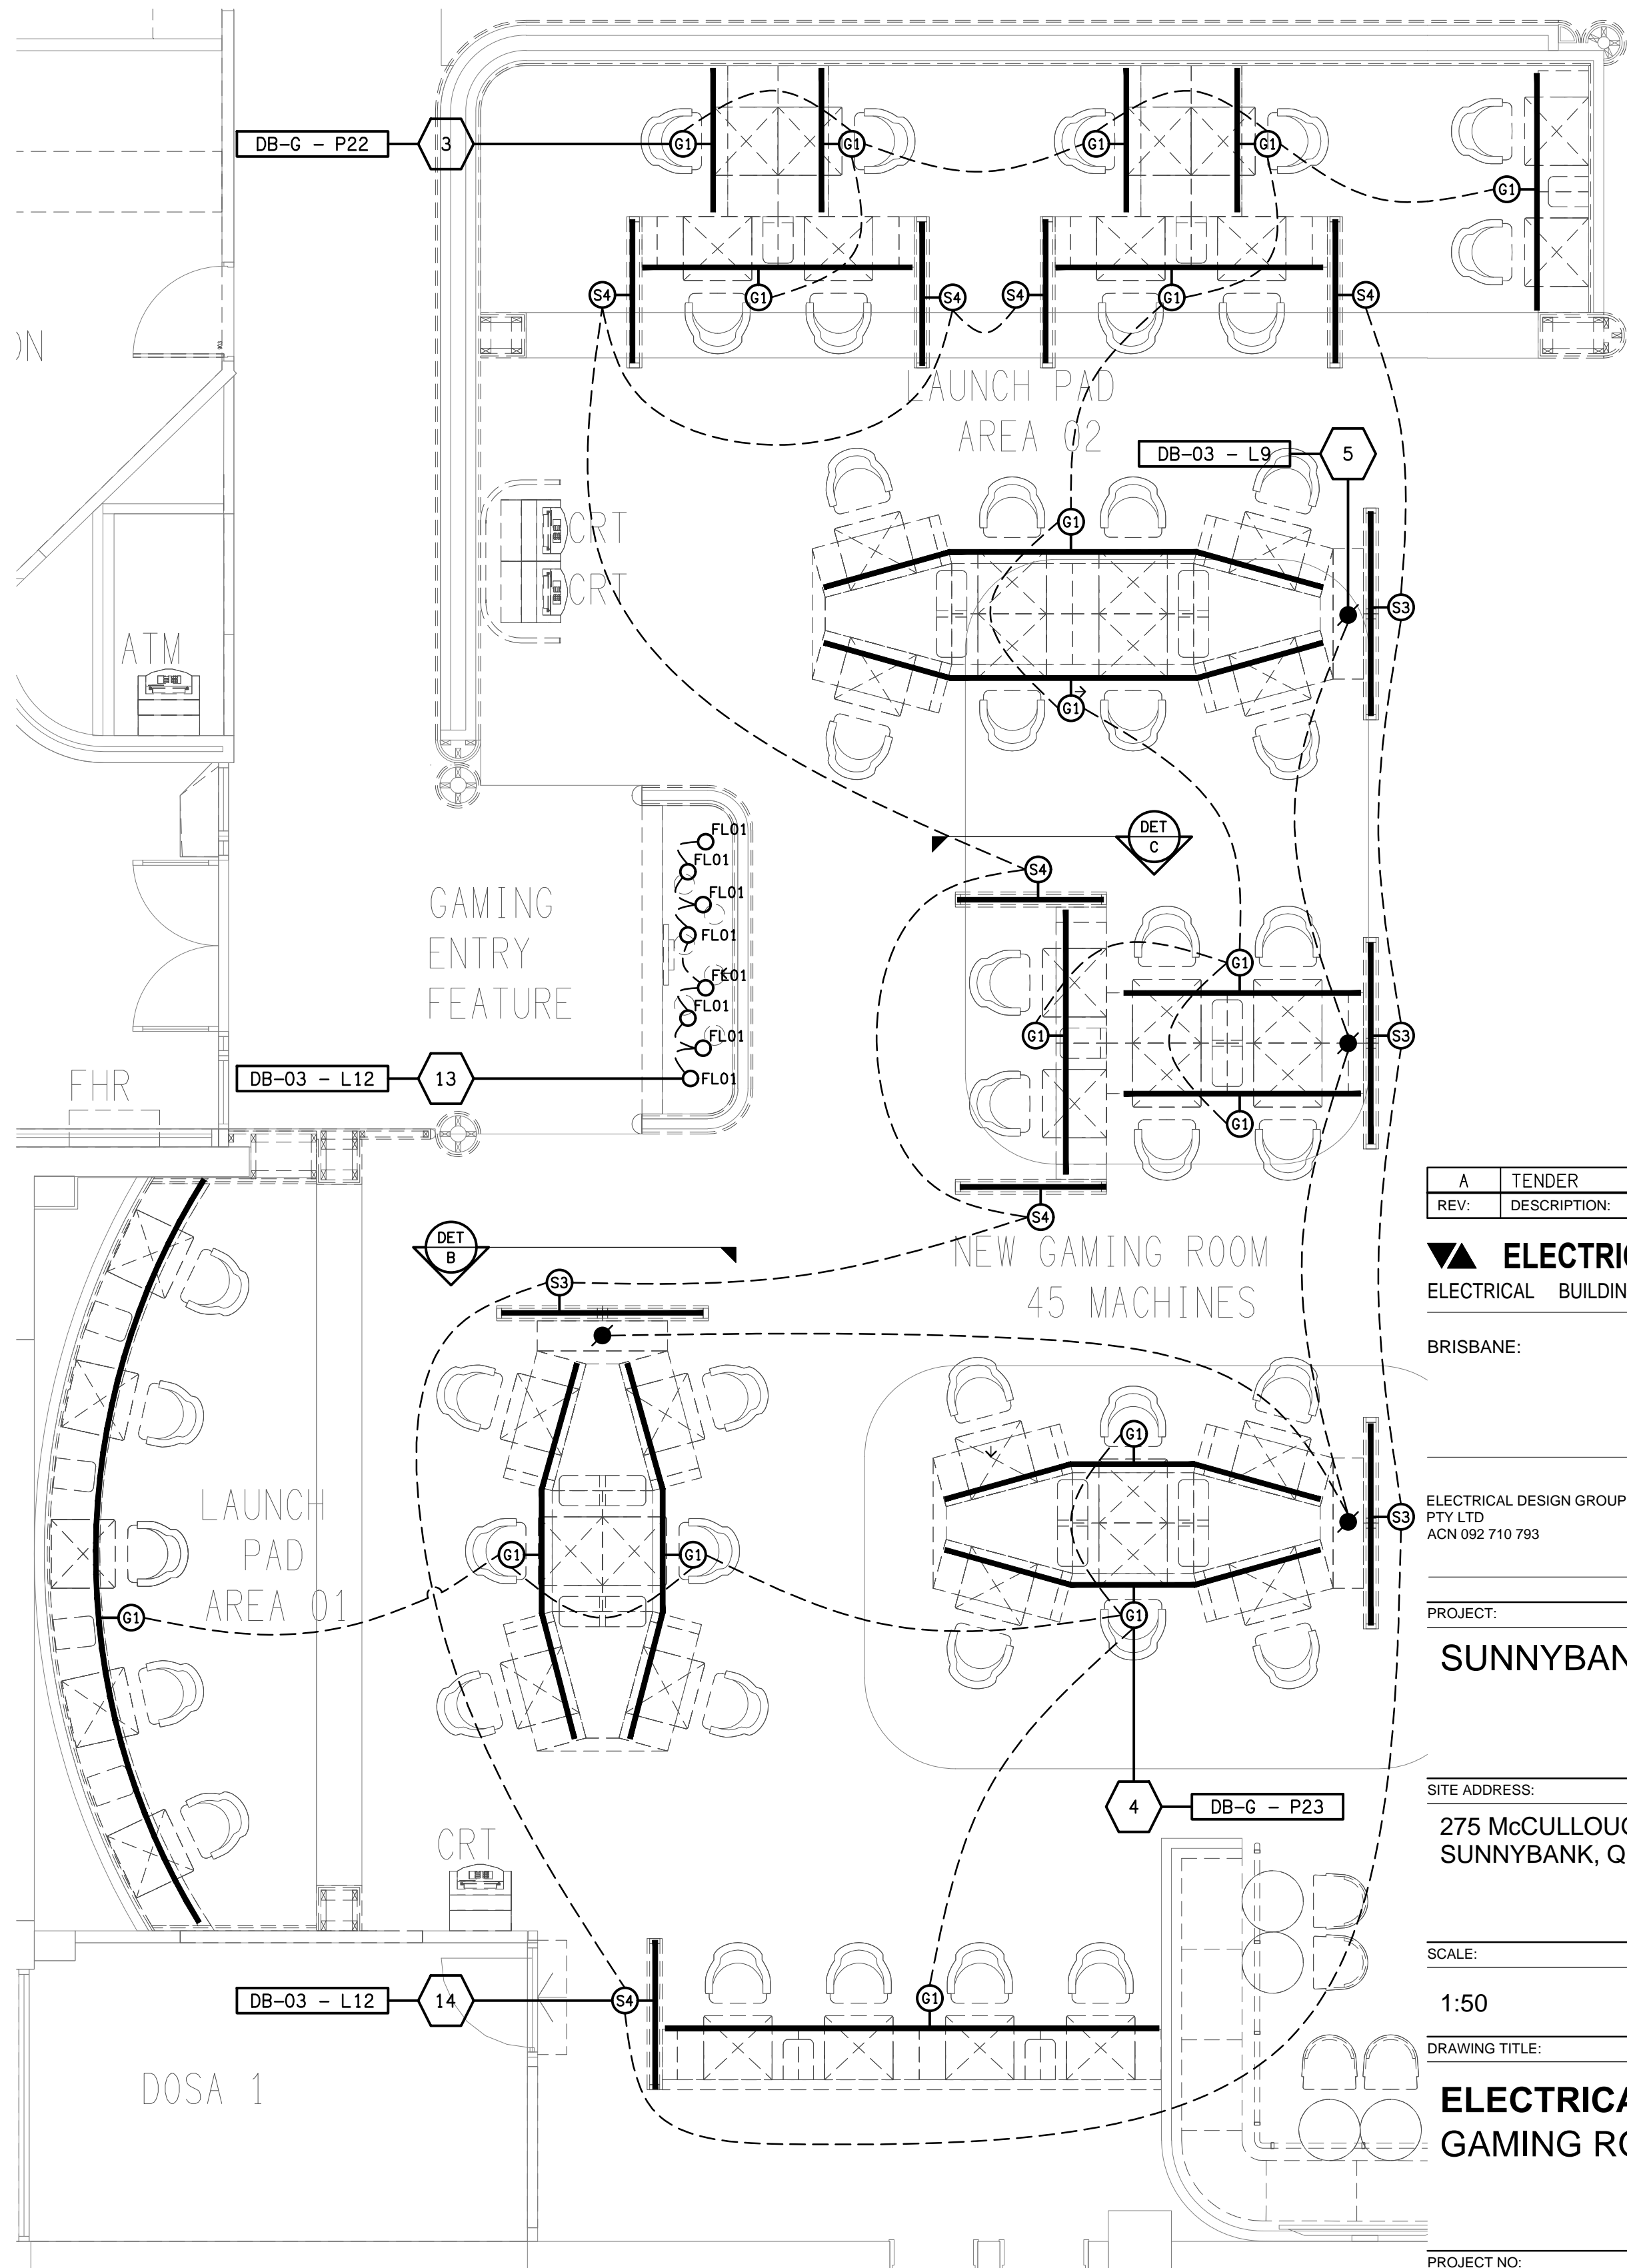

LIGHTING PLAN
GAMING ROOM LAYOUT
SCALE 1: 50

A	TENDER	10/10/2025
REV.	DESCRIPTION:	DATE:

ELECTRICAL DESIGN GROUP
ELECTRICAL BUILDING SERVICES CONSULTANTS

BRISBANE: P.O. Box 15 Sherwood Qld 4075
Phone: (07) 3278 4375
Email: brisbane@edg.net.au
Web: www.edg.net.au

ELECTRICAL DESIGN GROUP BRISBANE PTY LTD
ACN 092 710 793

PROJECT: **SUNNYBANK HOTEL**

SITE ADDRESS:
**275 McCULLOUGH STREET,
SUNNYBANK, QUEENSLAND**

SCALE: **1:50** SHEET SIZE: **A1**

DRAWING TITLE:
**ELECTRICAL SERVICES
GAMING ROOM PLANS**

PROJECT NO: DRAWING NO: REVISION:

C3628a E04 A