


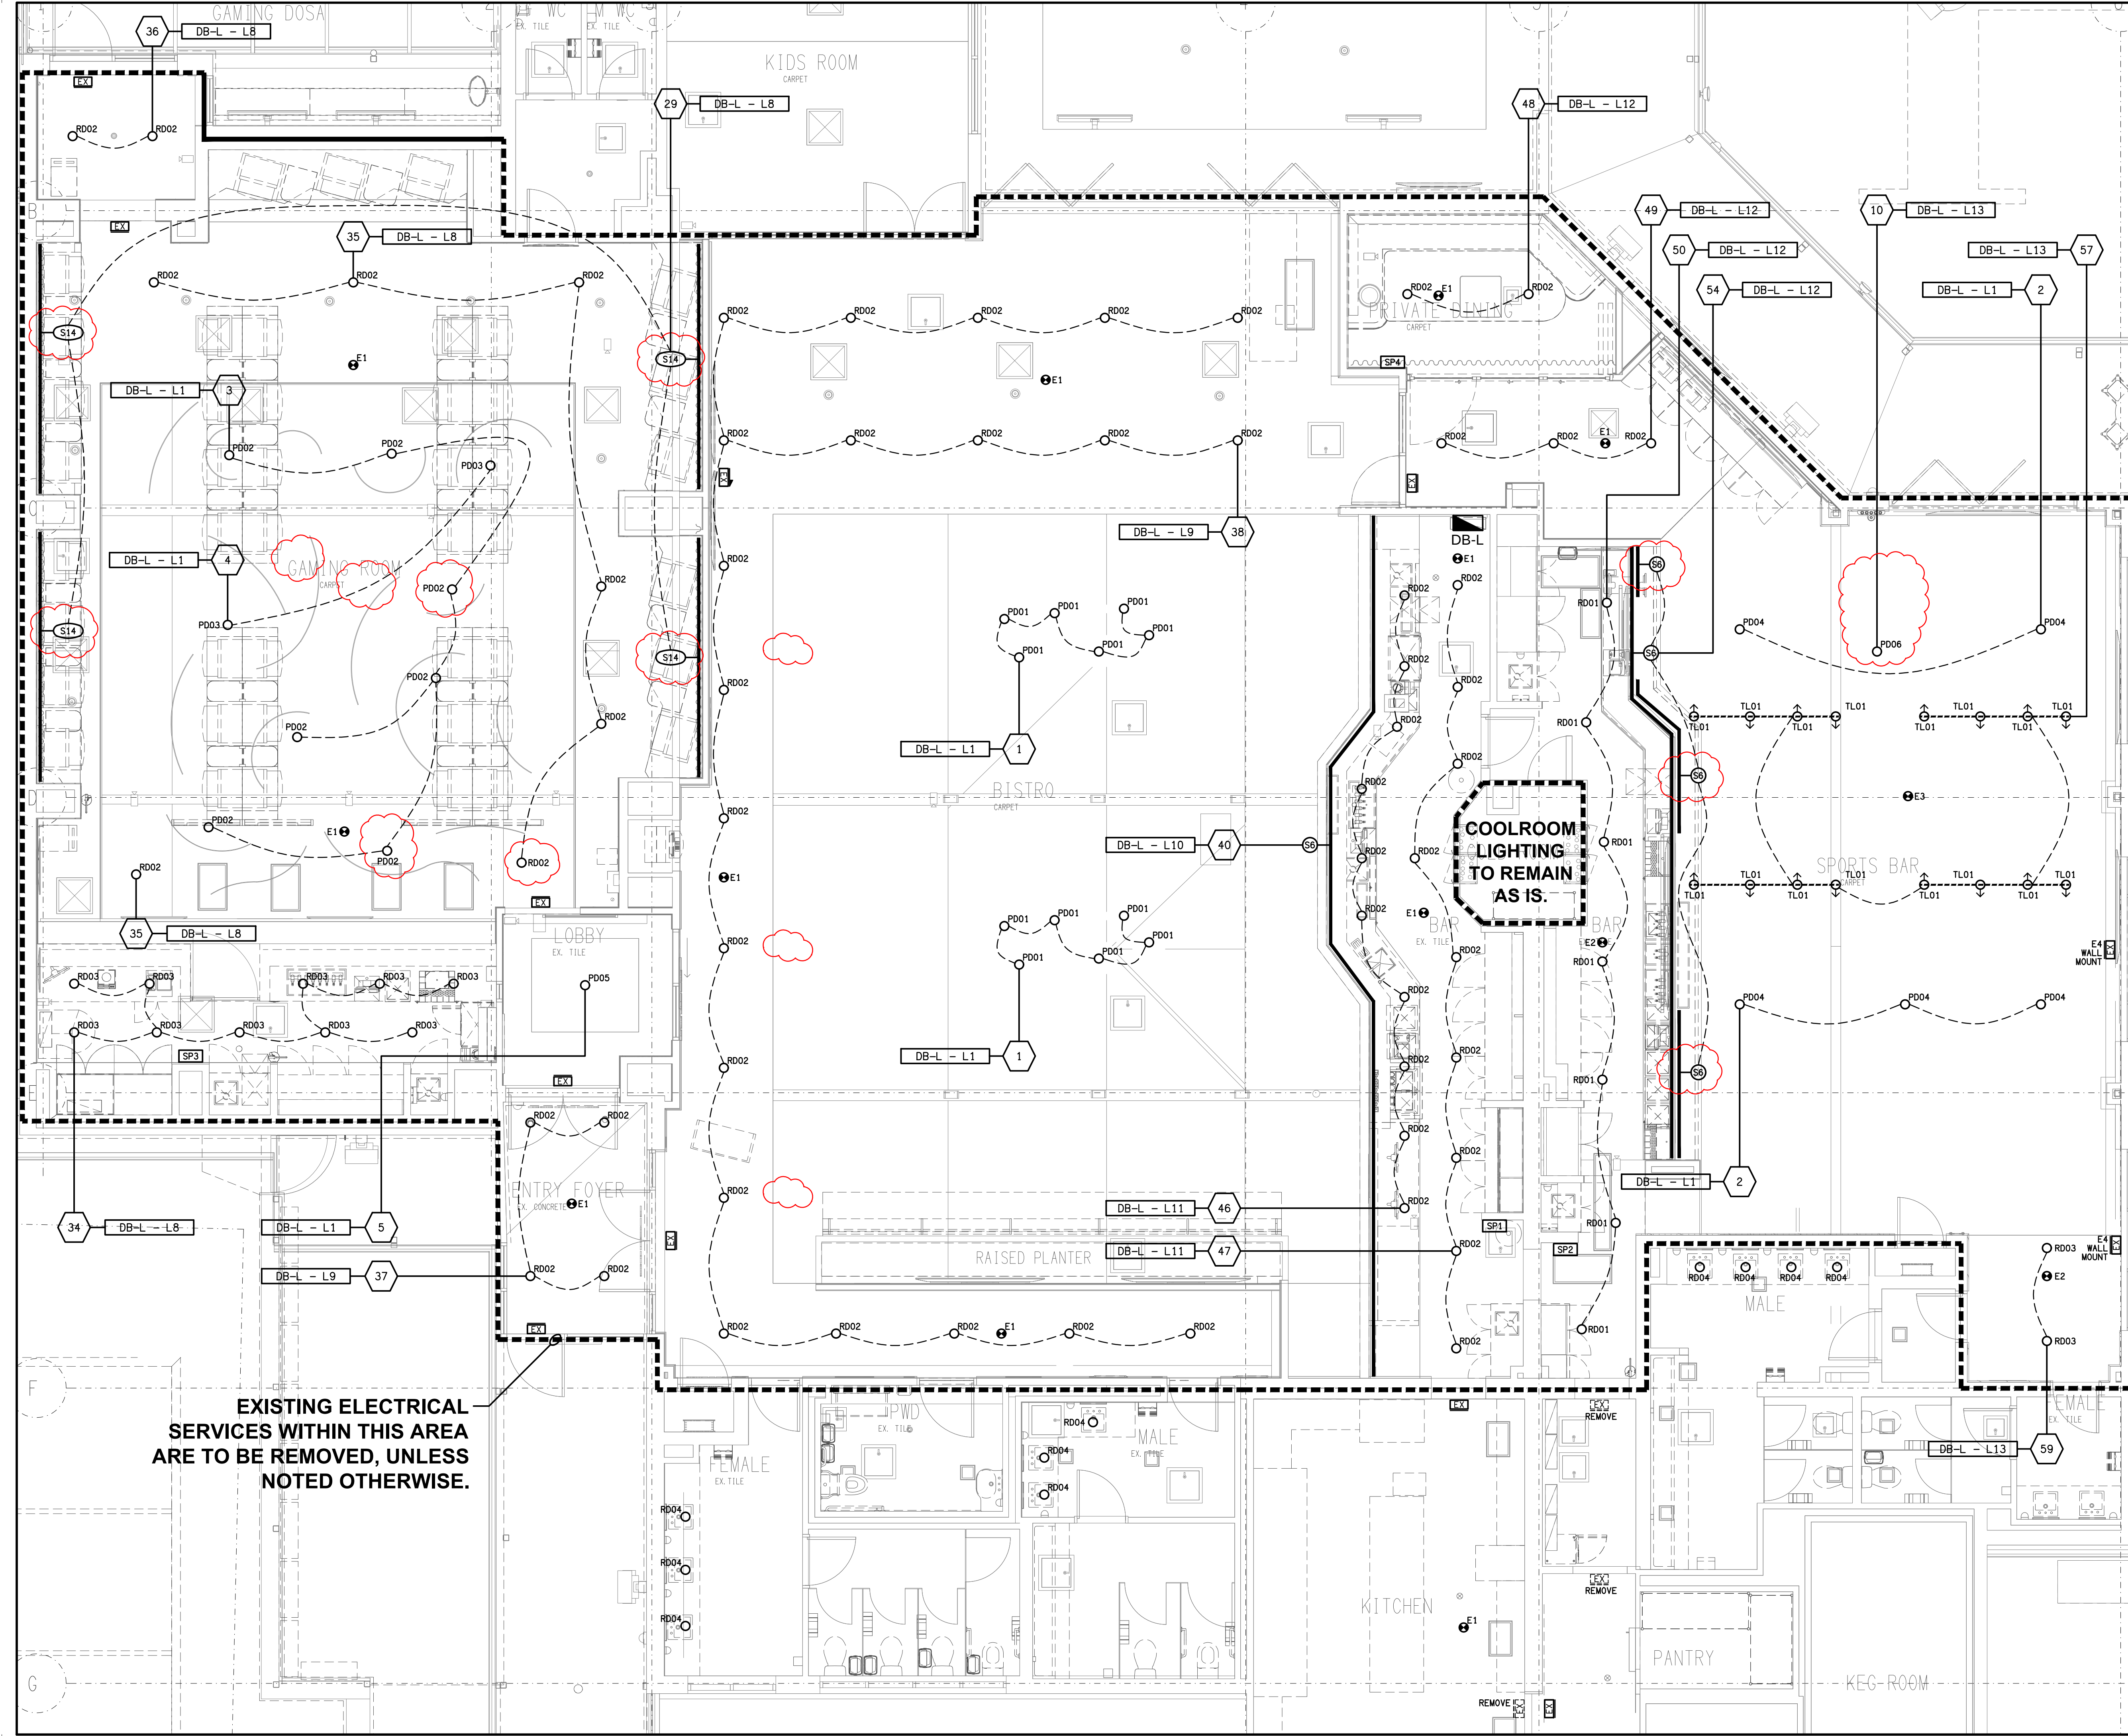

EXISTING ELECTRICAL
SERVICES WITHIN THIS AREA
ARE TO BE REMOVED, UNLESS
NOTED OTHERWISE.

COOLROOM
LIGHTING
TO REMAIN
AS IS.

THE COPYRIGHT OF THIS DRAWING REMAINS THE PROPERTY OF THE ELECTRICAL DESIGN GROUP.

USE FIGURED DIMENSIONS IN PREFERENCE TO SCALE.

ALL DIMENSIONS TO BE VERIFIED ONSITE.

F	TENDER	22/01/2026
REV.	DESCRIPTION:	DATE:

ELECTRICAL DESIGN GROUP
ELECTRICAL BUILDING SERVICES CONSULTANTS

BRISBANE: P.O. Box 15 Sherwood Qld 4075
Phone: (07) 3278 4375
Email: brisbane@edg.net.au
Web: www.edg.net.au

ELECTRICAL DESIGN GROUP BRISBANE PTY LTD
ACN 092 710 793

TRADING AS:
ELECTRICAL DESIGN GROUP

PROJECT:
JIMBOOMBA TAVERN

SITE ADDRESS:
CORNER MT LINDESAY HIGHWAY &
CUSACKS LANE, JIMBOOMBA

SCALE:	SHEET SIZE:
1:50	AT A1

DRAWING TITLE:
**ELECTRICAL SERVICES
REFLECTED CEILING PLAN**

PROJECT NO:	DRAWING NO:	REVISION:
C3630a	E05	F