



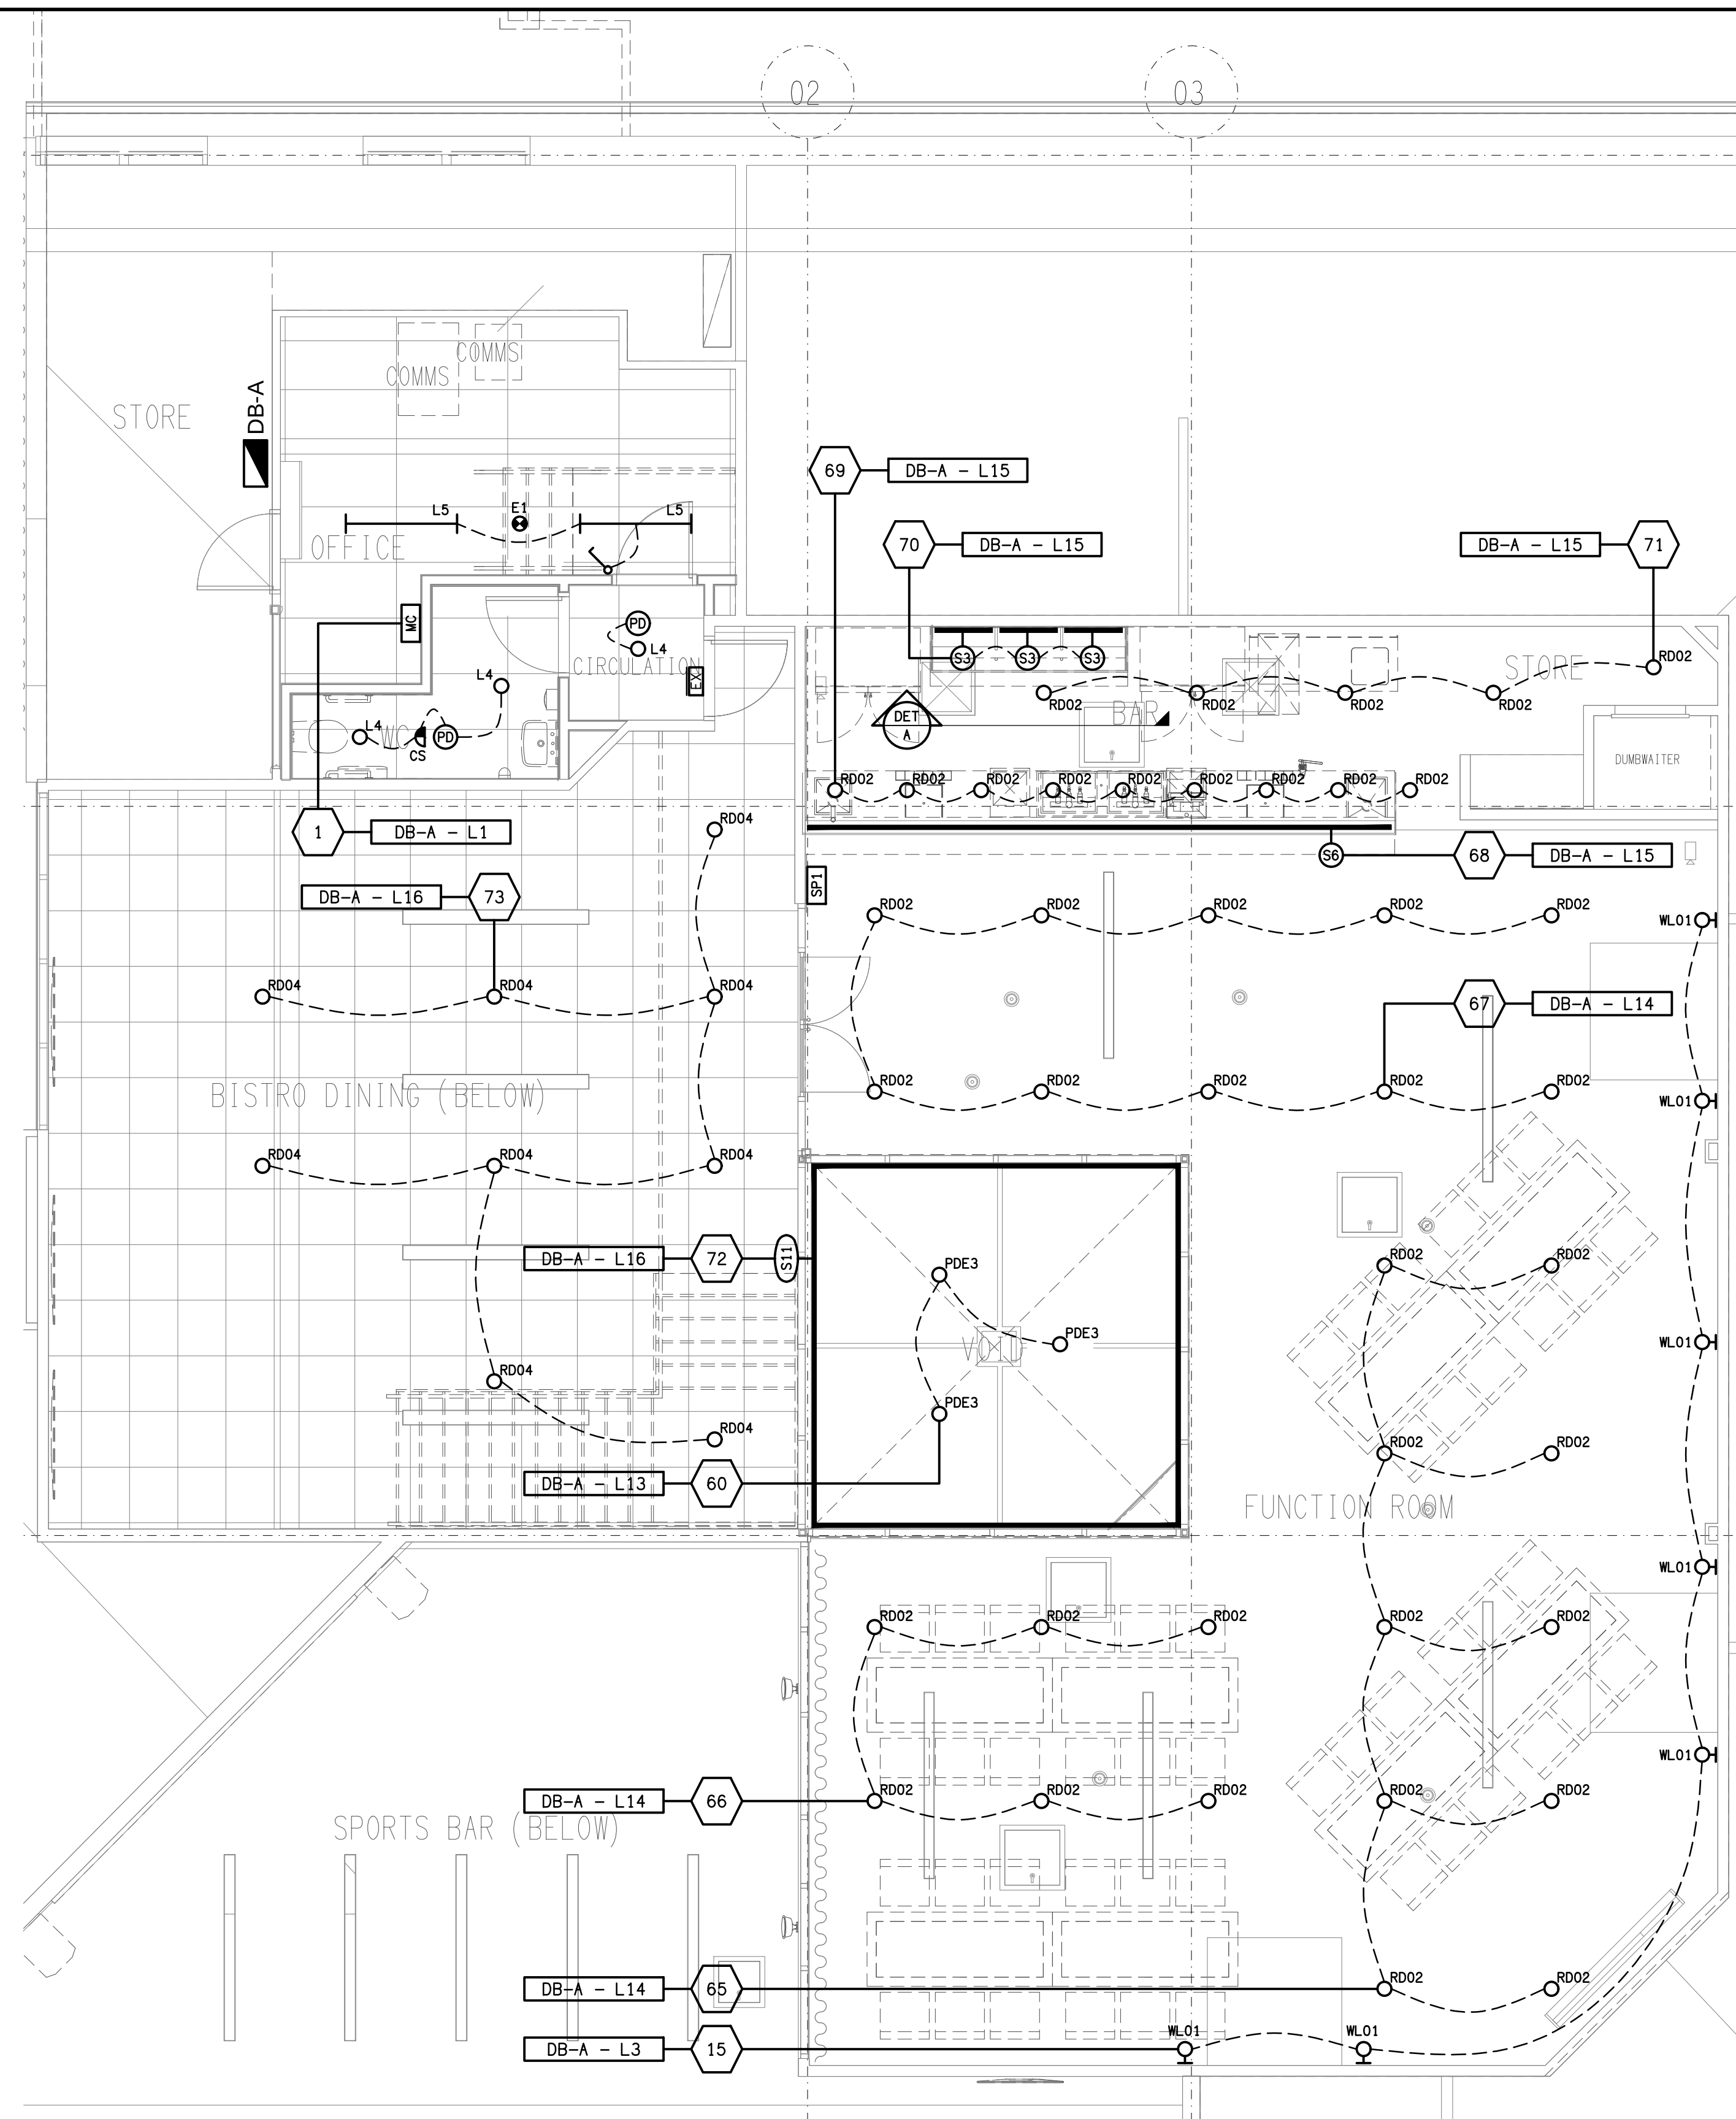

REFLECTED CEILING PLAN

LEVEL 1
SCALE 1:50

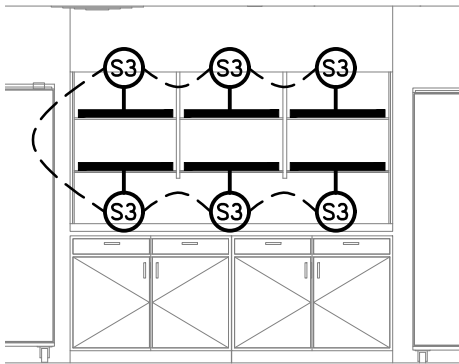

DETAIL A
LEVEL 1 BAR ELEVATION
SCALE 1: 50

THE COPYRIGHT OF THIS DRAWING REMAINS THE PROPERTY OF
THE ELECTRICAL DESIGN GROUP.

USE FIGURED DIMENSIONS IN PREFERENCE TO SCALE.

ALL DIMENSIONS TO BE VERIFIED ONSITE.

C	TENDER	18/11/2025
REV:	DESCRIPTION:	DATE:

ELECTRICAL DESIGN GROUP
ELECTRICAL BUILDING SERVICES CONSULTANTS

BRISBANE: P.O. Box 15 Sherwood Qld 4075
Phone: (07) 3278 4375
Email: brisbane@edg.net.au
Web: www.edg.net.au

ELECTRICAL DESIGN GROUP BRISBANE
PTY LTD
ACN 092 710 793

TRADING AS:
ELECTRICAL DESIGN
GROUP

PROJECT: _____

KENSINGTON TAVERN

SITE ADDRESS:

25 JULIE STREET, CRESTMEAD
QUEENSLAND

SCALE: SHEET SIZE:

1:50 AT A1

DRAWING TITLE:

ELECTRICAL SERVICES

LEVEL 1

FLOOR PLAN & REFLECTED CEILING PLAN

PROJECT NO:	DRAWING NO:	REVISION:
-------------	-------------	-----------

C3638a E08 C