




**DETAIL A**  
TYPICAL SCREEN TYPE 1 PLAN  
SCALE 1:10

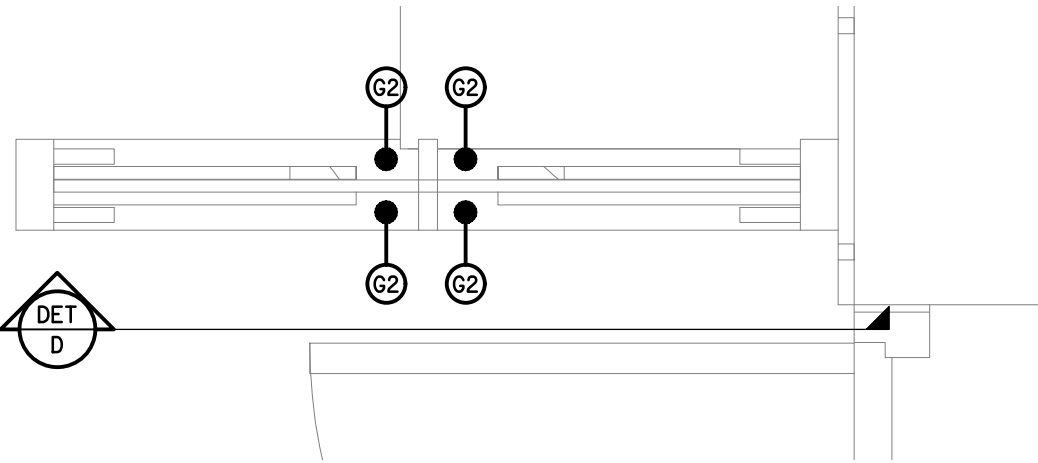


**DETAIL B**  
TYPICAL SCREEN TYPE 2 PLAN  
SCALE 1:10

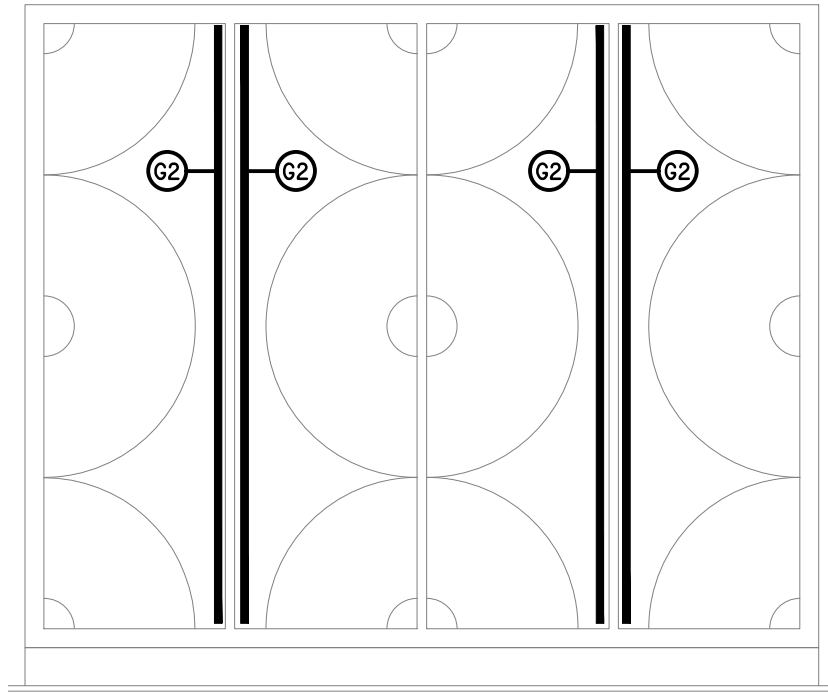

**DETAIL C**  
TYPICAL SCREEN TYPE 1 ELEVATION  
SCALE 1:20

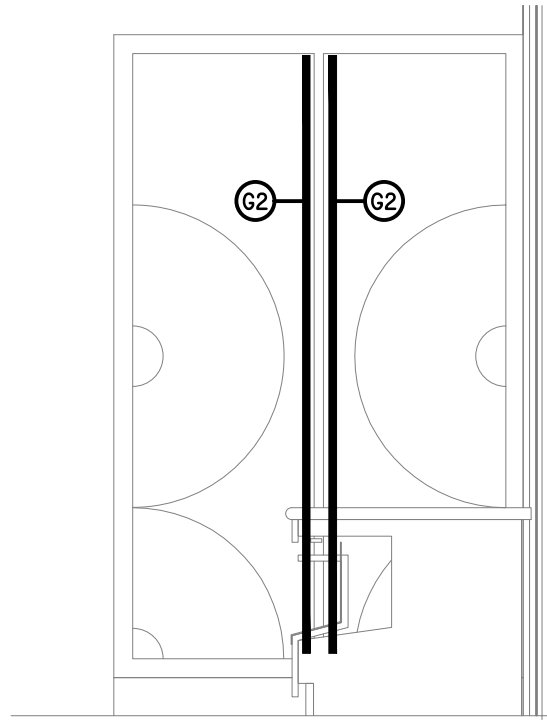

**DETAIL D**  
TYPICAL SCREEN TYPE 2 ELEVATION  
SCALE 1:20


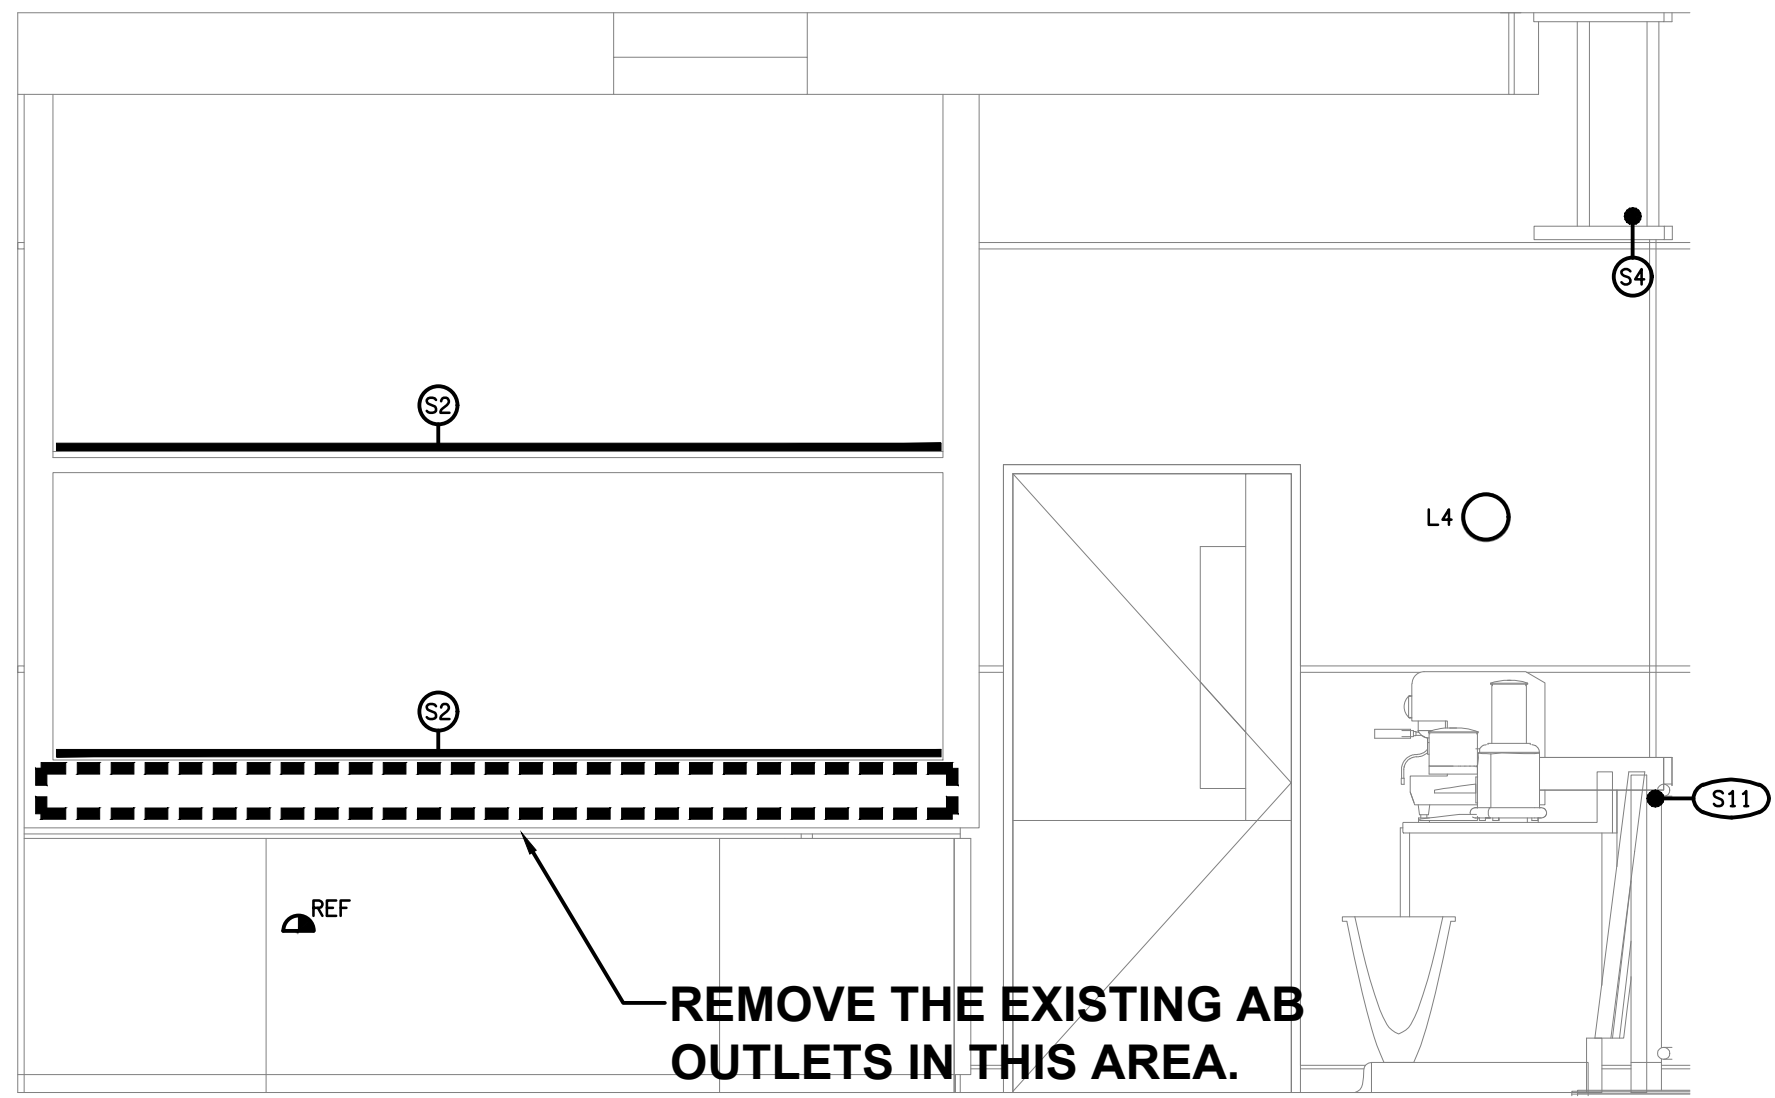


**DETAIL E**  
GAMING BAR SECTION VIEW  
SCALE 1:25

THE COPYRIGHT OF THIS DRAWING REMAINS THE PROPERTY OF THE ELECTRICAL DESIGN GROUP.

USE FIGURED DIMENSIONS IN PREFERENCE TO SCALE.

ALL DIMENSIONS TO BE VERIFIED ONSITE.

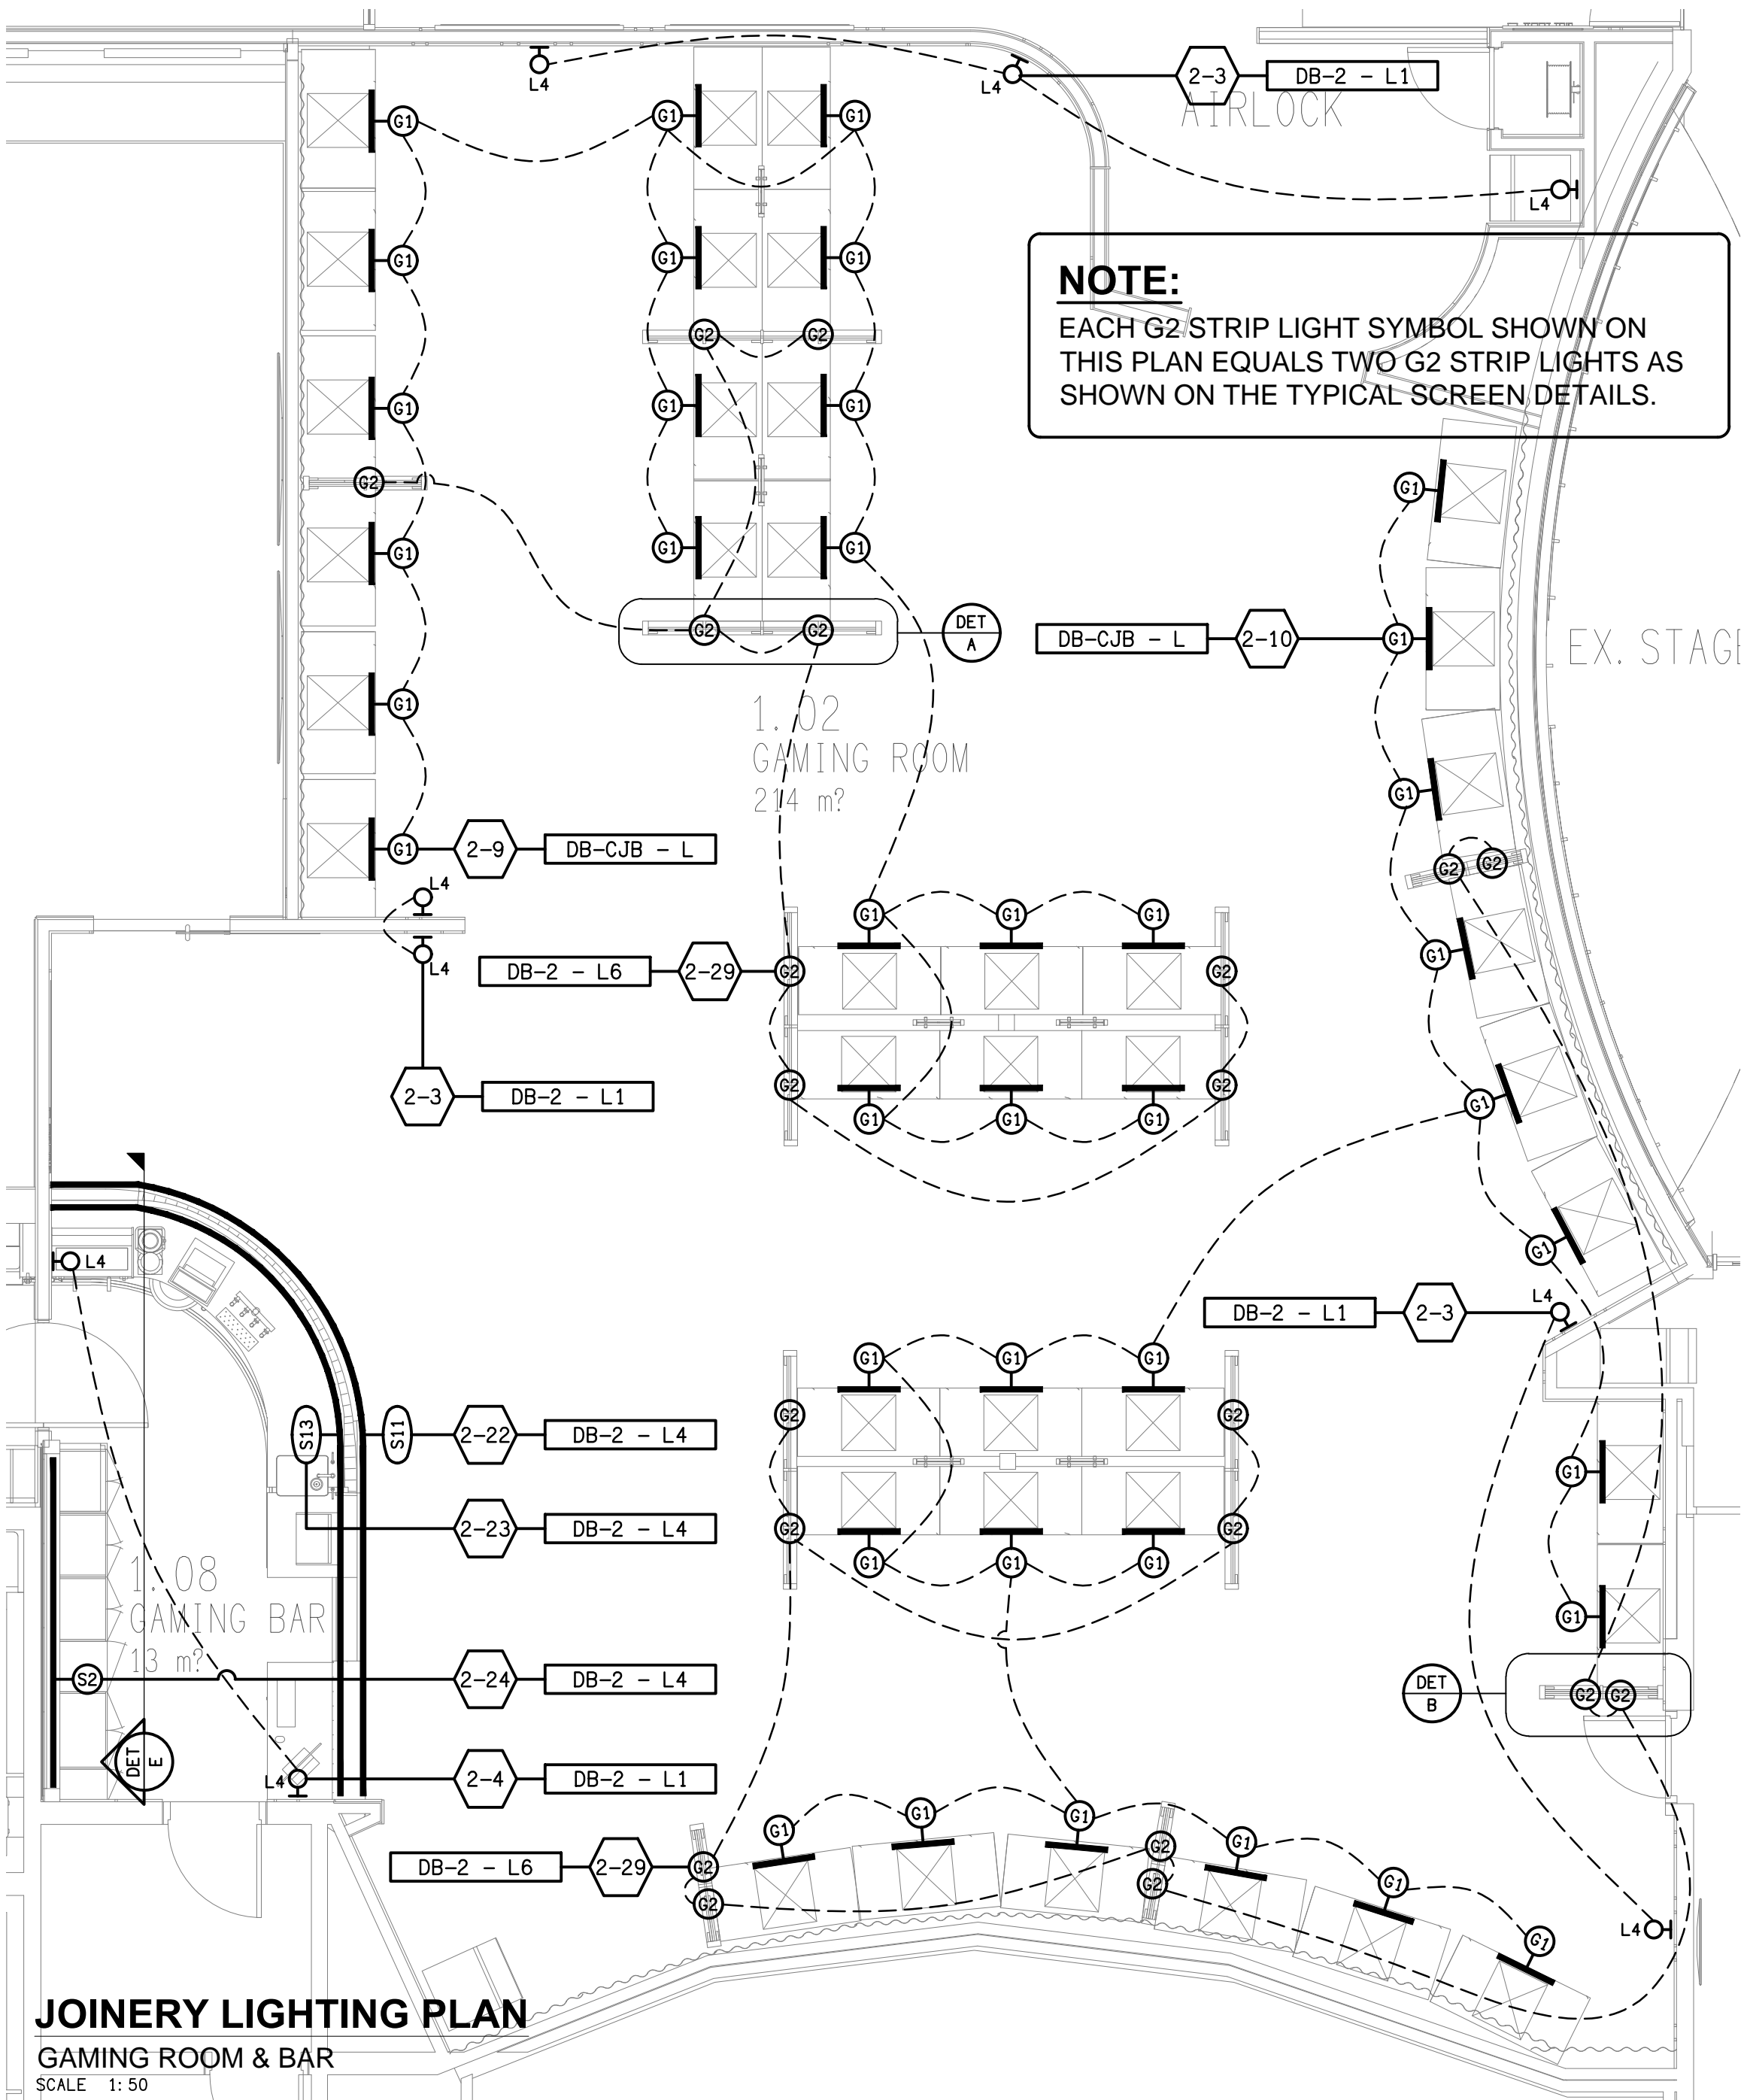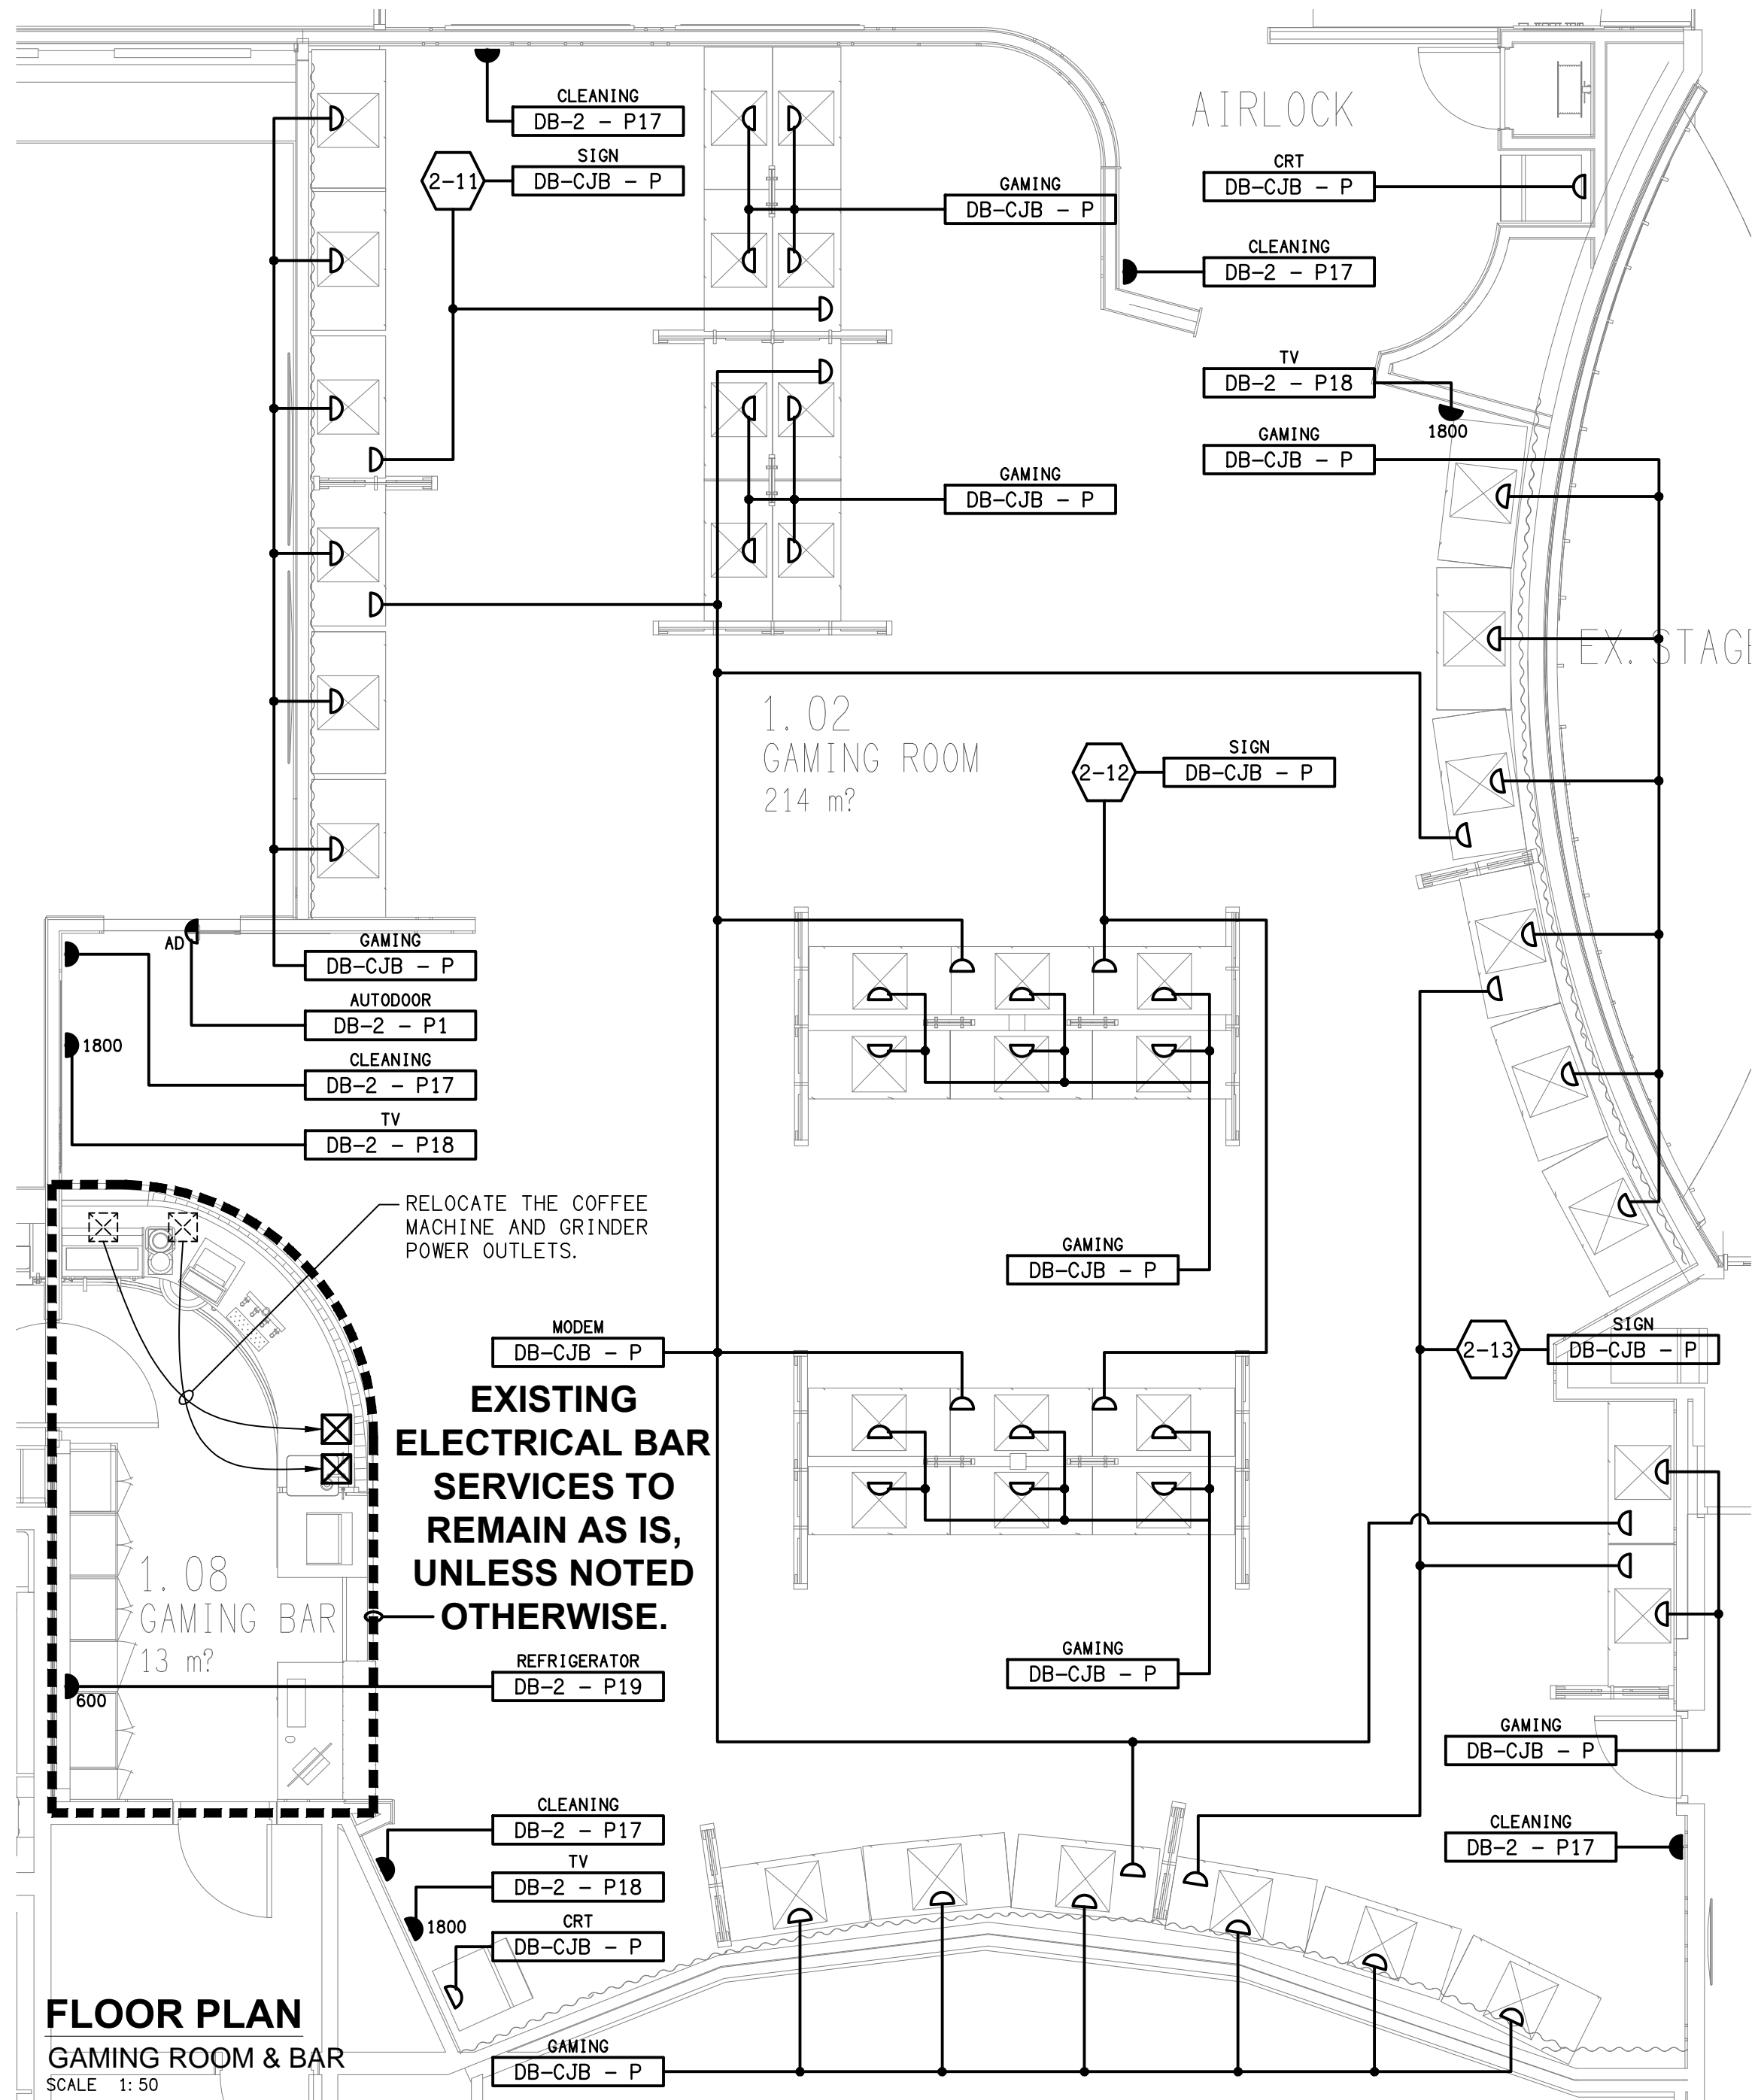

**NOTE:**  
EACH G2 STRIP LIGHT SYMBOL SHOWN ON THIS PLAN EQUALS TWO G2 STRIP LIGHTS AS SHOWN ON THE TYPICAL SCREEN DETAILS.

B	TENDER	31/10/2025
REV:	DESCRIPTION:	DATE:

**ELECTRICAL DESIGN GROUP**  
ELECTRICAL BUILDING SERVICES CONSULTANTS

BRISBANE: P.O. Box 15 Sherwood Qld 4075  
Phone: (07) 3278 4375  
Email: brisbane@edg.net.au  
Web: www.edg.net.au

ELECTRICAL DESIGN GROUP BRISBANE PTY LTD  
ACN 092 710 793

TRADING AS:  
ELECTRICAL DESIGN GROUP

PROJECT:

**CLUB TAVERN CABOOLTURE**

SITE ADDRESS:

16 MATTHEW TERRACE, CABOOLTURE

SCALE: SHEET SIZE:

1:50 AT A1

DRAWING TITLE:

**ELECTRICAL SERVICES**  
GAMING ROOM & BAR  
FLOOR PLANS

PROJECT NO: DRAWING NO: REVISION:

**C3646a E04 B**