


NOTE:
REFER TO DRAWING C3646a-E06.dwg FOR THE
ADDITIONAL JOINERY AND WALL LIGHTING PLAN.

**THE EXISTING ELECTRICAL CEILING
SERVICES WITHIN THIS AREA ARE TO
REMAIN AS IS, UNLESS NOTED OTHERWISE.**

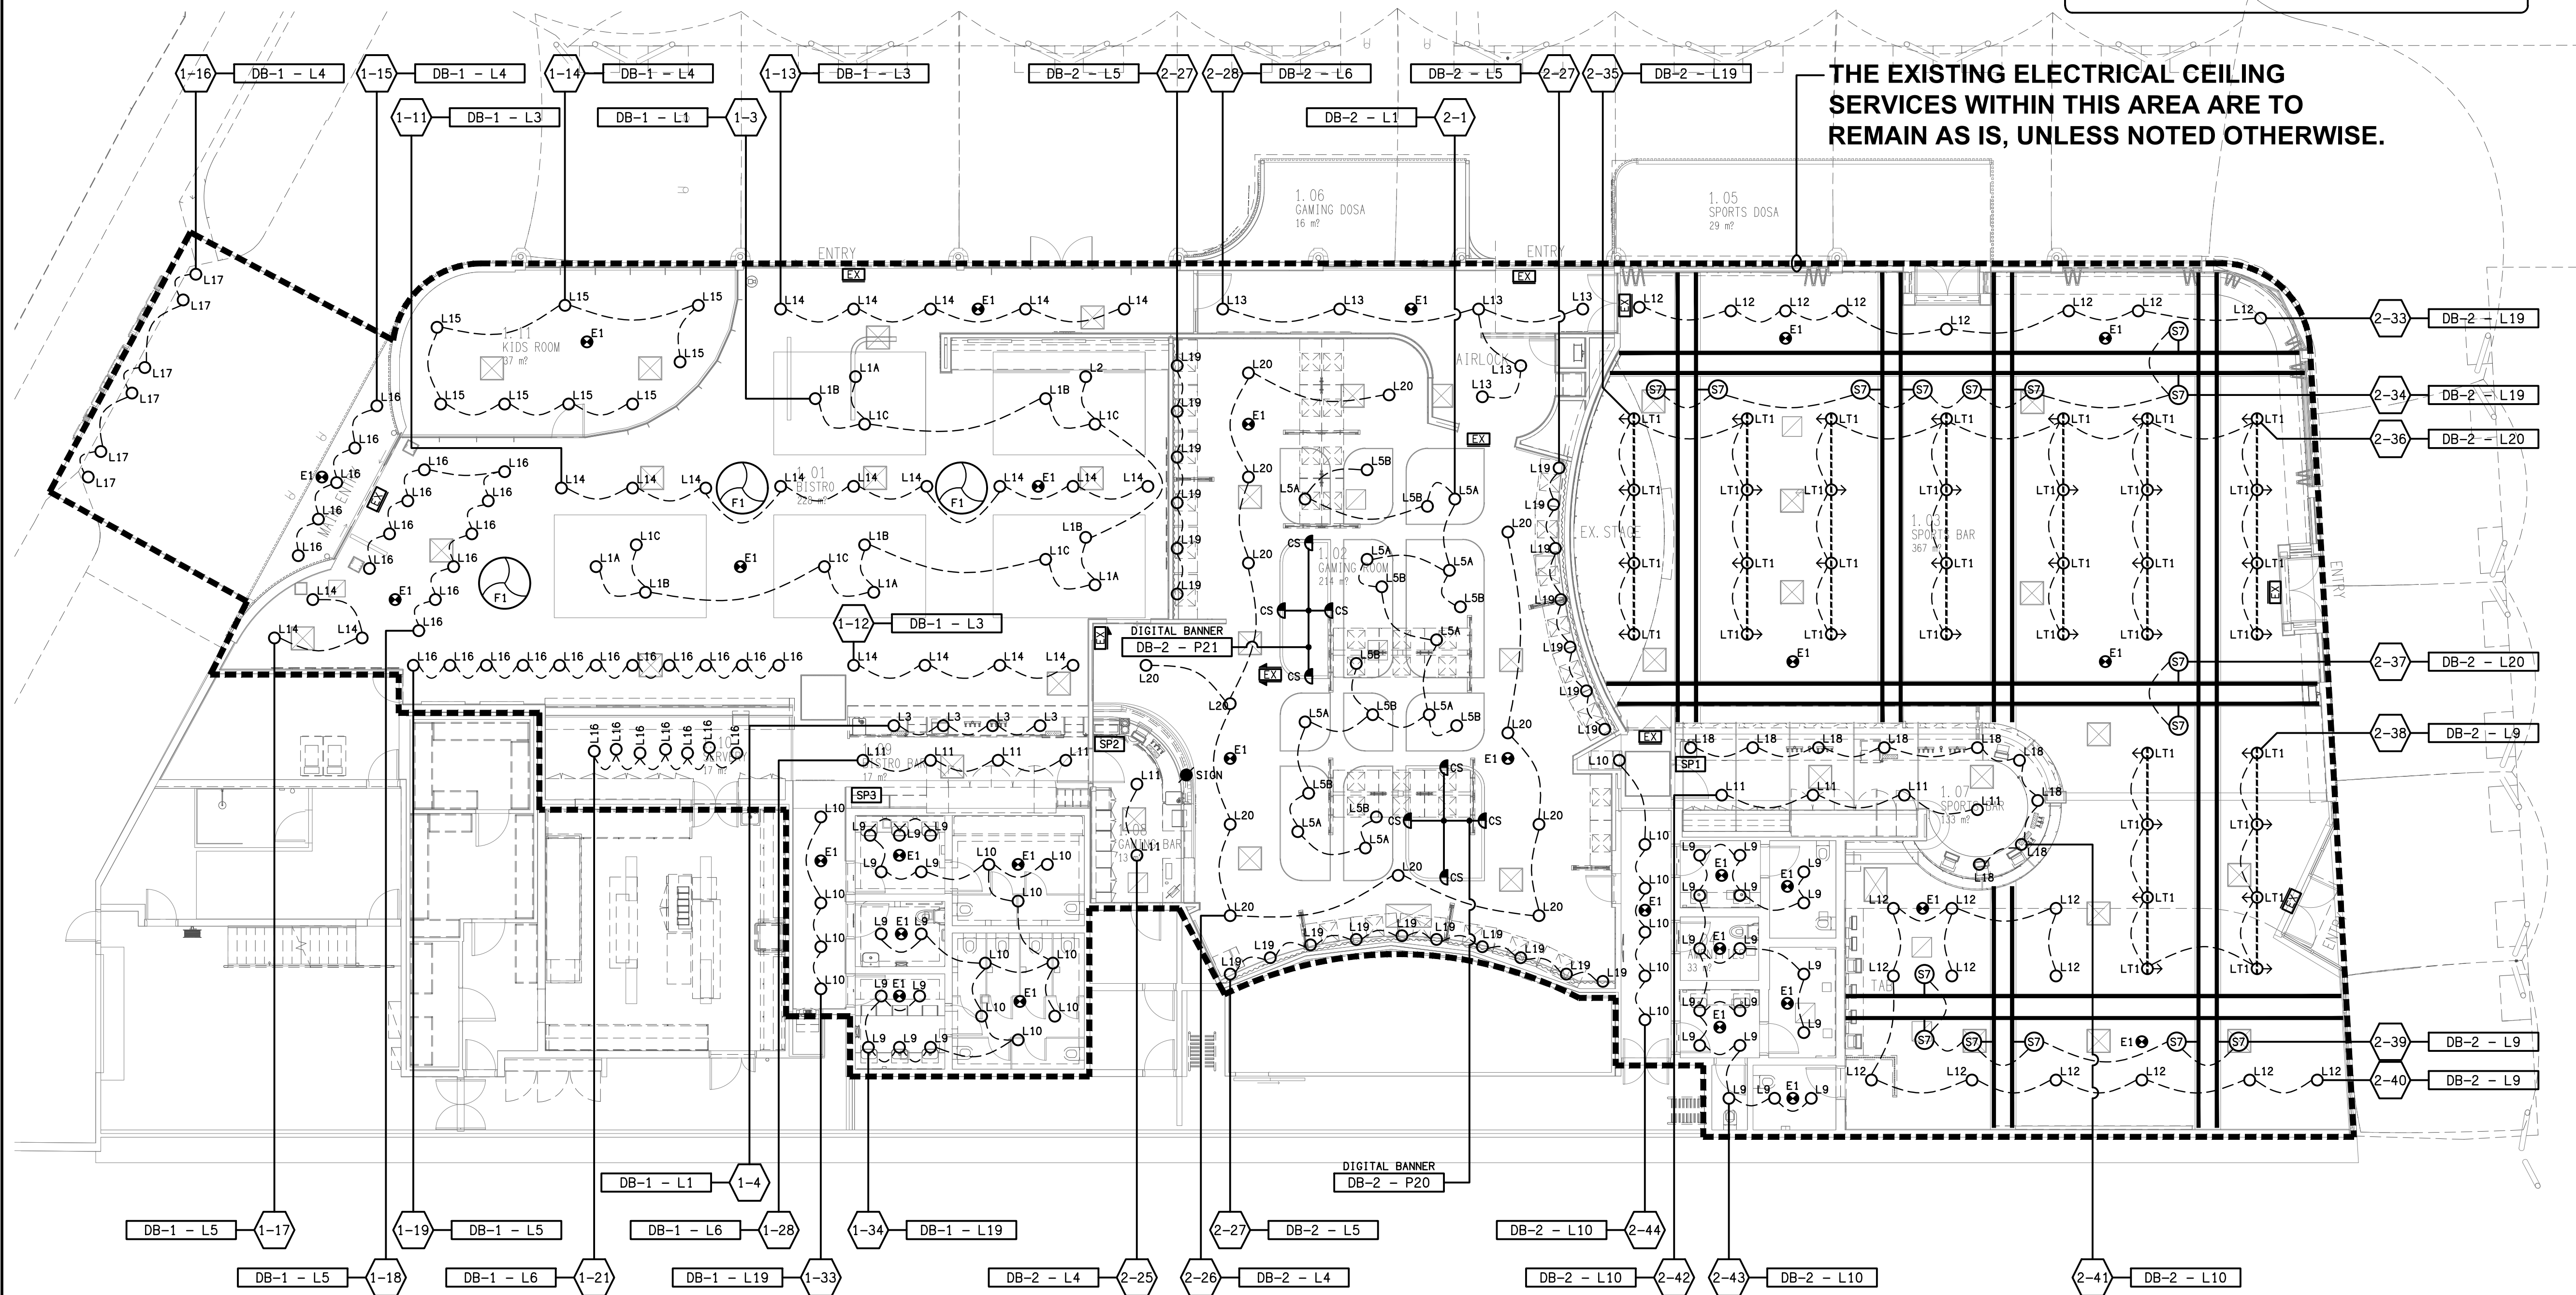

B	TENDER	31/10/2025
REV:	DESCRIPTION:	DATE:

ELECTRICAL DESIGN GROUP
ELECTRICAL BUILDING SERVICES CONSULTANTS

BRISBANE: P.O. Box 15 Sherwood Qld 4075
Phone: (07) 3278 4375
Email: brisbane@edg.net.au
Web: www.edg.net.au

ELECTRICAL DESIGN GROUP BRISBANE PTY LTD
ACN 092 710 793

TRADING AS:
ELECTRICAL DESIGN
GROUP

PROJECT:

**CLUB TAVERN
CABOOLTURE**

SITE ADDRESS:

16 MATTHEW TERRACE, CABOOLTURE

SCALE: SHEET SIZE:

1:100 AT A1

DRAWING TITLE:

**ELECTRICAL SERVICES
REFLECTED CEILING PLAN**

PROJECT NO: DRAWING NO: REVISION:

C3646a E05 B