

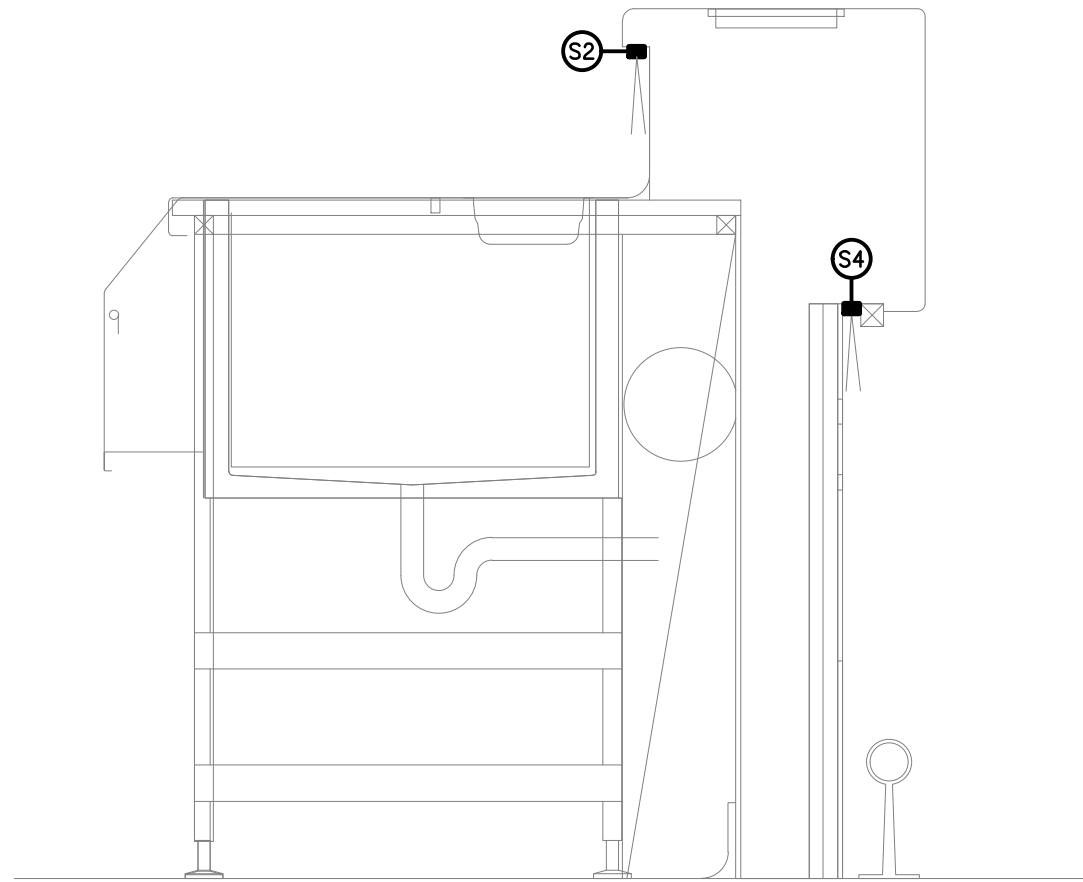



SUBSTATION BAR
LIGHTING PLAN
SCALE 1: 50

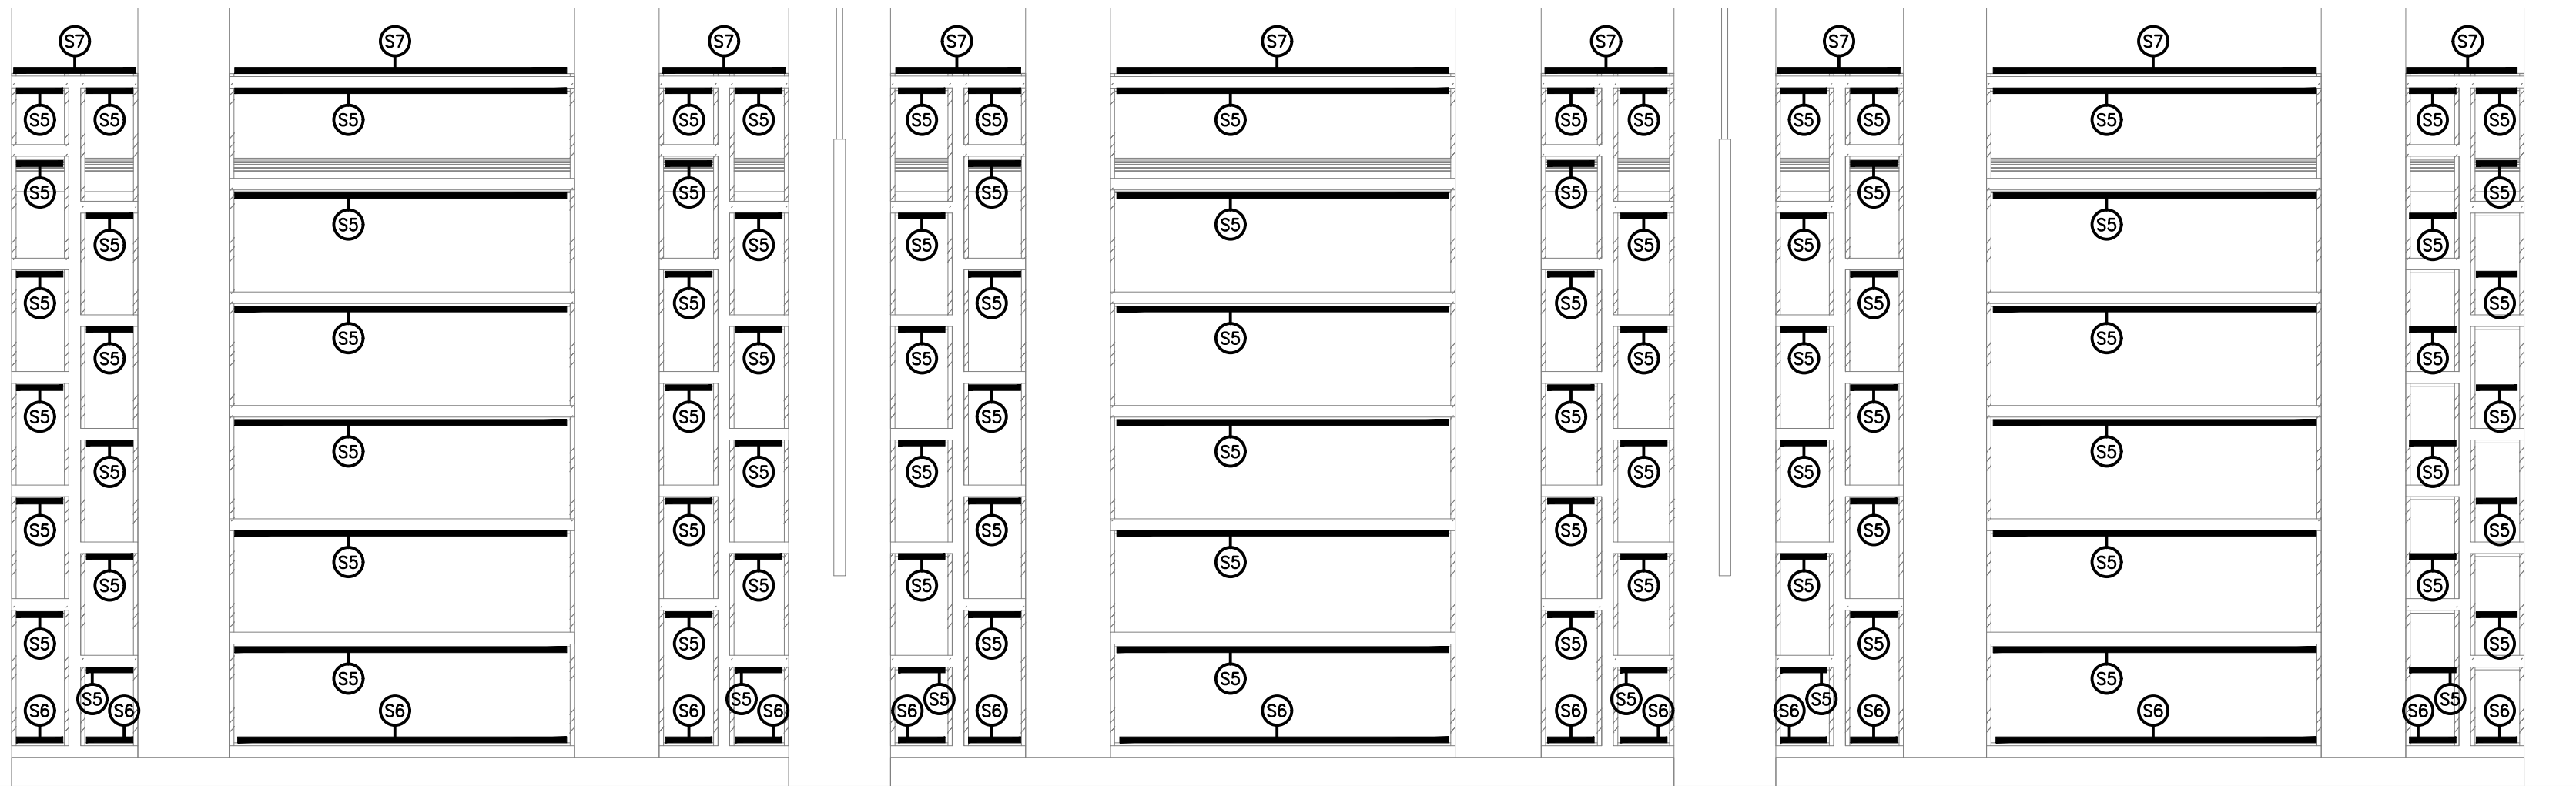


DETAIL A
COUNTER SECTION
SCALE 1: 10

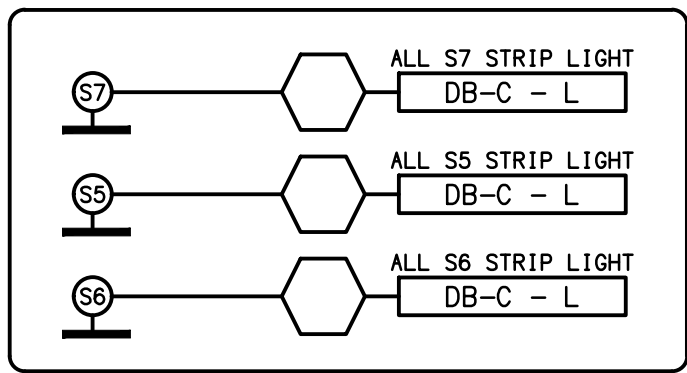


DETAIL B
REAR BAR WALL ELEVATION
SCALE 1: 20

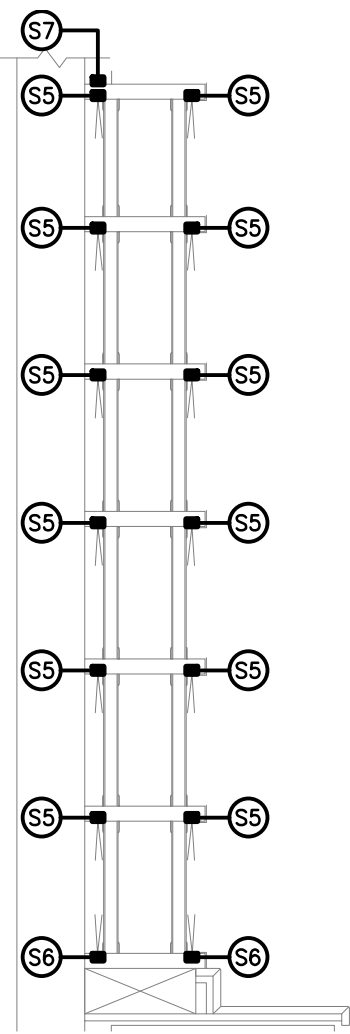

DETAIL C
REAR BAR WALL SECTION
SCALE 1: 20

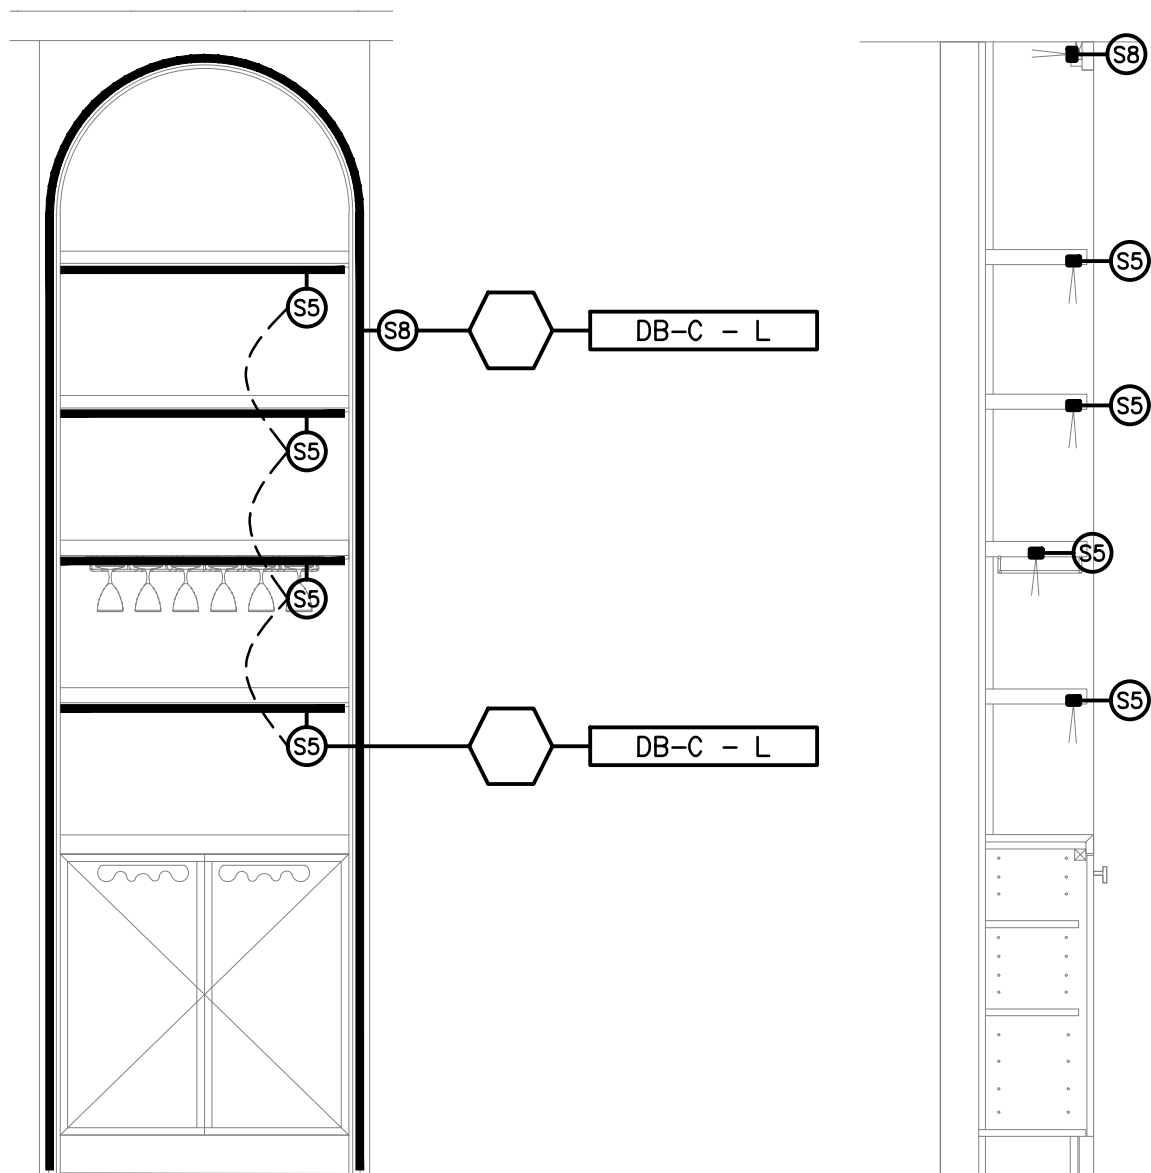

DETAIL D
WAITERS STATION ELEVATION
SCALE 1: 20

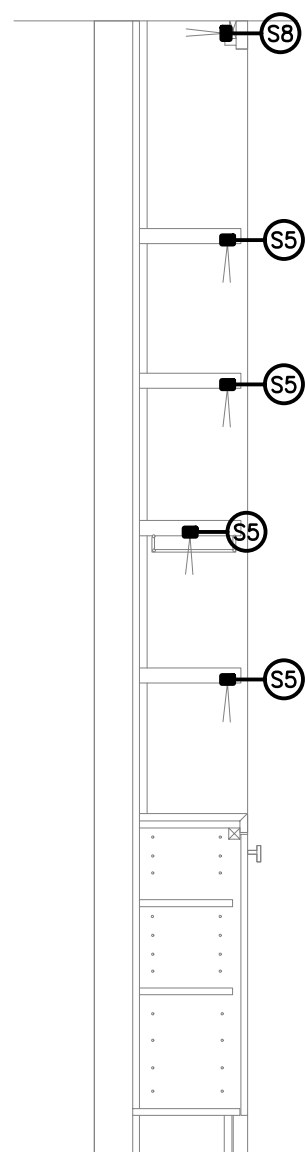

DETAIL E
WAITERS STATION SECTION
SCALE 1: 20