
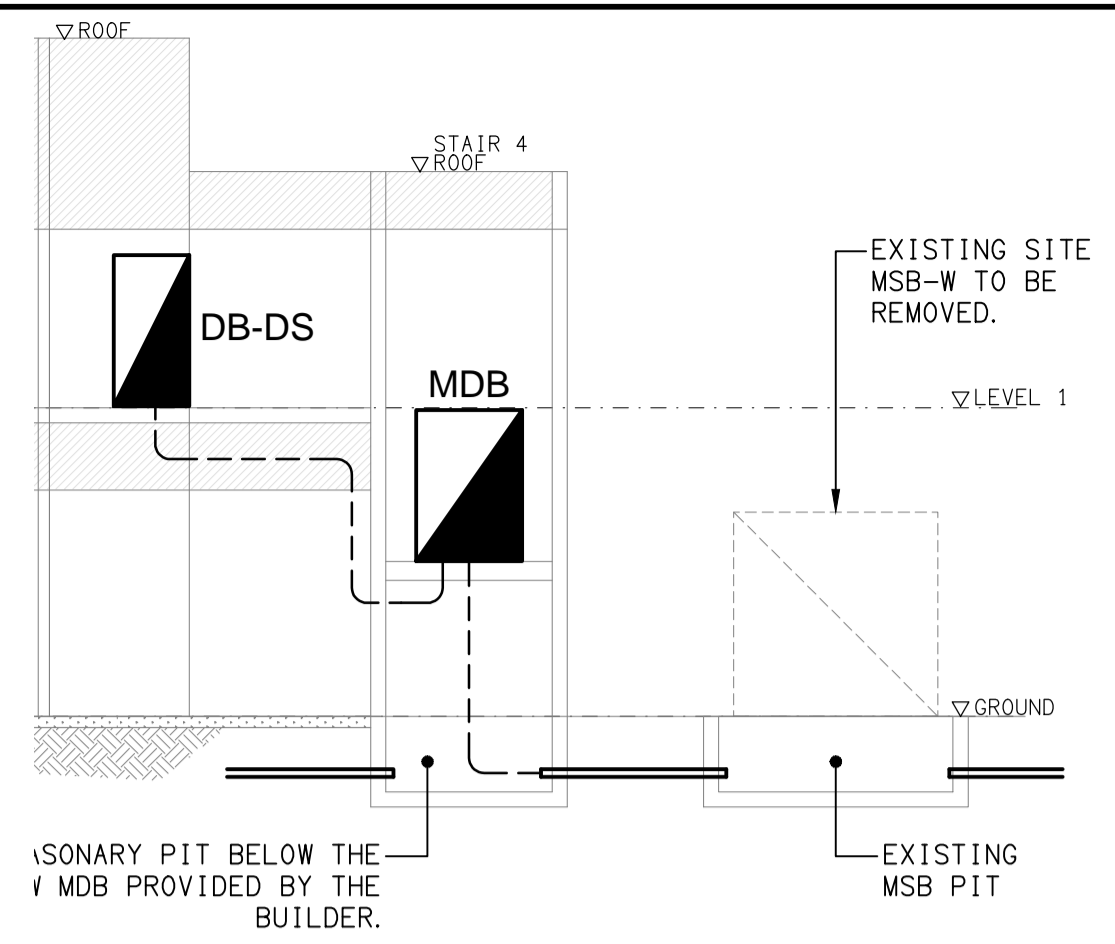


DETAIL A
CABLE ROUTE SECTION
NOT TO SCALE

DETAIL B
CABLE ROUTE SECTION
NOT TO SCALE

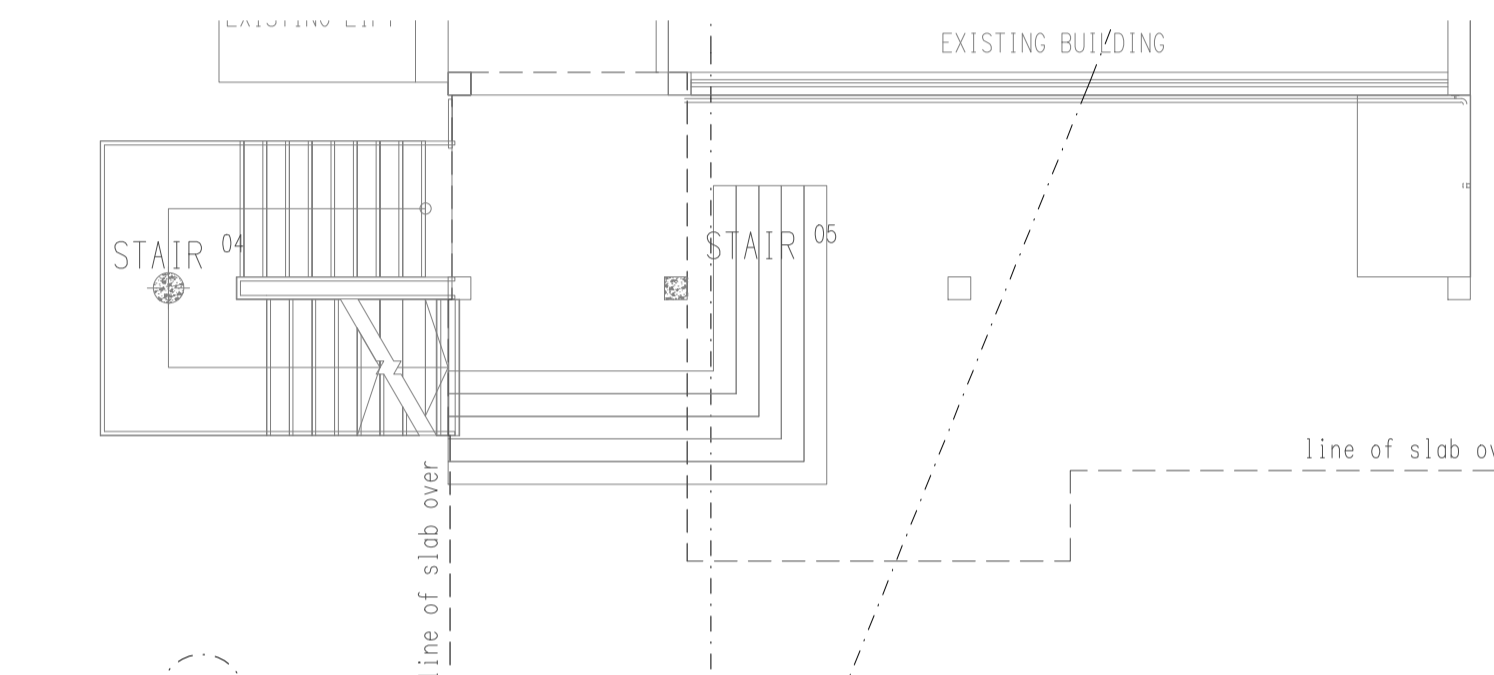

ELECTRICAL DESIGN GROUP BRISBANE
PTY LTD
ACN 092 710 793
TRADING AS:
ELECTRICAL DESIGN GROUP

THE COPYRIGHT OF THIS DRAWING
REMAINS THE PROPERTY OF THE
ELECTRICAL DESIGN GROUP.
USE FIGURED DIMENSIONS
IN REFERENCE TO SCALE.
ALL DIMENSIONS TO BE
VERIFIED ONSITE.

ELECTRICAL DESIGN GROUP
ELECTRICAL BUILDING SERVICES CONSULTANTS
BRISBANE GOLD COAST

P.O. Box 15, Sherwood Q. 4075
Phone: (07) 3278 4375
Email: brisbane@edg.net.au
Web: www.edg.net.au

PROJECT:
**KINGS CHRISTIAN COLLEGE - REEDY CREEK
GLAs & STUDENT SERVICES KCC49**

68 GEMVALE ROAD, REEDY CREEK, QUEENSLAND

D	CONSTRUCTION	24/09/2024
REV:	DESCRIPTION:	DATE:

DRAWING:
**ELECTRICAL SERVICES
PROPOSED PART SITE PLAN**

SCALE:
1:100

AT A1

PROJECT NO:
C2717a

DRAWING NO:
E05

REVISION:
D