



DETAIL A
KITCHENETTE ELEVATION
SCALE 1:50


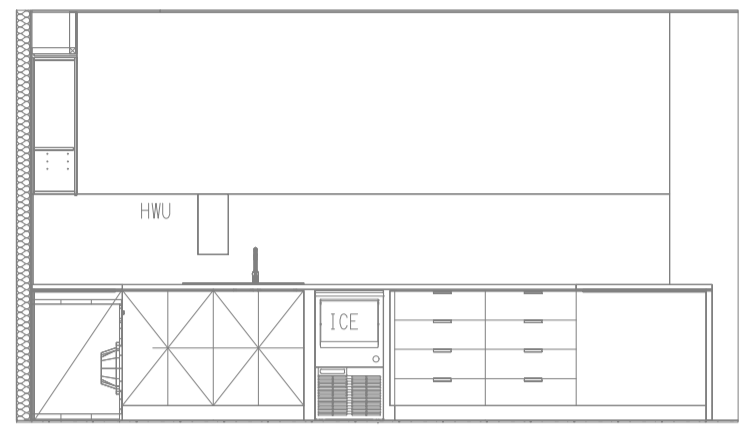


DETAIL B
UTILITIES BENCH ELEVATION 1
SCALE 1:50

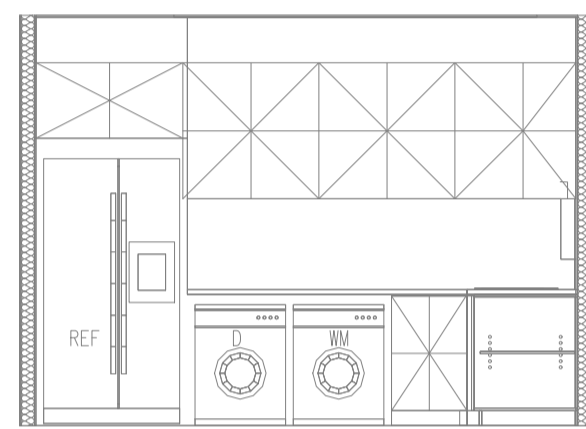

DETAIL C
UTILITIES BENCH ELEVATION 2
SCALE 1:50

EXISTING ELECTRICAL SERVICES WITHIN THIS AREA ARE TO BE REMOVED, UNLESS NOTED OTHERWISE.

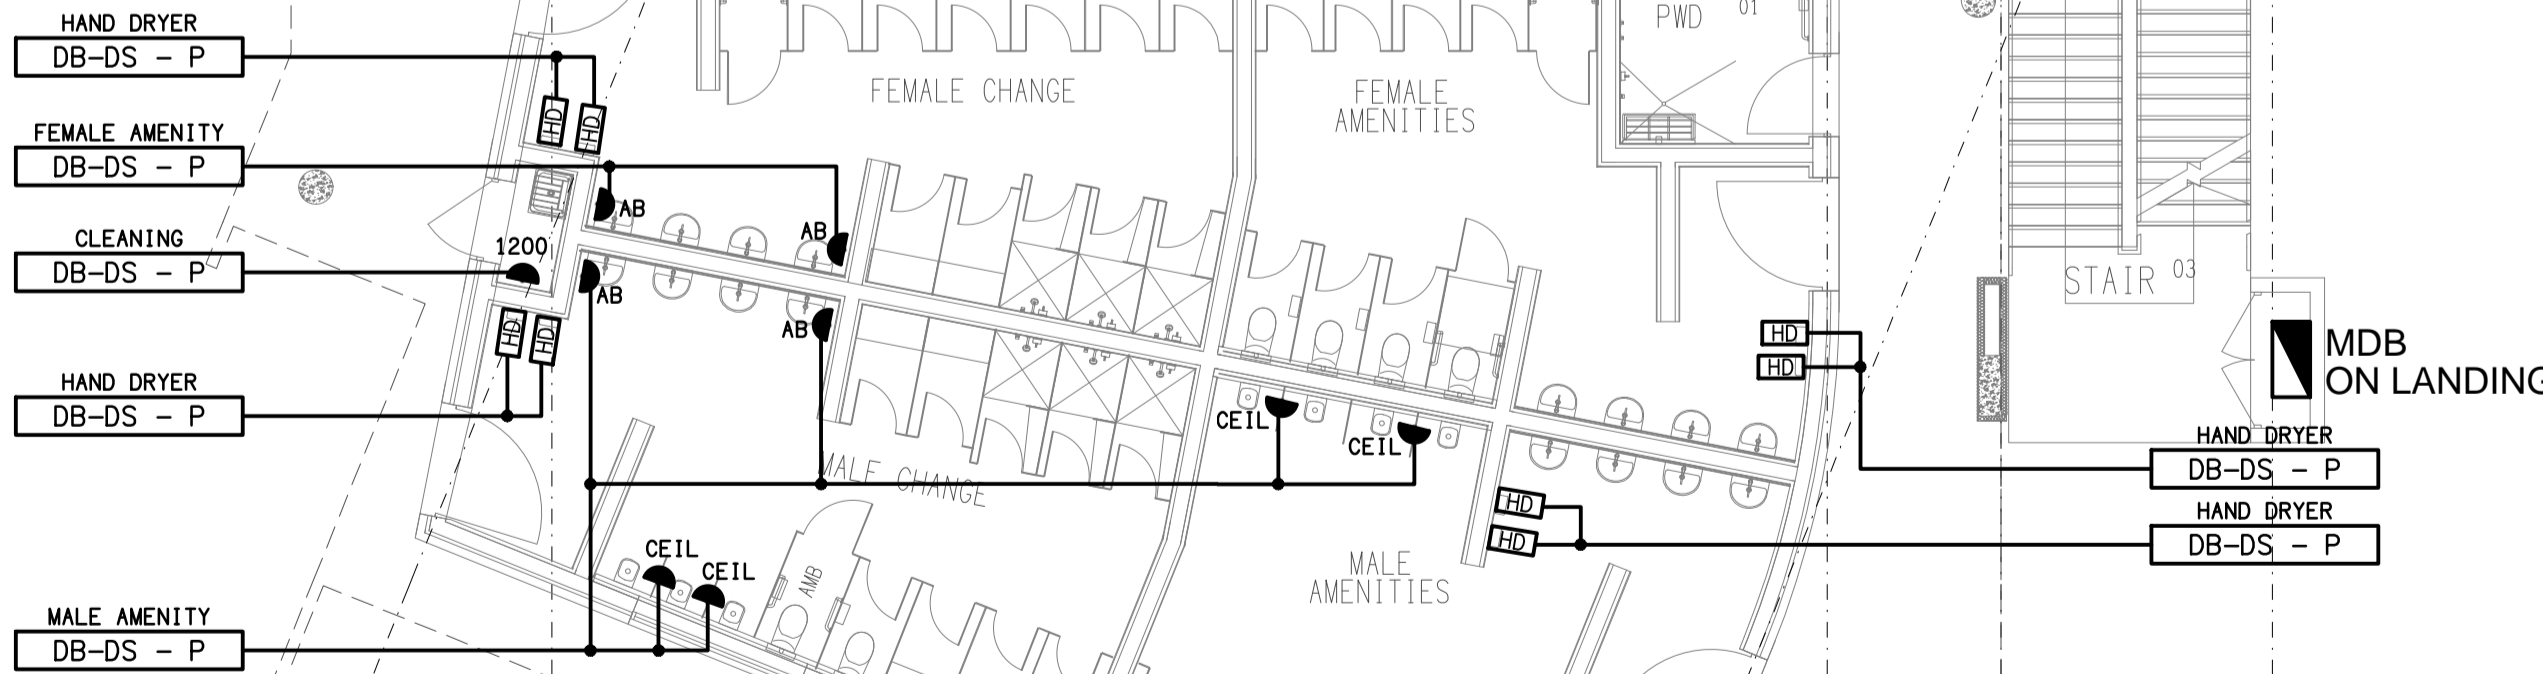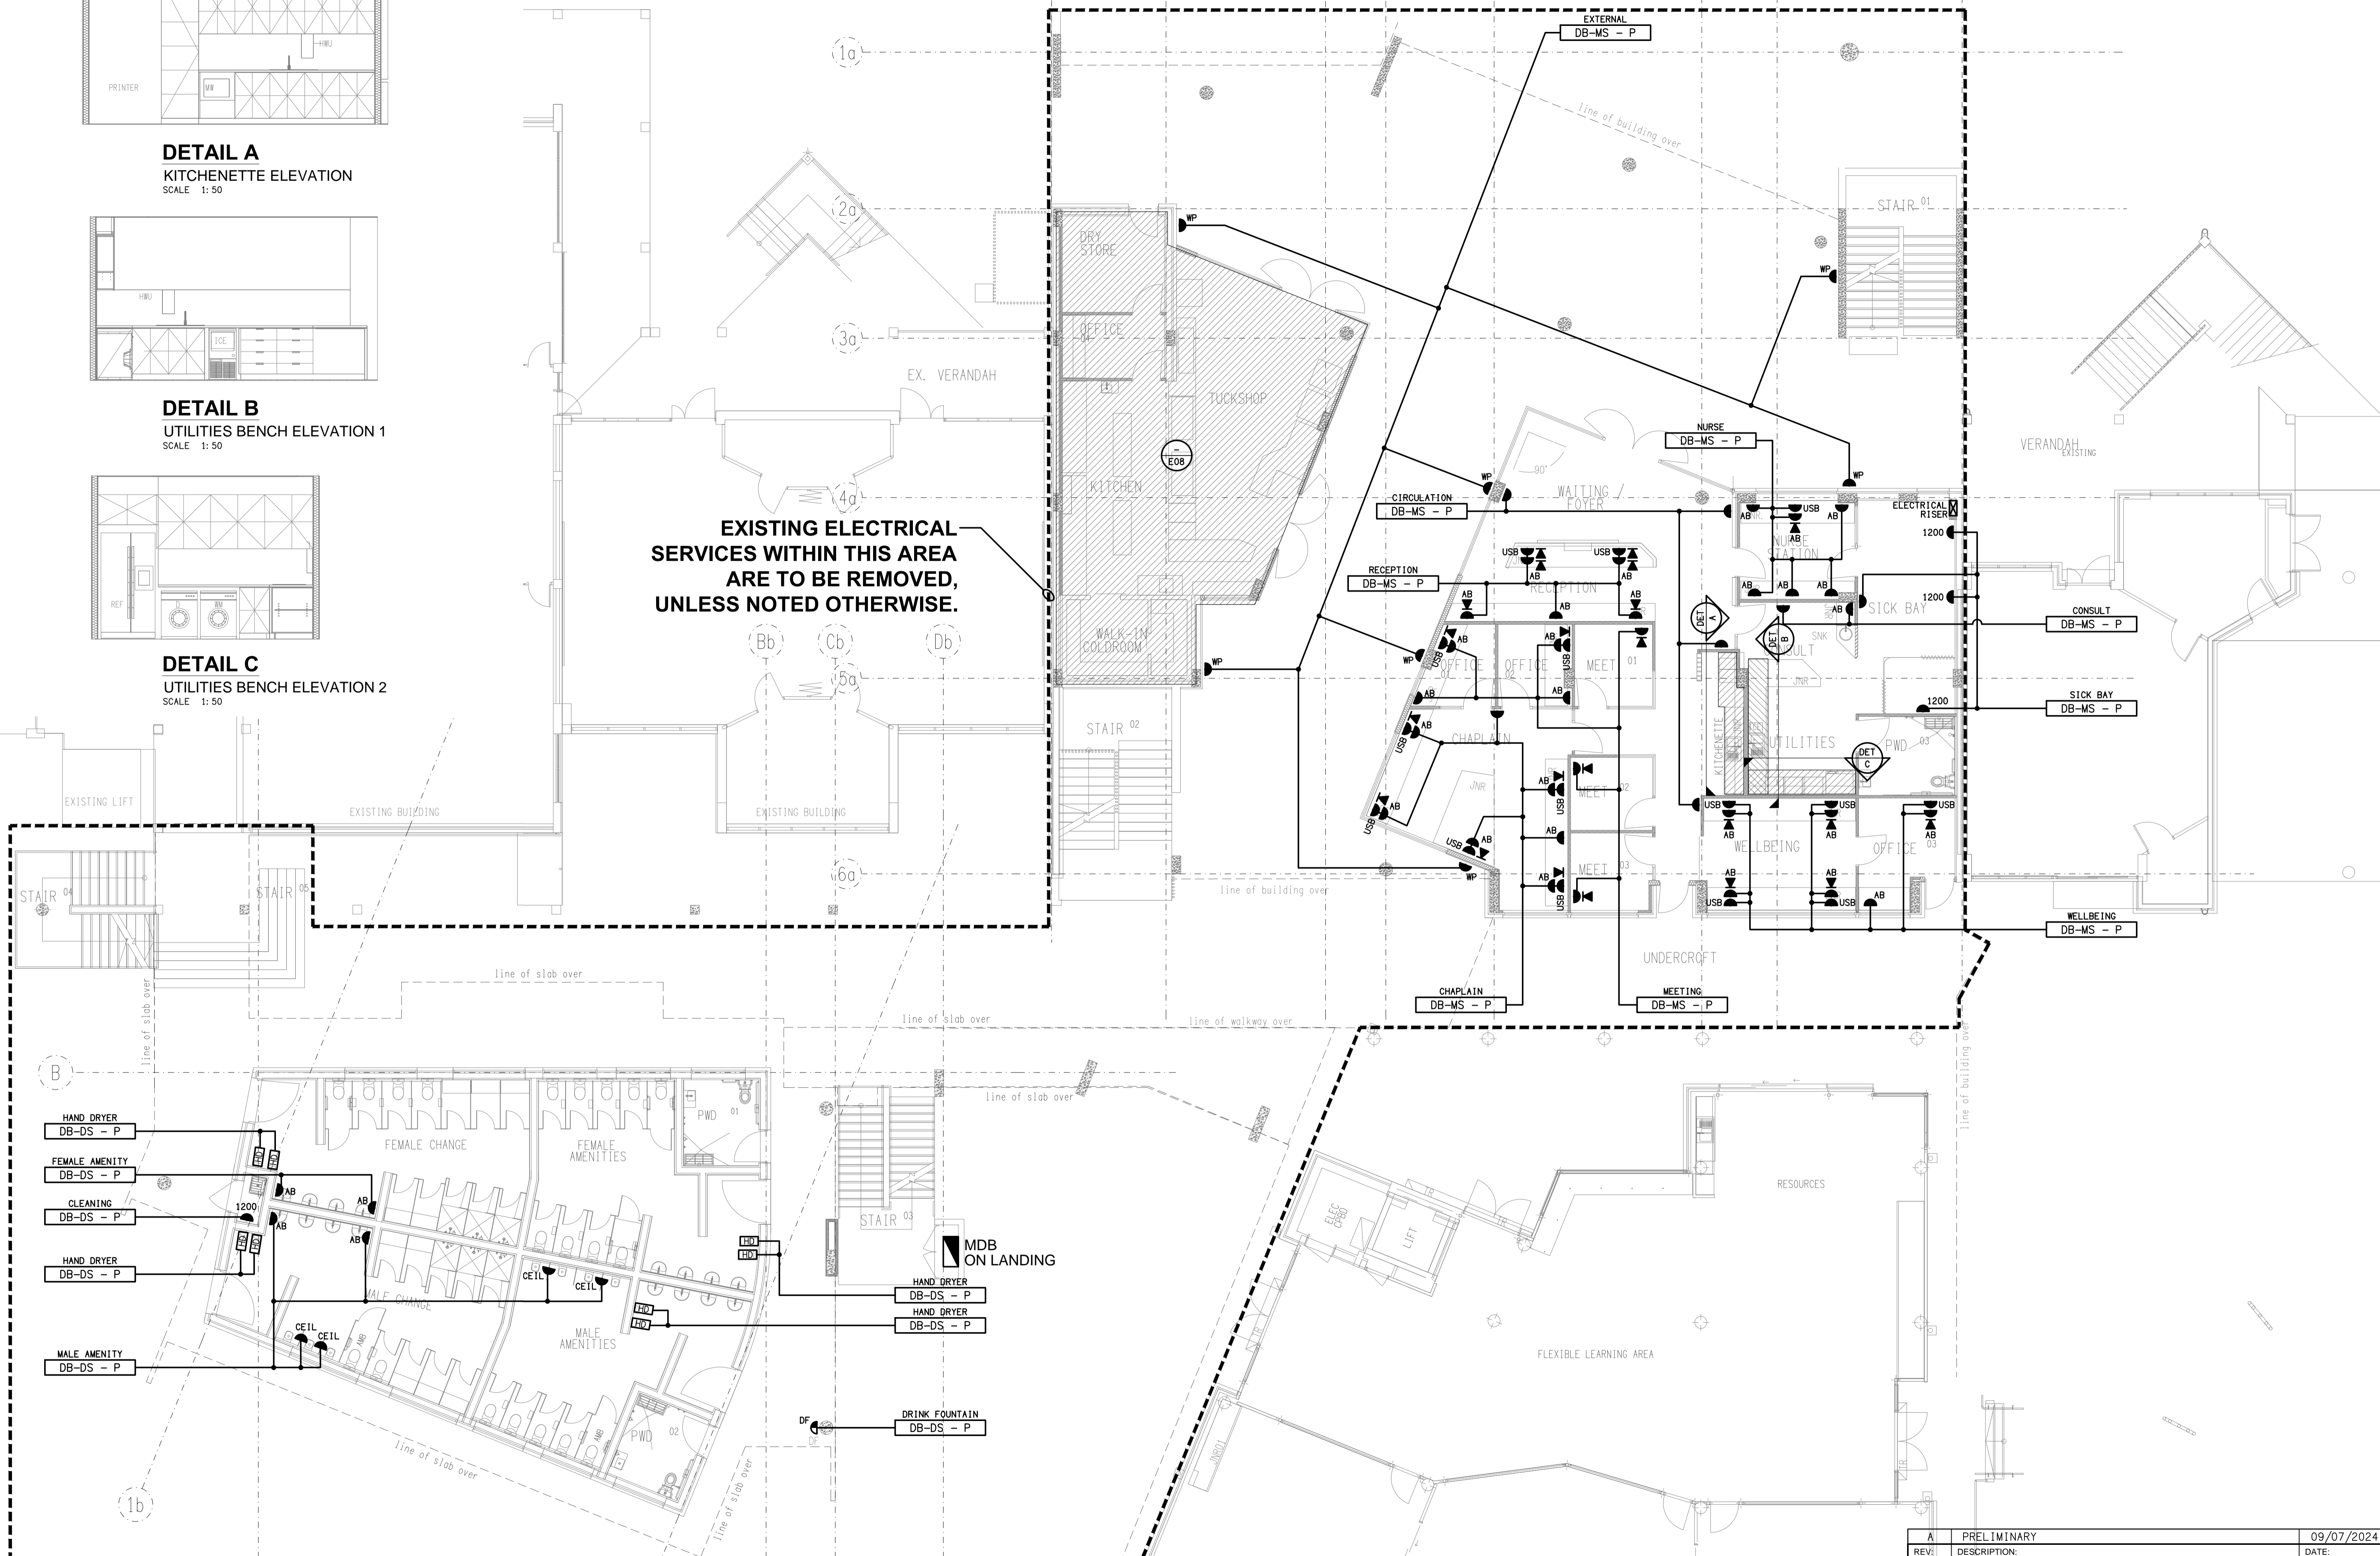

ELECTRICAL DESIGN GROUP BRISBANE PTY LTD
ACN 092 710 793
TRADING AS:
ELECTRICAL DESIGN GROUP

THE COPYRIGHT OF THIS DRAWING REMAINS THE PROPERTY OF THE ELECTRICAL DESIGN GROUP.
USE FIGURED DIMENSIONS IN REFERENCE TO SCALE.
ALL DIMENSIONS TO BE VERIFIED ONSITE.

ELECTRICAL DESIGN GROUP
ELECTRICAL BUILDING SERVICES CONSULTANTS
BRISBANE GOLD COAST
P.O. Box 15, Sherwood Q.4075
Phone: (07) 3278 4375
Email: brisbane@edg.net.au
Web: www.edg.net.au

PROJECT:
**KINGS CHRISTIAN COLLEGE - REEDY CREEK
GLAs & STUDENT SERVICES KCC49**
68 GEMVALE ROAD, REEDY CREEK, QUEENSLAND

REV: A	DESCRIPTION: PRELIMINARY	DATE: 09/07/2024
DRAWING: ELECTRICAL SERVICES GROUND LEVEL FLOOR PLAN		
SCALE: 1:100 UNO AT A1	PROJECT NO: C2717a	DRAWING NO: E06
		REVISION: A