



**DETAIL A**  
KITCHENETTE ELEVATION  
SCALE 1:50

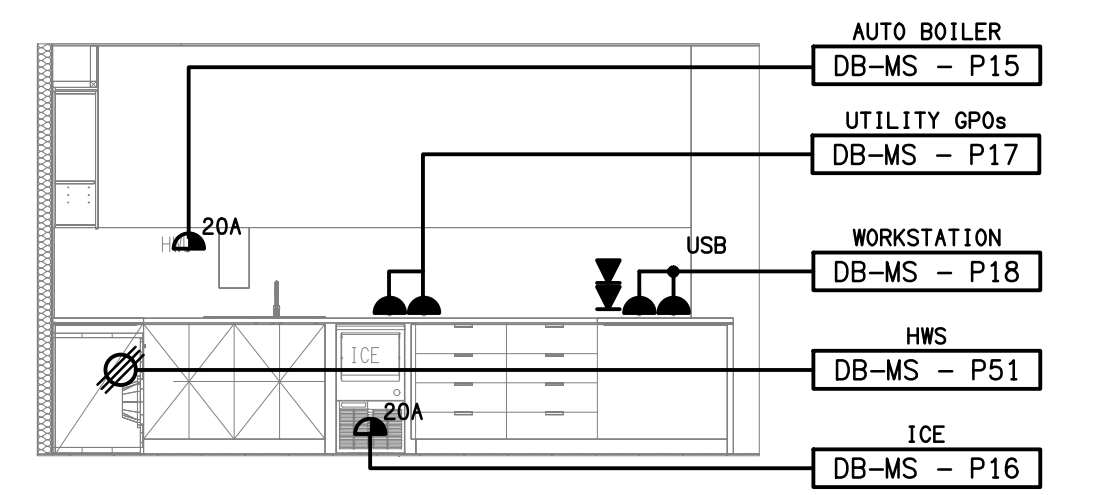


**DETAIL B**  
UTILITIES BENCH ELEVATION 1  
SCALE 1:50

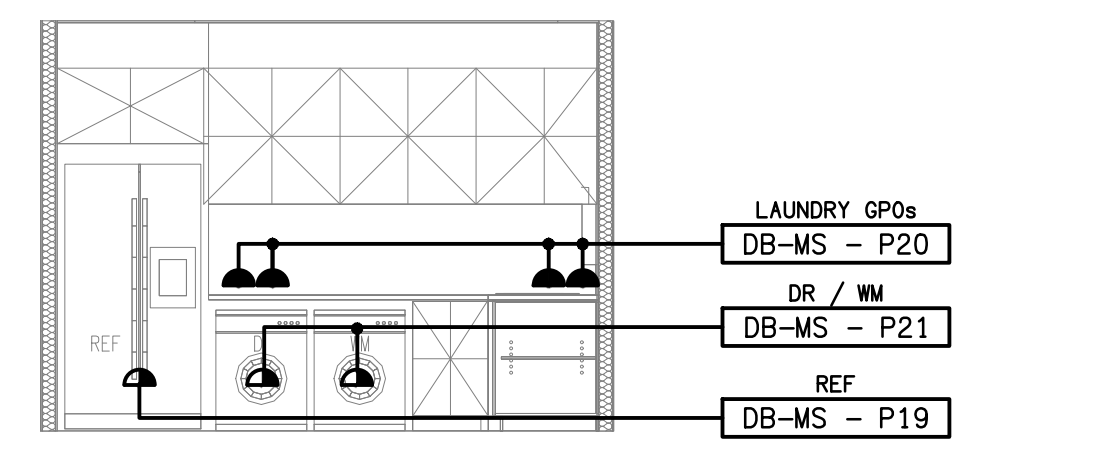

**DETAIL C**  
UTILITIES BENCH ELEVATION 2  
SCALE 1:50

**EXISTING ELECTRICAL SERVICES WITHIN THIS AREA ARE TO BE REMOVED, UNLESS NOTED OTHERWISE.**

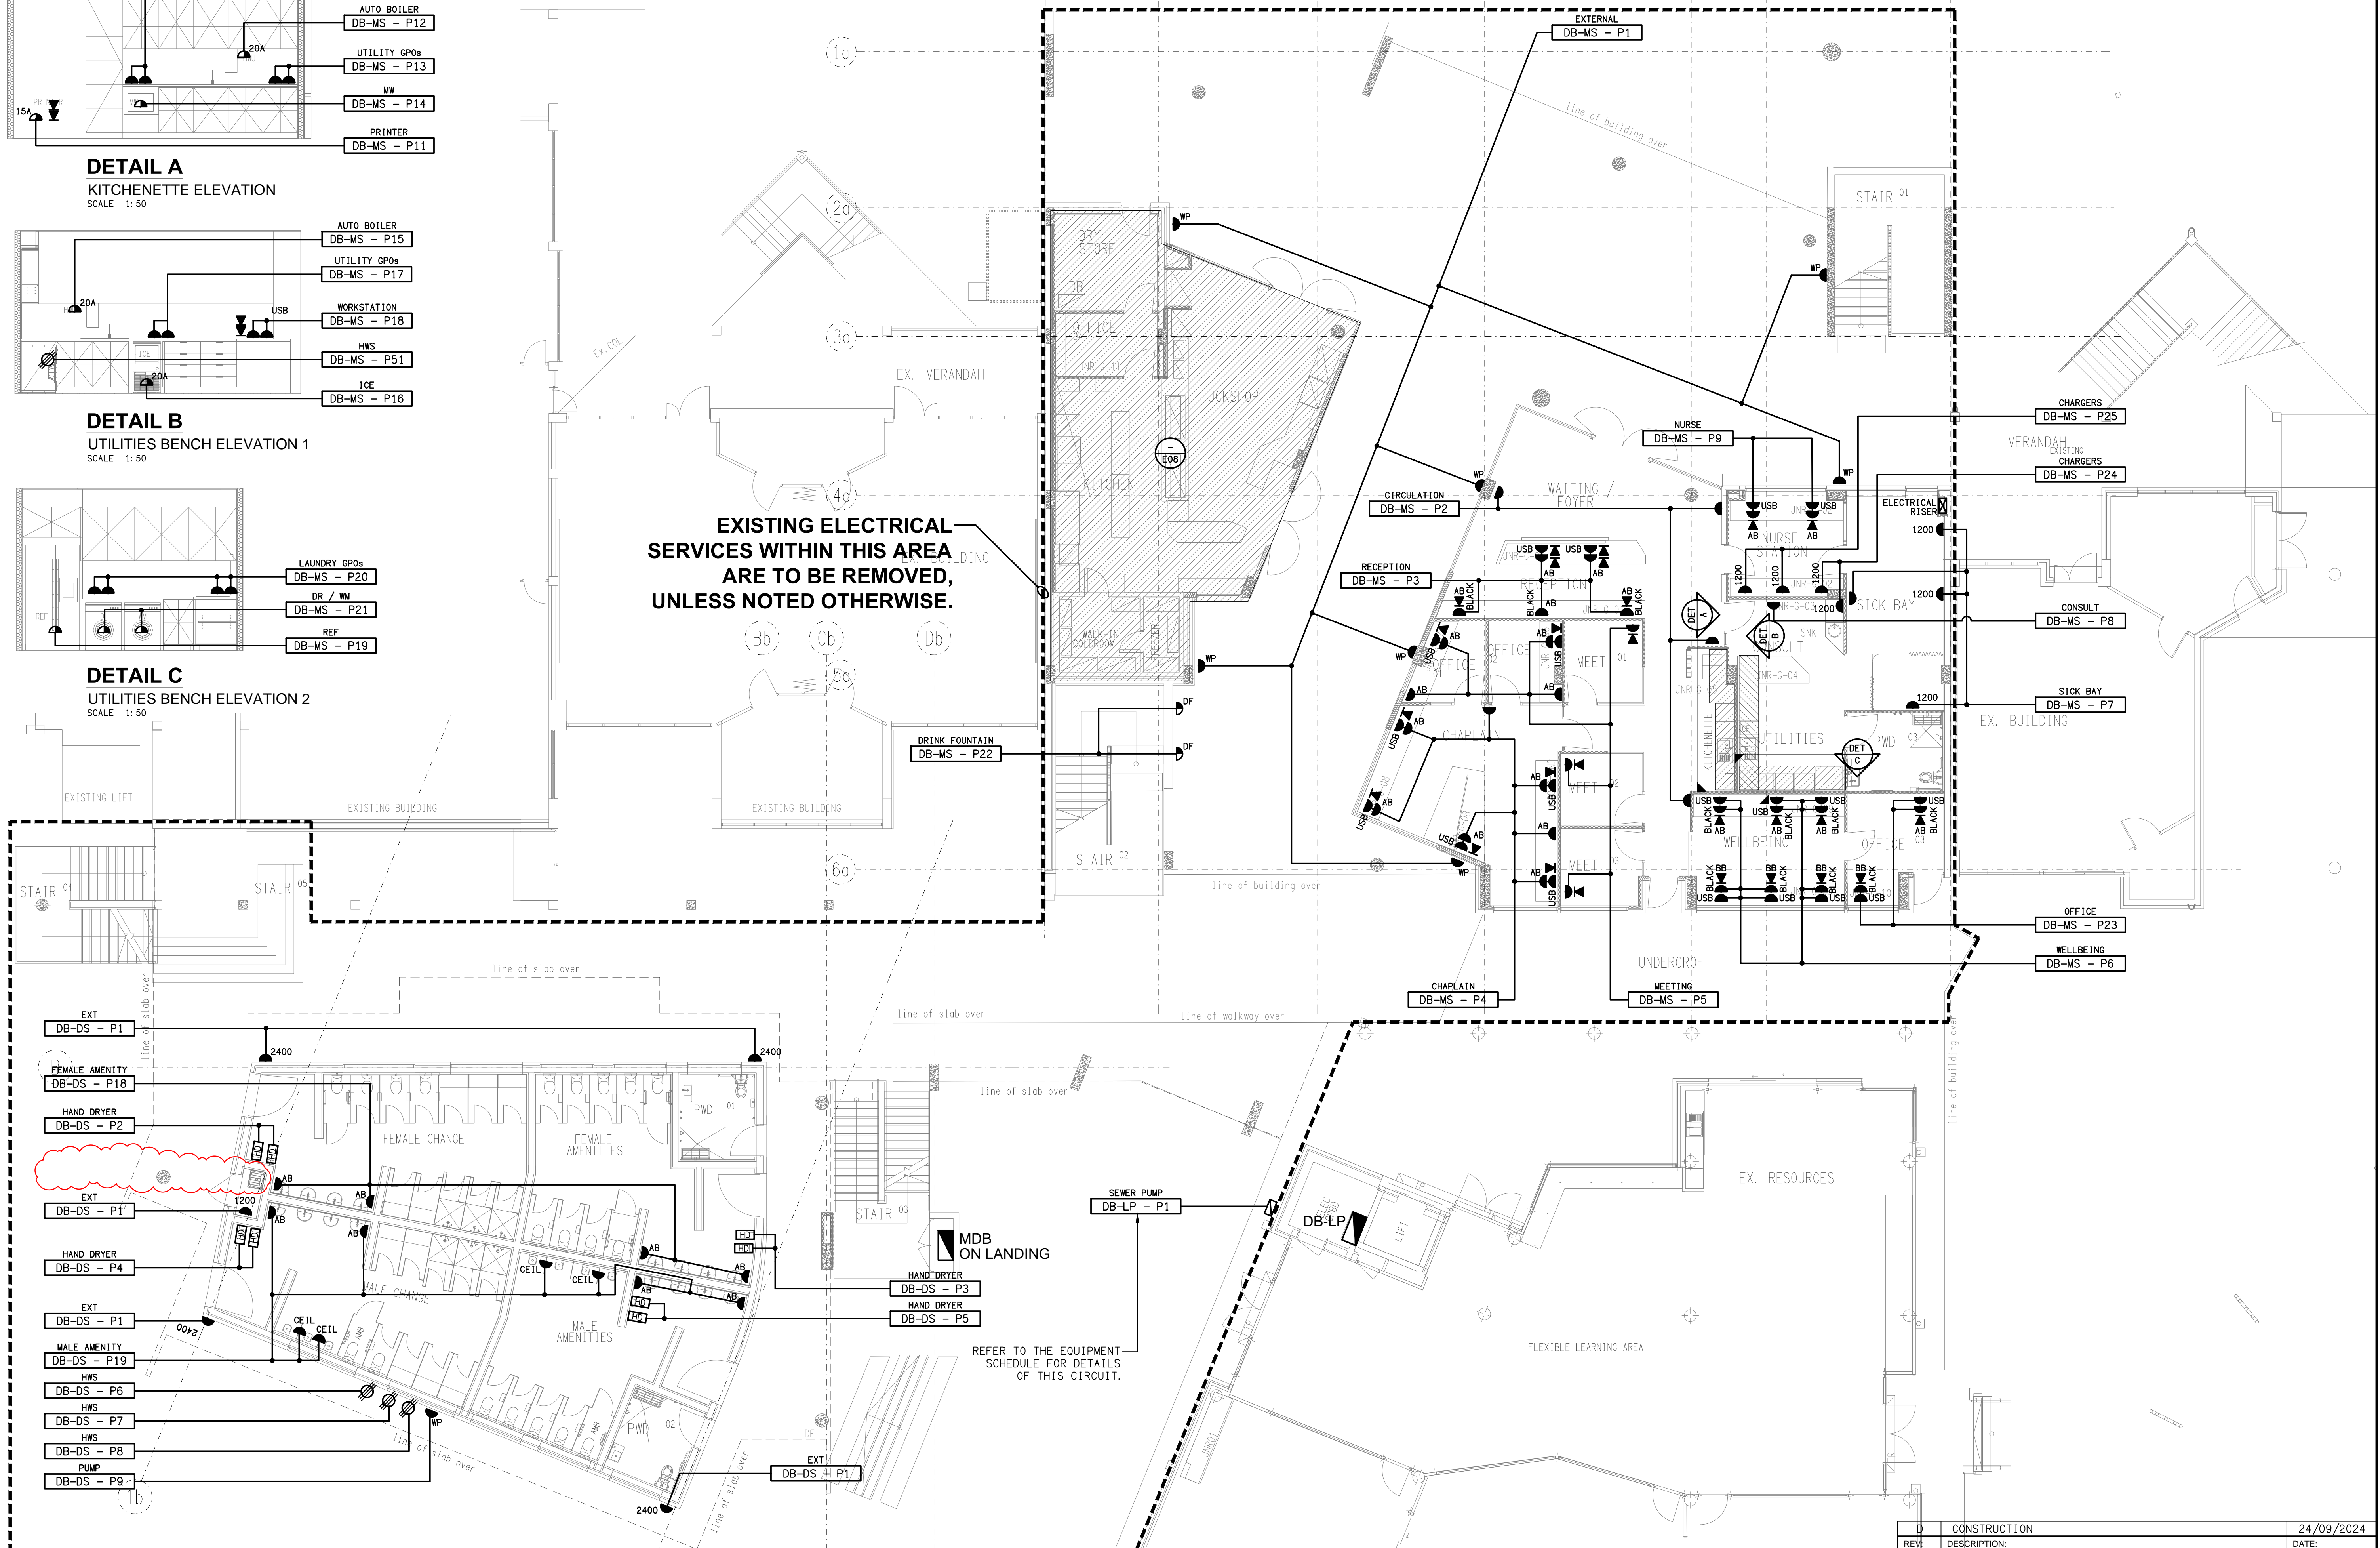

REFER TO THE EQUIPMENT SCHEDULE FOR DETAILS OF THIS CIRCUIT.

ELECTRICAL DESIGN GROUP BRISBANE  
PTY LTD  
ACN 092 710 793  
TRADING AS:  
ELECTRICAL DESIGN GROUP

THE COPYRIGHT OF THIS DRAWING  
REMAINS THE PROPERTY OF THE  
ELECTRICAL DESIGN GROUP.  
USE FIGURED DIMENSIONS  
IN PREFERENCE TO SCALE.  
ALL DIMENSIONS TO BE  
VERIFIED ONSITE.

**ELECTRICAL DESIGN GROUP**  
ELECTRICAL BUILDING SERVICES CONSULTANTS  
BRISBANE GOLD COAST  
P.O. Box 15, Sherwood Q. 4075  
Phone: (07) 3278 4375  
Email: brisbane@edg.net.au  
Web: www.edg.net.au

PROJECT:  
**KINGS CHRISTIAN COLLEGE - REEDY CREEK  
GLAs & STUDENT SERVICES KCC49**  
68 GEMVALE ROAD, REEDY CREEK, QUEENSLAND

D	CONSTRUCTION	24/09/2024
REV.	DESCRIPTION:	DATE:
DRAWING: <b>ELECTRICAL SERVICES GROUND LEVEL FLOOR PLAN</b>		
SCALE: 1:100 UNO	PROJECT NO: <b>C2717a</b>	DRAWING NO: <b>E06</b>
AT A1	REVISION: <b>D</b>	