



DETAIL A
STAFF KITCHENETTE ELEVATION
NOT TO SCALE

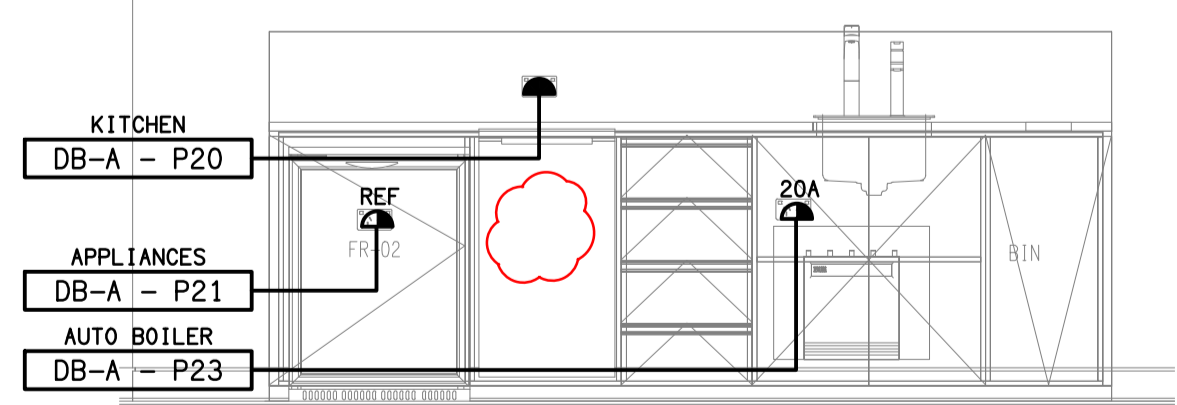

DETAIL B
LOUNGE KITCHENETTE ELEVATION
NOT TO SCALE

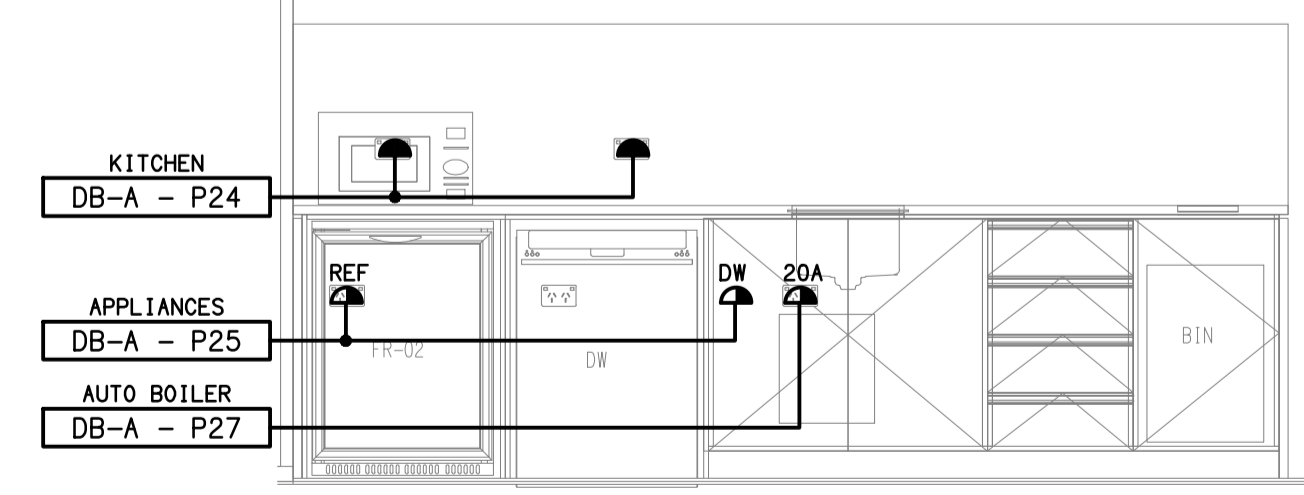

DETAIL C
SHOWROOM KITCHENETTE ELEVATION
NOT TO SCALE

ELECTRICAL DESIGN GROUP BRISBANE PTY LTD ACN 092 710 793 TRADING AS: ELECTRICAL DESIGN GROUP	THE COPYRIGHT OF THIS DRAWING REMAINS THE PROPERTY OF THE ELECTRICAL DESIGN GROUP. USE FIGURED DIMENSIONS IN PREFERENCE TO SCALE. ALL DIMENSIONS TO BE VERIFIED ONSITE.	ELECTRICAL DESIGN GROUP ELECTRICAL BUILDING SERVICES CONSULTANTS BRISBANE GOLD COAST P.O. Box 15, Sherwood Q.4075 Phone: (07) 3278 4375 Email: brisbane@edg.net.au Web: www.edg.net.au	PROJECT: KEEMA SPRINGWOOD ADDITIONAL SHOWROOMS	H CONSTRUCTION 18/07/2024 REV: DESCRIPTION: DATE:
			3519 PACIFIC HIGHWAY, SLACKS CREEK	DRAWING: ELECTRICAL SERVICES GROUND LEVEL FLOOR PLAN
SCALE: 1:100	PROJECT NO: C2857a	DRAWING NO: E04	REVISION: H	AT A1