



NORTH
EXTERNAL BUILDING ELEVATION
SCALE 1:200

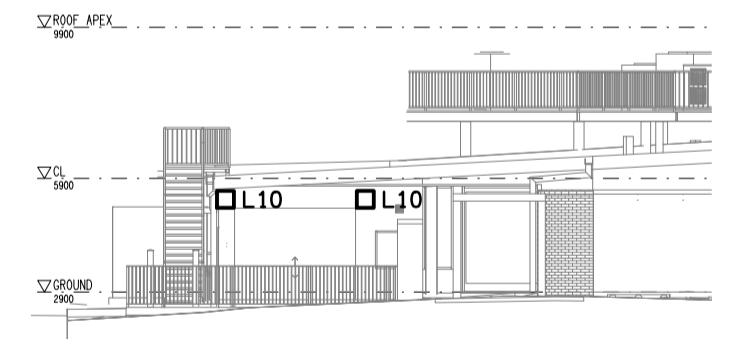

SOUTH
EXTERNAL BUILDING ELEVATION
SCALE 1:200

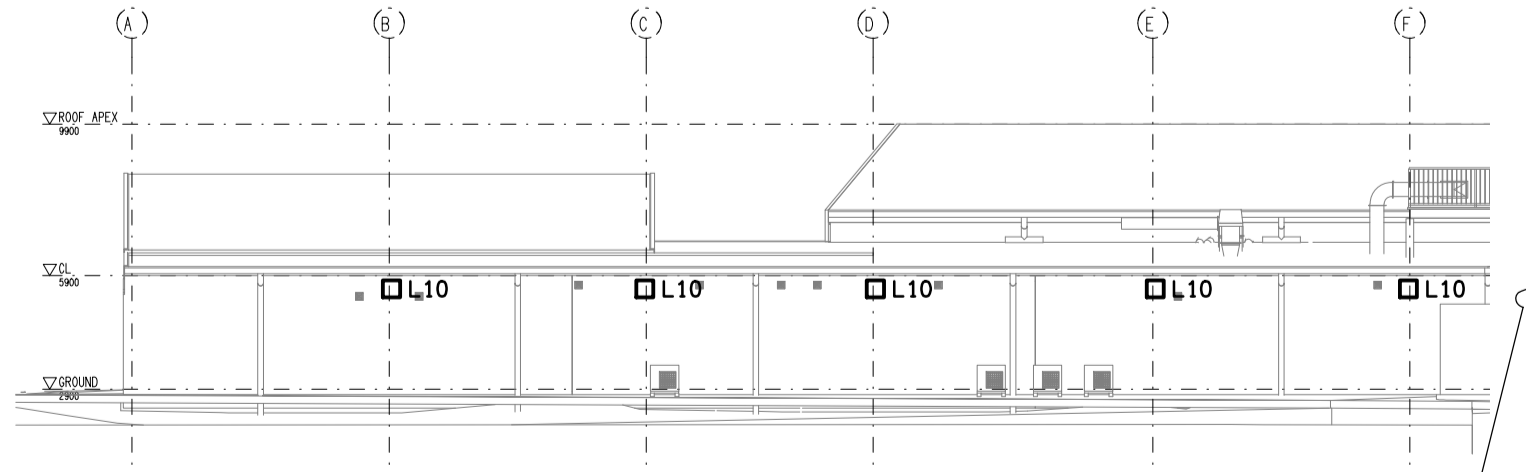

WEST
EXTERNAL BUILDING ELEVATION
SCALE 1:200

ELECTRICAL DESIGN GROUP BRISBANE
PTY LTD
ACN 092 710 793
TRADING AS:
ELECTRICAL DESIGN GROUP

THE COPYRIGHT OF THIS DRAWING
REMAINS THE PROPERTY OF THE
ELECTRICAL DESIGN GROUP.
USE FIGURED DIMENSIONS
IN PREFERENCE TO SCALE.
ALL DIMENSIONS TO BE
VERIFIED ONSITE.

ELECTRICAL DESIGN GROUP
ELECTRICAL BUILDING SERVICES CONSULTANTS
BRISBANE GOLD COAST

P.O. Box 15, Sherwood Q.4075
Phone: (07) 3278 4375
Email: brisbane@edg.net.au
Web: www.edg.net.au

PROJECT:
**DRY DOCK ROAD HOTEL,
TWEED HEADS SOUTH**
CORNER DOCK ROAD & FRASER DRIVE, NEW SOUTH WALES

B	PRELIMINARY	31/05/2024
REV:	DESCRIPTION:	DATE:

DRAWING:
**ELECTRICAL SERVICES
HOTEL JOINERY LIGHTING PLAN**

SCALE: 1:100 UNO	AT A1	PROJECT NO: C2864a	DRAWING NO: E07	REVISION: B
---------------------	-------	------------------------------	---------------------------	-----------------------