


**SITE PLAN**  
WAREHOUSE 1 & 2  
SCALE 1:250

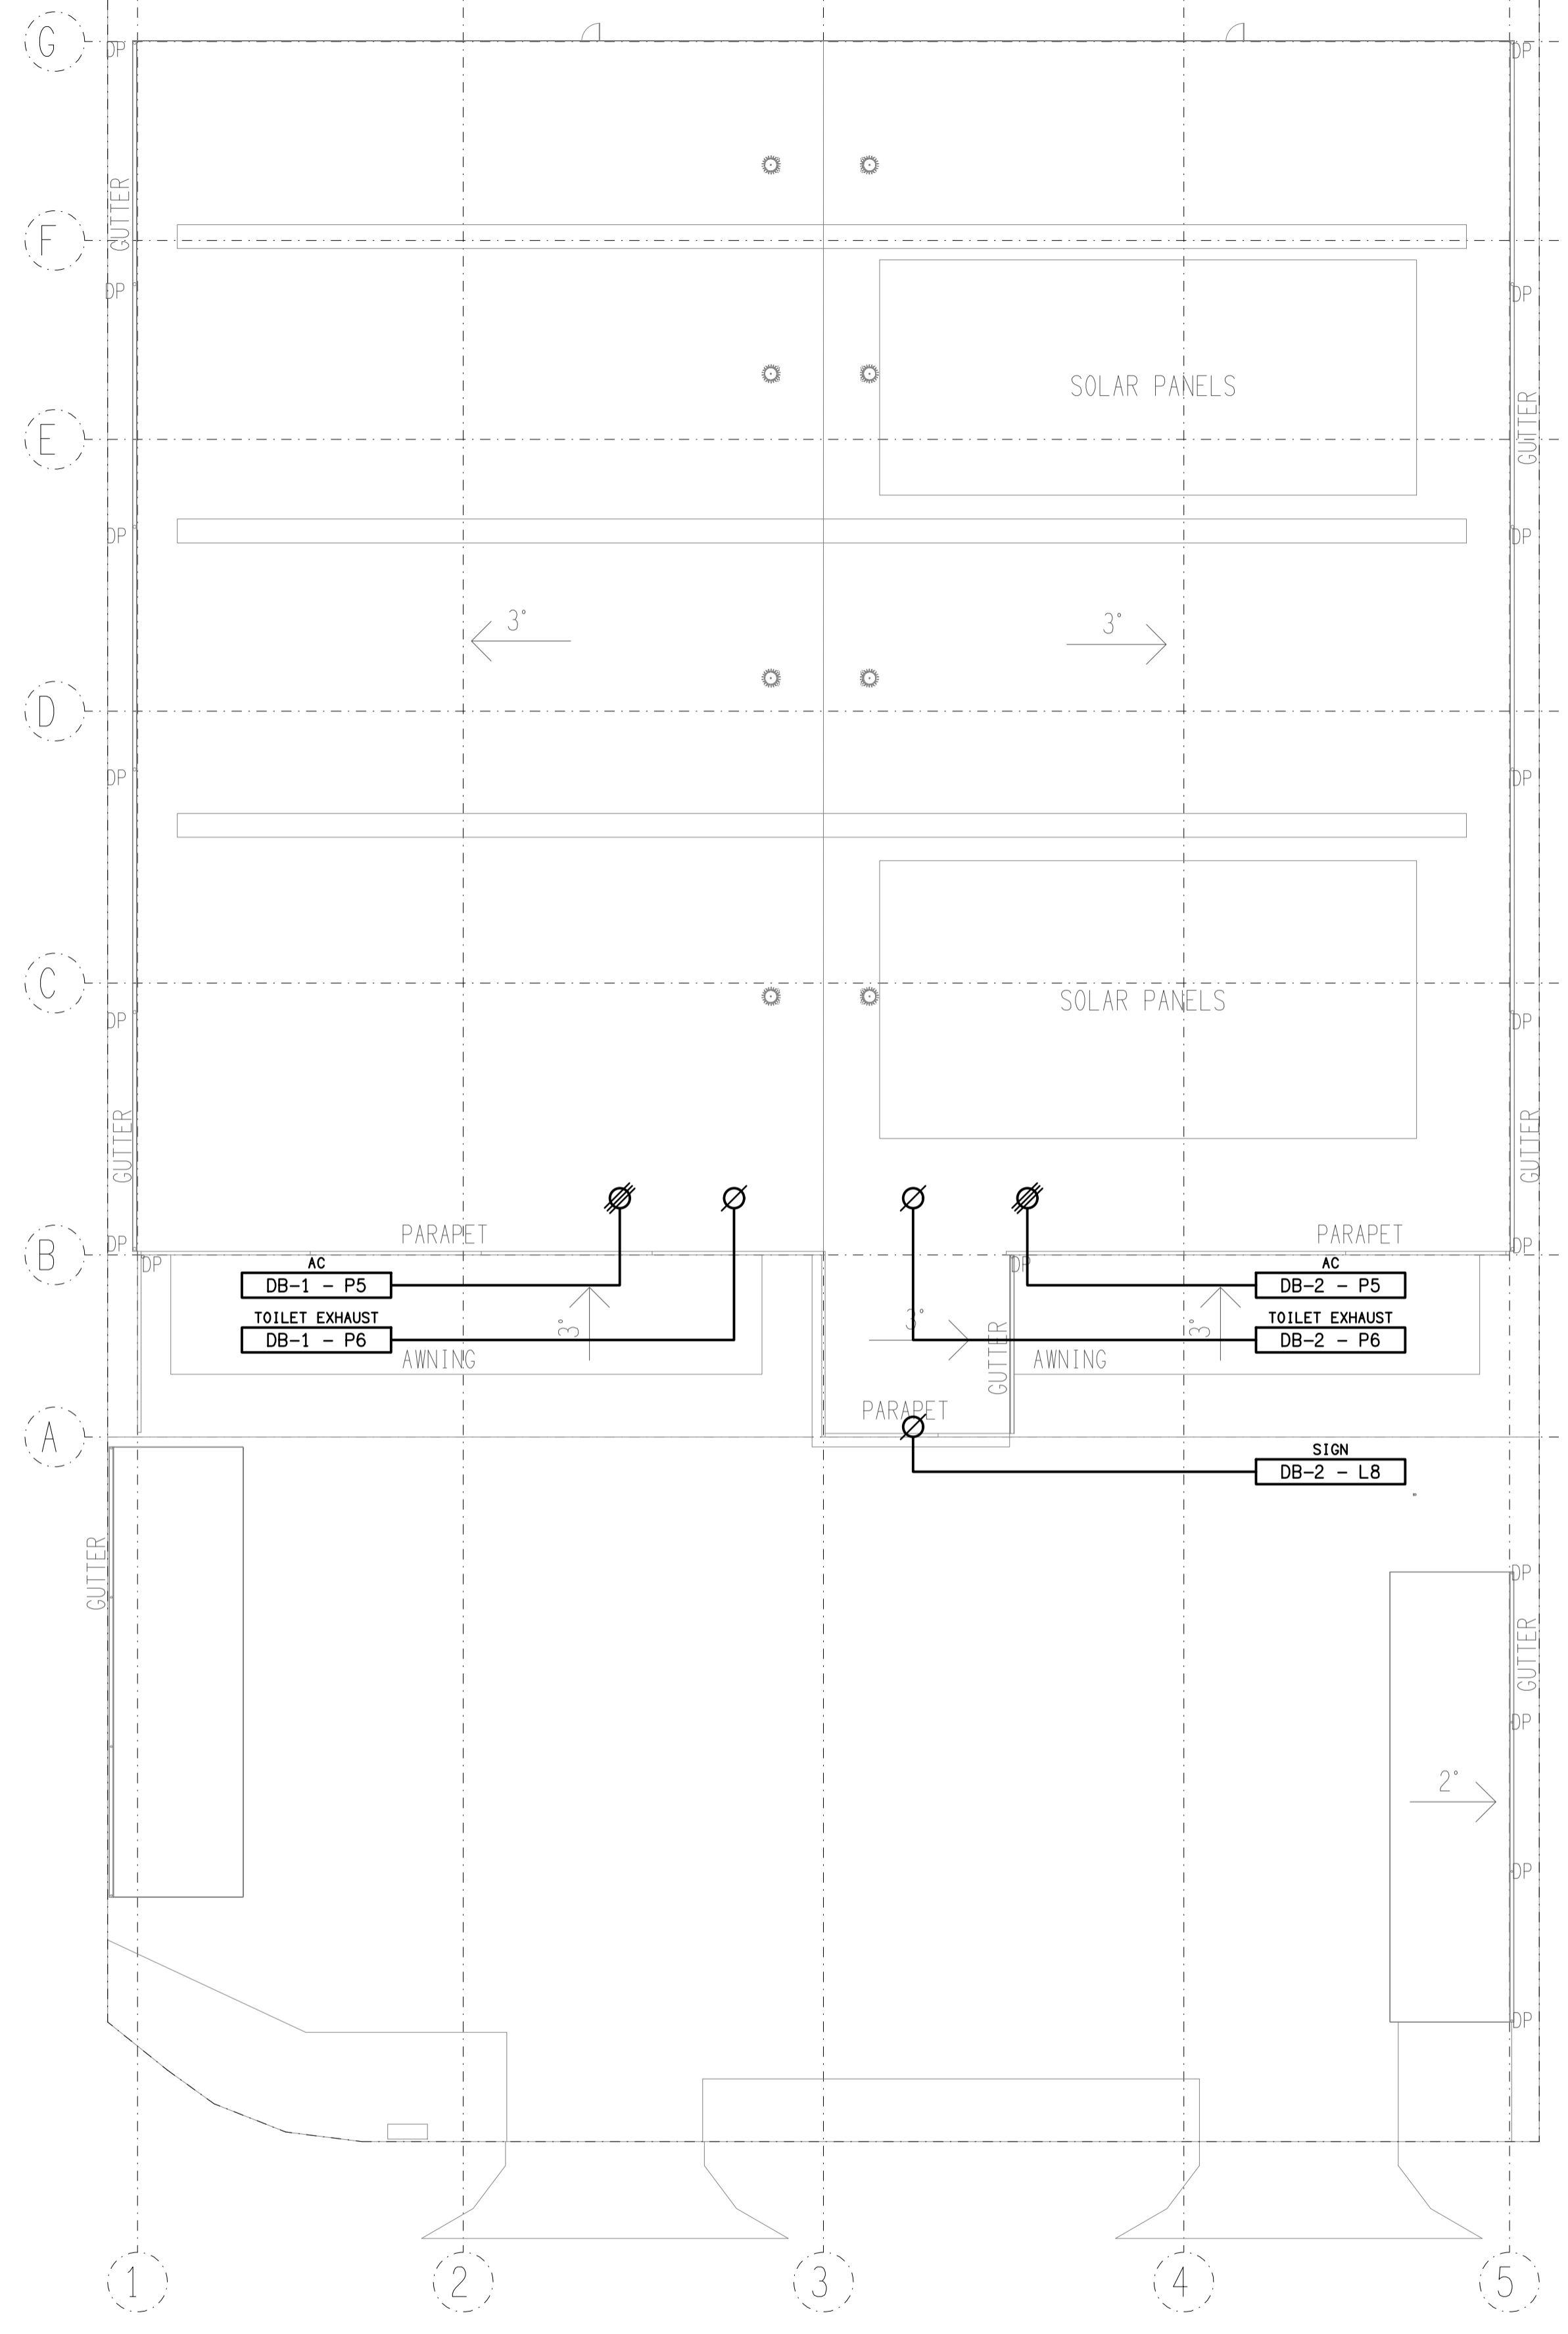

**ROOF PLAN**  
WAREHOUSE 1 & 2  
SCALE 1:250

ELECTRICAL DESIGN GROUP BRISBANE  
PTY LTD  
ACN 092 710 793  
TRADING AS:  
ELECTRICAL DESIGN GROUP

THE COPYRIGHT OF THIS DRAWING  
REMAINS THE PROPERTY OF THE  
ELECTRICAL DESIGN GROUP.  
USE FIGURED DIMENSIONS  
IN PREFERENCE TO SCALE.  
ALL DIMENSIONS TO BE  
VERIFIED ONSITE.

**ELECTRICAL DESIGN GROUP**  
ELECTRICAL BUILDING SERVICES CONSULTANTS  
BRISBANE GOLD COAST

P.O. Box 15, Sherwood Q.4075  
Phone: (07) 3278 4375  
Email: brisbane@edg.net.au  
Web: www.edg.net.au

PROJECT:  
**BURNSIDE ROAD, GILBERTON**  
LOT 4 BURNSIDE ROAD, GILBERTON, QUEENSLAND

H	CONSTRUCTION	25/09/2024
REV.	DESCRIPTION:	DATE:

DRAWING:  
**ELECTRICAL SERVICES  
SITE PLAN & ROOF PLAN**

SCALE: 1:250	AT A1	PROJECT NO: <b>C2964a</b>	DRAWING NO: <b>E03</b>	REVISION: <b>H</b>
-----------------	-------	------------------------------	---------------------------	-----------------------