



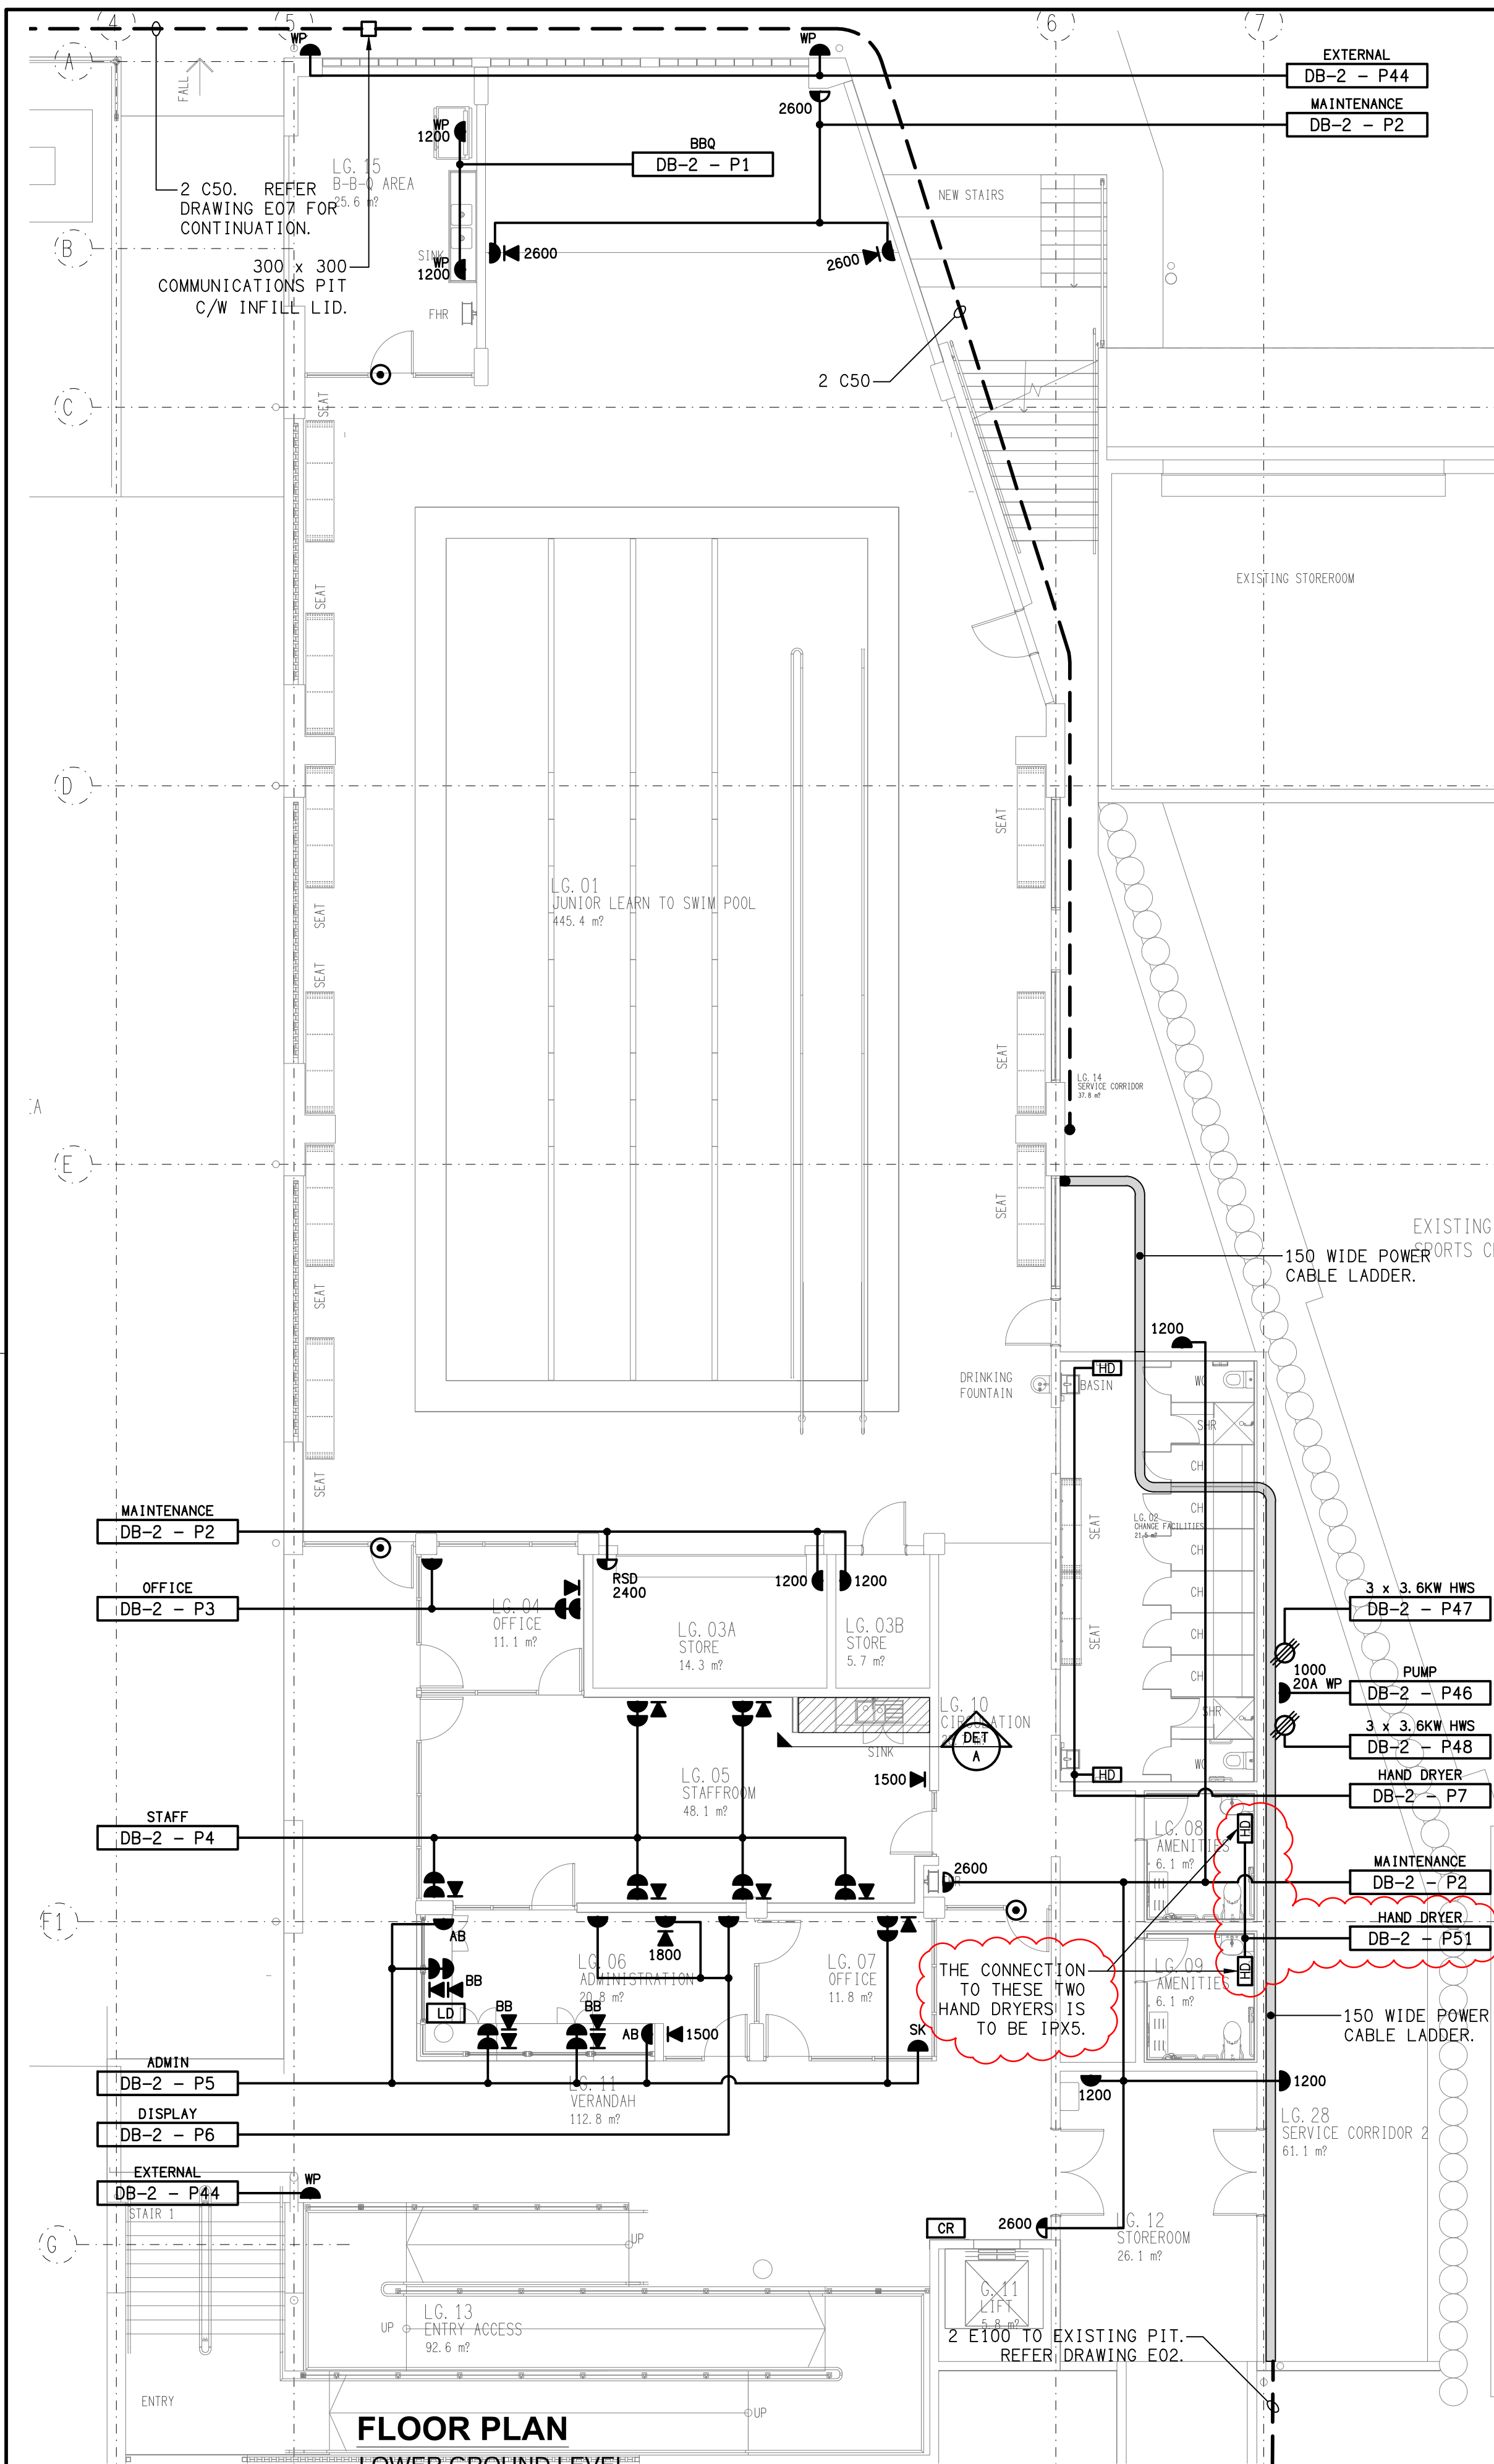


FLOOR PLAN
LOWER GROUND LEVEL
SCALE 1: 100

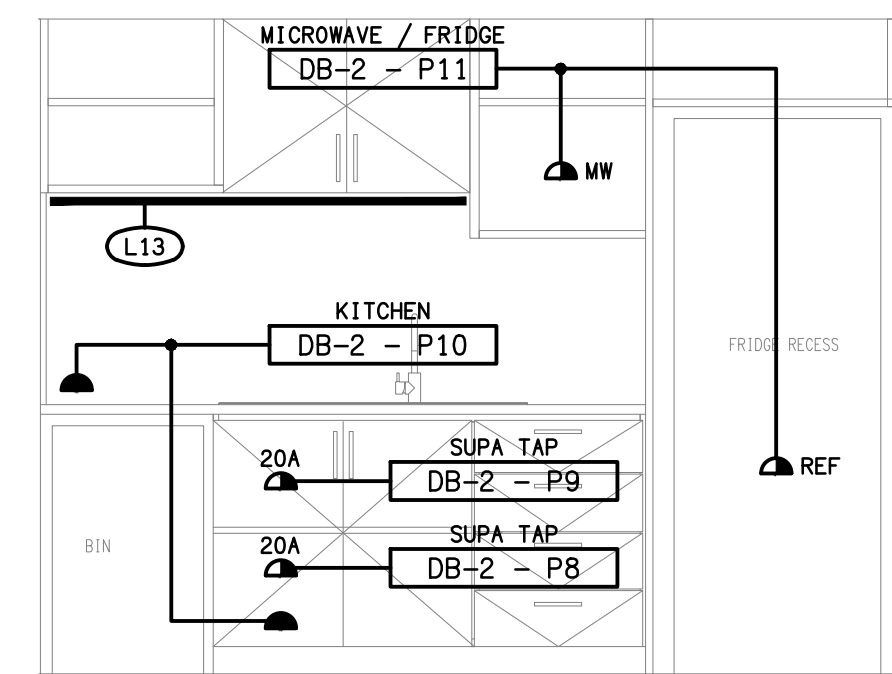

DETAIL A
STAFF ROOM KITCHENETTE ELEVATION
SCALE 1: 25

NOTE THAT CHANGES MADE AT REVISIONS (K) AND (L) ARE ALL SHOWN CLOUDED ON THIS DRAWING.

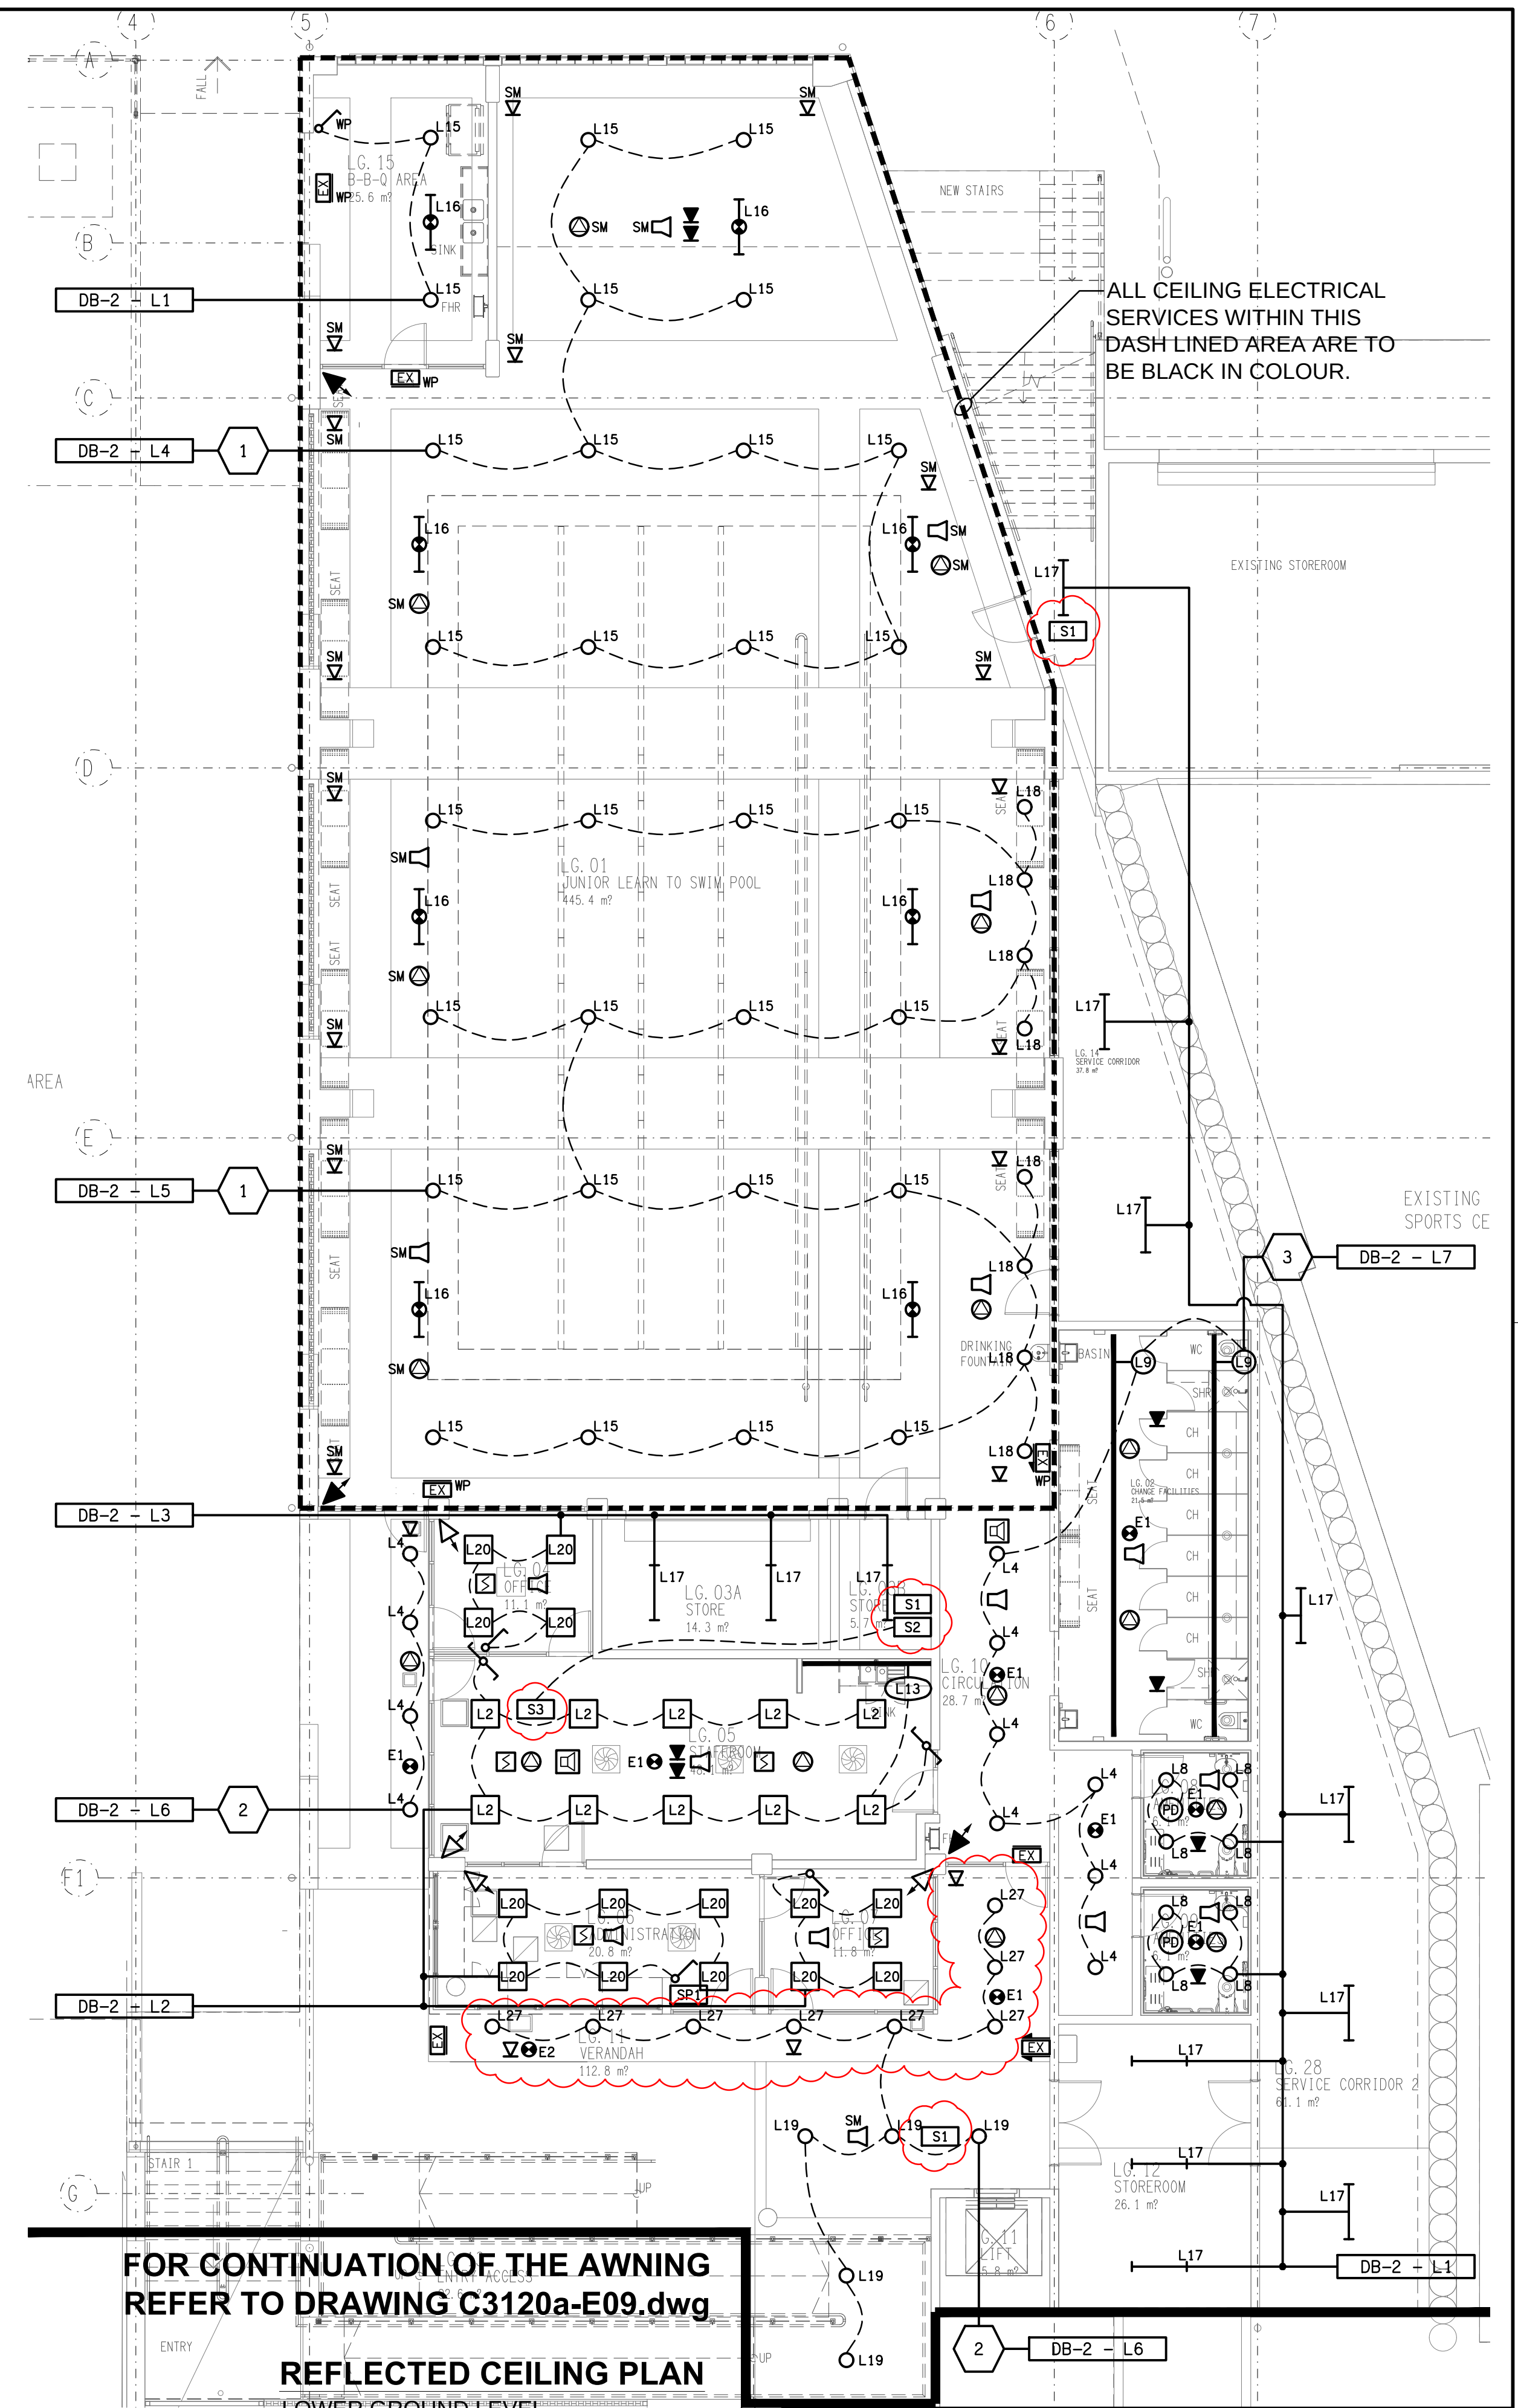

**FOR CONTINUATION OF THE AWNING
REFER TO DRAWING C3120a-E09.dwg**

REFLECTED CEILING PLAN
LOWER GROUND LEVEL
SCALE 1: 100

ELECTRICAL DESIGN GROUP BRISBANE PTY LTD ACN 092 710 793 TRADING AS: ELECTRICAL DESIGN GROUP	THE COPYRIGHT OF THIS DRAWING REMAINS THE PROPERTY OF THE ELECTRICAL DESIGN GROUP. USE FIGURED DIMENSIONS IN PREFERENCE TO SCALE. ALL DIMENSIONS TO BE VERIFIED ONSITE.	ELECTRICAL DESIGN GROUP ELECTRICAL BUILDING SERVICES CONSULTANTS BRISBANE GOLD COAST P.O.Box 15, Sherwood Q.4075 Phone: (07) 3278 4375 Email: brisbane@edg.net.au Web: www.edg.net.au	PROJECT: ST JOHN'S ANGLICAN COLLEGE FOREST LAKE AQUATIC CENTRE STAGE 1 COLLEGE AVENUE, FOREST LAKE	DRAWING: ELECTRICAL SERVICES AQUATIC CENTRE LOWER GROUND PLANS SCALE: 1:100 AT A1 PROJECT NO: C3120a DRAWING NO: E03 REVISION: L
--	--	--	---	---