


**DETAIL A**  
STAFF ROOM KITCHENETTE ELEVATION  
SCALE 1:25

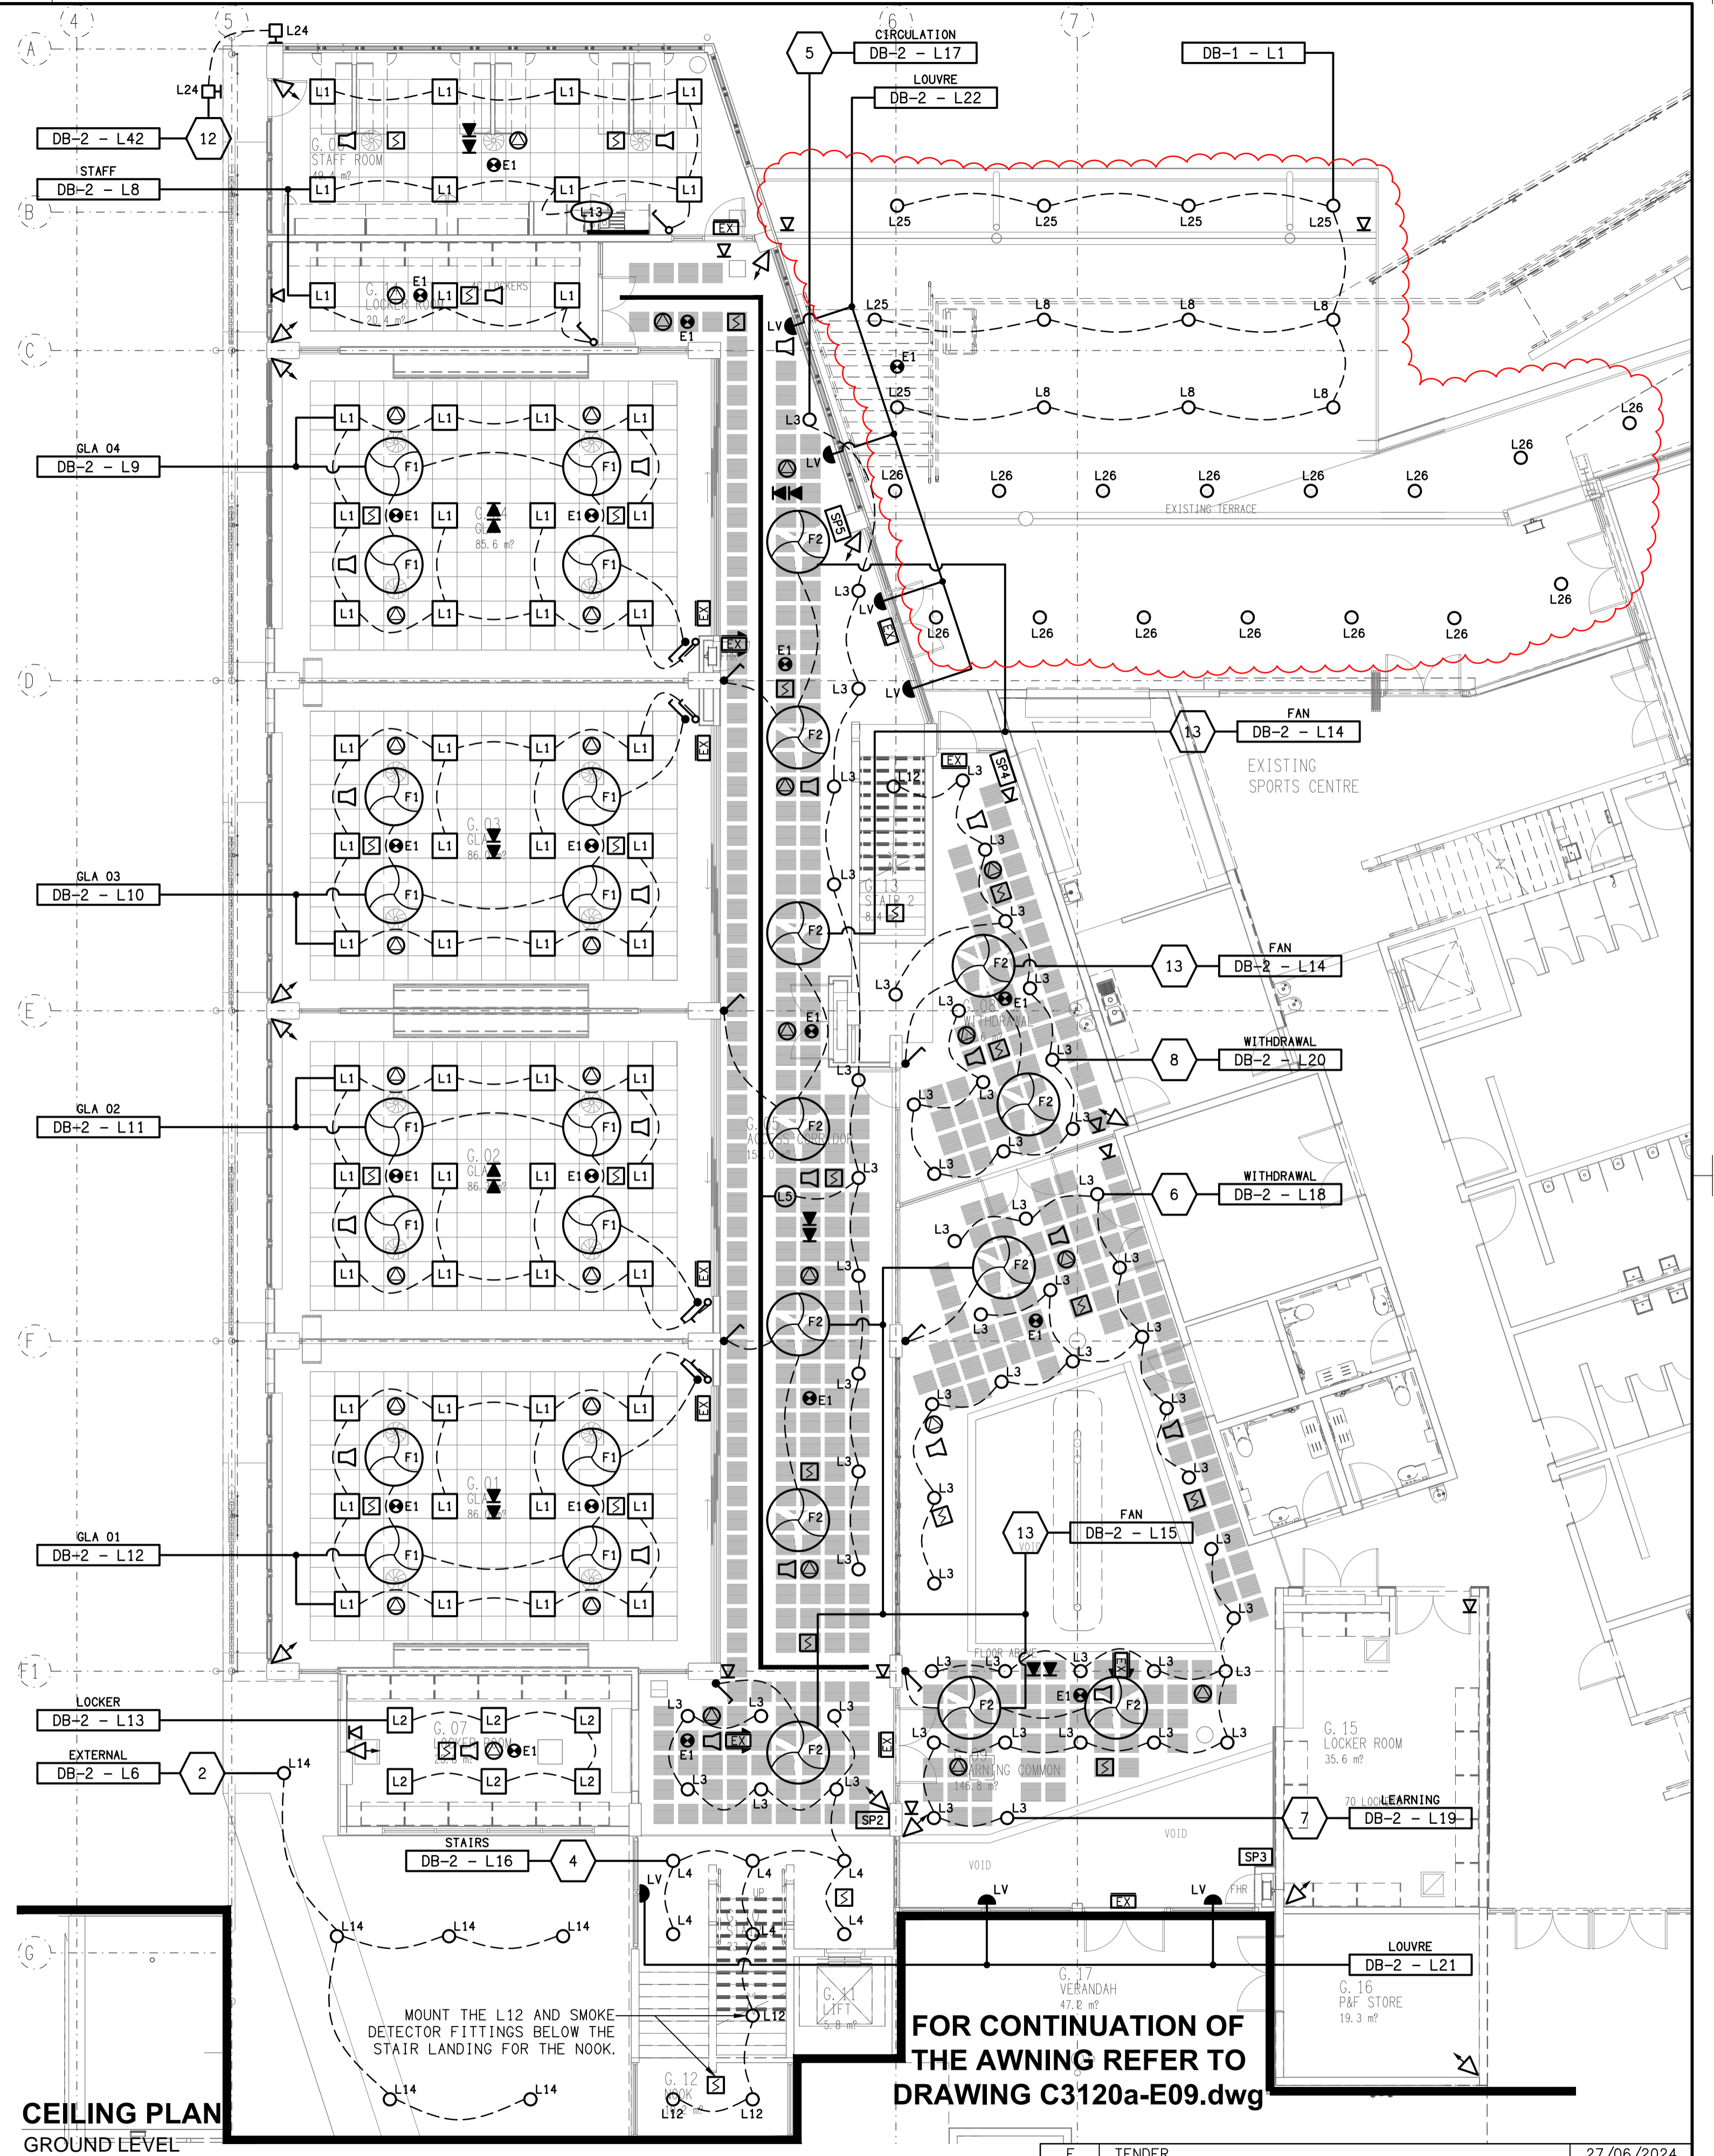

**CEILING PLAN**  
GROUND LEVEL  
SCALE 1:100

**FLOOR PLAN**  
GROUND LEVEL  
SCALE 1:100

ELECTRICAL DESIGN GROUP BRISBANE  
PTY LTD  
ACN 092 710 793  
TRADING AS:  
ELECTRICAL DESIGN GROUP

THE COPYRIGHT OF THIS DRAWING  
REMAINS THE PROPERTY OF THE  
ELECTRICAL DESIGN GROUP.  
USE FIGURED DIMENSIONS  
IN REFERENCE TO SCALE.  
ALL DIMENSIONS TO BE  
VERIFIED ONSITE.

**ELECTRICAL DESIGN GROUP**  
ELECTRICAL BUILDING SERVICES CONSULTANTS  
BRISBANE GOLD COAST  
P.O. Box 15, Sherwood Q.4075  
Phone: (07) 3278 4375  
Email: brisbane@edg.net.au  
Web: www.edg.net.au

PROJECT:  
**ST JOHN'S ANGLICAN COLLEGE  
FOREST LAKE  
AQUATIC CENTRE STAGE 1  
COLLEGE AVENUE, FOREST LAKE**

E	TENDER	27/06/2024
REV:	DESCRIPTION:	DATE:
DRAWING: <b>ELECTRICAL SERVICES AQUATIC CENTRE GROUND LEVEL PLANS</b>		
SCALE: 1:100	AT A1	PROJECT NO: <b>C3120a</b>
		DRAWING NO: <b>E04</b>
		REVISION: <b>E</b>