



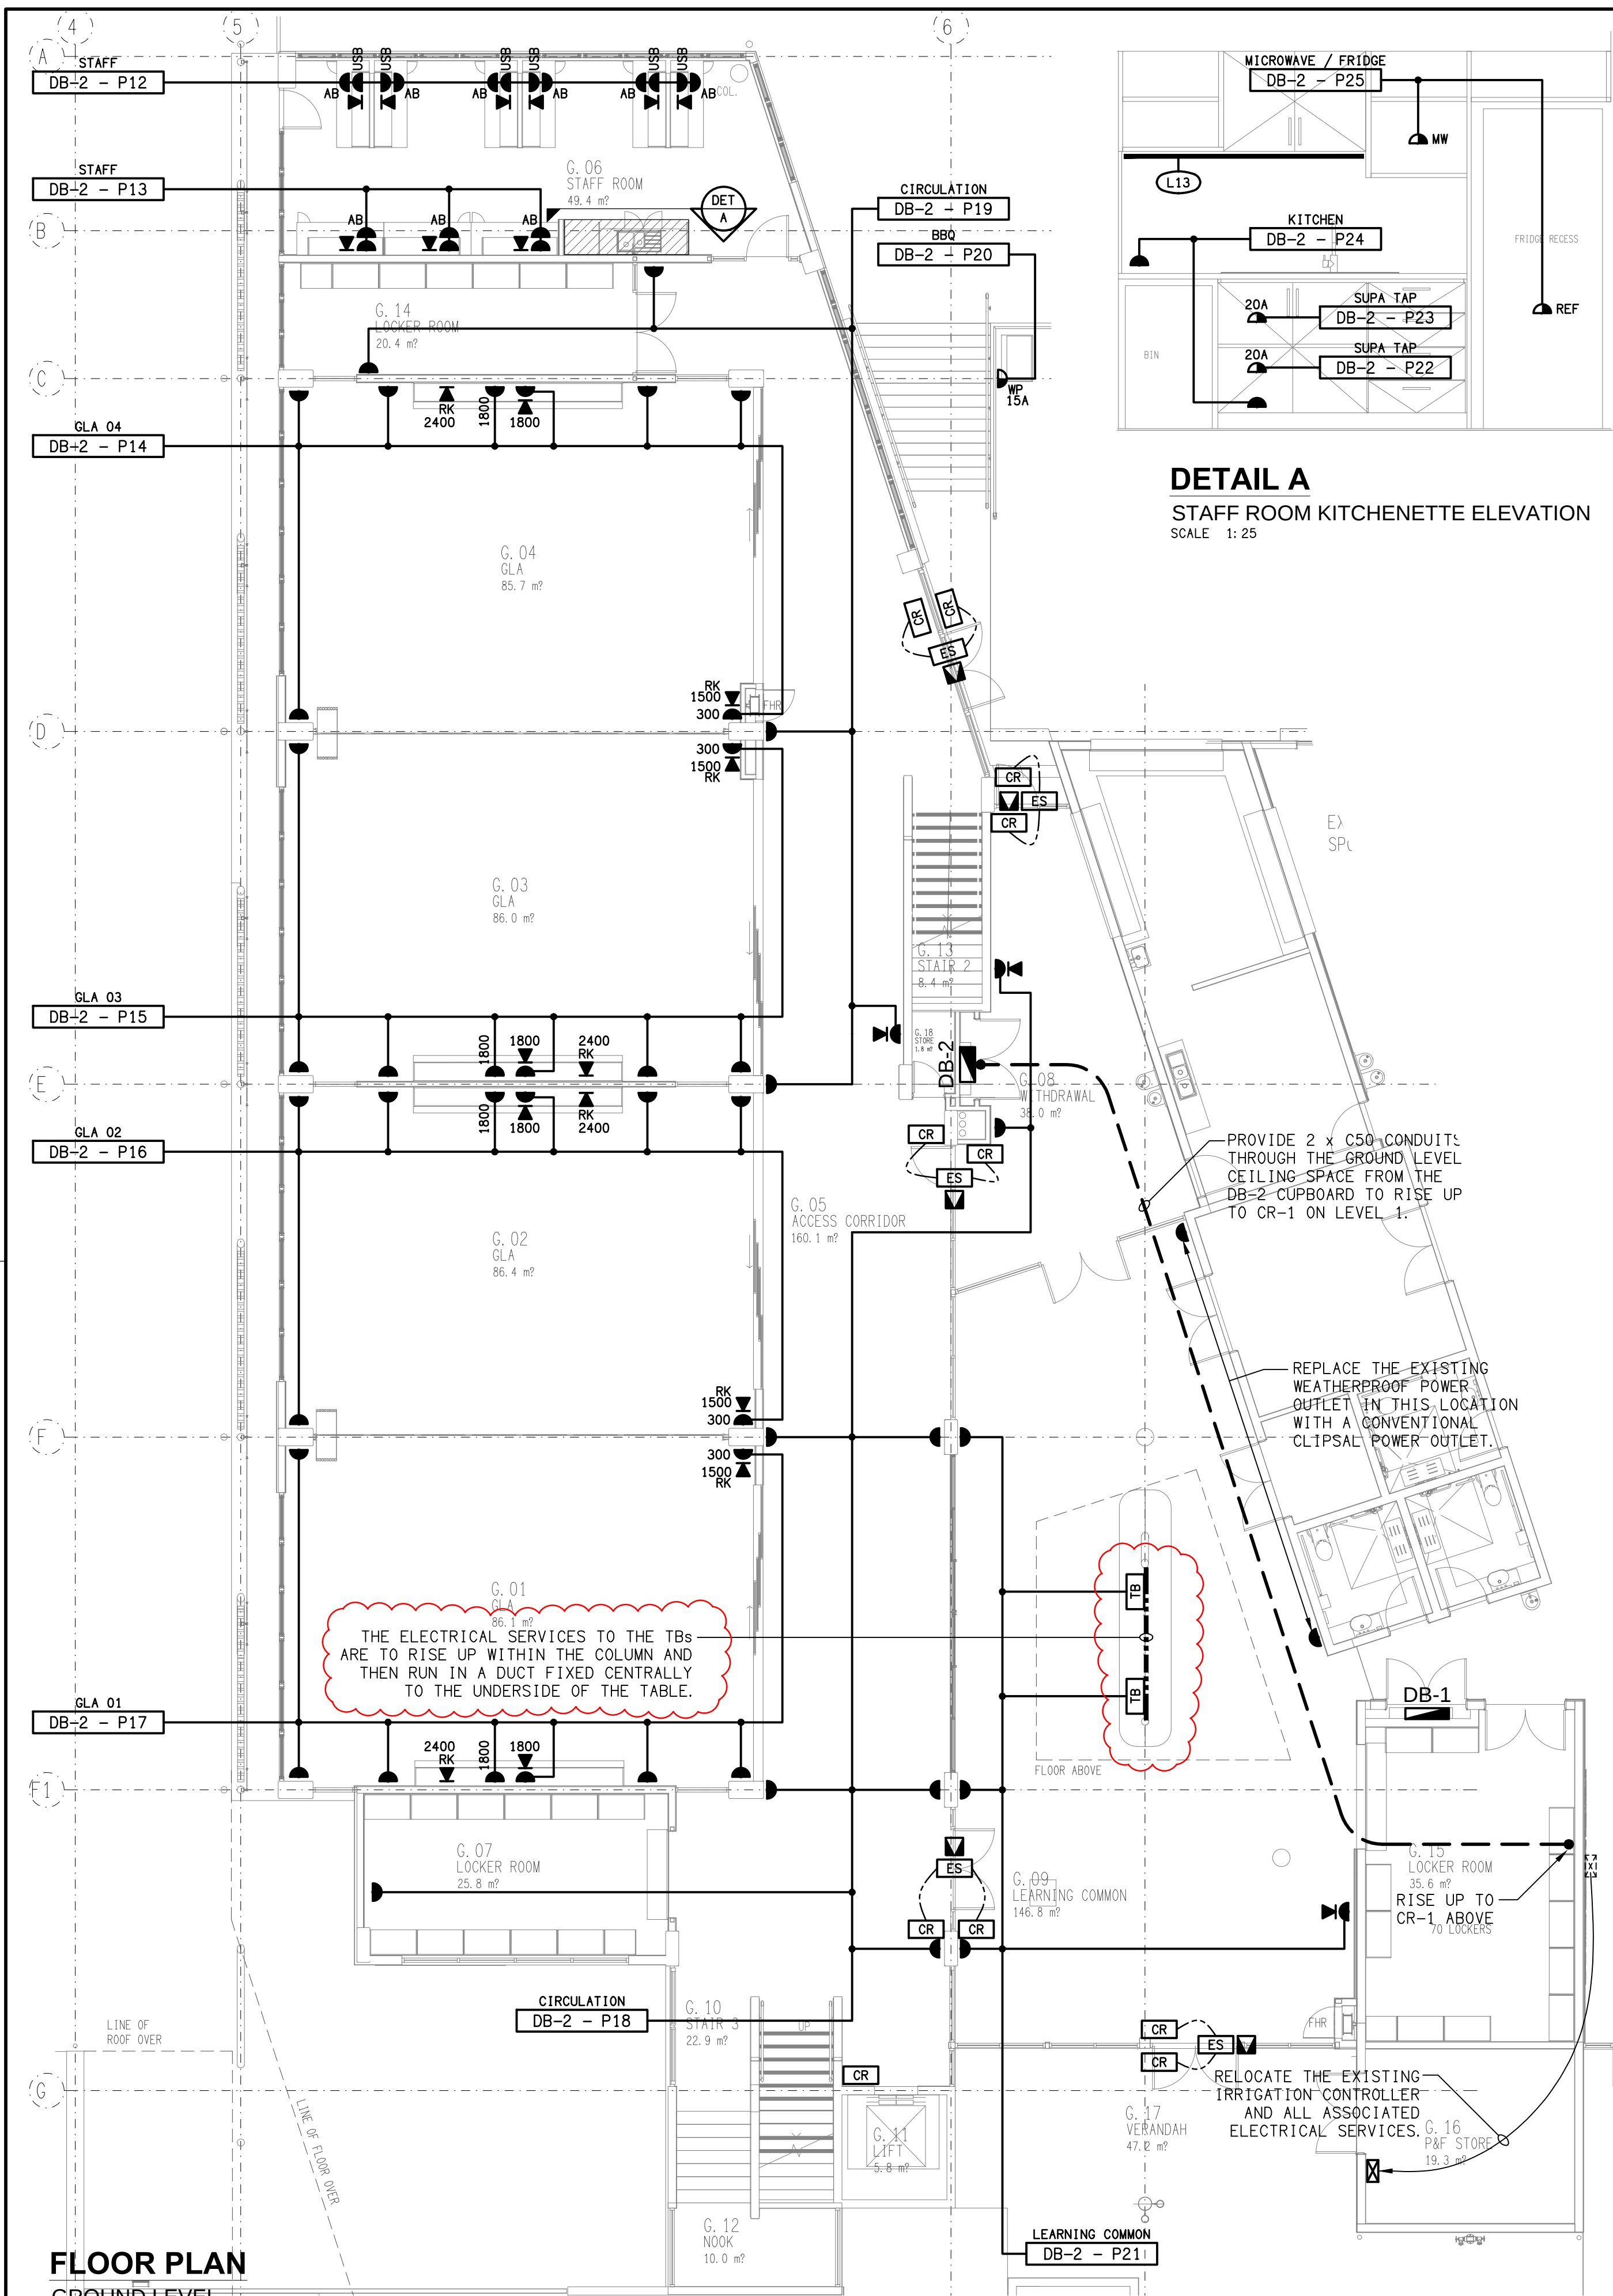

DETAIL A
STAFF ROOM KITCHENETTE ELEVATION
SCALE 1: 25

FLOOR PLAN
GROUND LEVEL
SCALE 1: 100

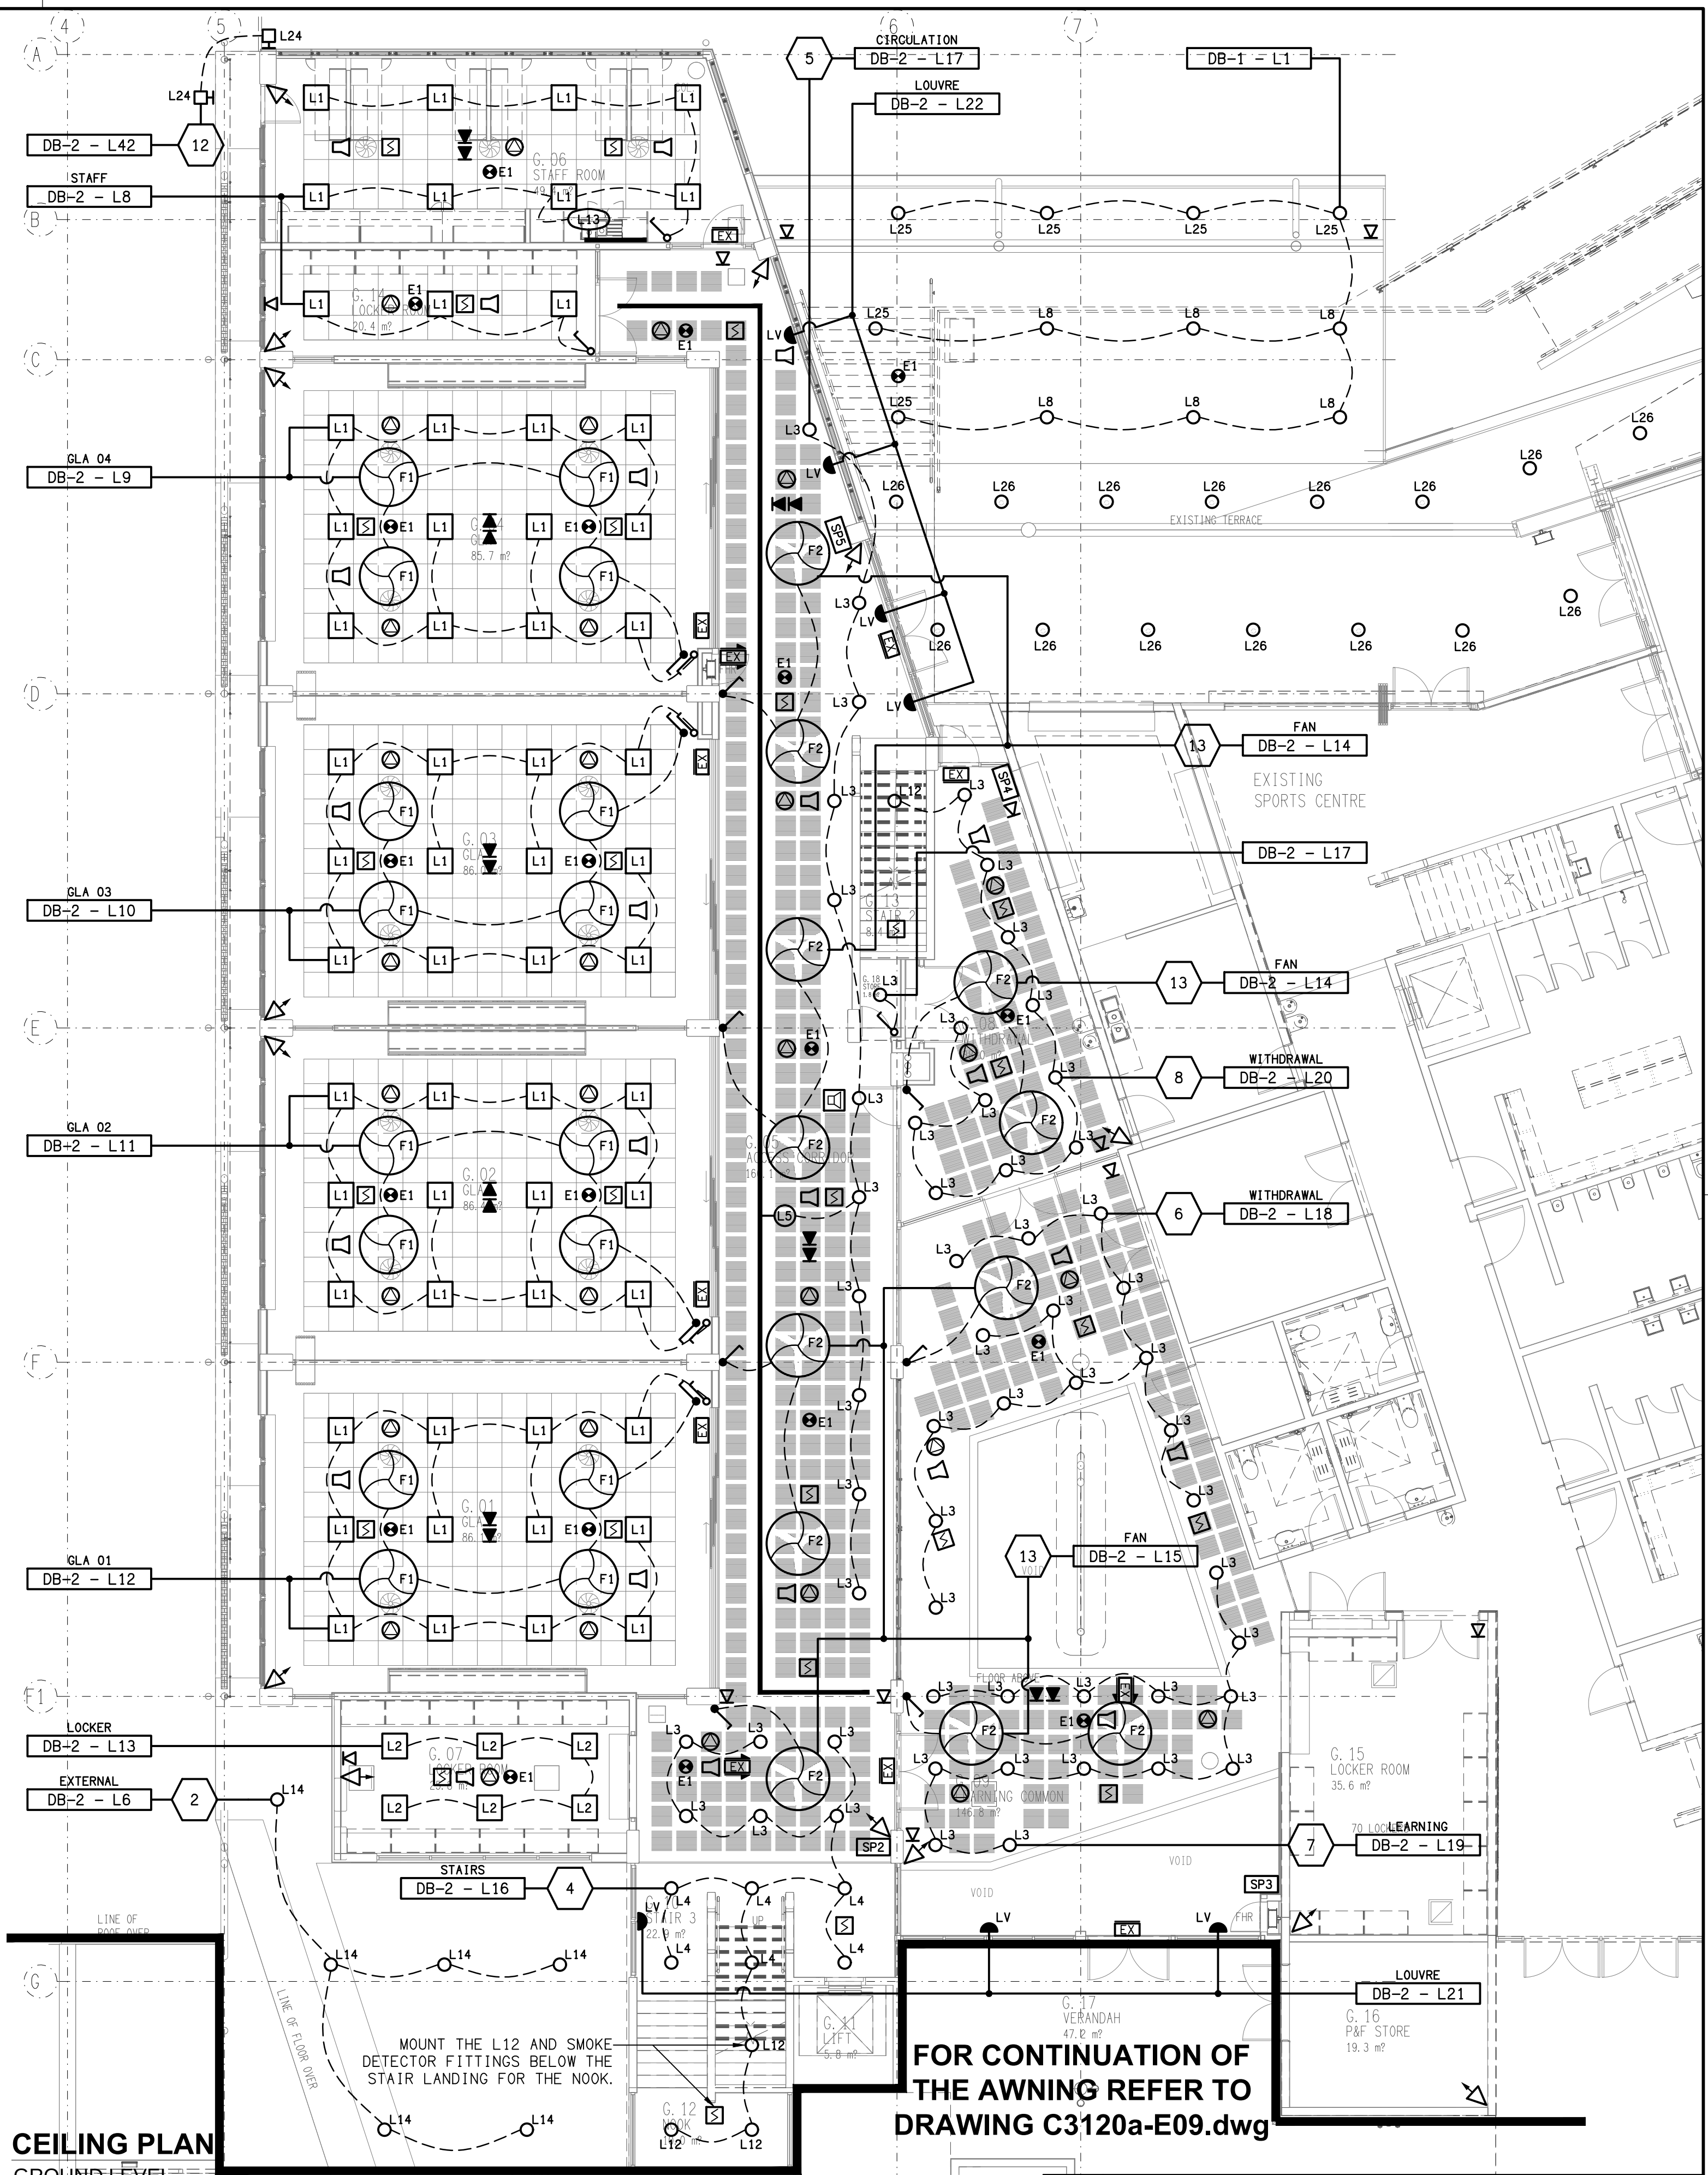

CEILING PLAN
GROUND LEVEL
SCALE 1: 100

**FOR CONTINUATION OF
THE AWNING REFER TO
DRAWING C3120a-E09.dwg**

ELECTRICAL DESIGN GROUP BRISBANE
PTY LTD
ACN 092 710 793
TRADING AS:
ELECTRICAL DESIGN GROUP

THE COPYRIGHT OF THIS DRAWING
REMAINS THE PROPERTY OF THE
ELECTRICAL DESIGN GROUP.
USE FIGURED DIMENSIONS
IN PREFERENCE TO SCALE.
ALL DIMENSIONS TO BE
VERIFIED ONSITE.

ELECTRICAL DESIGN GROUP
ELECTRICAL BUILDING SERVICES CONSULTANTS
BRISBANE GOLD COAST

P.O.Box 15, Sherwood Q.4075
Phone: (07) 3278 4375
Email: brisbane@edg.net.au
Web: www.edg.net.au

PROJECT:
**ST JOHN'S ANGLICAN COLLEGE
FOREST LAKE
AQUATIC CENTRE STAGE 1
COLLEGE AVENUE, FOREST LAKE**

H	CONSTRUCTION	19/06/2025
REV:	DESCRIPTION:	DATE:

DRAWING:
**ELECTRICAL SERVICES
AQUATIC CENTRE GROUND LEVEL PLANS**

SCALE: 1:100	AT A1	PROJECT NO: C3120a	DRAWING NO: E04	REVISION: H
-----------------	-------	------------------------------	---------------------------	-----------------------