



DETAIL A
FUNCTIONS BAR FLOOR PLAN
SCALE 1:50

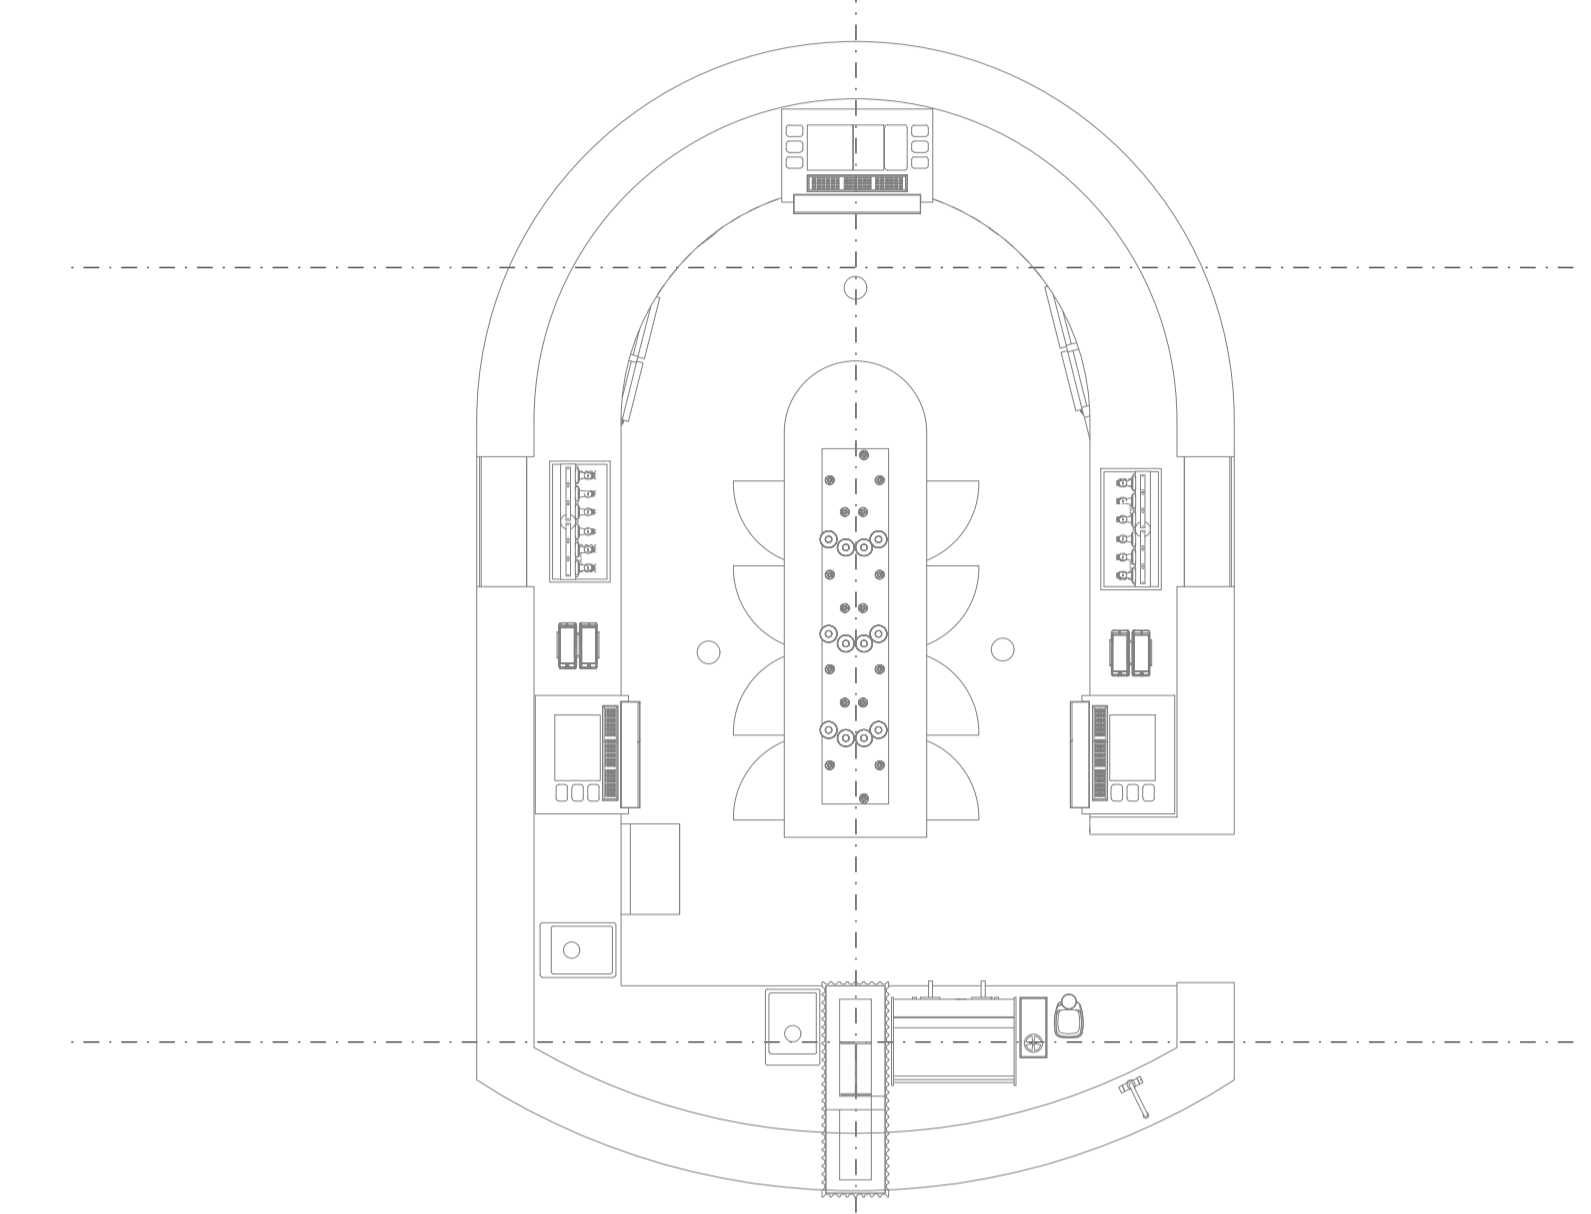

DETAIL B
BISTRO BAR FLOOR PLAN
SCALE 1:50

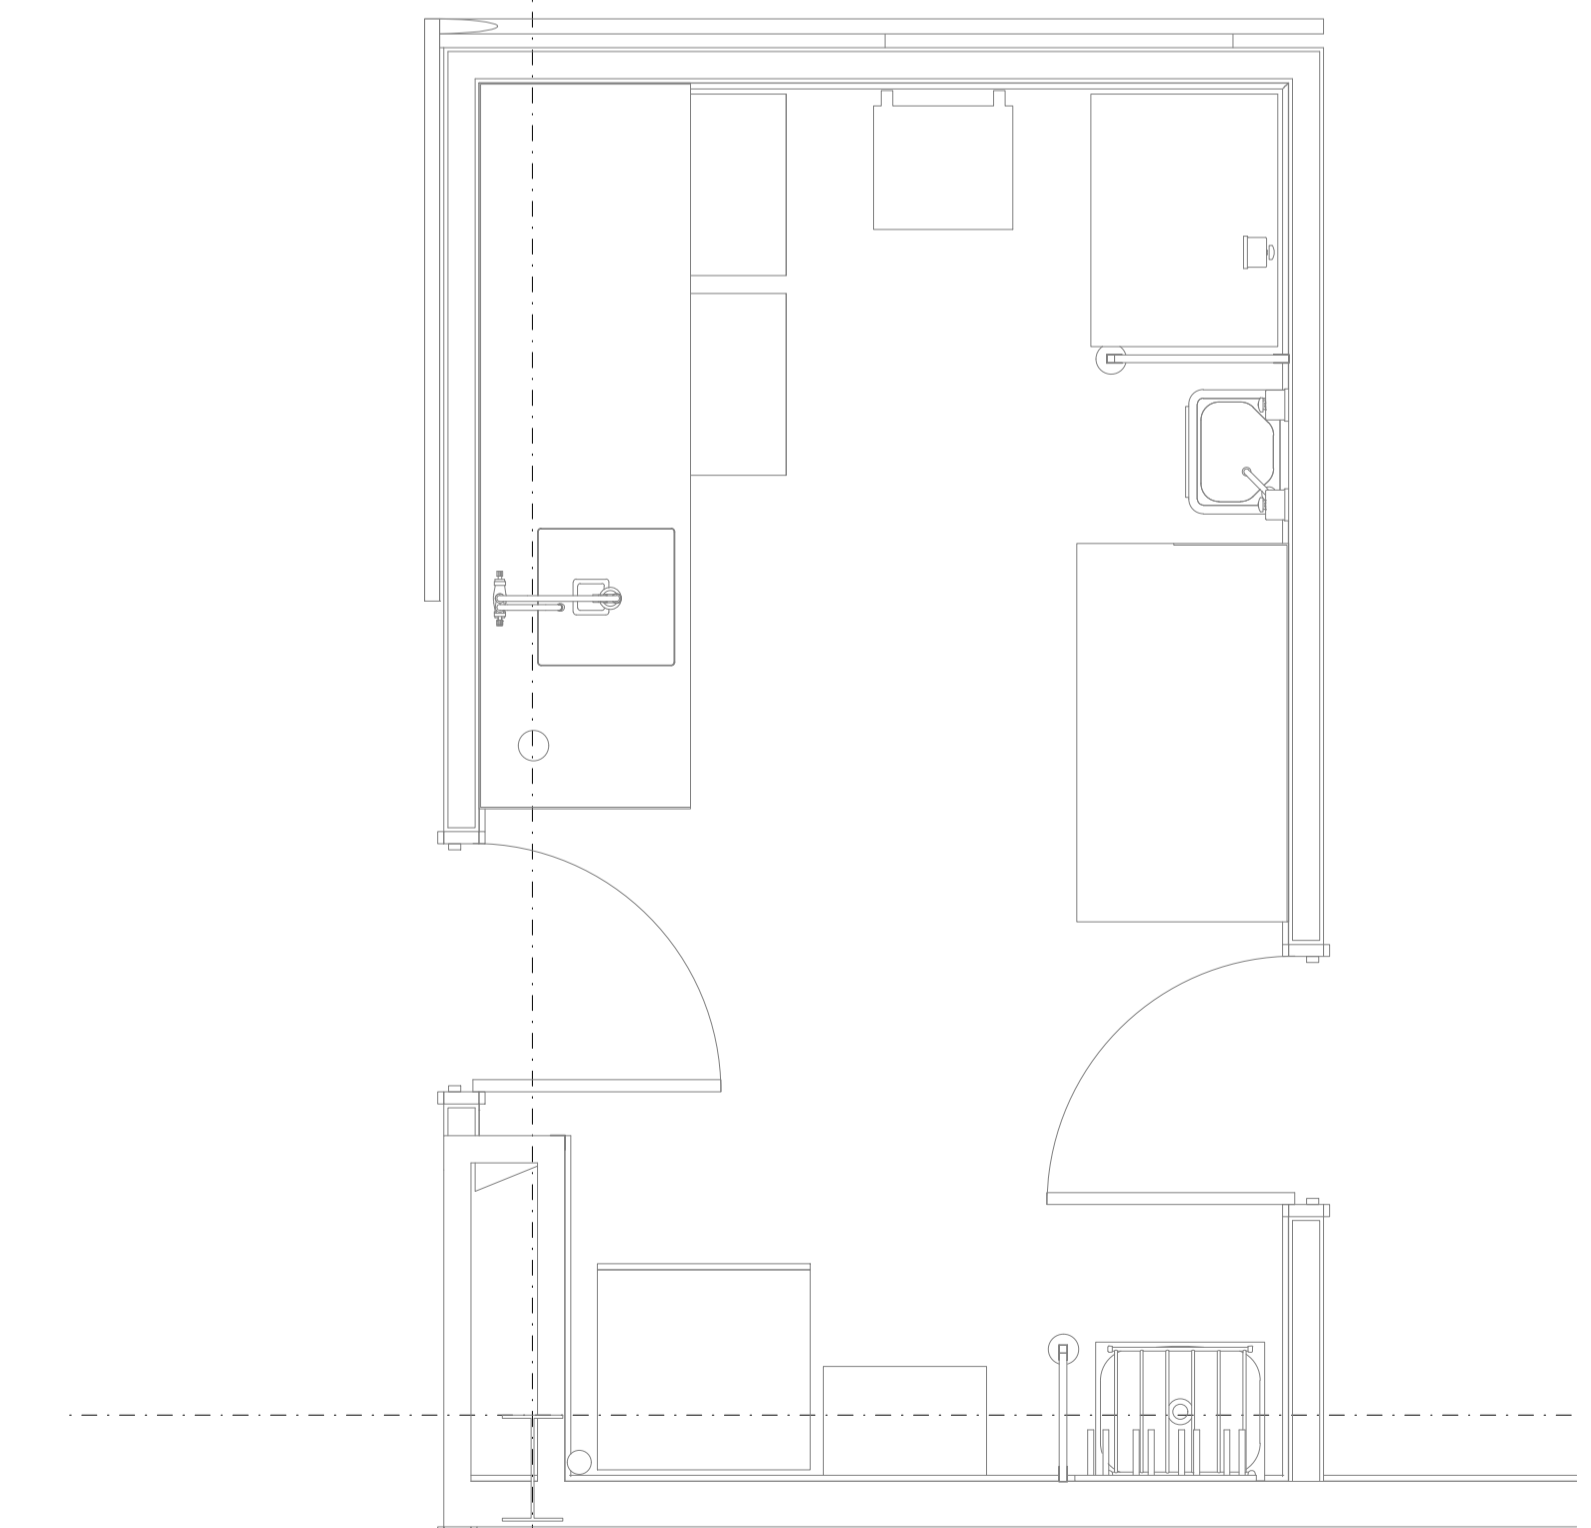

DETAIL C
WASHUP ROOM FLOOR PLAN
SCALE 1:25

ELECTRICAL DESIGN GROUP BRISBANE
PTY LTD
ACN 092 710 793
TRADING AS:
ELECTRICAL DESIGN GROUP

THE COPYRIGHT OF THIS DRAWING
REMAINS THE PROPERTY OF THE
ELECTRICAL DESIGN GROUP.
USE FIGURED DIMENSIONS
IN PREFERENCE TO SCALE.
ALL DIMENSIONS TO BE
VERIFIED ONSITE.

ELECTRICAL DESIGN GROUP
ELECTRICAL BUILDING SERVICES CONSULTANTS
BRISBANE GOLD COAST
P.O. Box 15, Sherwood Q.4075
Phone: (07) 3278 4375
Email: brisbane@edg.net.au
Web: www.edg.net.au

PROJECT:
SUNNYBANK COMMUNITY SPORTS CLUB
470 McCULLOUGH STREET, SUNNYBANK

REV: A	DESCRIPTION: PRELIMINARY	DATE: 03/06/2024
DRAWING: ELECTRICAL SERVICES BISTRO & BAR FLOOR PLAN		
SCALE: 1:100 UNO	PROJECT NO: C3179a	DRAWING NO: E05
AT A1	REVISION: A	