


NOTE:
DO NOT USE CORRUGATED CONDUIT WITHIN THE KITCHEN AND BAR AREAS.

FLOOR PLAN
PROPOSED KITCHEN & FOYER
SCALE 1: 50

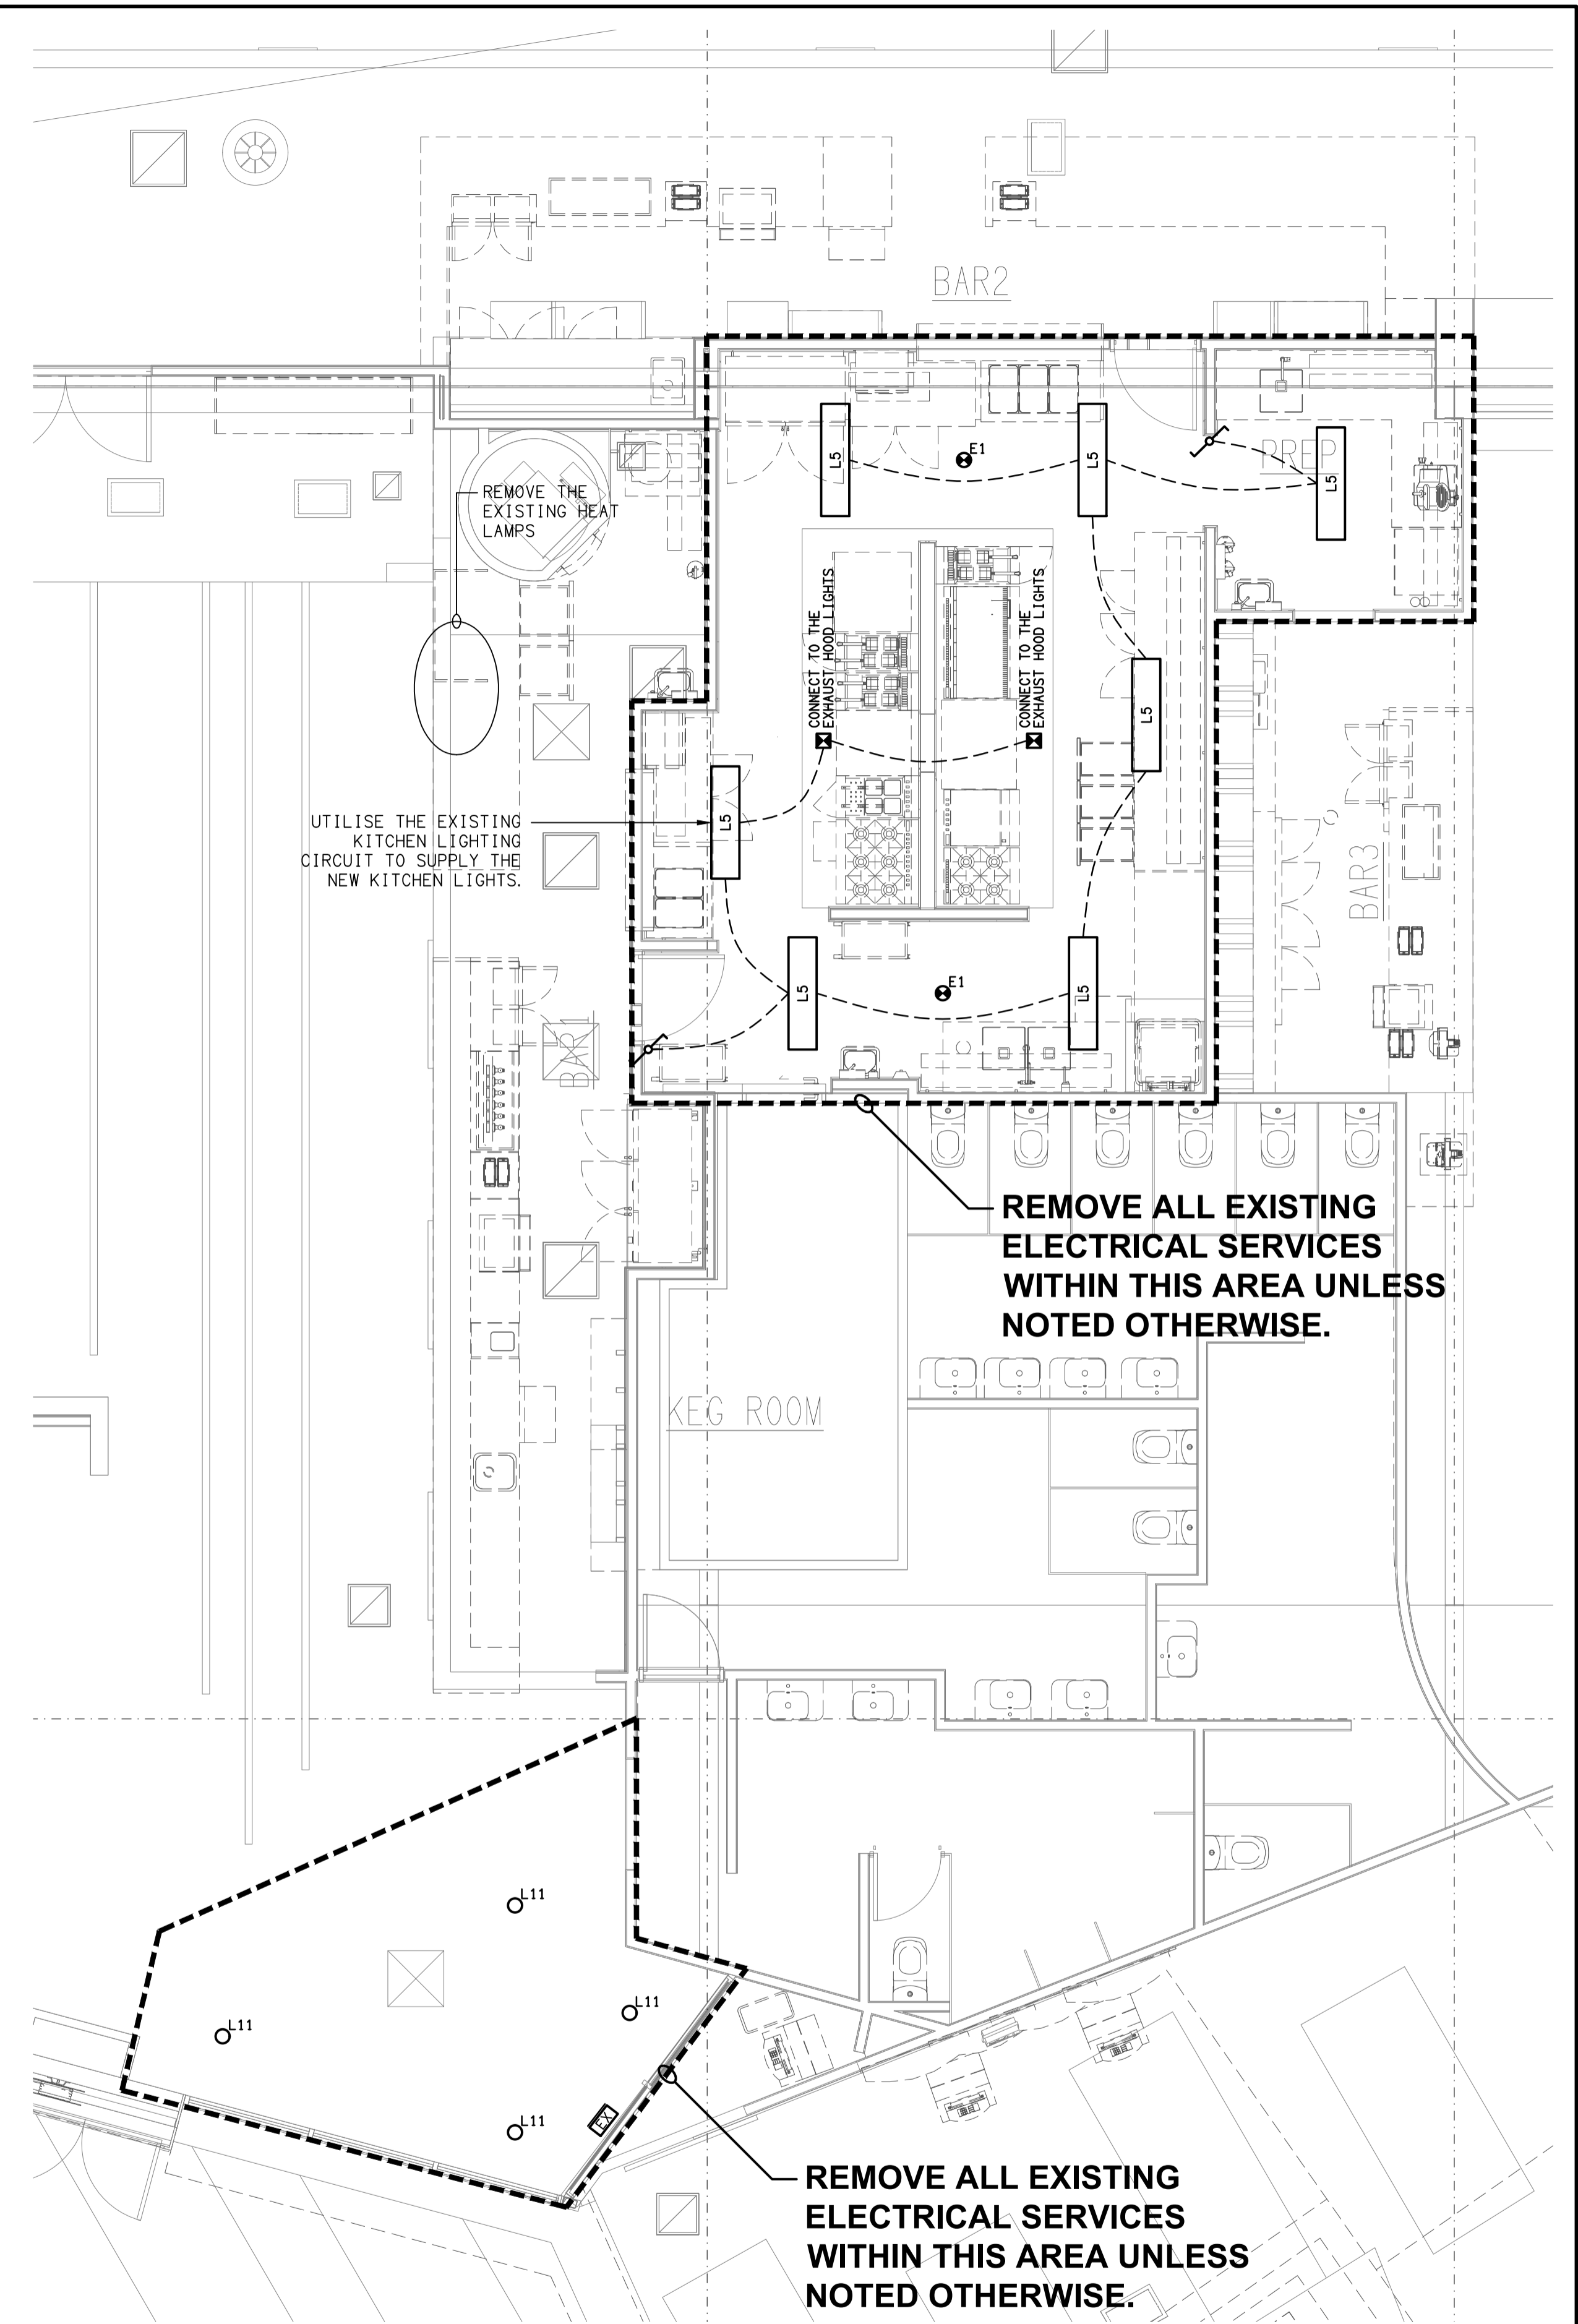

REFLECTED CEILING PLAN
PROPOSED KITCHEN & FOYER
SCALE 1: 50

ELECTRICAL DESIGN GROUP BRISBANE
PTY LTD
ACN 092 710 793
TRADING AS:
ELECTRICAL DESIGN GROUP

THE COPYRIGHT OF THIS DRAWING
REMAINS THE PROPERTY OF THE
ELECTRICAL DESIGN GROUP.
USE FIGURED DIMENSIONS
IN PREFERENCE TO SCALE.
ALL DIMENSIONS TO BE
VERIFIED ONSITE.

ELECTRICAL DESIGN GROUP
ELECTRICAL BUILDING SERVICES CONSULTANTS
BRISBANE GOLD COAST

P.O. Box 15, Sherwood Q.4075
Phone: (07) 3278 4375
Email: brisbane@edg.net.au
Web: www.edg.net.au

PROJECT:
SUNNYBANK COMMUNITY SPORTS CLUB

470 McCULLOUGH STREET, SUNNYBANK

A	PRELIMINARY	03/06/2024
REV.	DESCRIPTION:	DATE:

DRAWING: ELECTRICAL SERVICES FOYER & KITCHEN FLOOR PLAN & REFLECTED CEILING PLAN		PROJECT NO: C3179a	DRAWING NO: E07	REVISION: A
SCALE: 1:50	AT A1			