


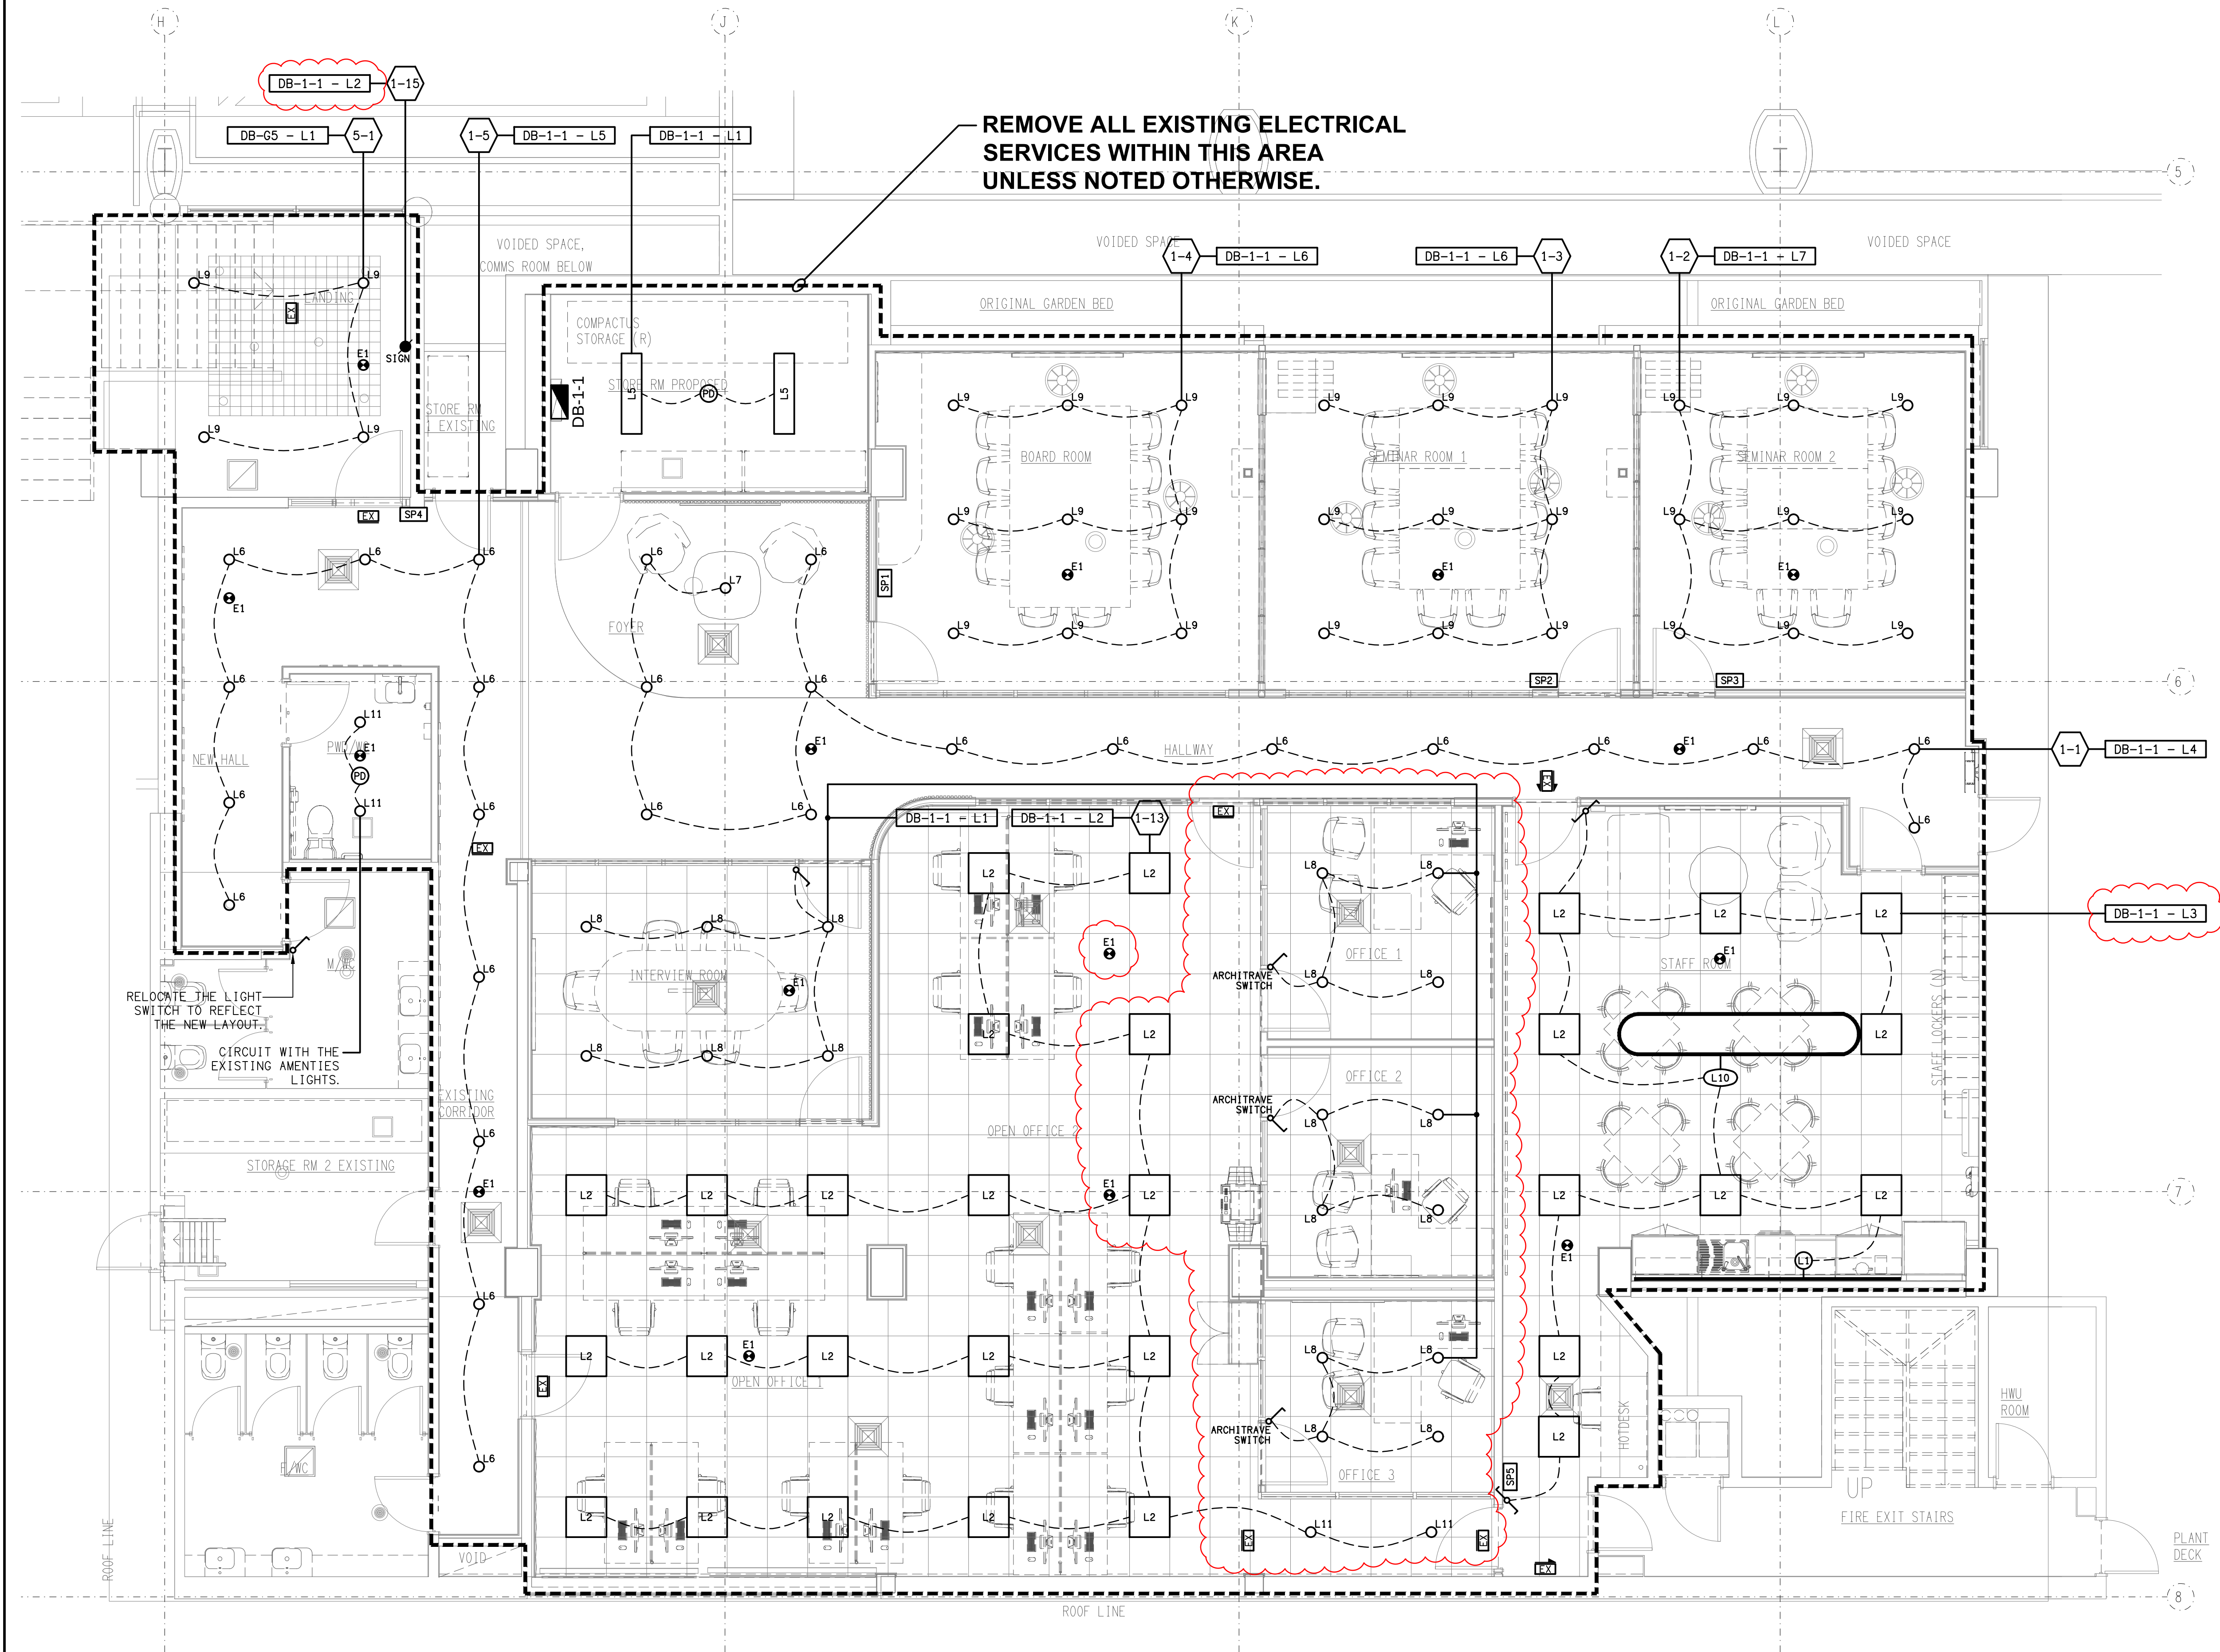

F	CONSTRUCTION	28/03/2025
REV.	DESCRIPTION:	DATE:

ELECTRICAL DESIGN GROUP
ELECTRICAL BUILDING SERVICES CONSULTANTS

BRISBANE: P.O. Box 15 Sherwood Qld 4075
Phone: (07) 3278 4375
Email: brisbane@edg.net.au
Web: www.edg.net.au

ELECTRICAL DESIGN GROUP BRISBANE PTY LTD
ACN 092 710 793

TRADING AS:
ELECTRICAL DESIGN
GROUP

PROJECT:
**SUNNYBANK COMMUNITY
SPORTS CLUB**

SITE ADDRESS:
**470 McCULLOUGH STREET
SUNNYBANK**

SCALE: 1:50 UNO
SHEET SIZE: AT A1

DRAWING TITLE:

**ELECTRICAL SERVICES
LEVEL 1 OFFICE
REFLECTED CEILING PLAN**

PROJECT NO. DRAWING NO. REVISION:

C3179a E09 F