


**DETAIL A**  
 BAR / CASHIER FLOOR PLAN  
 SCALE 1:50

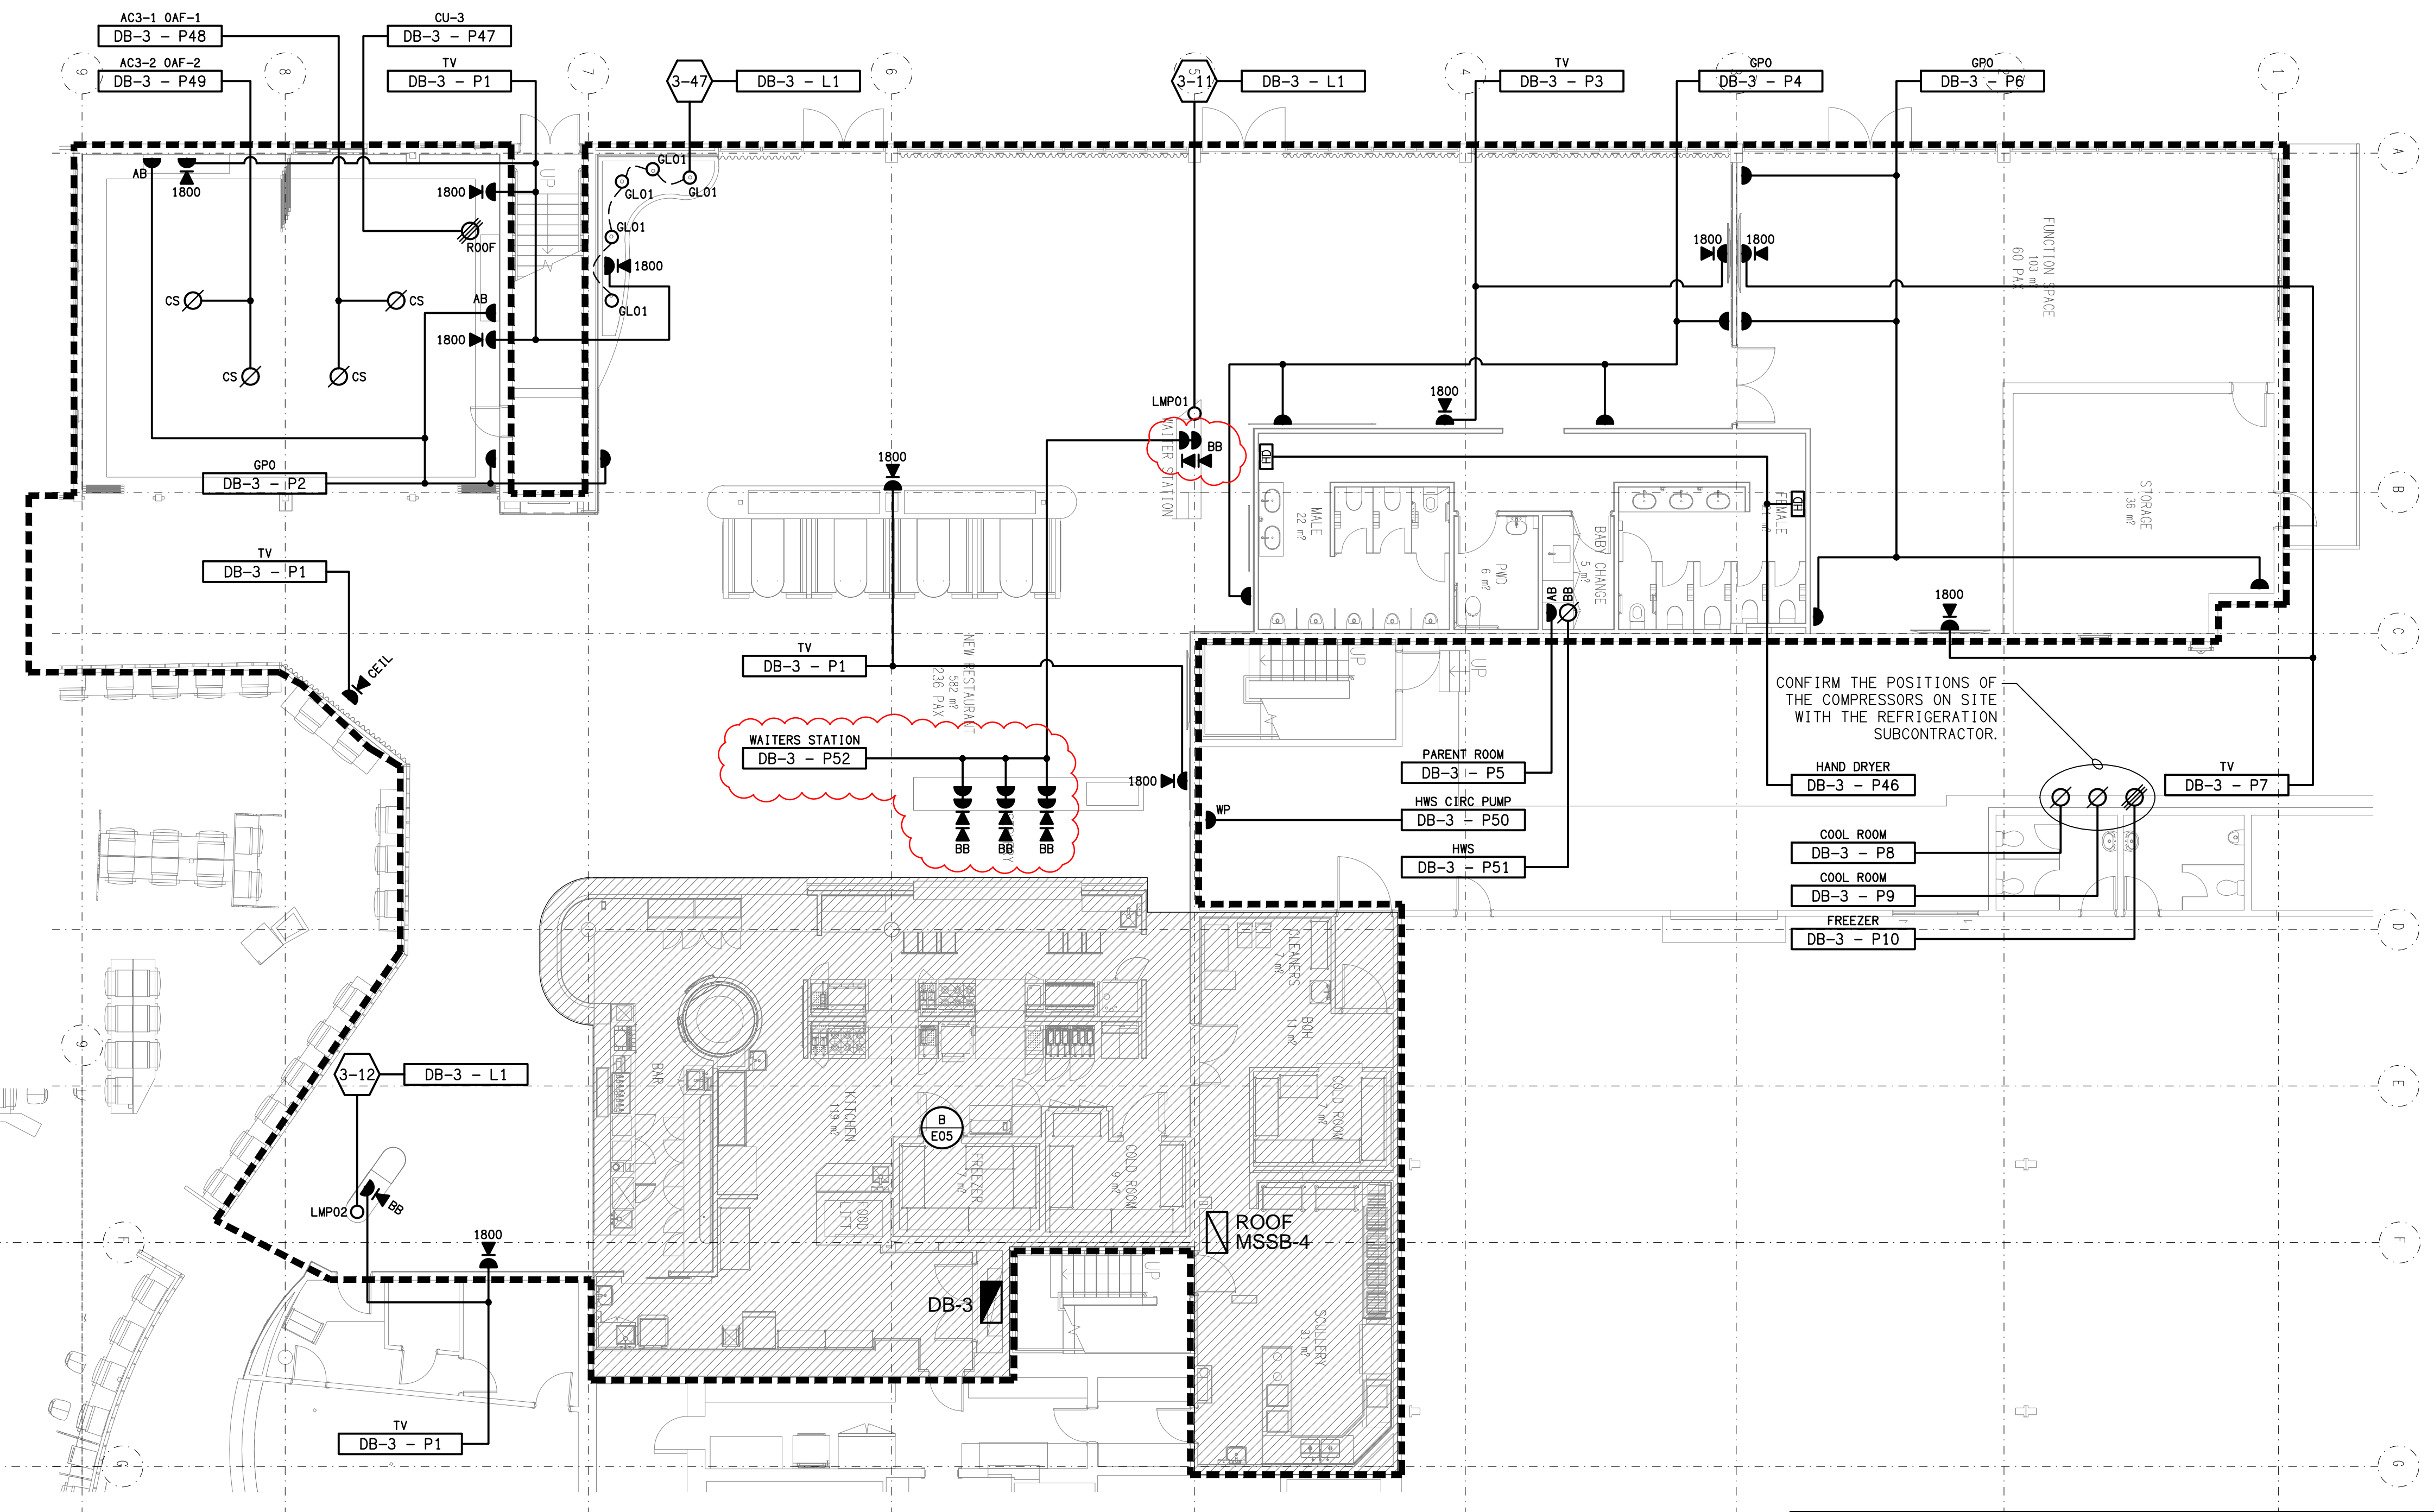

ELECTRICAL DESIGN GROUP BRISBANE  
 PTY LTD  
 ACN 092 710 793  
 TRADING AS:  
 ELECTRICAL DESIGN GROUP

THE COPYRIGHT OF THIS DRAWING  
 REMAINS THE PROPERTY OF THE  
 ELECTRICAL DESIGN GROUP.  
 USE FIGURED DIMENSIONS  
 IN PREFERENCE TO SCALE.  
 ALL DIMENSIONS TO BE  
 VERIFIED ONSITE.

**ELECTRICAL DESIGN GROUP**  
 ELECTRICAL BUILDING SERVICES CONSULTANTS  
 BRISBANE GOLD COAST  
 P.O. Box 15, Sherwood Q.4075  
 Phone: (07) 3278 4375  
 Email: brisbane@edg.net.au  
 Web: www.edg.net.au

PROJECT:  
**REDLANDS SPORTING CLUB  
 REFURBISHMENT**  
 ANSON ROAD, WELLINGTON POINT, QUEENSLAND

F	CONSTRUCTION	17/07/2024
REV.	DESCRIPTION:	DATE:
DRAWING: <b>ELECTRICAL SERVICES FLOOR PLAN</b>		
SCALE: 1:100 & 1:50	PROJECT NO: <b>C3204a</b>	DRAWING NO: <b>E04</b>
AT A1	REVISION: <b>F</b>	