


DETAIL A
L1 LIGHTING ELEVATION
SCALE 1:50

DETAIL B
L1 LIGHTING SECTION
SCALE 1:50

DETAIL C
L3 LIGHTING ELEVATION
SCALE 1:50

DETAIL D
L3 LIGHTING ELEVATION
SCALE 1:50

DETAIL E
L3 / L2 LIGHTING SECTION
SCALE 1:50

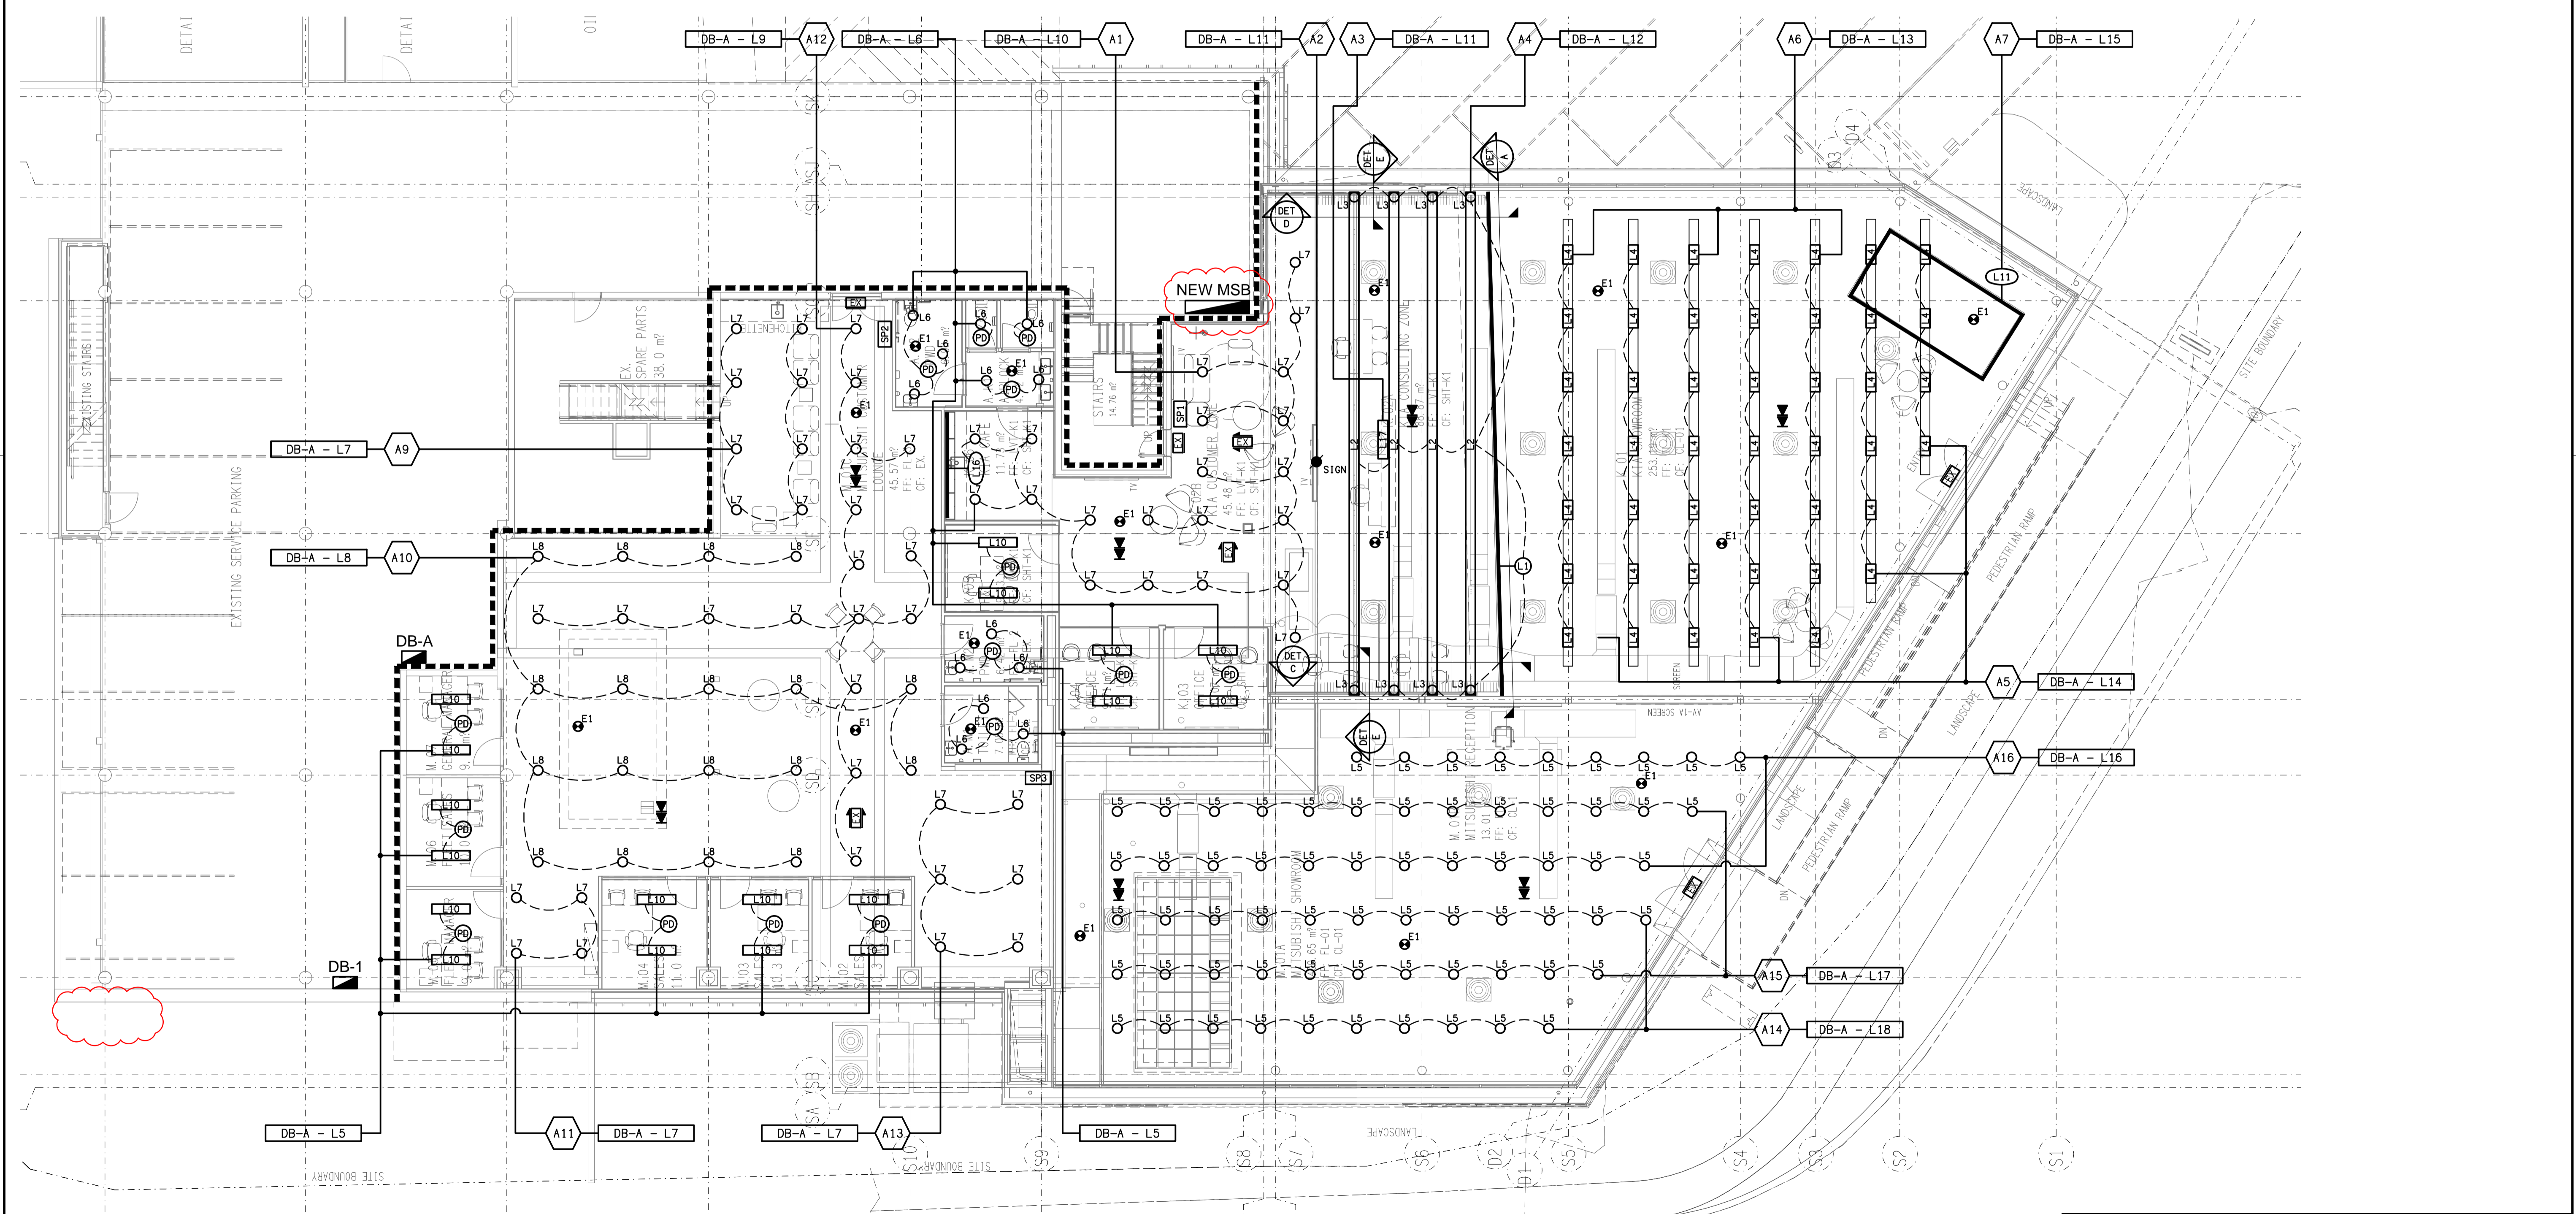

ELECTRICAL DESIGN GROUP BRISBANE
PTY LTD
ACN 092 710 793
TRADING AS:
ELECTRICAL DESIGN GROUP

THE COPYRIGHT OF THIS DRAWING
REMAINS THE PROPERTY OF THE
ELECTRICAL DESIGN GROUP.
USE FIGURED DIMENSIONS
IN PREFERENCE TO SCALE.
ALL DIMENSIONS TO BE
VERIFIED ONSITE.

ELECTRICAL DESIGN GROUP
ELECTRICAL BUILDING SERVICES CONSULTANTS
BRISBANE GOLD COAST
P.O. Box 15, Sherwood Q.4075
Phone: (07) 3278 4375
Email: brisbane@edg.net.au
Web: www.edg.net.au

PROJECT:
TOOWONG KIA & MITSUBISHI
601 MILTON ROAD, TOOWONG

C	BUILDING APPROVAL	17/01/2025
REV:	DESCRIPTION:	DATE:
DRAWING: ELECTRICAL SERVICES GROUND LEVEL SHOWROOM REFLECTED CEILING PLAN		
SCALE: 1:100	PROJECT NO: AT A1 C3227a	DRAWING NO: E05
		REVISION: C