
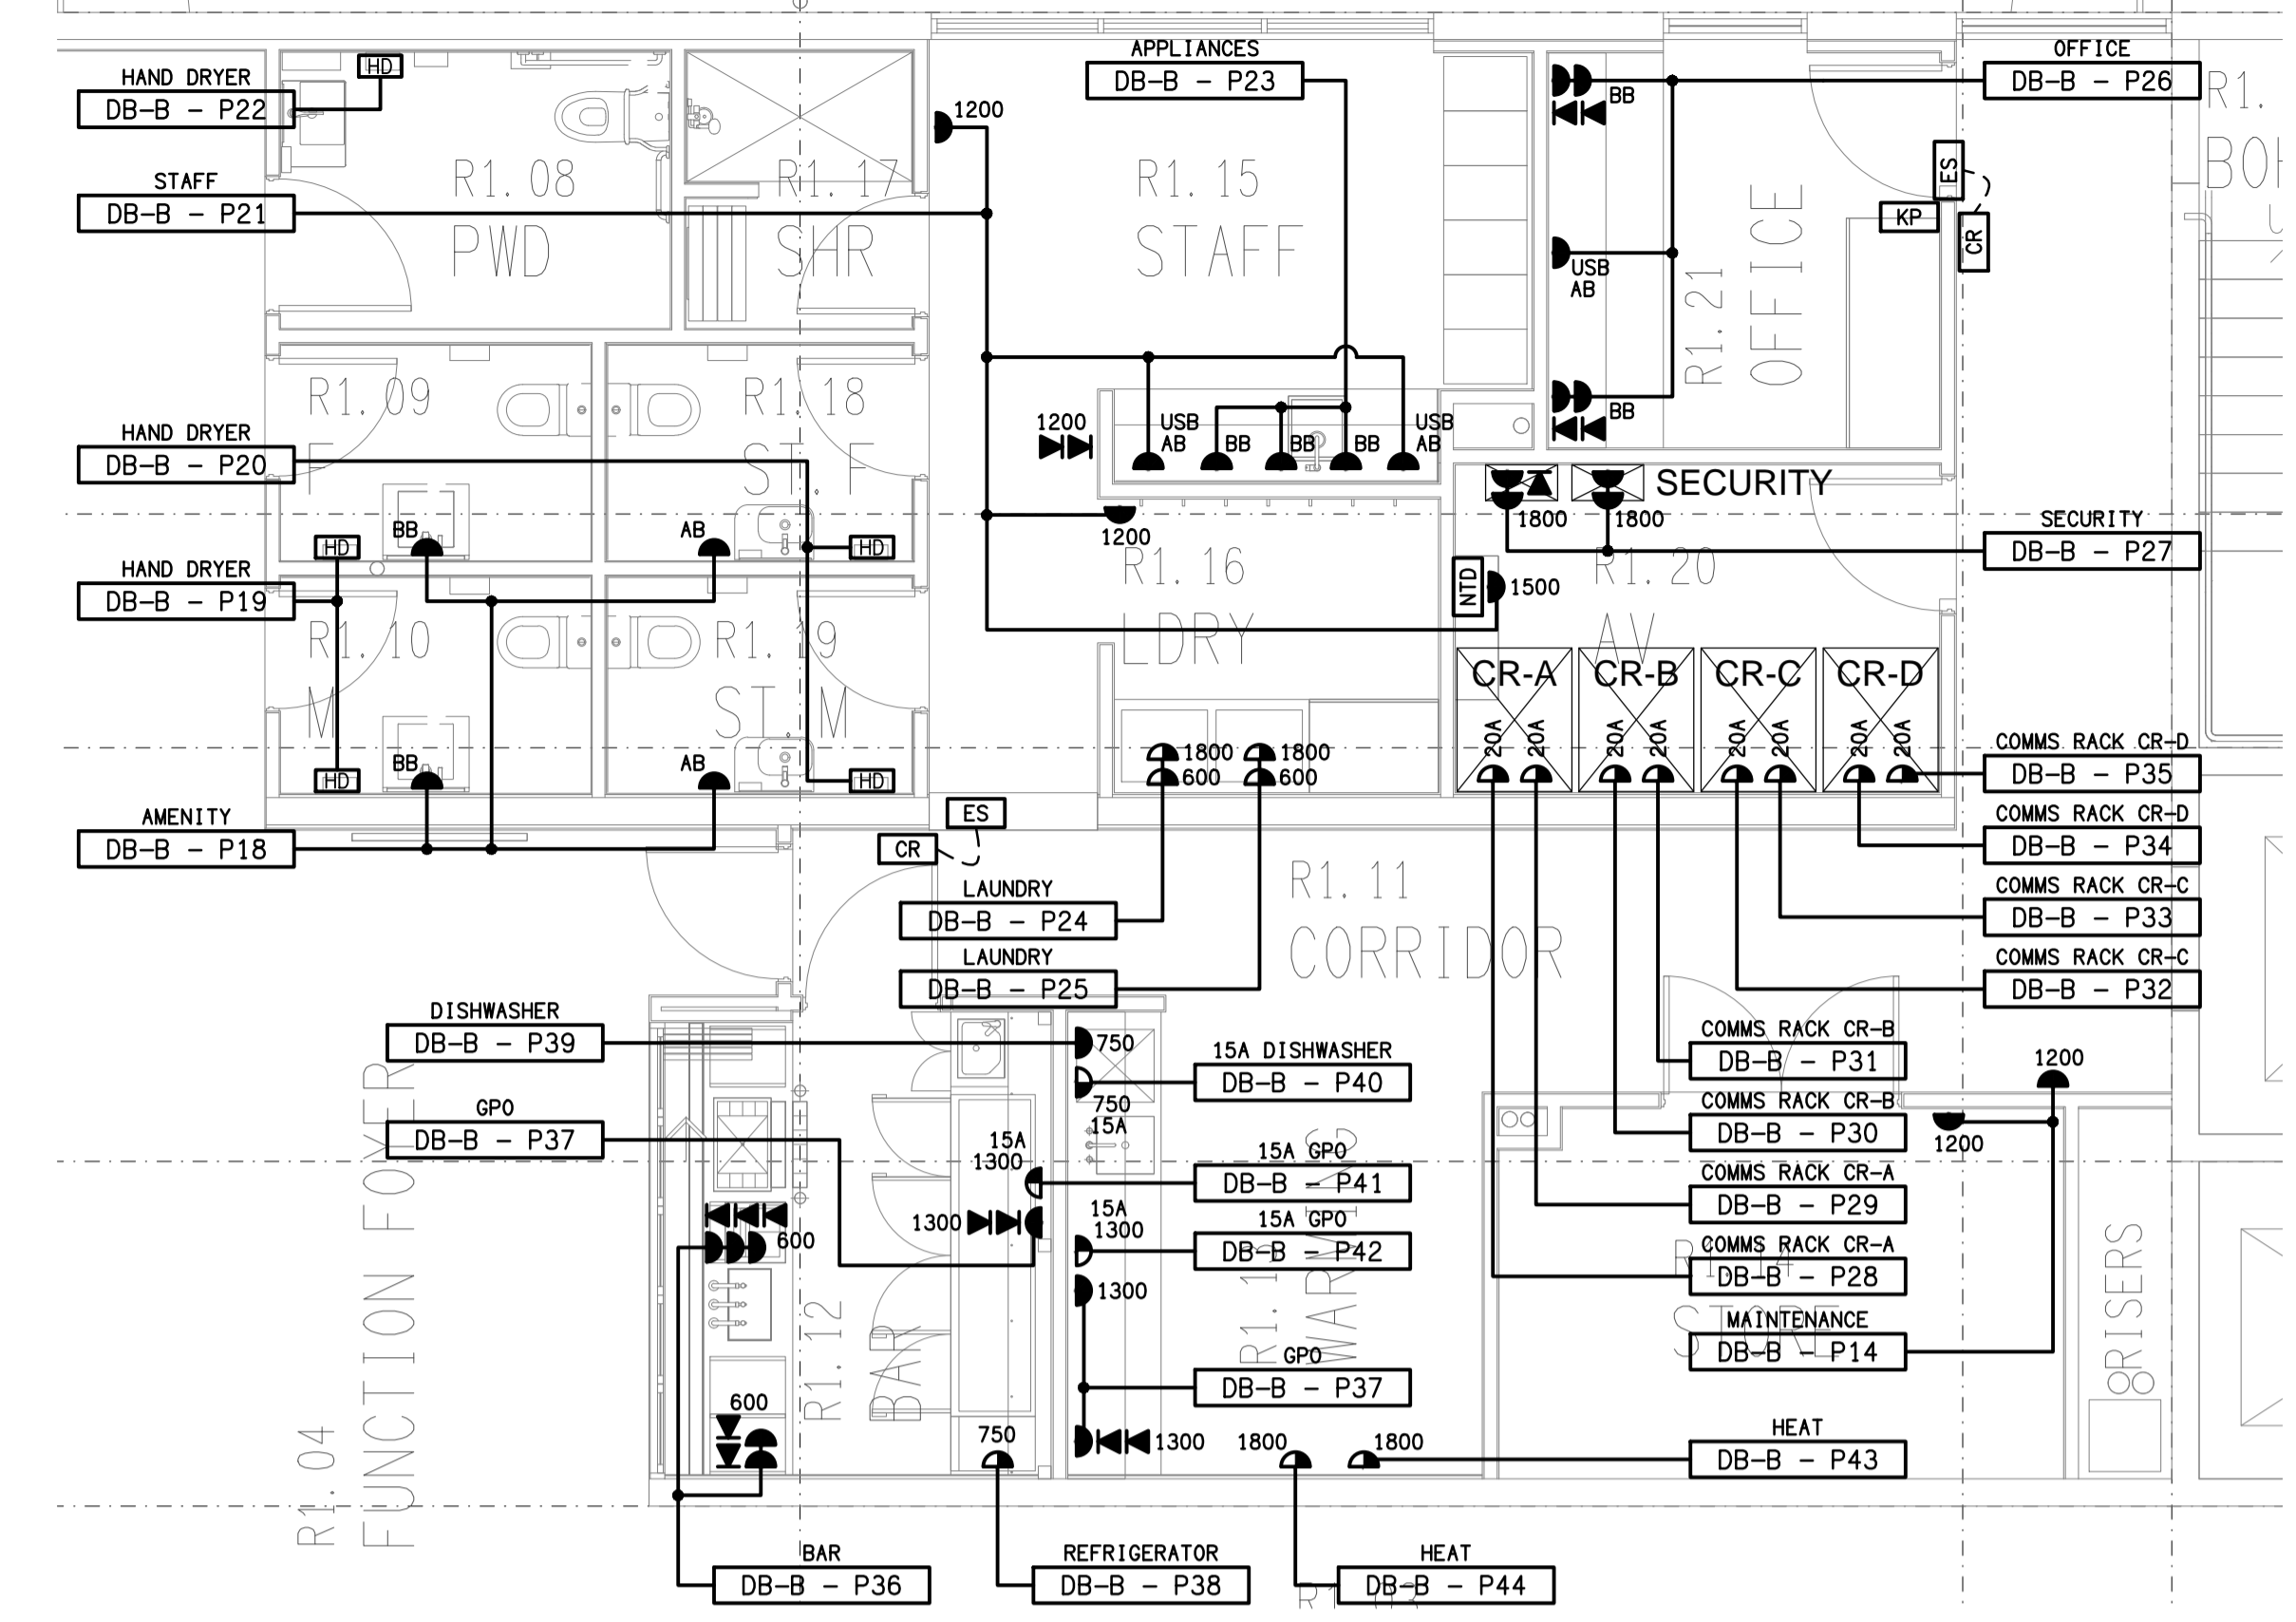


REFER TO THE LEVEL 0 FLOOR PLAN BELOW FOR THE ELECTRICAL SERVICES WITHIN THIS AREA.

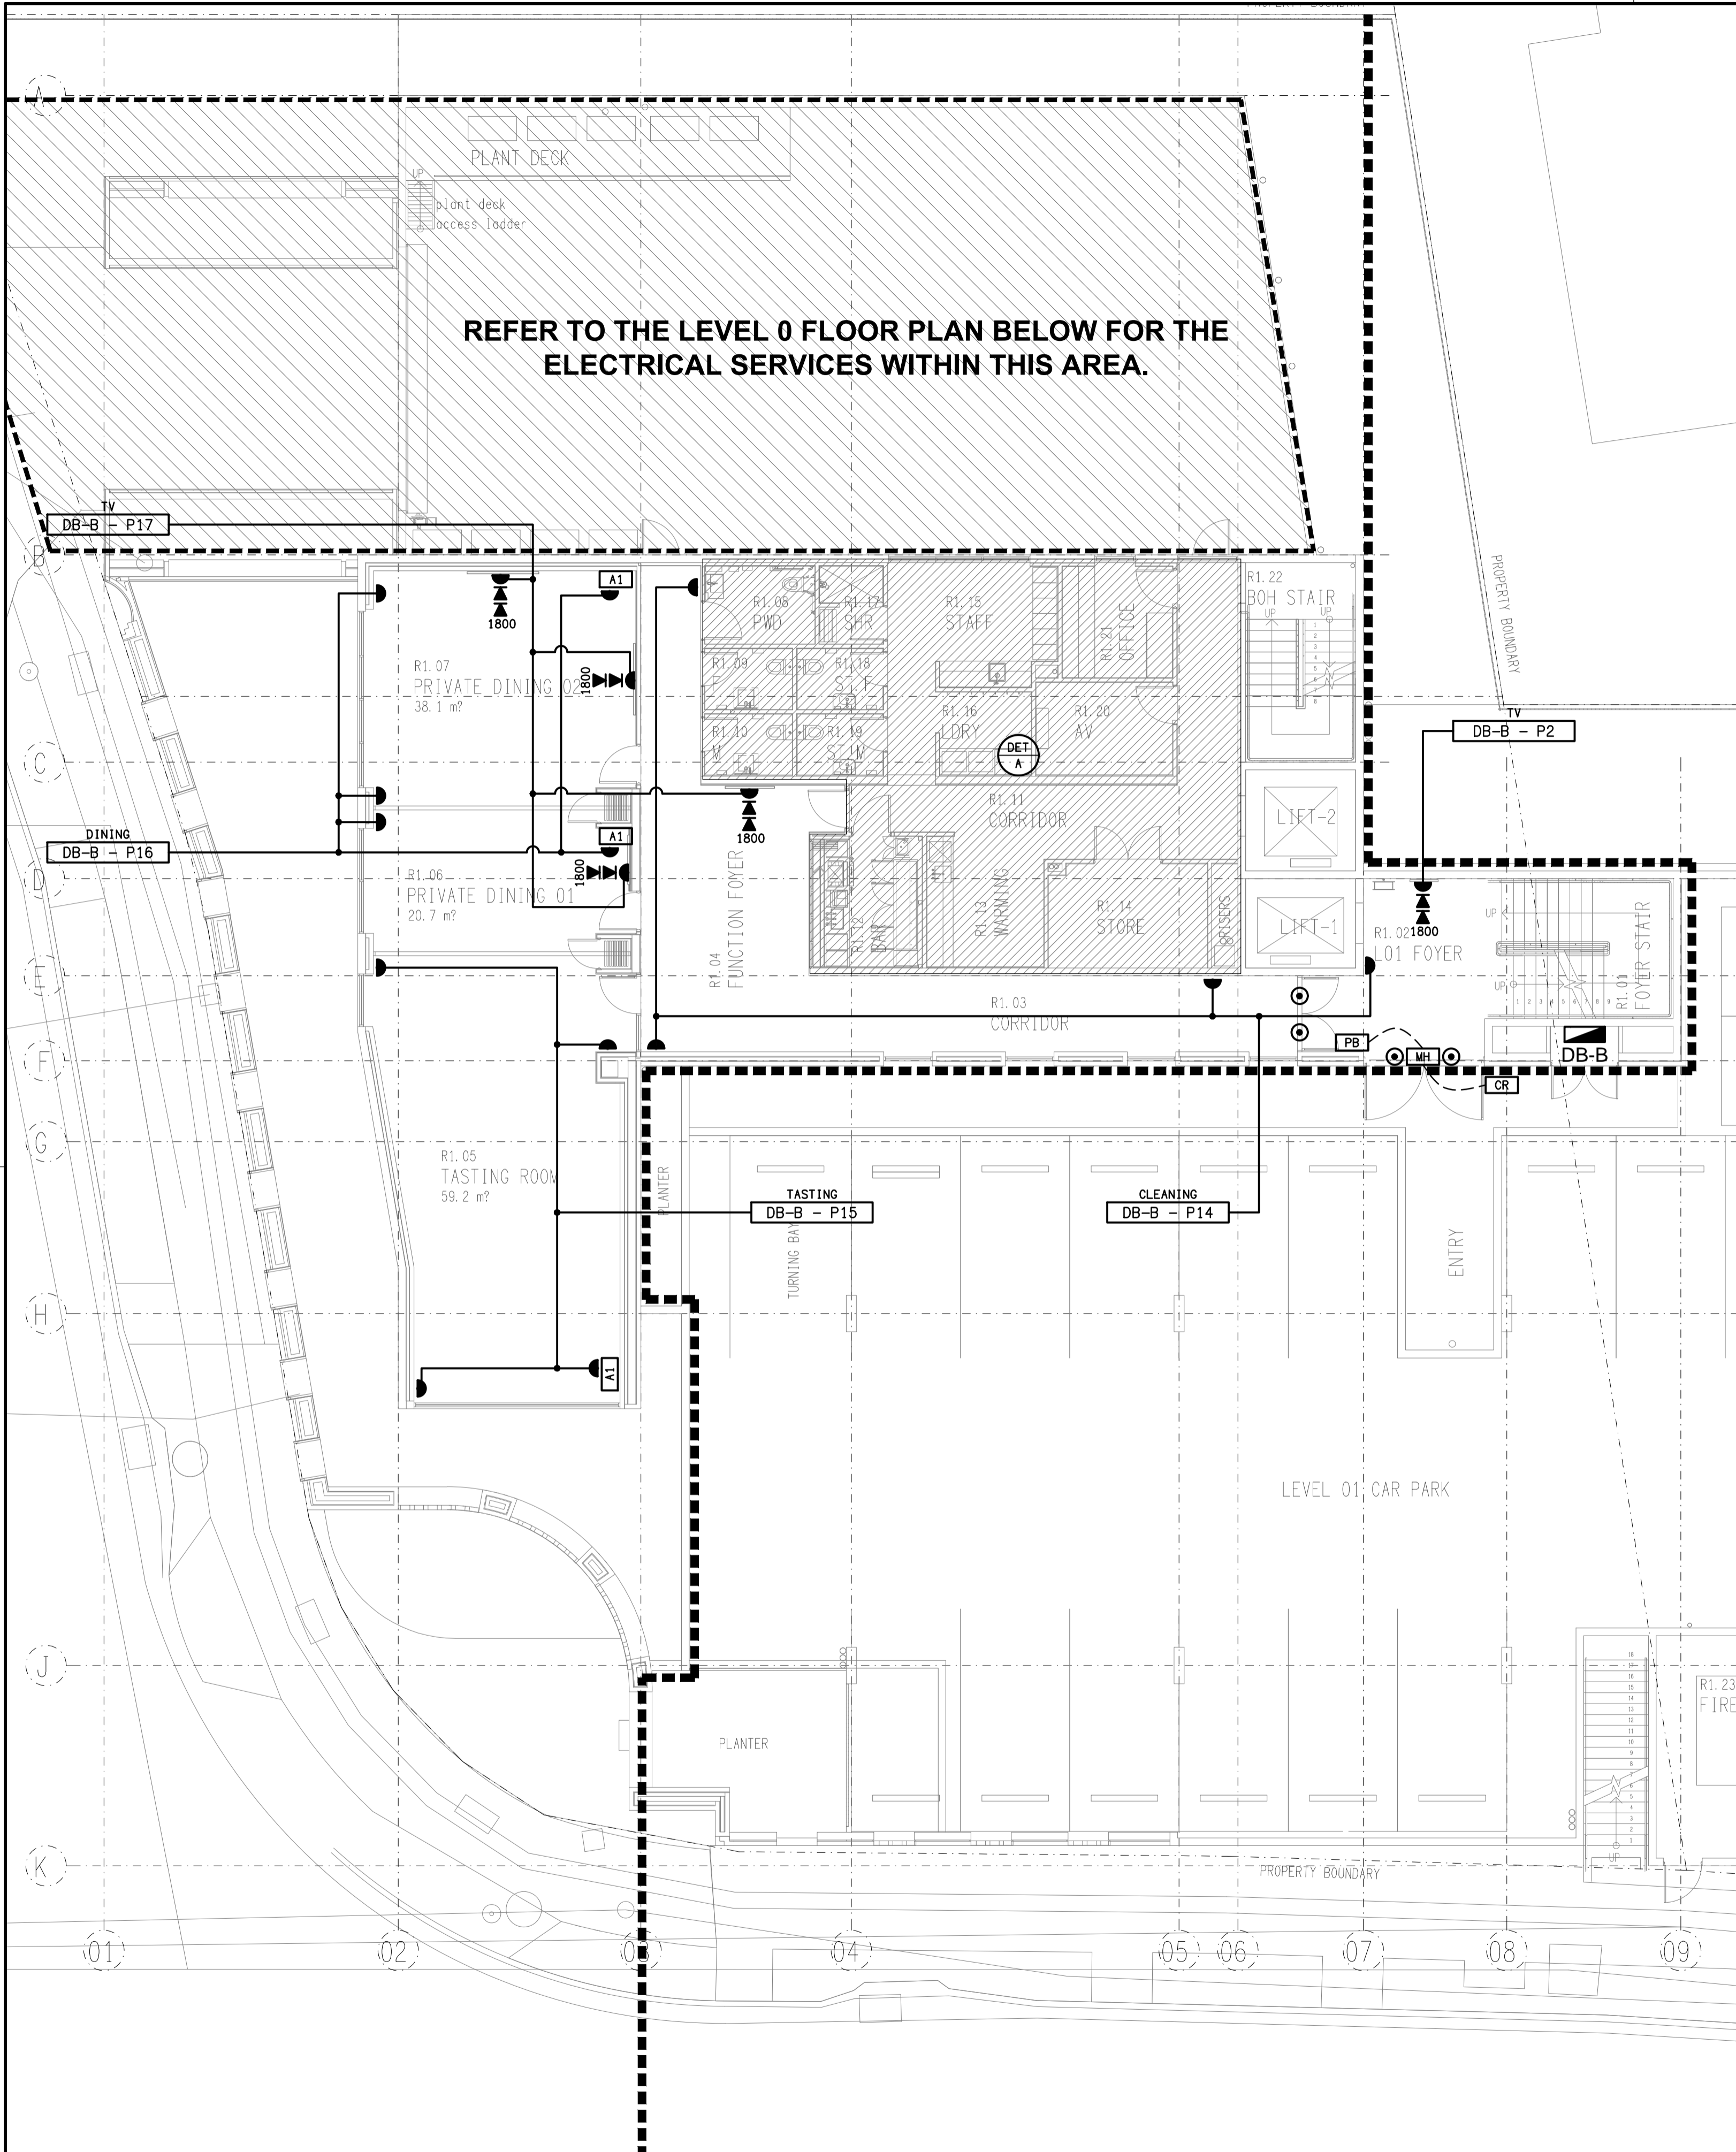

DETAIL A
STAFF & BAR LAYOUT
SCALE: 1:50

ELECTRICAL DESIGN GROUP BRISBANE
PTY LTD
ACN 092 710 793
TRADING AS:
ELECTRICAL DESIGN GROUP

THE COPYRIGHT OF THIS DRAWING
REMAINS THE PROPERTY OF THE
ELECTRICAL DESIGN GROUP.
USE FIGURED DIMENSIONS
IN PREFERENCE TO SCALE.
ALL DIMENSIONS TO BE
VERIFIED ONSITE.

ELECTRICAL DESIGN GROUP
ELECTRICAL BUILDING SERVICES CONSULTANTS
BRISBANE GOLD COAST
P.O. Box 15, Sherwood Q.4075
Phone: (07) 3278 4375
Email: brisbane@edg.net.au
Web: www.edg.net.au

PROJECT:
185 SAMFORD ROAD, ENOGGERA

B	75% DEVELOPMENT	02/10/2024
REV:	DESCRIPTION:	DATE:
DRAWING: ELECTRICAL SERVICES LEVEL 1 FLOOR PLAN		
SCALE: 1:100 UNO	PROJECT NO: C3234a	DRAWING NO: E08
AT A1	REVISION: B	