



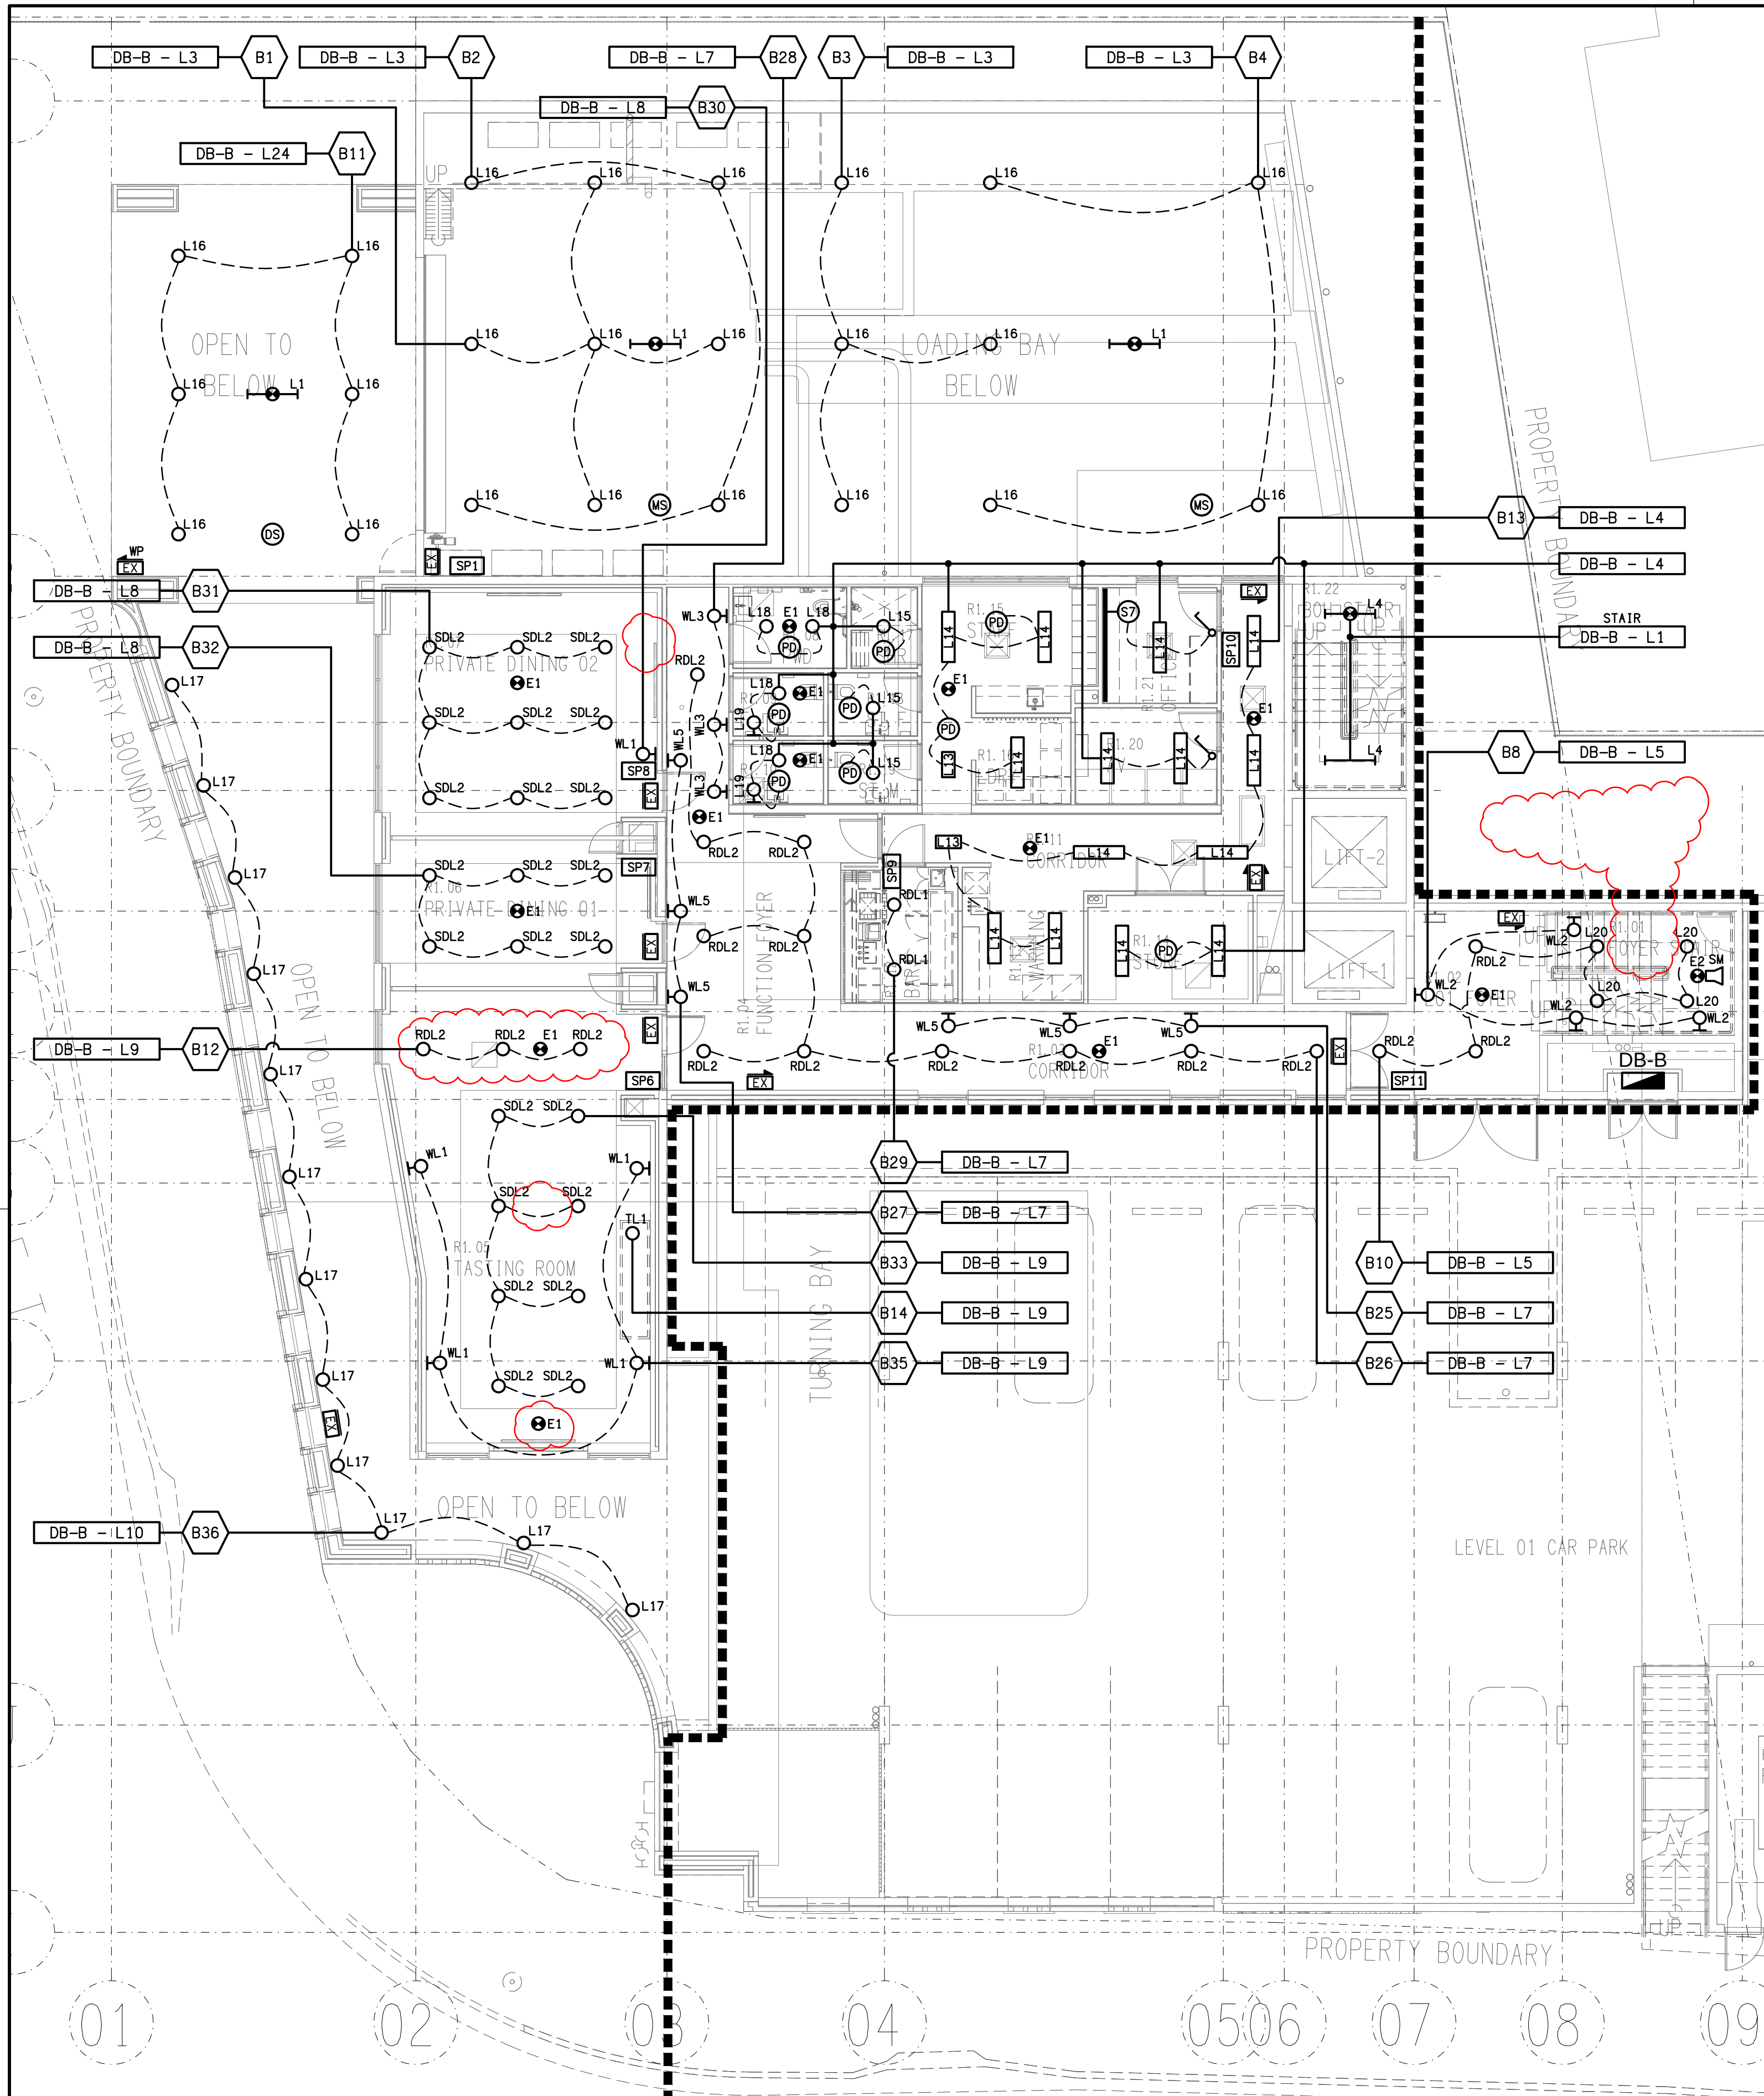

LIGHTING PLAN
LEVEL 1 REFLECTED CEILING PLAN
SCALE 1: 100

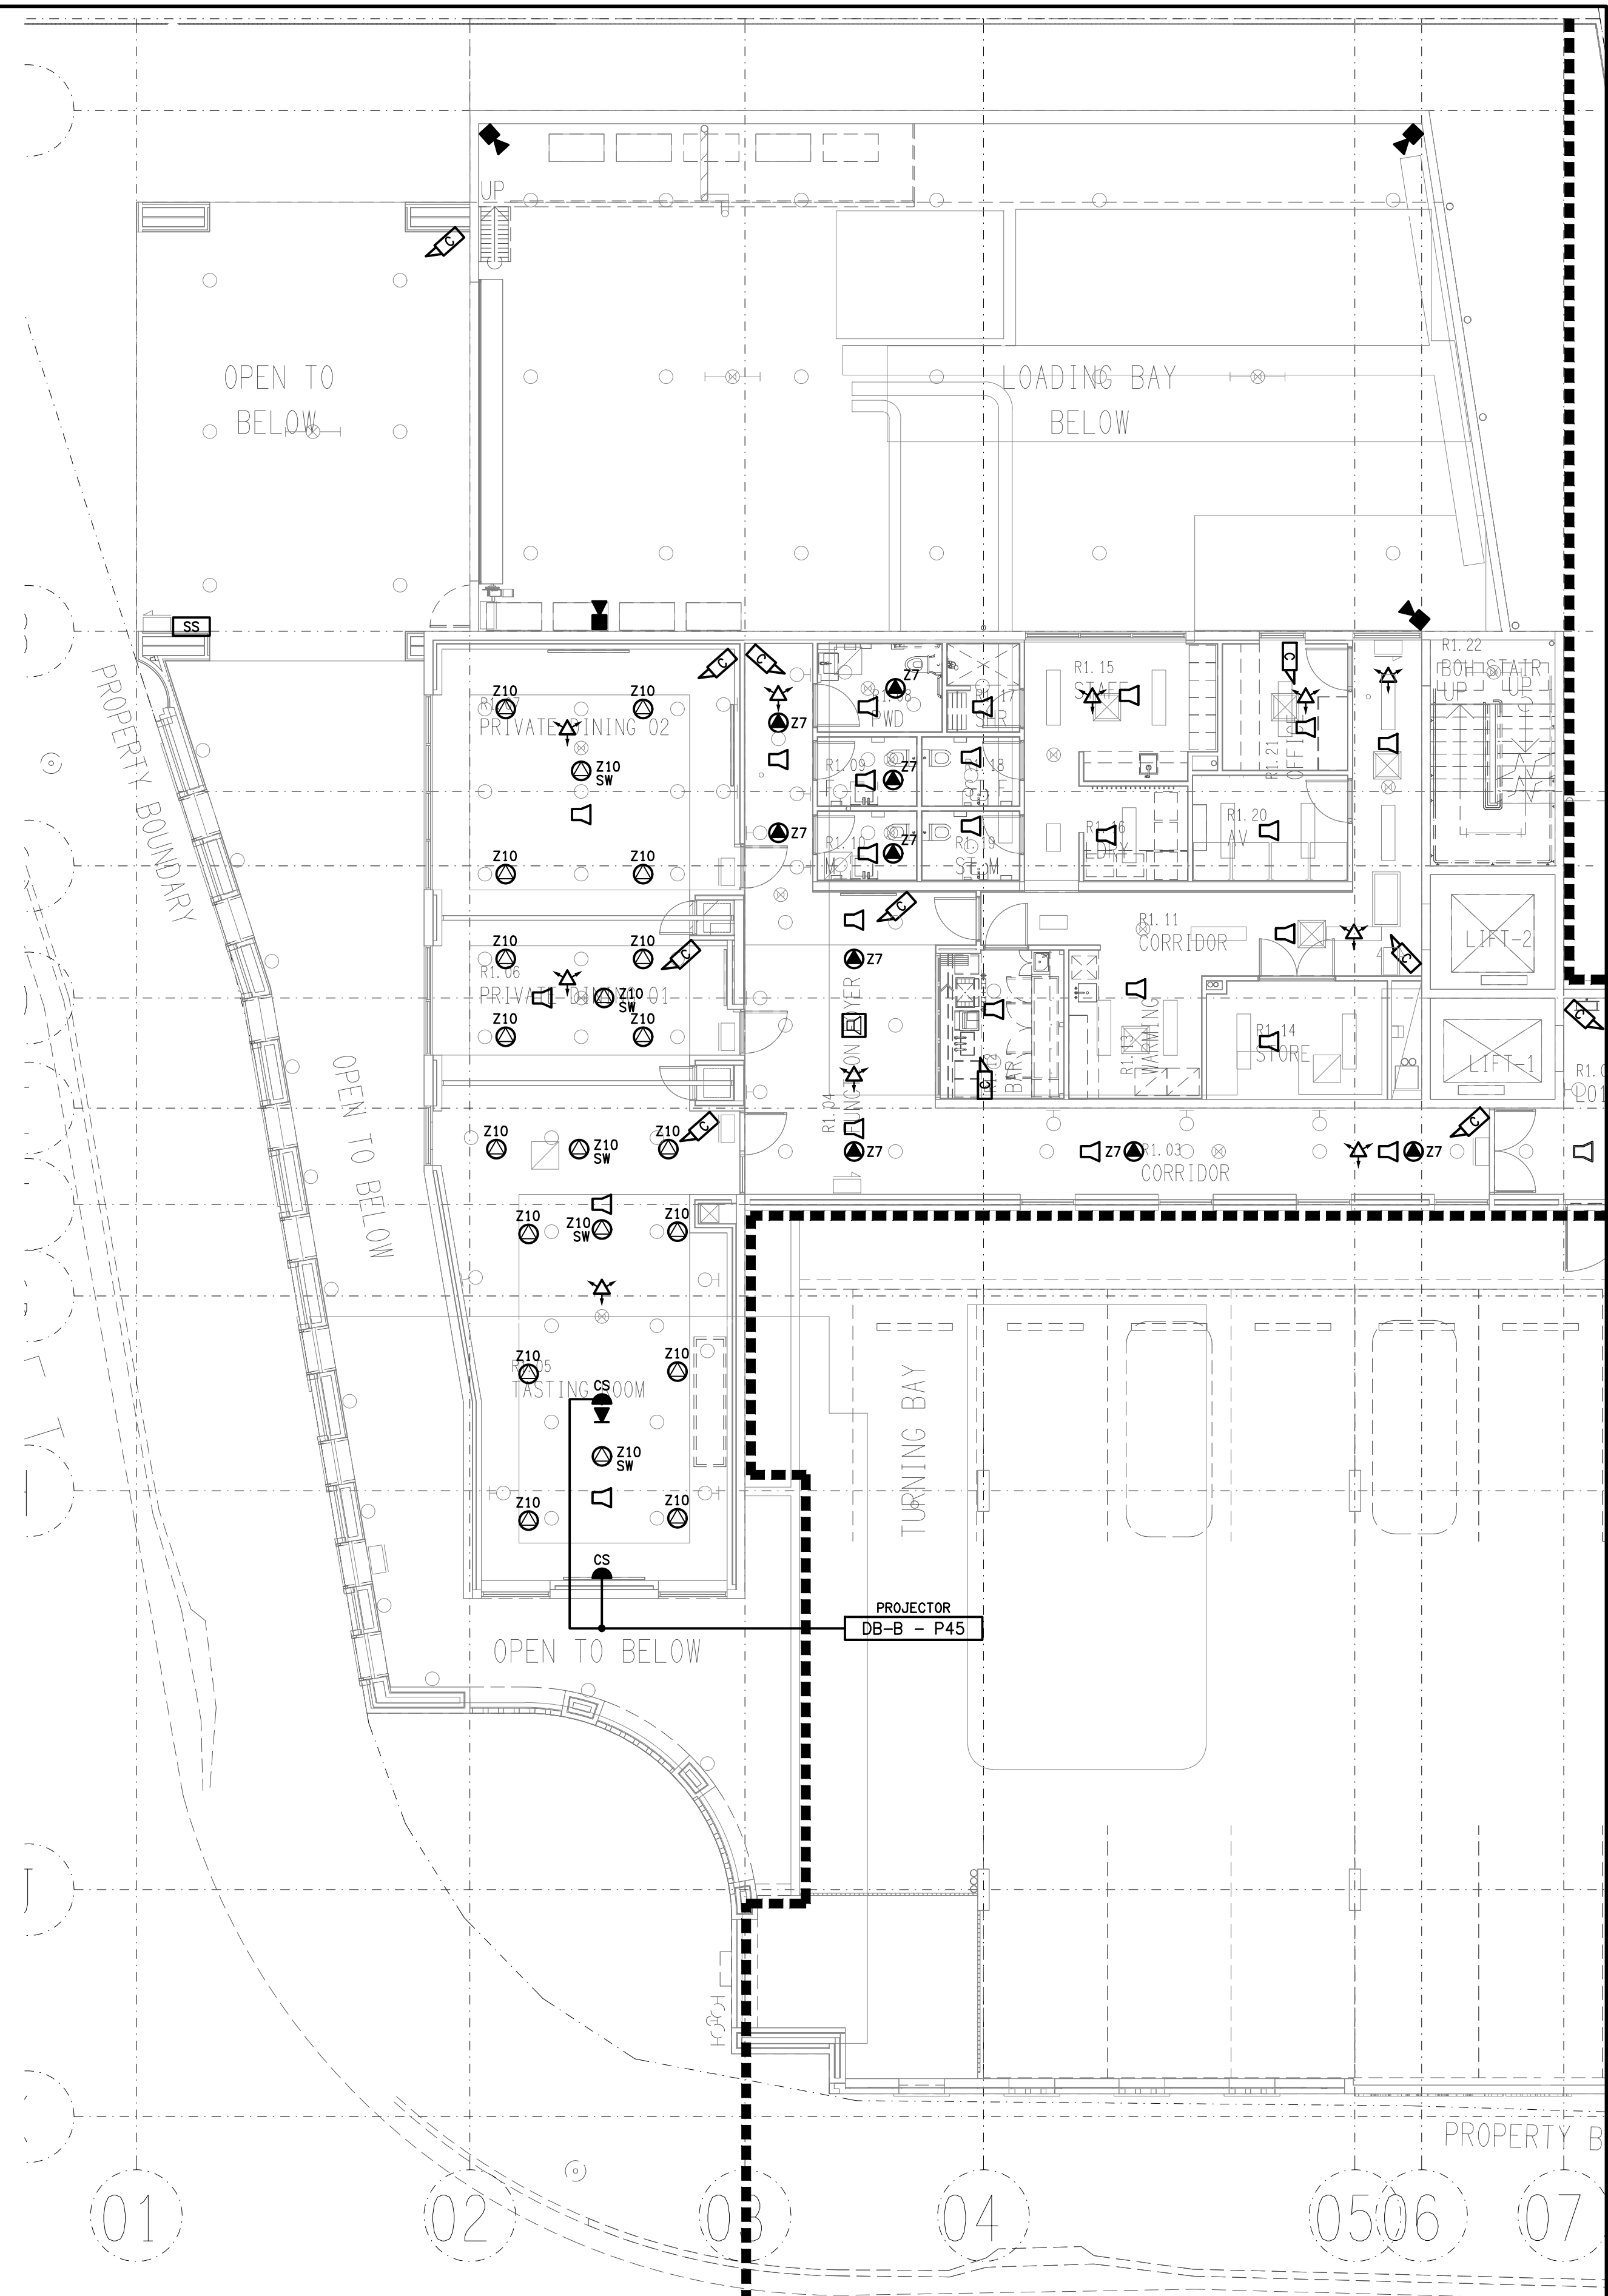

NON LIGHTING PLAN
LEVEL 1 REFLECTED CEILING PLAN
SCALE 1: 100

ELECTRICAL DESIGN GROUP BRISBANE
PTY LTD
ACN 092 710 793
TRADING AS:
ELECTRICAL DESIGN GROUP

THE COPYRIGHT OF THIS DRAWING
REMAINS THE PROPERTY OF THE
ELECTRICAL DESIGN GROUP.
USE FIGURED DIMENSIONS
IN PREFERENCE TO SCALE.
ALL DIMENSIONS TO BE
VERIFIED ONSITE.

ELECTRICAL DESIGN GROUP
ELECTRICAL BUILDING SERVICES CONSULTANTS
BRISBANE GOLD COAST

P.O.Box 15, Sherwood Q.4075
Phone: (07) 3278 4375
Email: brisbane@edg.net.au
Web: www.edg.net.au

PROJECT:
185 SAMFORD ROAD, ENOGGERA

1	CONSTRUCTION	09/05/2025
REV:	DESCRIPTION:	DATE:

DRAWING: ELECTRICAL SERVICES LEVEL 1 REFLECTED CEILING PLAN		PROJECT NO: C3234a	DRAWING NO: E11	REVISION: 1
SCALE: 1:100	AT A1			