


**LIGHTING PLAN**  
LEVEL 1 REFLECTED CEILING PLAN  
SCALE 1:100

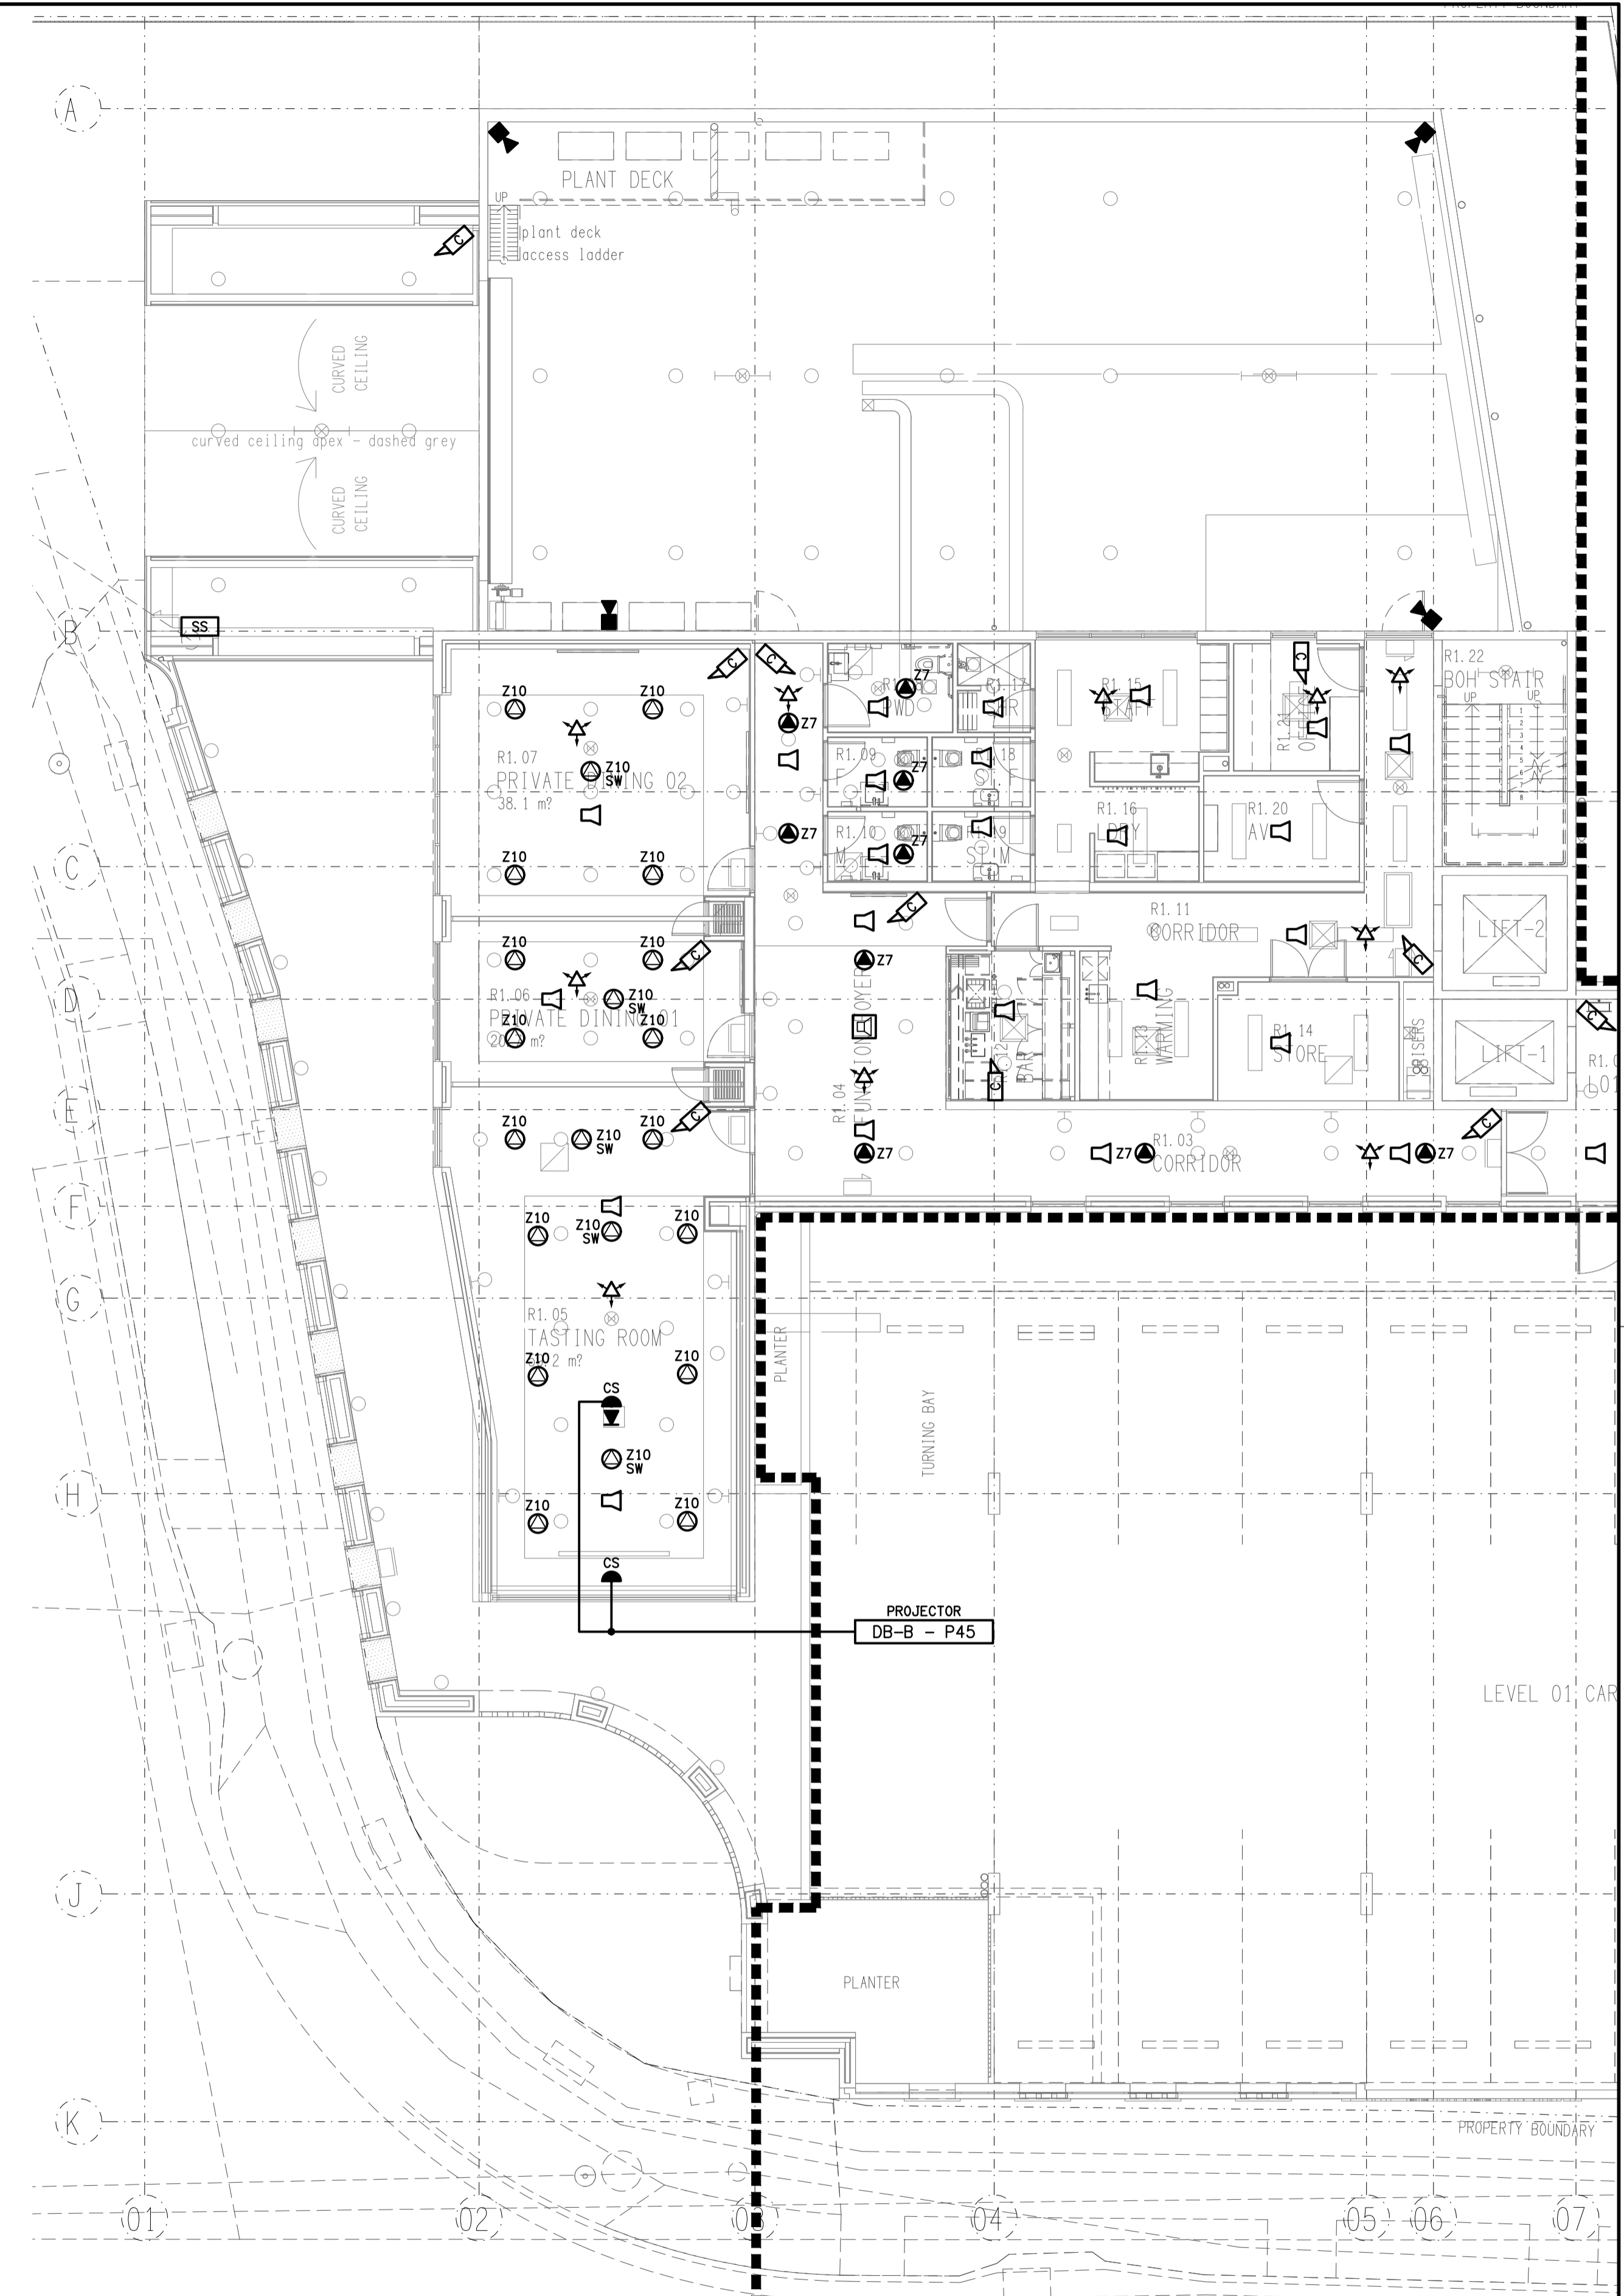

**NON LIGHTING PLAN**  
LEVEL 1 REFLECTED CEILING PLAN  
SCALE 1:100

ELECTRICAL DESIGN GROUP BRISBANE  
PTY LTD  
ACN 092 710 793  
TRADING AS:  
ELECTRICAL DESIGN GROUP

THE COPYRIGHT OF THIS DRAWING  
REMAINS THE PROPERTY OF THE  
ELECTRICAL DESIGN GROUP.  
USE FIGURED DIMENSIONS  
IN PREFERENCE TO SCALE.  
ALL DIMENSIONS TO BE  
VERIFIED ONSITE.

**ELECTRICAL DESIGN GROUP**  
ELECTRICAL BUILDING SERVICES CONSULTANTS  
BRISBANE GOLD COAST  
P.O. Box 15, Sherwood Q.4075  
Phone: (07) 3278 4375  
Email: brisbane@edg.net.au  
Web: www.edg.net.au

PROJECT:  
185 SAMFORD ROAD, ENOGGERA

B	75% DEVELOPMENT	02/10/2024
REV:	DESCRIPTION:	DATE:
DRAWING: <b>ELECTRICAL SERVICES</b> <b>LEVEL 1</b> <b>REFLECTED CEILING PLAN</b>		
SCALE: 1:100	PROJECT NO: C3234a	DRAWING NO: E11
AT A1	REVISION: B	