


**REFLECTED CEILING PLAN**  
 PROPOSED TENANCIES  
 SCALE 1:100

THE TENANCY L1 LIGHT FITTINGS HAVE BEEN CHANGED FROM BATTENS TO TROFFERS AT THIS REVISION B.

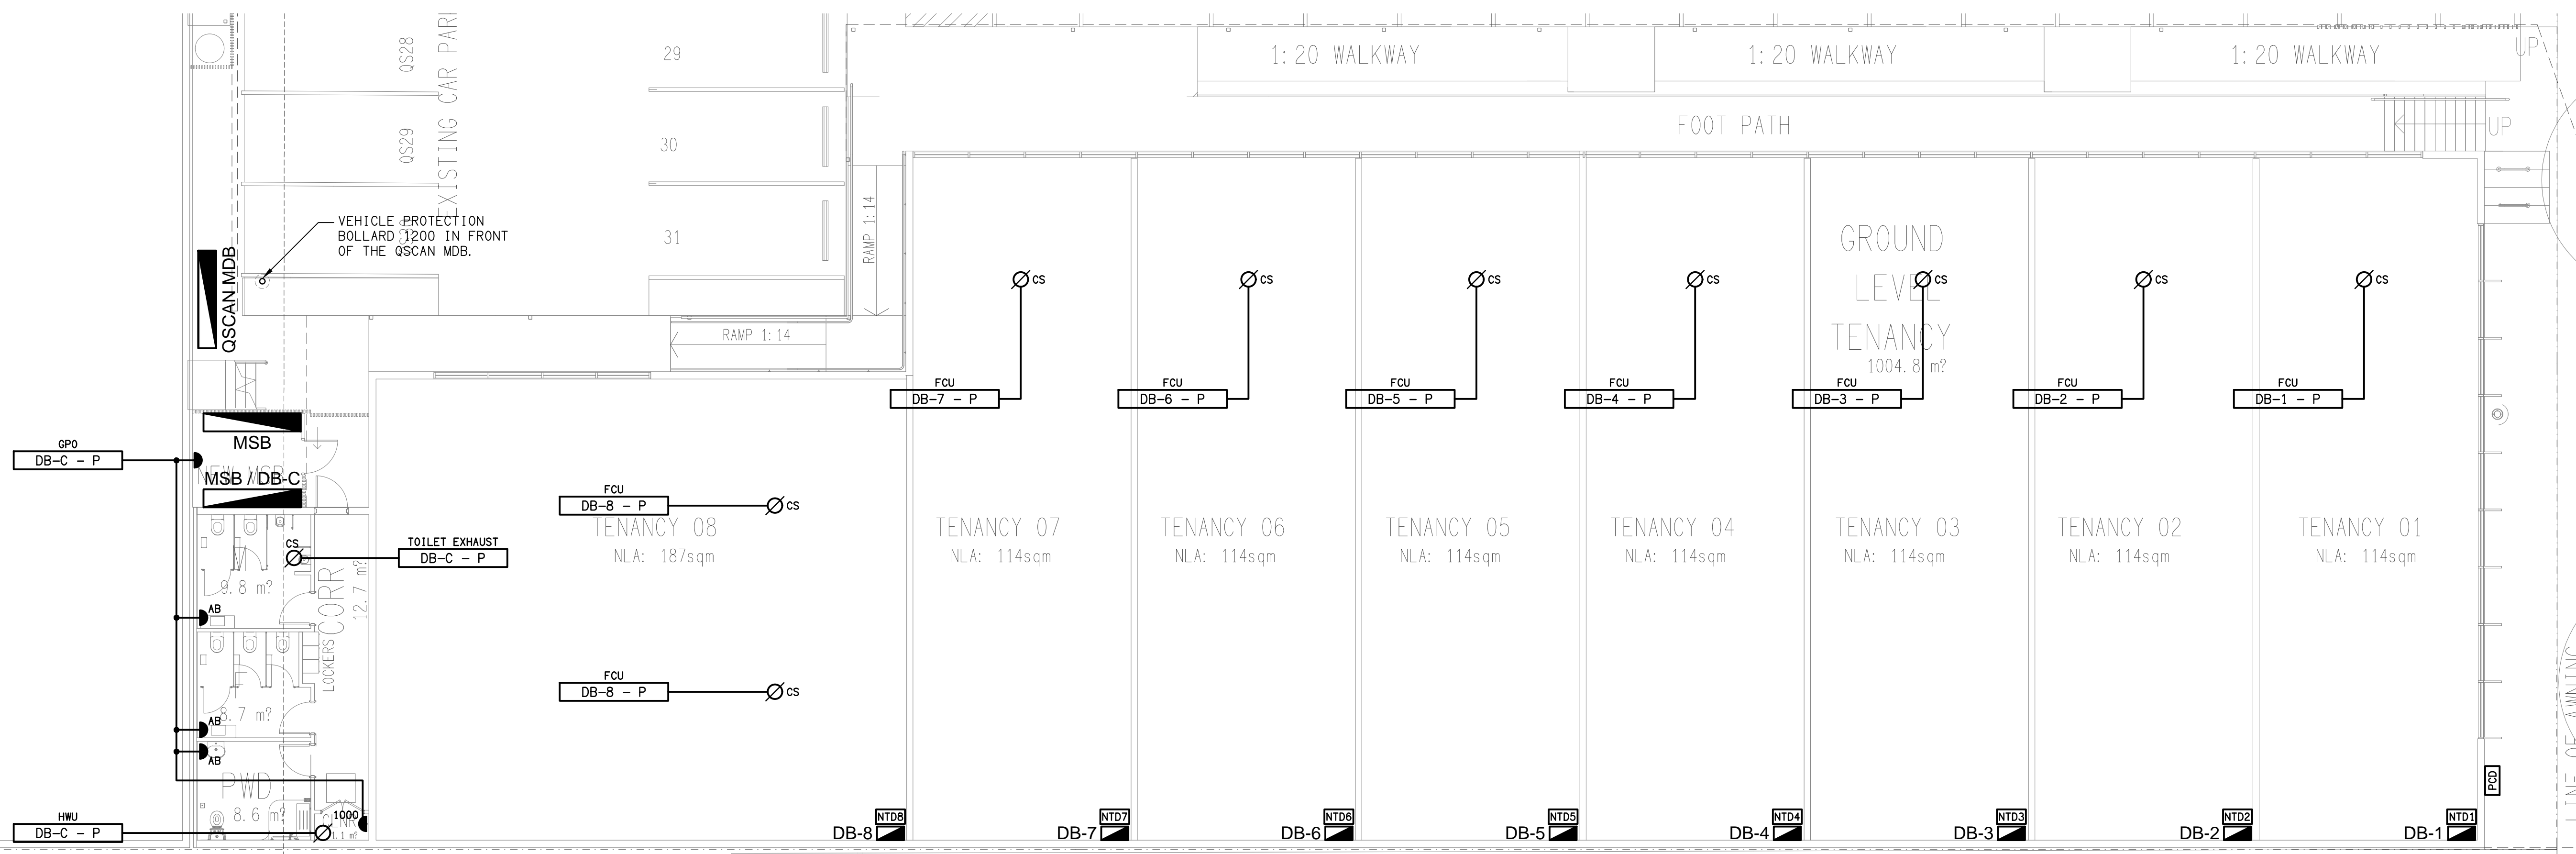

**FLOOR PLAN**  
 PROPOSED TENANCIES  
 SCALE 1:100

ELECTRICAL DESIGN GROUP BRISBANE  
 PTY LTD  
 ACN 092 710 793  
 TRADING AS:  
 ELECTRICAL DESIGN GROUP

THE COPYRIGHT OF THIS DRAWING  
 REMAINS THE PROPERTY OF THE  
 ELECTRICAL DESIGN GROUP.  
 USE FIGURED DIMENSIONS  
 IN PREFERENCE TO SCALE.  
 ALL DIMENSIONS TO BE  
 VERIFIED ONSITE.

**ELECTRICAL DESIGN GROUP**  
 ELECTRICAL BUILDING SERVICES CONSULTANTS  
 BRISBANE GOLD COAST

P.O. Box 15, Sherwood Q.4075  
 Phone: (07) 3278 4375  
 Email: brisbane@edg.net.au  
 Web: www.edg.net.au

PROJECT:  
 6 SILVYN STREET, REDCLIFFE

|      |              |            |
|------|--------------|------------|
| B    | TENDER       | 24/06/2024 |
| REV. | DESCRIPTION: | DATE:      |

DRAWING:  
**ELECTRICAL SERVICES**  
**FLOOR & REFLECTED CEILING PLAN**

SCALE:  
 1:100

AT A1

PROJECT NO:  
**C3242a**

DRAWING NO:  
**E03**

REVISION:  
**B**