



DONALDSON
GROUND LEVEL REFLECTED CEILING PLAN
SCALE 1:50

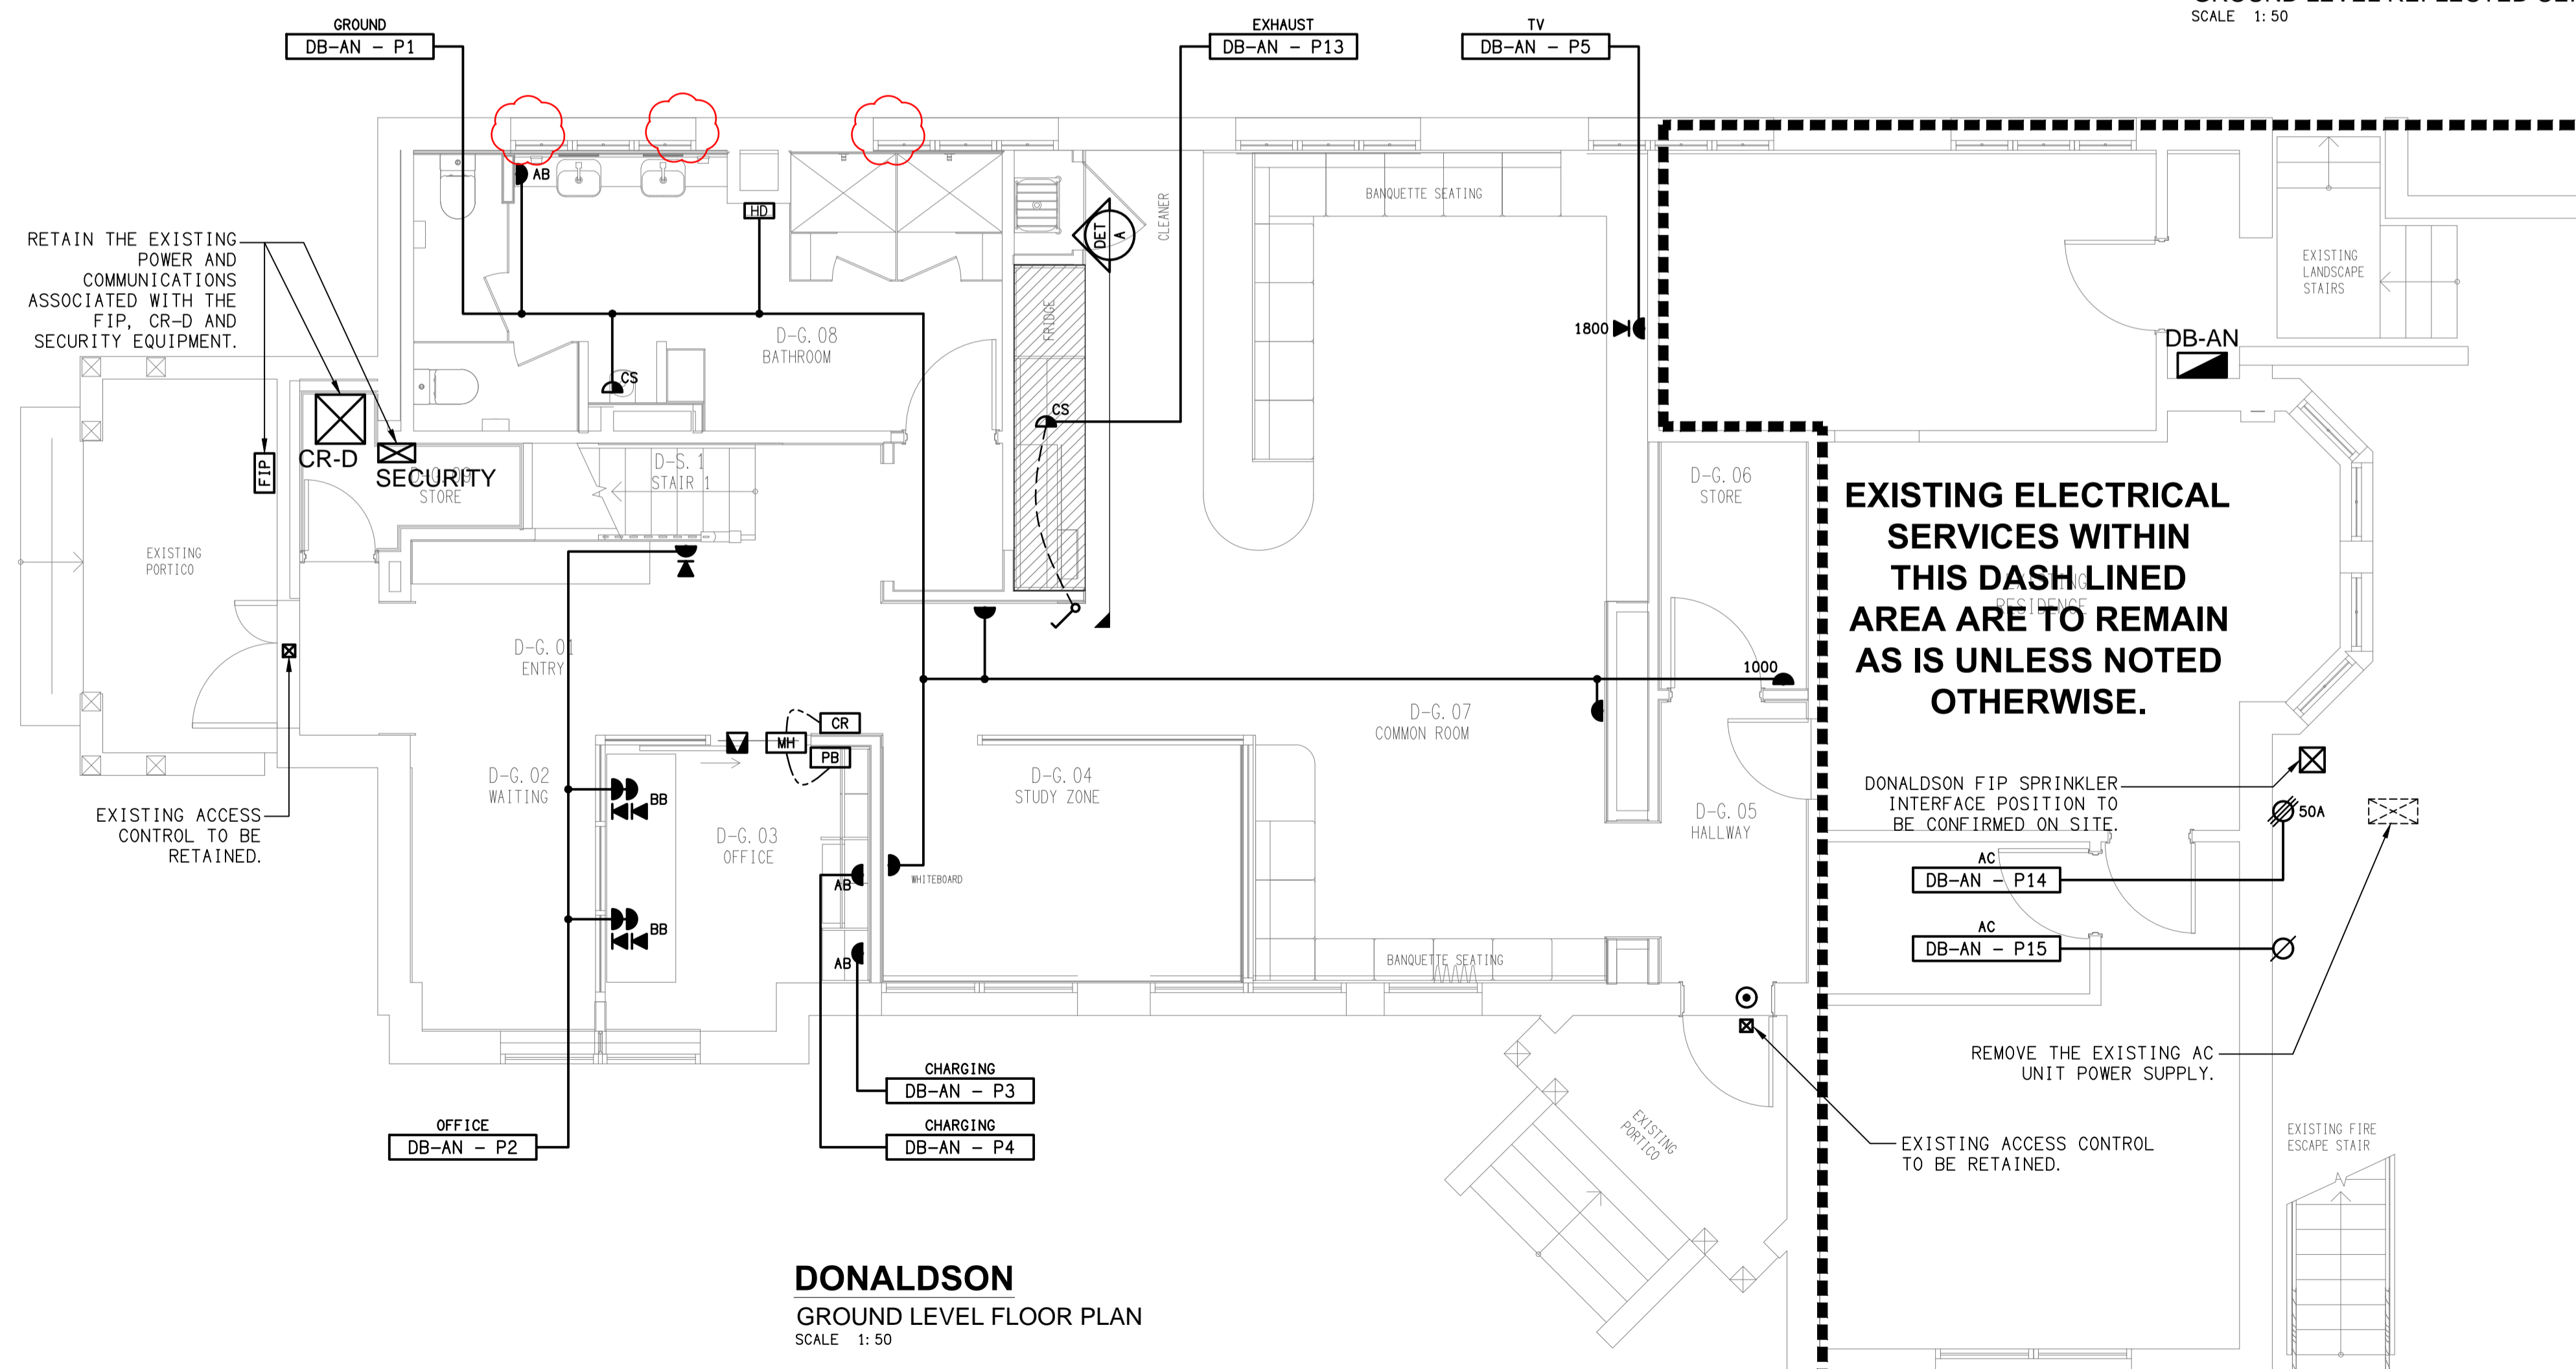

DONALDSON
GROUND LEVEL FLOOR PLAN
SCALE 1:50

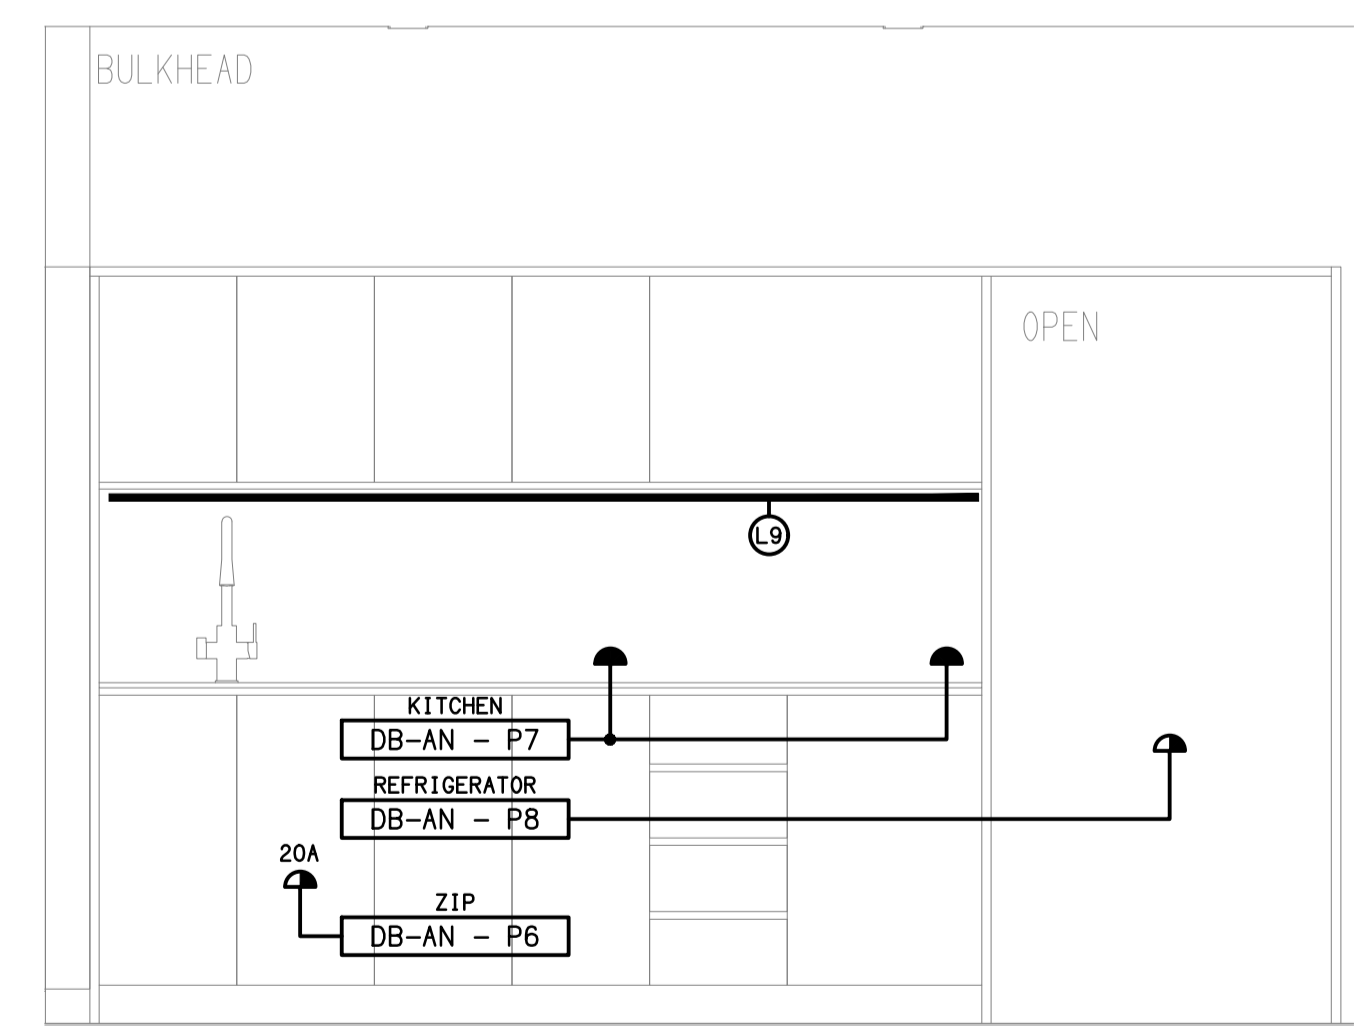

DETAIL A
KITCHENETTE ELEVATION
SCALE 1:20

ELECTRICAL DESIGN GROUP BRISBANE PTY LTD
ACN 092 710 793
TRADING AS:
ELECTRICAL DESIGN GROUP

THE COPYRIGHT OF THIS DRAWING REMAINS THE PROPERTY OF THE ELECTRICAL DESIGN GROUP.
USE FIGURED DIMENSIONS IN PREFERENCE TO SCALE.
ALL DIMENSIONS TO BE VERIFIED ONSITE.

ELECTRICAL DESIGN GROUP
ELECTRICAL BUILDING SERVICES CONSULTANTS
BRISBANE GOLD COAST
P.O. Box 15, Sherwood Q.4075
Phone: (07) 3278 4375
Email: brisbane@edg.net.au
Web: www.edg.net.au

PROJECT:
**ANGLICAN CHURCH GRAMMAR SCHOOL
YEAR 7 BOARDING**
OAKLANDS PARADE, EAST BRISBANE

E	TENDER	16/07/2024
REV.	DESCRIPTION:	DATE:
DRAWING: ELECTRICAL SERVICES DONALDSON GROUND LEVEL PLANS		
SCALE: 1:50 UNO	AT A1	PROJECT NO: C3247a
		DRAWING NO: E04
		REVISION: E