



DONALDSON
GROUND LEVEL REFLECTED CEILING PLAN
SCALE 1:50

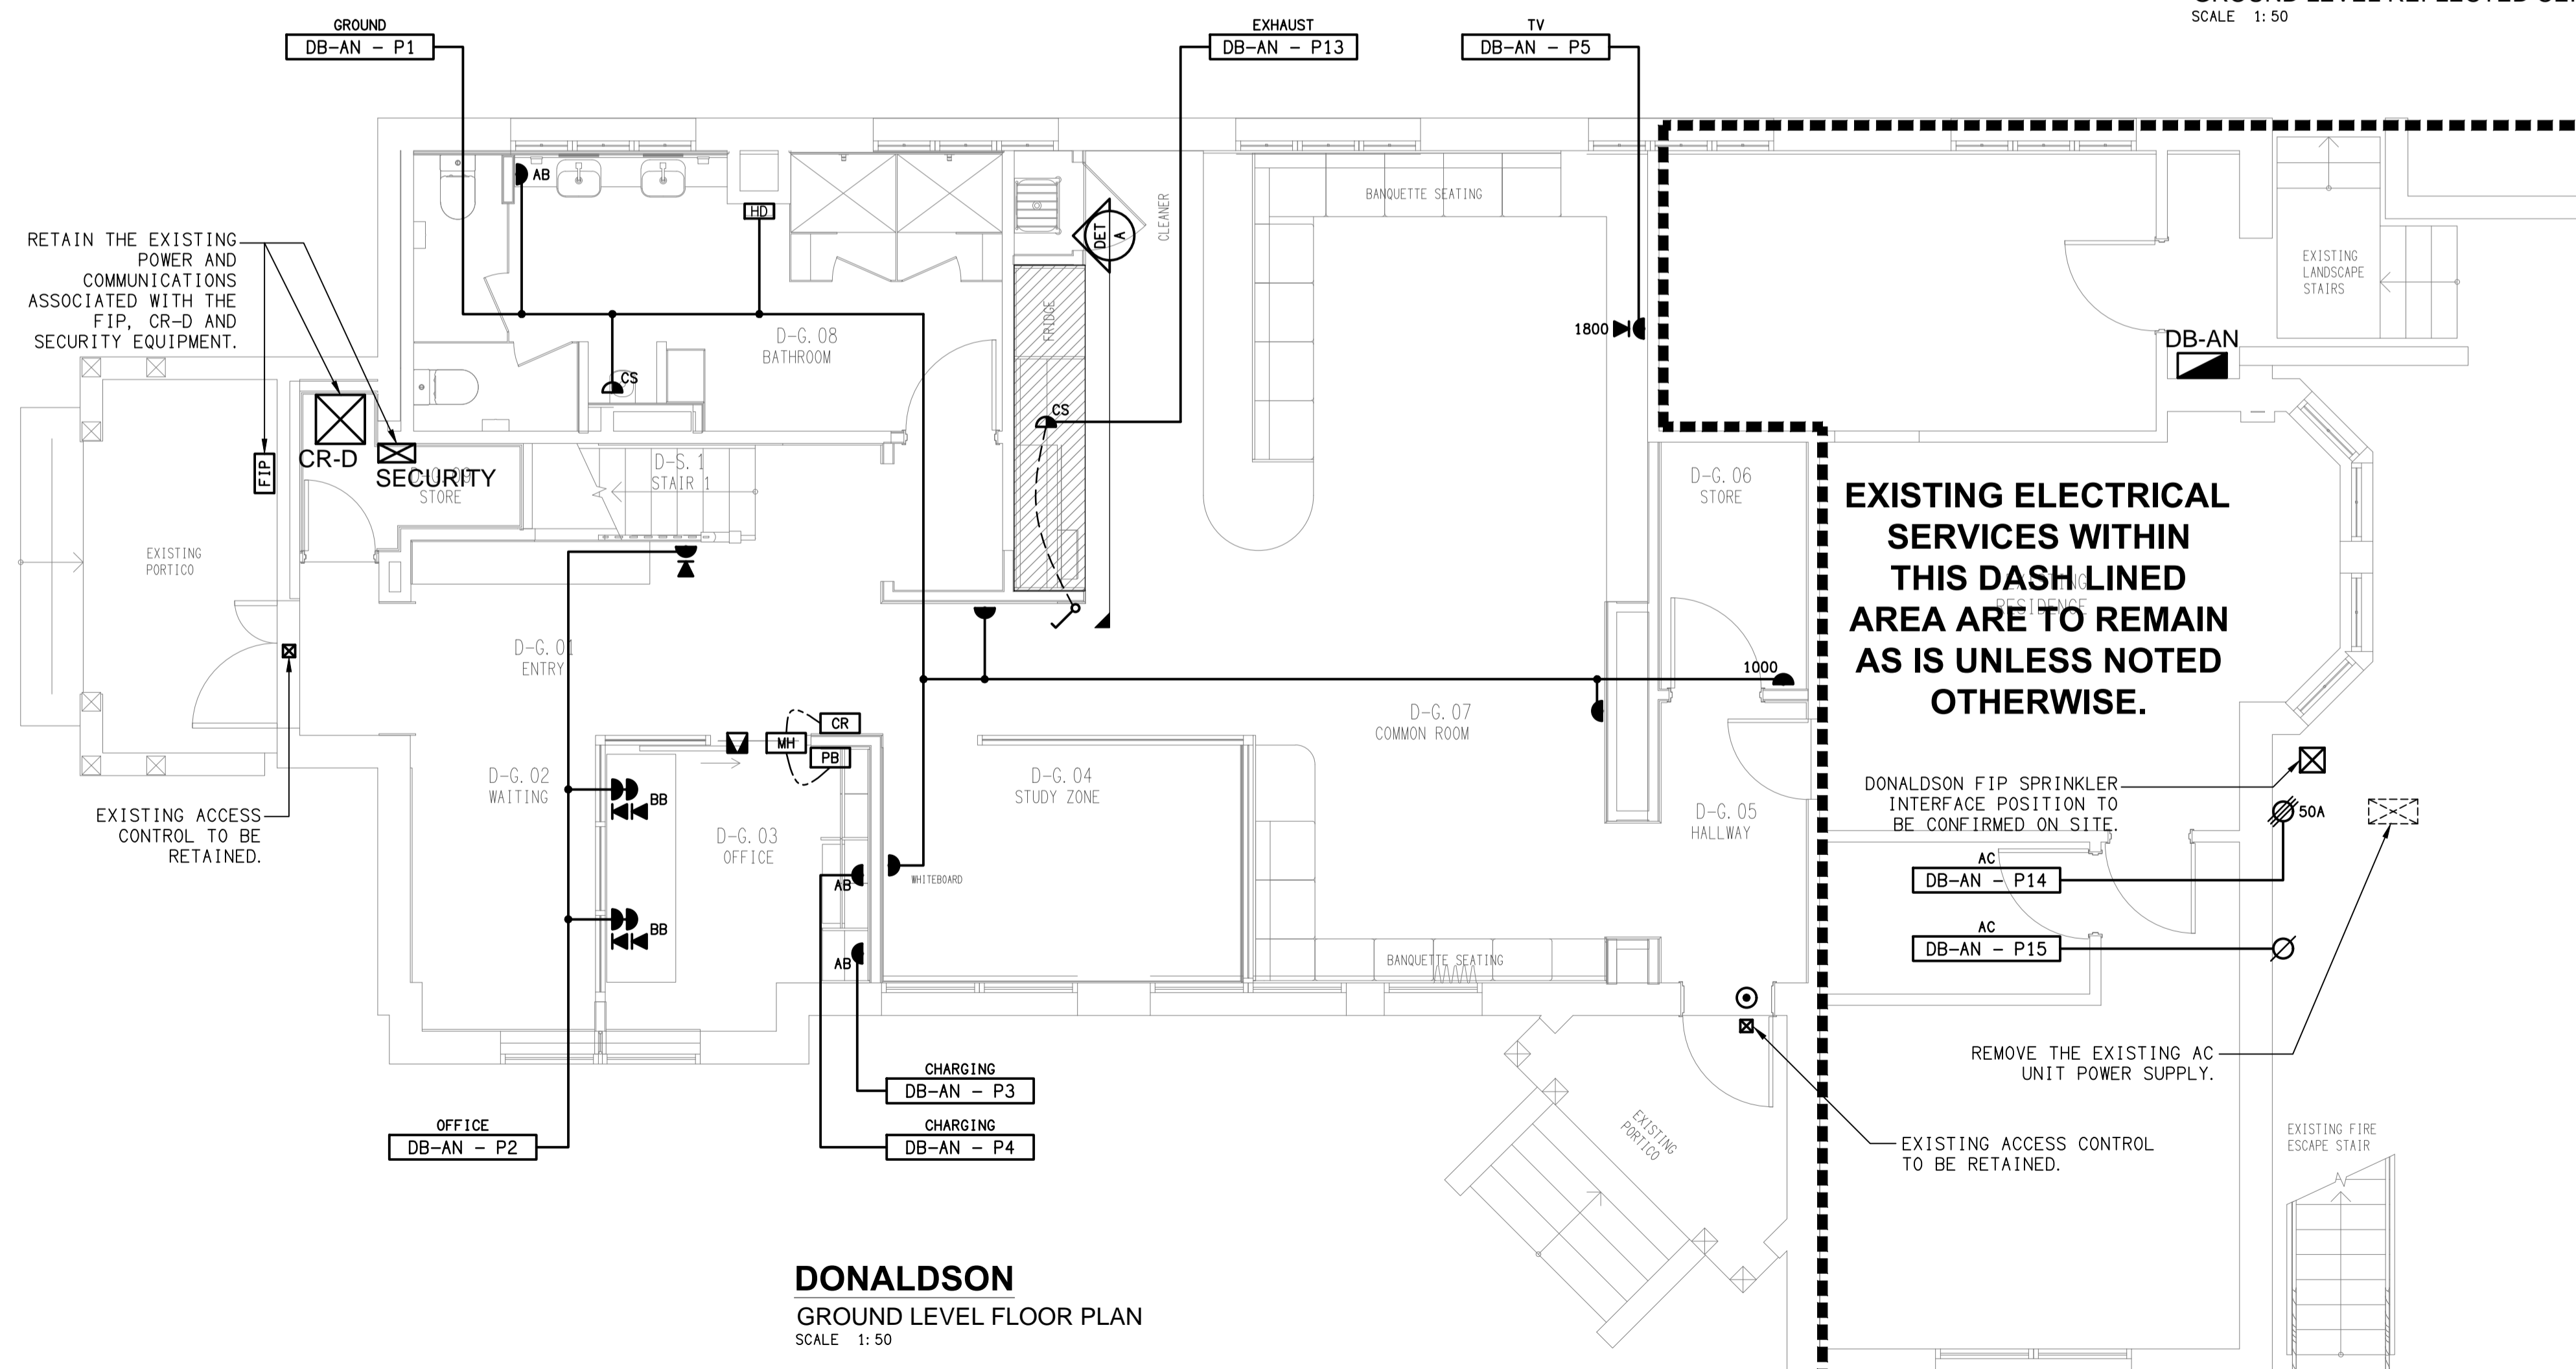

DONALDSON
GROUND LEVEL FLOOR PLAN
SCALE 1:50

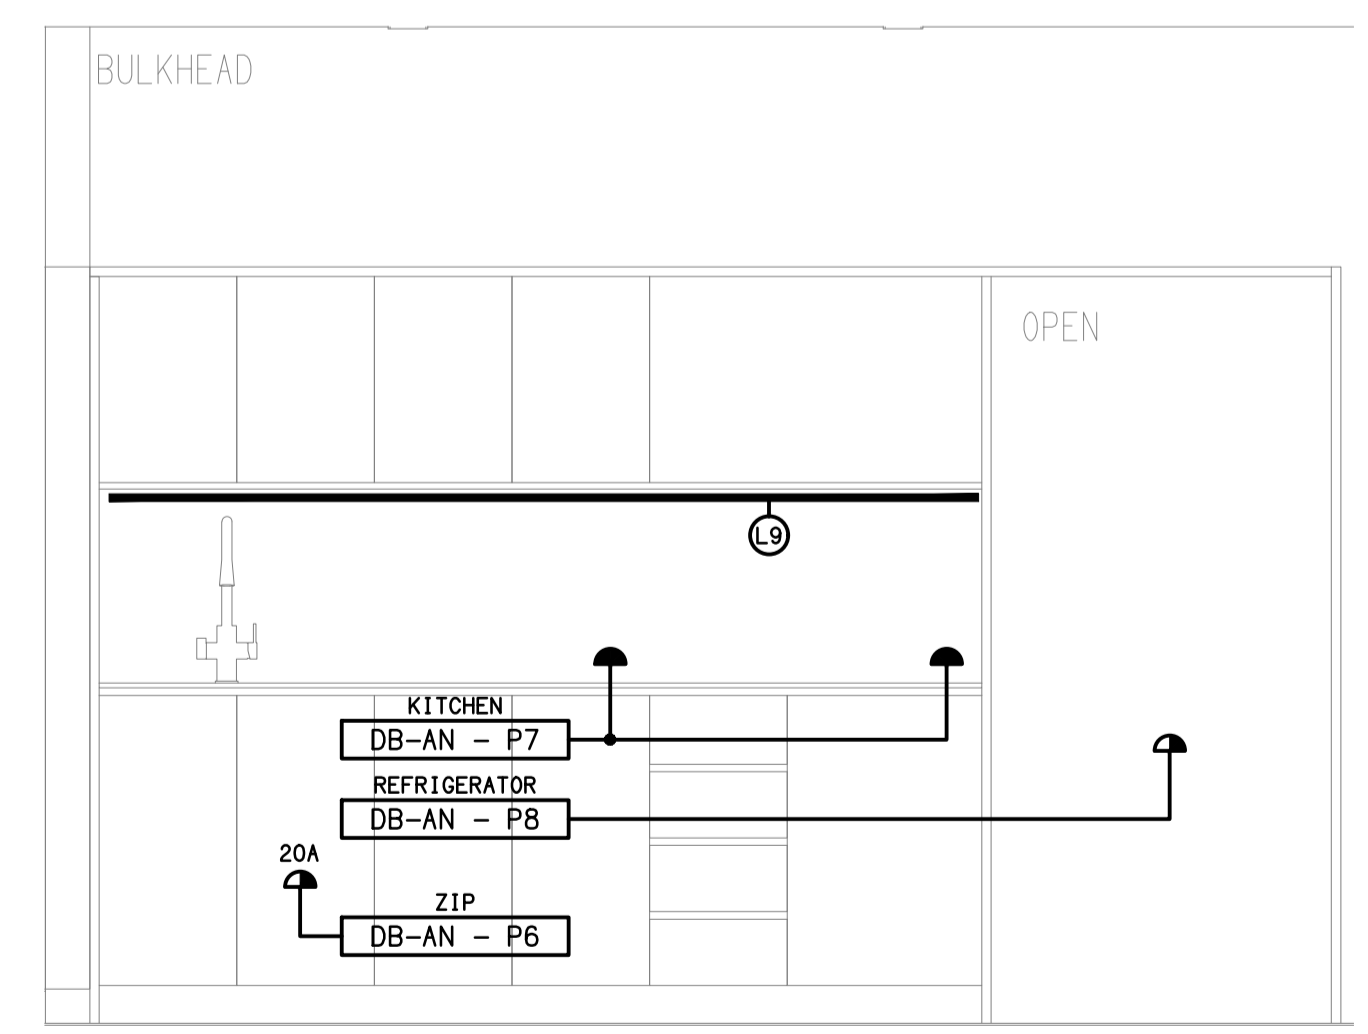

DETAIL A
KITCHENETTE ELEVATION
SCALE 1:20

ELECTRICAL DESIGN GROUP BRISBANE
PTY LTD
ACN 092 710 793
TRADING AS:
ELECTRICAL DESIGN GROUP

THE COPYRIGHT OF THIS DRAWING
REMAINS THE PROPERTY OF THE
ELECTRICAL DESIGN GROUP.
USE FIGURED DIMENSIONS
IN PREFERENCE TO SCALE.
ALL DIMENSIONS TO BE
VERIFIED ONSITE.

ELECTRICAL DESIGN GROUP
ELECTRICAL BUILDING SERVICES CONSULTANTS
BRISBANE GOLD COAST
P.O. Box 15, Sherwood Q.4075
Phone: (07) 3278 4375
Email: brisbane@edg.net.au
Web: www.edg.net.au

PROJECT:
**ANGLICAN CHURCH GRAMMAR SCHOOL
YEAR 7 BOARDING**
OAKLANDS PARADE, EAST BRISBANE

H	CONSTRUCTION	30/09/2024
REV.	DESCRIPTION:	DATE:
DRAWING: ELECTRICAL SERVICES DONALDSON GROUND LEVEL PLANS		
SCALE: 1:50 UNO	PROJECT NO: C3247a	DRAWING NO: E04
AT A1	REVISION: H	