



**DONALDSON**  
UPPER LEVEL REFLECTED CEILING PLAN  
SCALE 1:50

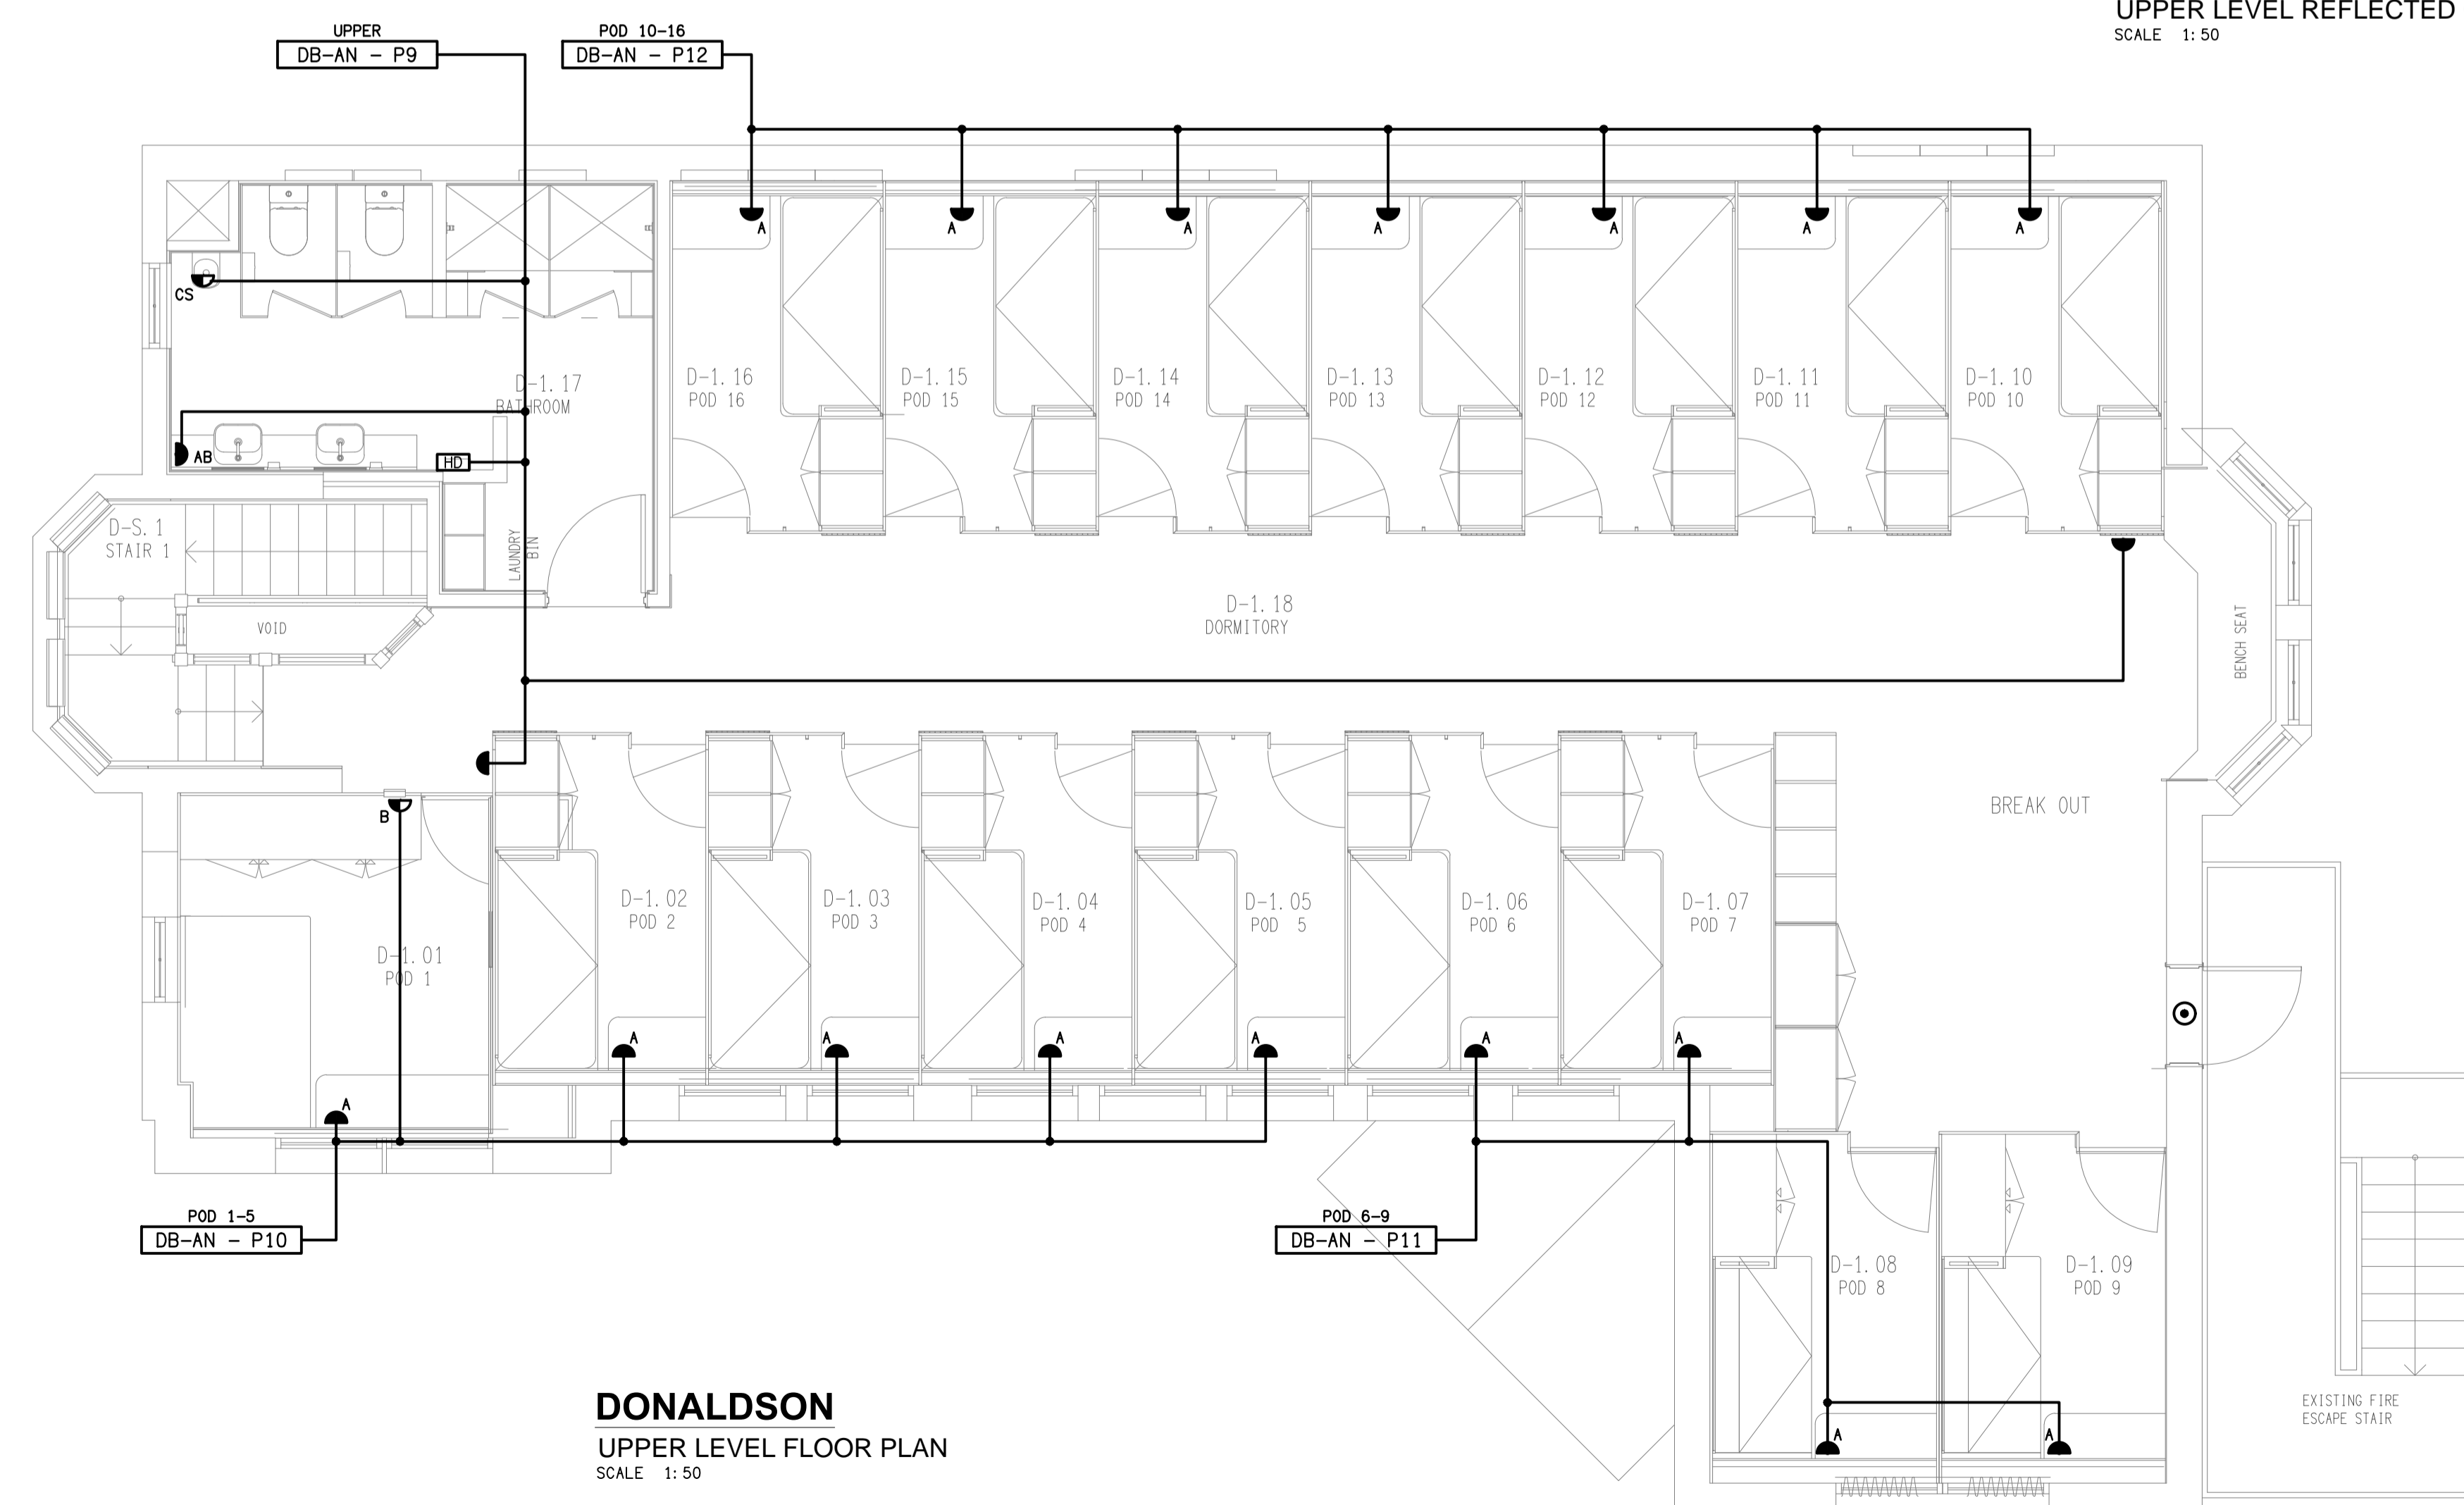

**DONALDSON**  
UPPER LEVEL FLOOR PLAN  
SCALE 1:50

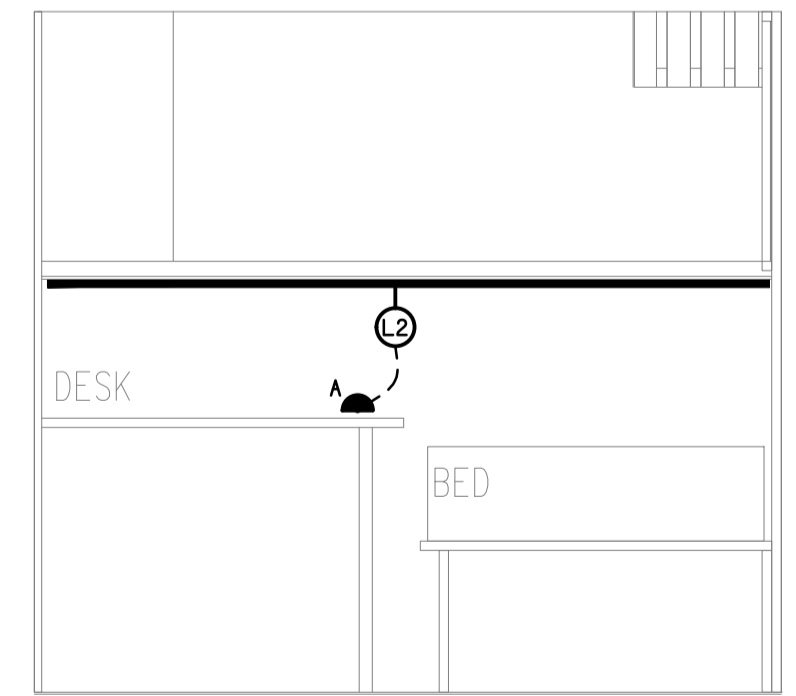

**DETAIL A**  
TYPICAL BEDROOM POD 3 ELEVATION  
SCALE 1:20

ELECTRICAL DESIGN GROUP BRISBANE PTY LTD  
ACN 092 710 793  
TRADING AS:  
ELECTRICAL DESIGN GROUP

THE COPYRIGHT OF THIS DRAWING REMAINS THE PROPERTY OF THE ELECTRICAL DESIGN GROUP.  
USE FIGURED DIMENSIONS IN PREFERENCE TO SCALE.  
ALL DIMENSIONS TO BE VERIFIED ONSITE.

**ELECTRICAL DESIGN GROUP**  
ELECTRICAL BUILDING SERVICES CONSULTANTS  
BRISBANE GOLD COAST  
P.O. Box 15, Sherwood Q.4075  
Phone: (07) 3278 4375  
Email: brisbane@edg.net.au  
Web: www.edg.net.au

PROJECT:  
**ANGLICAN CHURCH GRAMMAR SCHOOL  
YEAR 7 BOARDING**  
OAKLANDS PARADE, EAST BRISBANE

G	CONSTRUCTION	30/09/2024
REV:	DESCRIPTION:	DATE:
DRAWING: <b>ELECTRICAL SERVICES DONALDSON UPPER LEVEL PLANS</b>		
SCALE: 1:50 UNO	AT A1	PROJECT NO: <b>C3247a</b>
		DRAWING NO: <b>E05</b>
		REVISION: <b>G</b>