



GERALD WING
GROUND LEVEL REFLECTED CEILING PLAN
SCALE 1:50

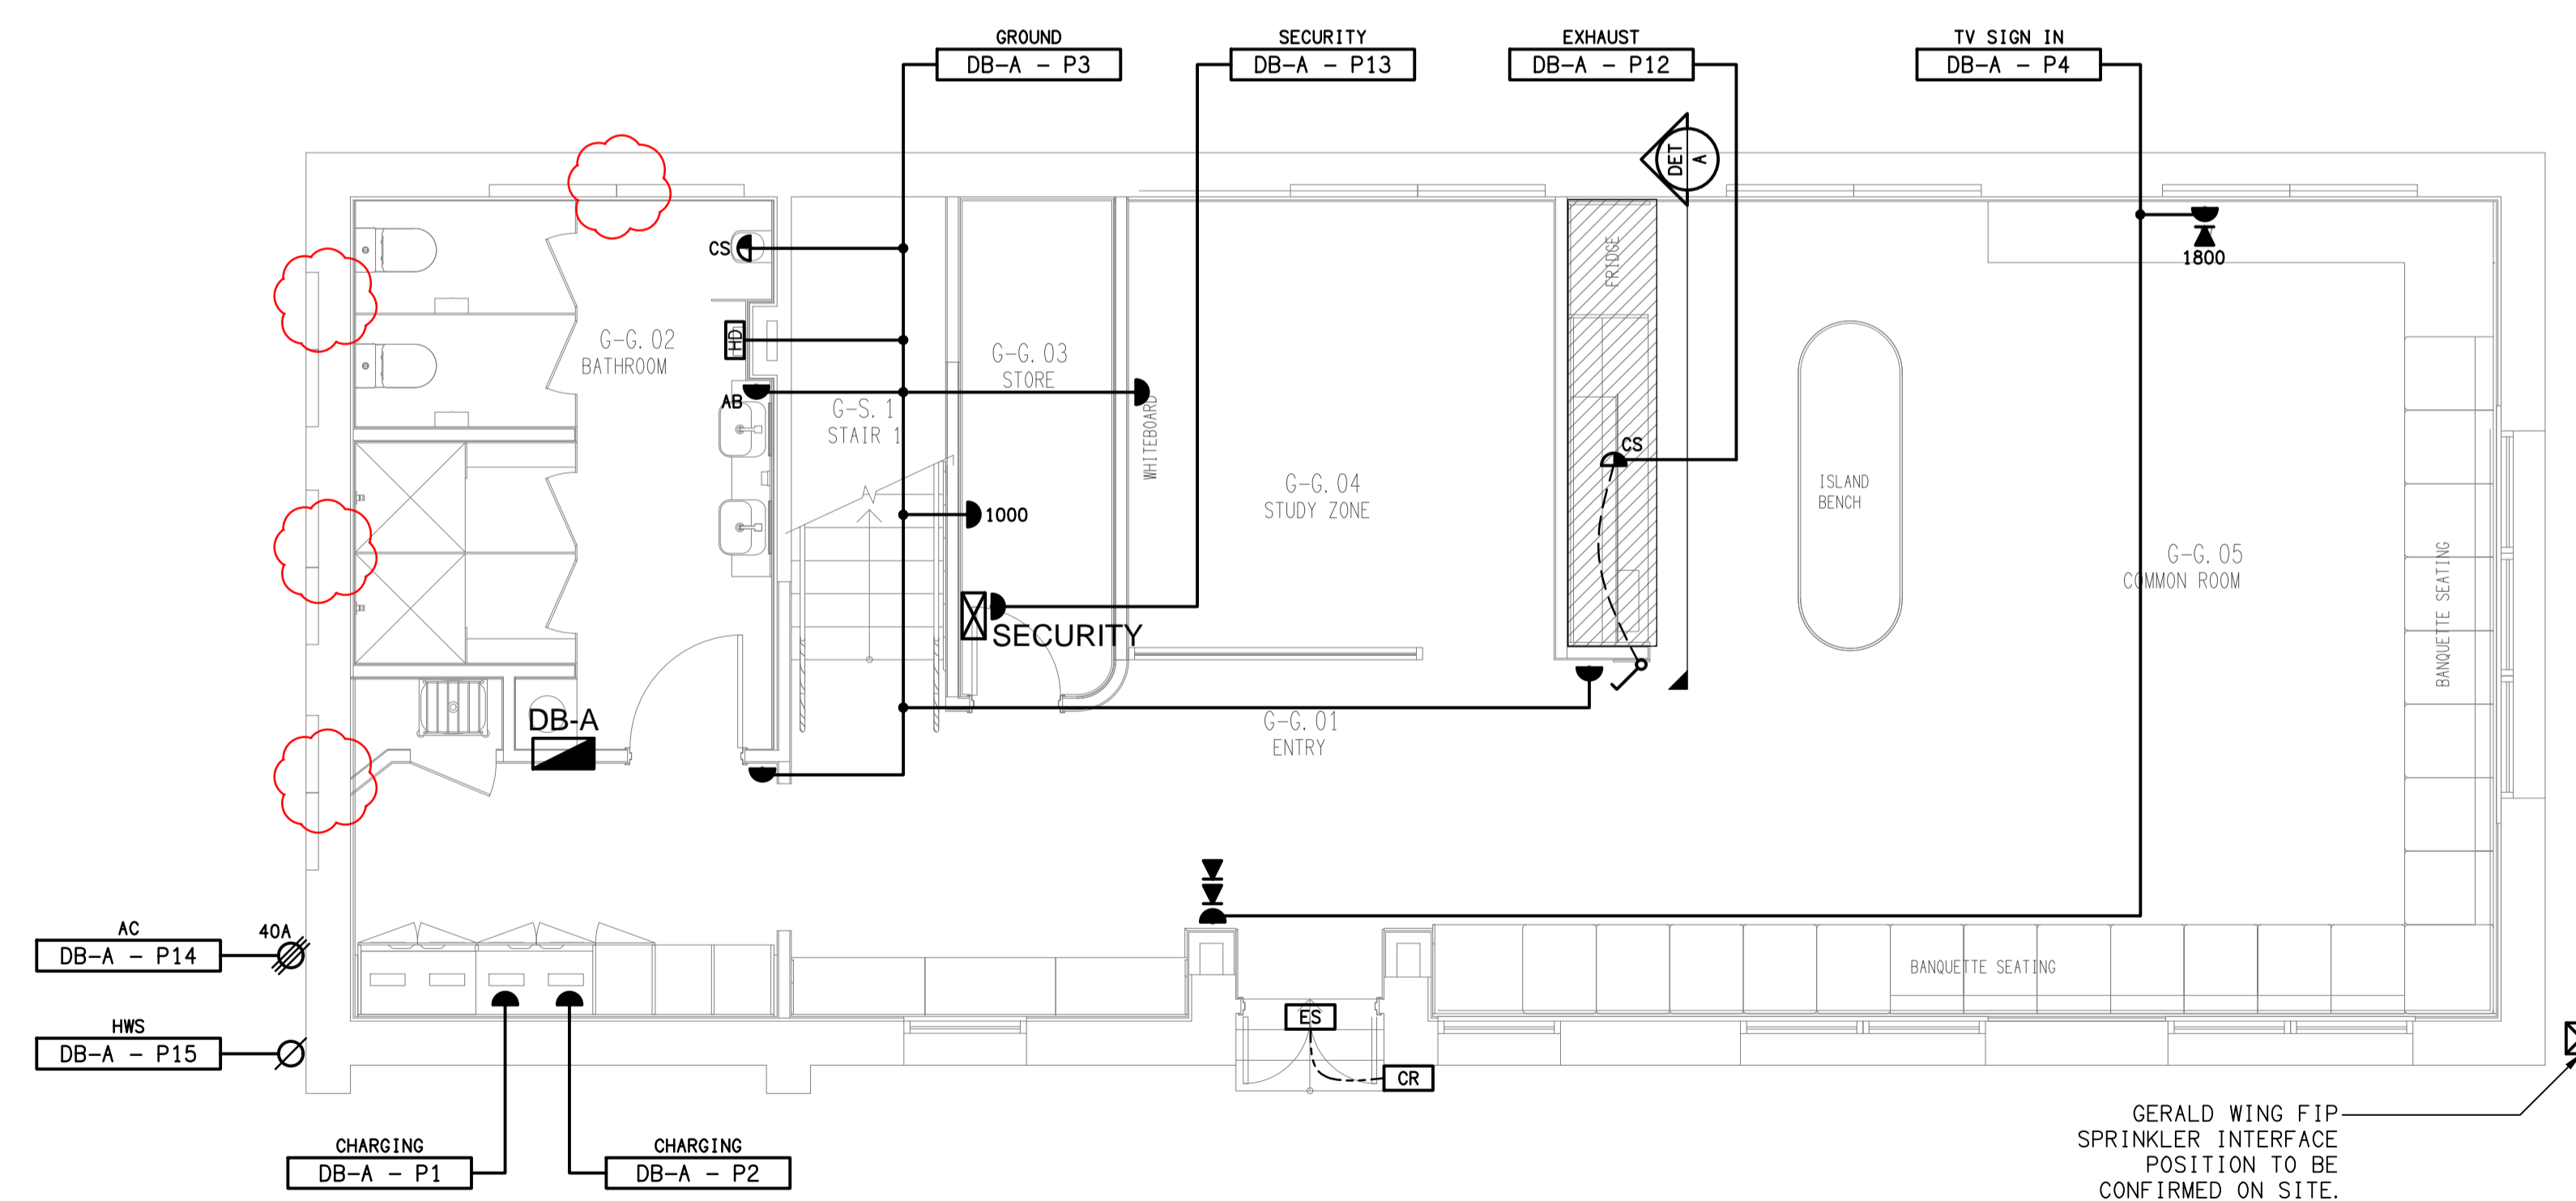

GERALD WING
GROUND LEVEL FLOOR PLAN
SCALE 1:50

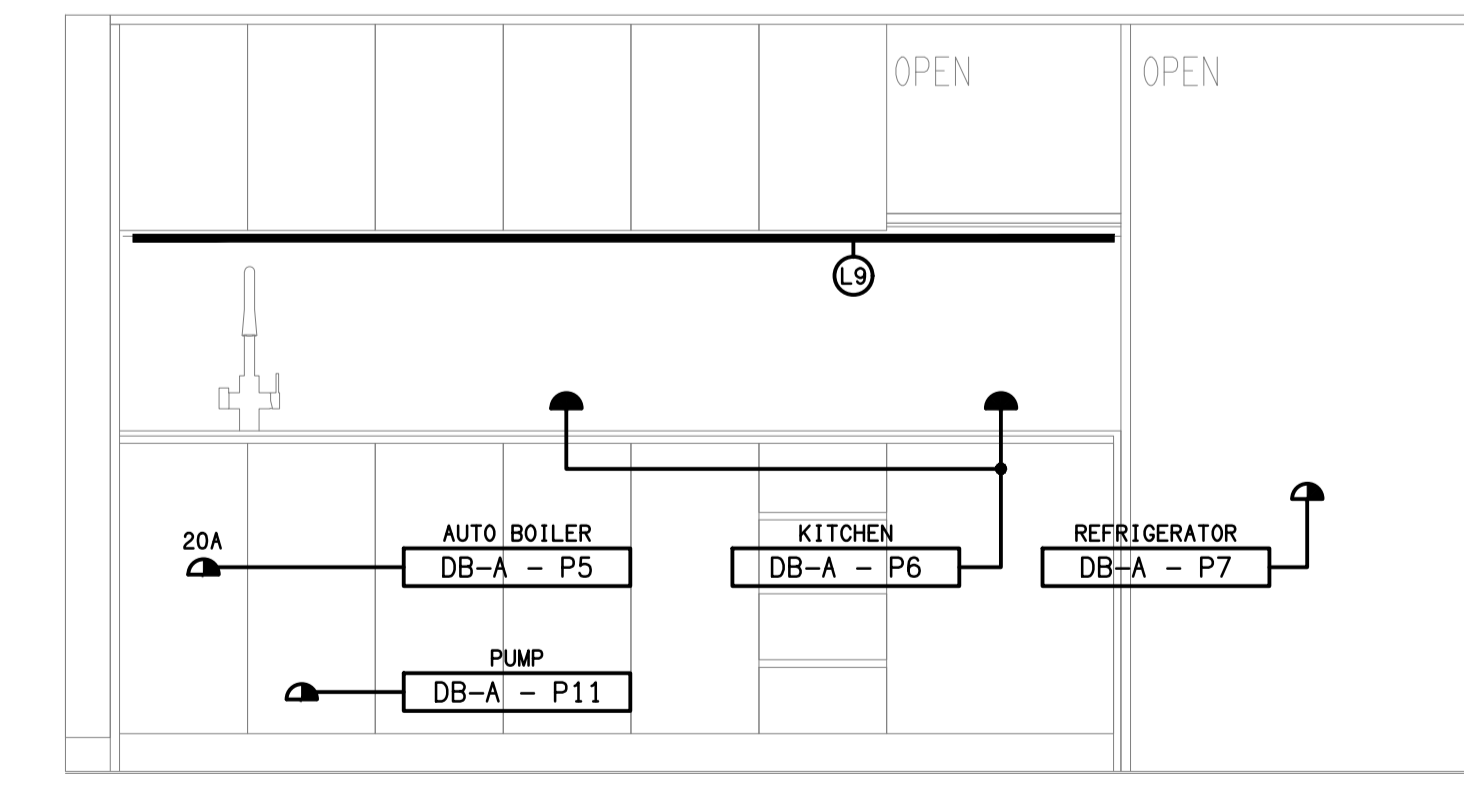

DETAIL A
KITCHENETTE ELEVATION
SCALE 1:20

ELECTRICAL DESIGN GROUP BRISBANE PTY LTD
ACN 092 710 793
TRADING AS:
ELECTRICAL DESIGN GROUP

THE COPYRIGHT OF THIS DRAWING REMAINS THE PROPERTY OF THE ELECTRICAL DESIGN GROUP.
USE FIGURED DIMENSIONS IN PREFERENCE TO SCALE.
ALL DIMENSIONS TO BE VERIFIED ONSITE.

ELECTRICAL DESIGN GROUP
ELECTRICAL BUILDING SERVICES CONSULTANTS
BRISBANE GOLD COAST
P.O. Box 15, Sherwood Q.4075
Phone: (07) 3278 4375
Email: brisbane@edg.net.au
Web: www.edg.net.au

PROJECT:
**ANGLICAN CHURCH GRAMMAR SCHOOL
YEAR 7 BOARDING**
OAKLANDS PARADE, EAST BRISBANE

E	TENDER	16/07/2024
REV.	DESCRIPTION:	DATE:
DRAWING: ELECTRICAL SERVICES GERALD WING GROUND LEVEL PLANS		
SCALE: 1:50 UNO	PROJECT NO: C3247a	DRAWING NO: E06
AT A1	REVISION: E	