



GERALD WING
GROUND LEVEL REFLECTED CEILING PLAN
SCALE 1:50

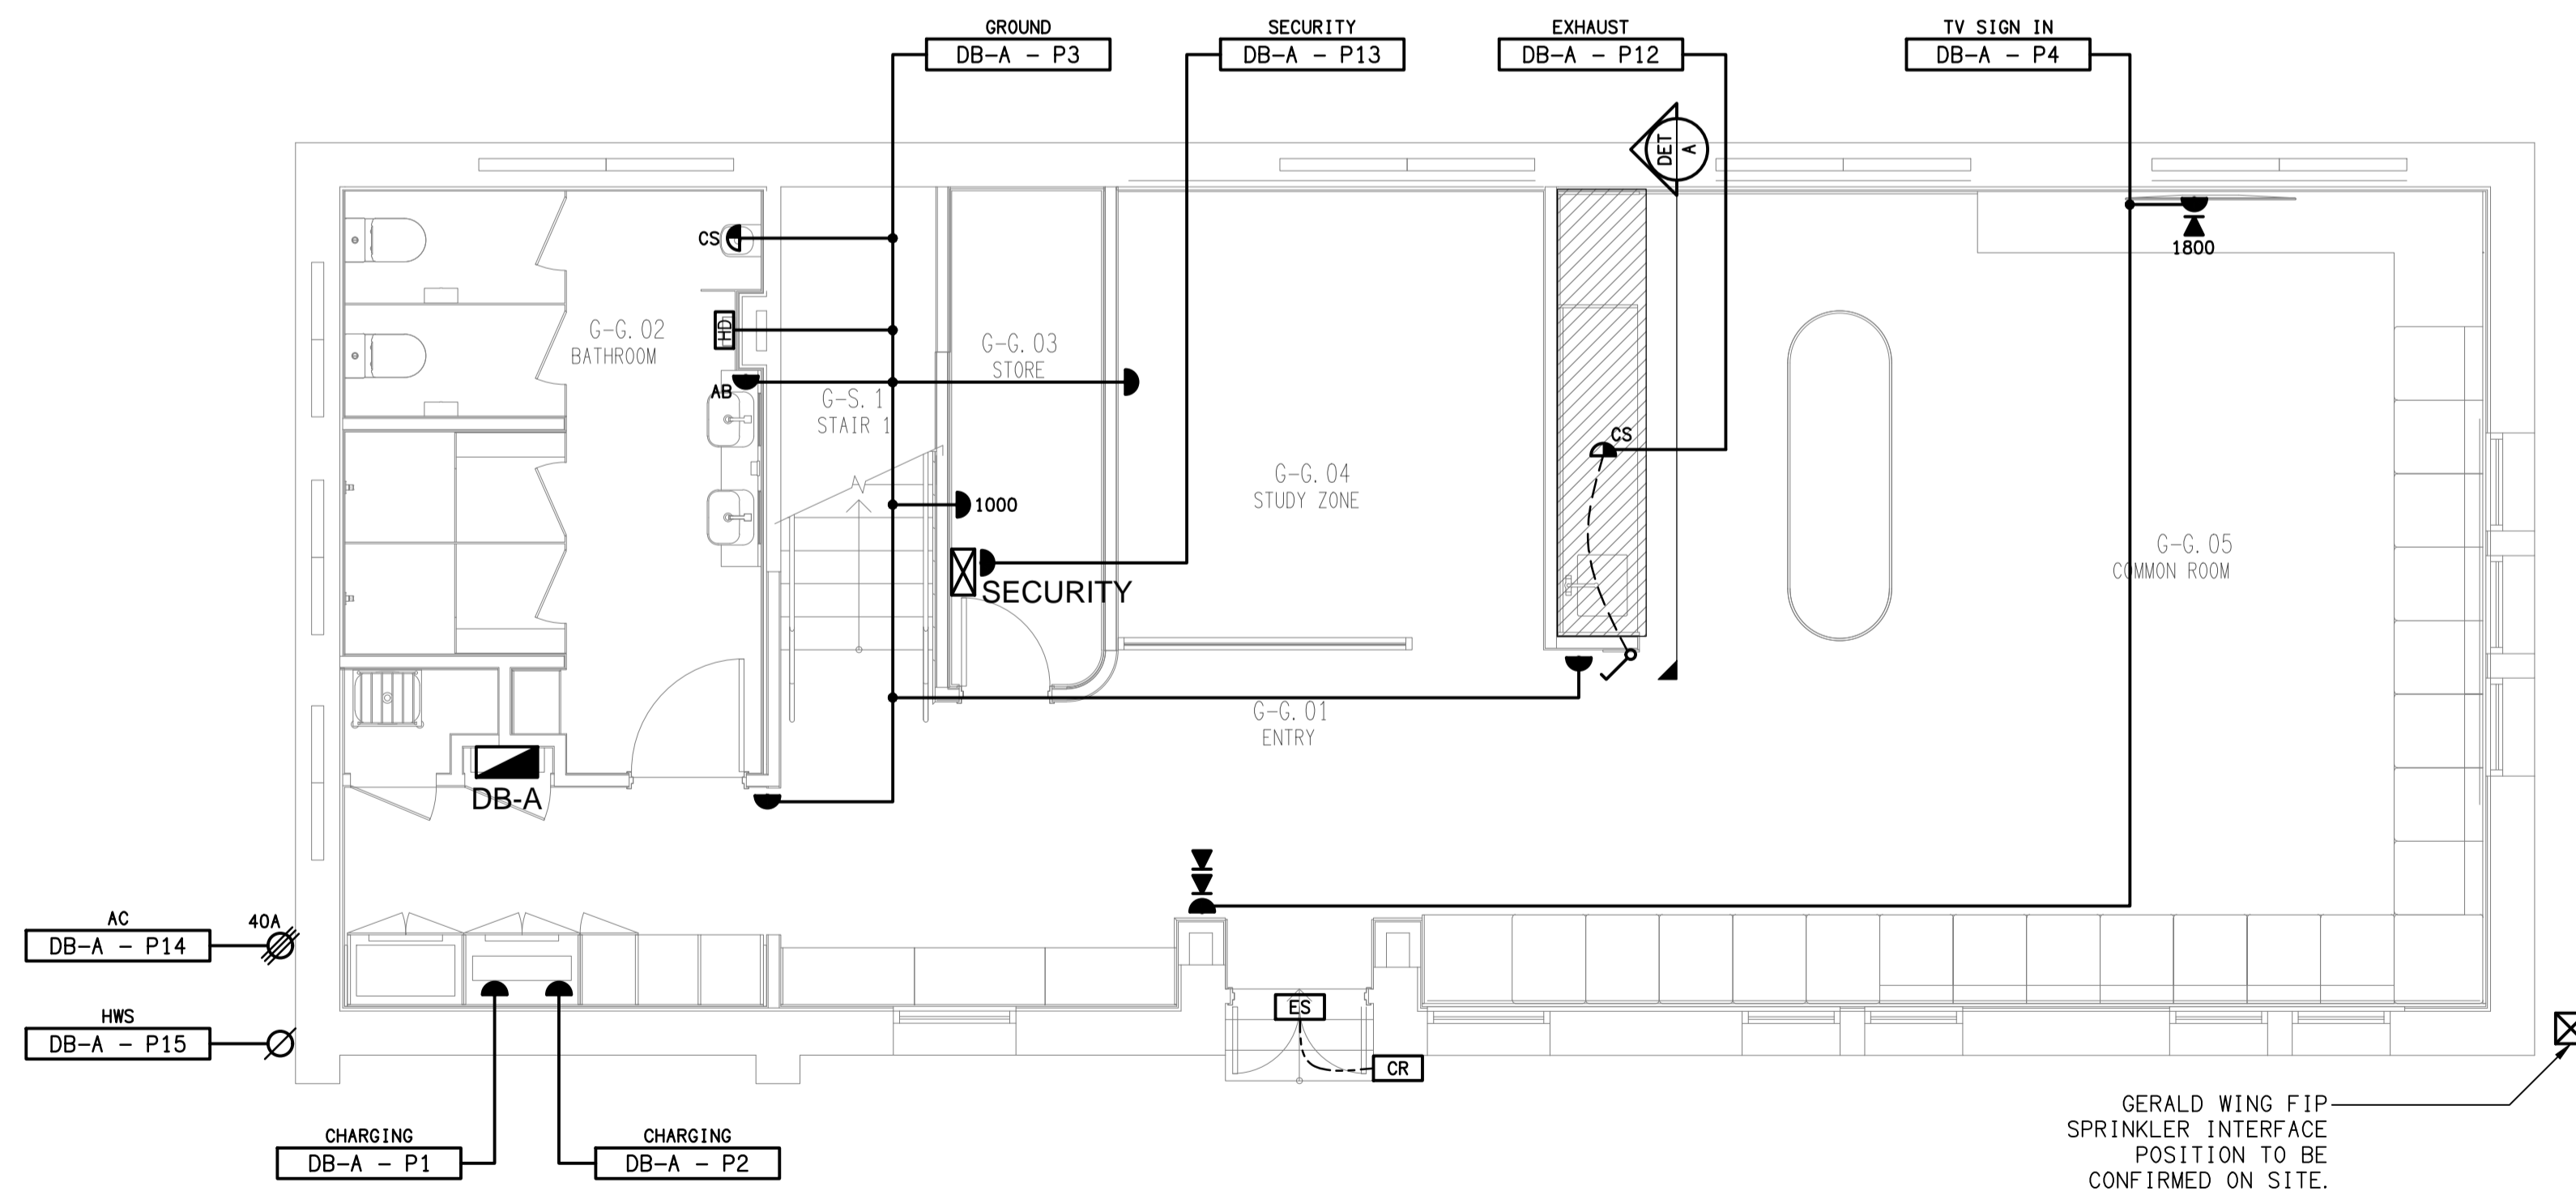

GERALD WING
GROUND LEVEL FLOOR PLAN
SCALE 1:50

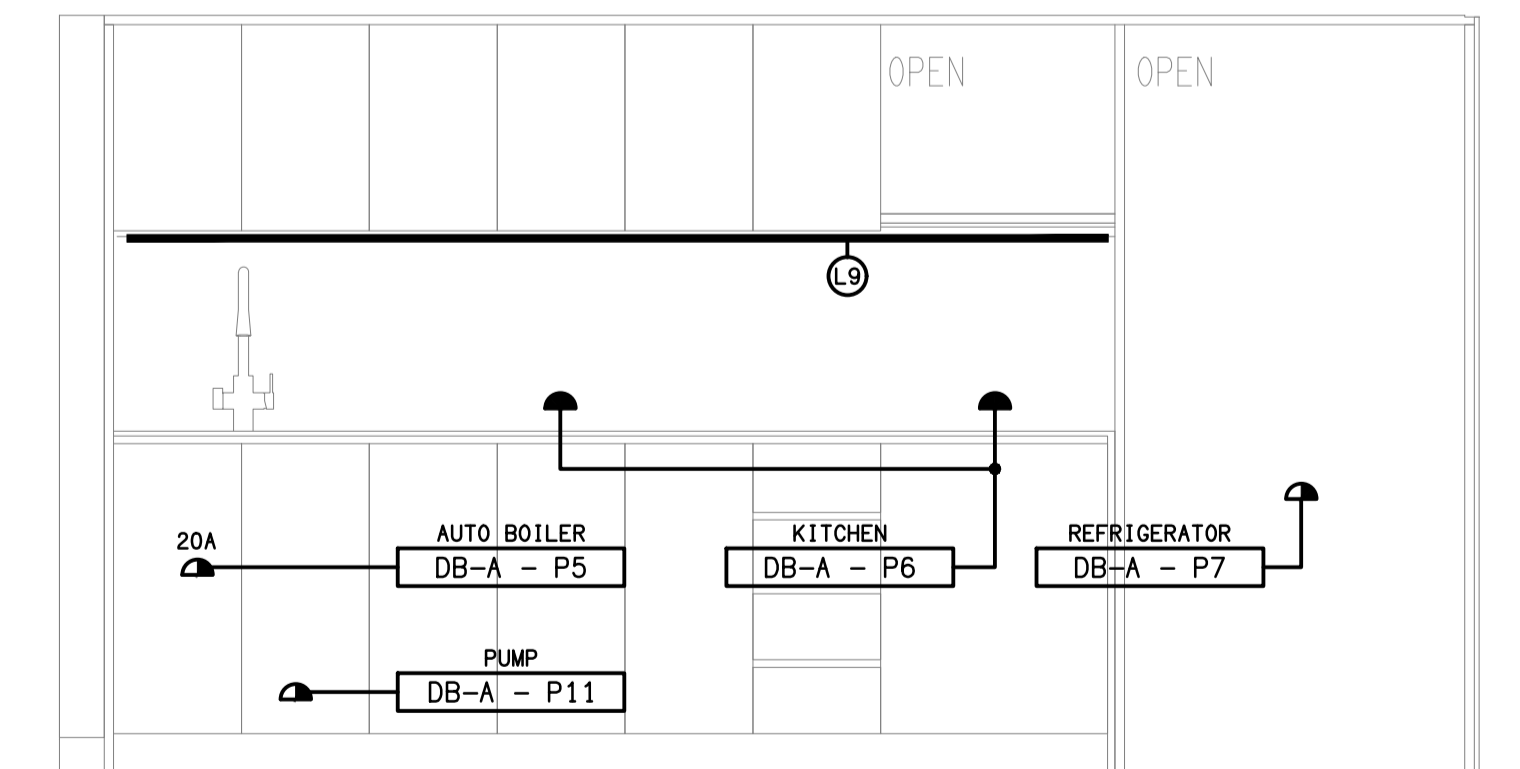

DETAIL A
KITCHENETTE ELEVATION
SCALE 1:20

ELECTRICAL DESIGN GROUP BRISBANE
PTY LTD
ACN 092 710 793
TRADING AS:
ELECTRICAL DESIGN GROUP

THE COPYRIGHT OF THIS DRAWING
REMAINS THE PROPERTY OF THE
ELECTRICAL DESIGN GROUP.

USE FIGURED DIMENSIONS
IN PREFERENCE TO SCALE.

ALL DIMENSIONS TO BE
VERIFIED ONSITE.

ELECTRICAL DESIGN GROUP
ELECTRICAL BUILDING SERVICES CONSULTANTS
BRISBANE GOLD COAST

P.O. Box 15, Sherwood Q.4075
Phone: (07) 3278 4375
Email: brisbane@edg.net.au
Web: www.edg.net.au

PROJECT:
ANGLICAN CHURCH GRAMMAR SCHOOL
YEAR 7 BOARDING

OAKLANDS PARADE, EAST BRISBANE

J	CONSTRUCTION	30/09/2024
REV.	DESCRIPTION:	DATE:

DRAWING:
ELECTRICAL SERVICES
GERALD WING GROUND LEVEL PLANS

SCALE:
1:50 UNO

AT A1

PROJECT NO:
C3247a

DRAWING NO:
E06

REVISION:
J