



GERALD WING
UPPER LEVEL REFLECTED CEILING PLAN
SCALE 1:50

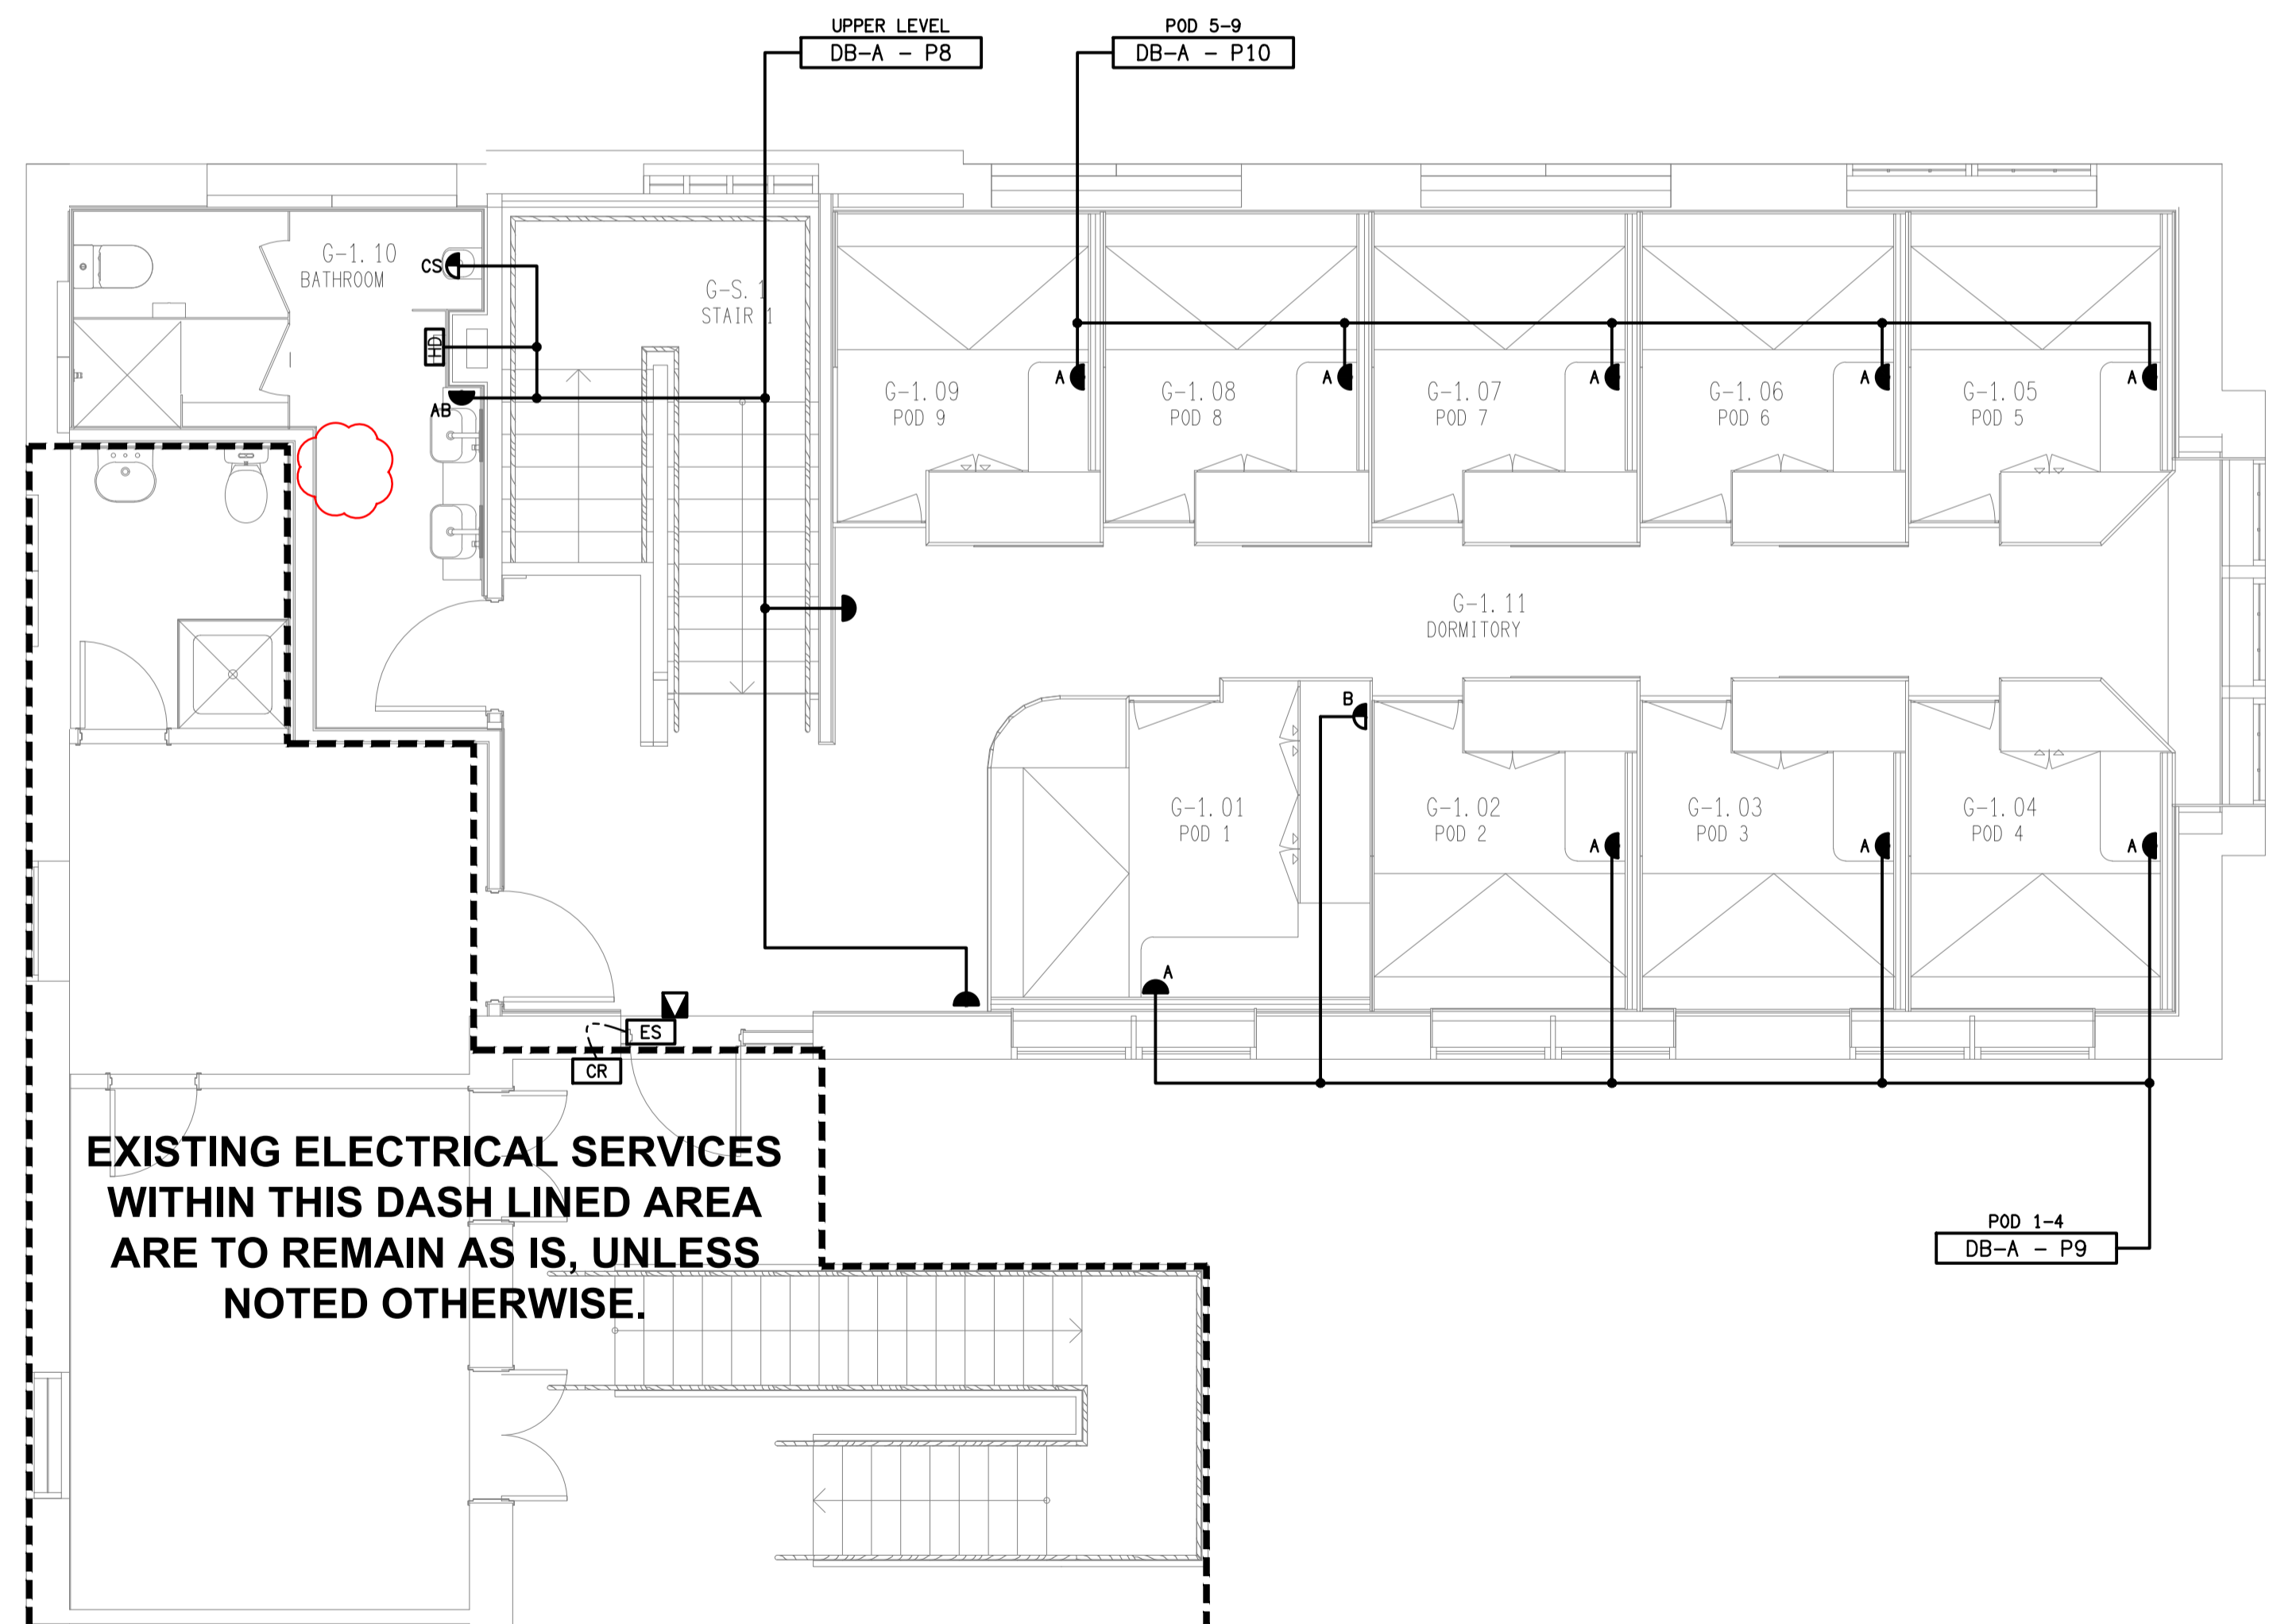

GERALD WING
UPPER LEVEL FLOOR PLAN
SCALE 1:50

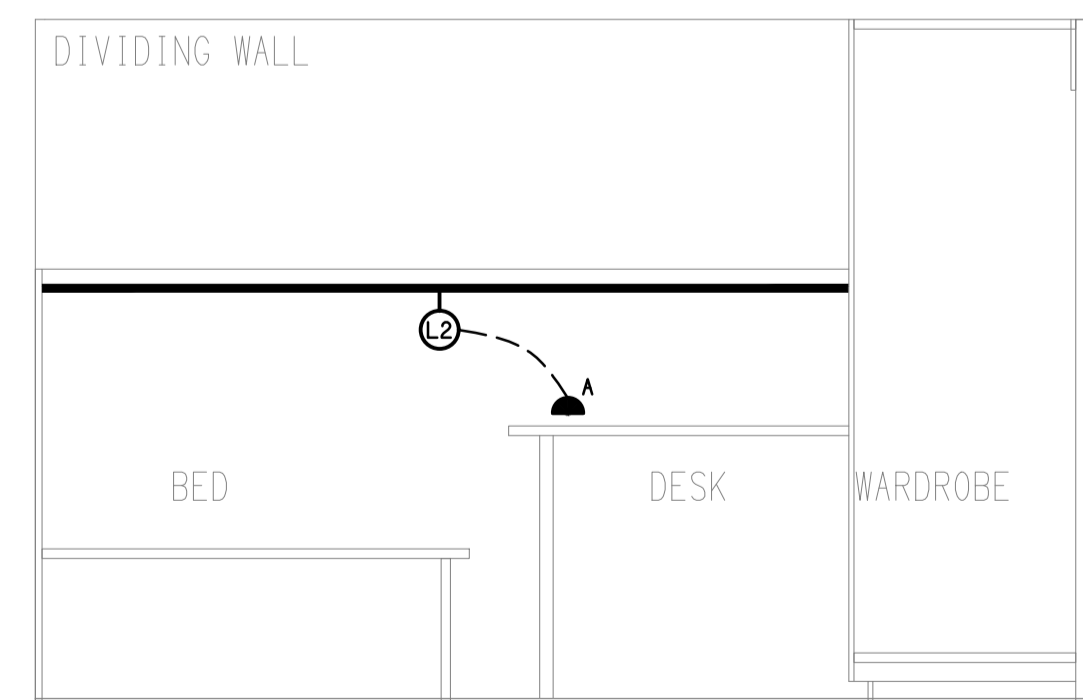

DETAIL A
TYPICAL BEDROOM POD 1 ELEVATION
SCALE 1:20

D	TENDER	16/07/2024
REV.	DESCRIPTION:	DATE:

DRAWING: **ELECTRICAL SERVICES**
GERALD WING UPPER LEVEL PLANS

SCALE: 1:50 UNO	AT A1	PROJECT NO: C3247a	DRAWING NO: E07	REVISION: D
--------------------	-------	------------------------------	---------------------------	-----------------------

ELECTRICAL DESIGN GROUP BRISBANE
PTY LTD
ACN 092 710 793
TRADING AS:
ELECTRICAL DESIGN GROUP

THE COPYRIGHT OF THIS DRAWING
REMAINS THE PROPERTY OF THE
ELECTRICAL DESIGN GROUP.
USE FIGURED DIMENSIONS
IN PREFERENCE TO SCALE.
ALL DIMENSIONS TO BE
VERIFIED ONSITE.

ELECTRICAL DESIGN GROUP
ELECTRICAL BUILDING SERVICES CONSULTANTS
BRISBANE GOLD COAST

P.O. Box 15, Sherwood Q.4075
Phone: (07) 3278 4375
Email: brisbane@edg.net.au
Web: www.edg.net.au

PROJECT:
ANGLICAN CHURCH GRAMMAR SCHOOL
YEAR 7 BOARDING

OAKLANDS PARADE, EAST BRISBANE