



EXISTING ELECTRICAL SERVICES WITHIN THIS DASH LINED AREA ARE TO REMAIN AS IS, UNLESS NOTED OTHERWISE.

GERALD WING
UPPER LEVEL REFLECTED CEILING PLAN
SCALE 1:50

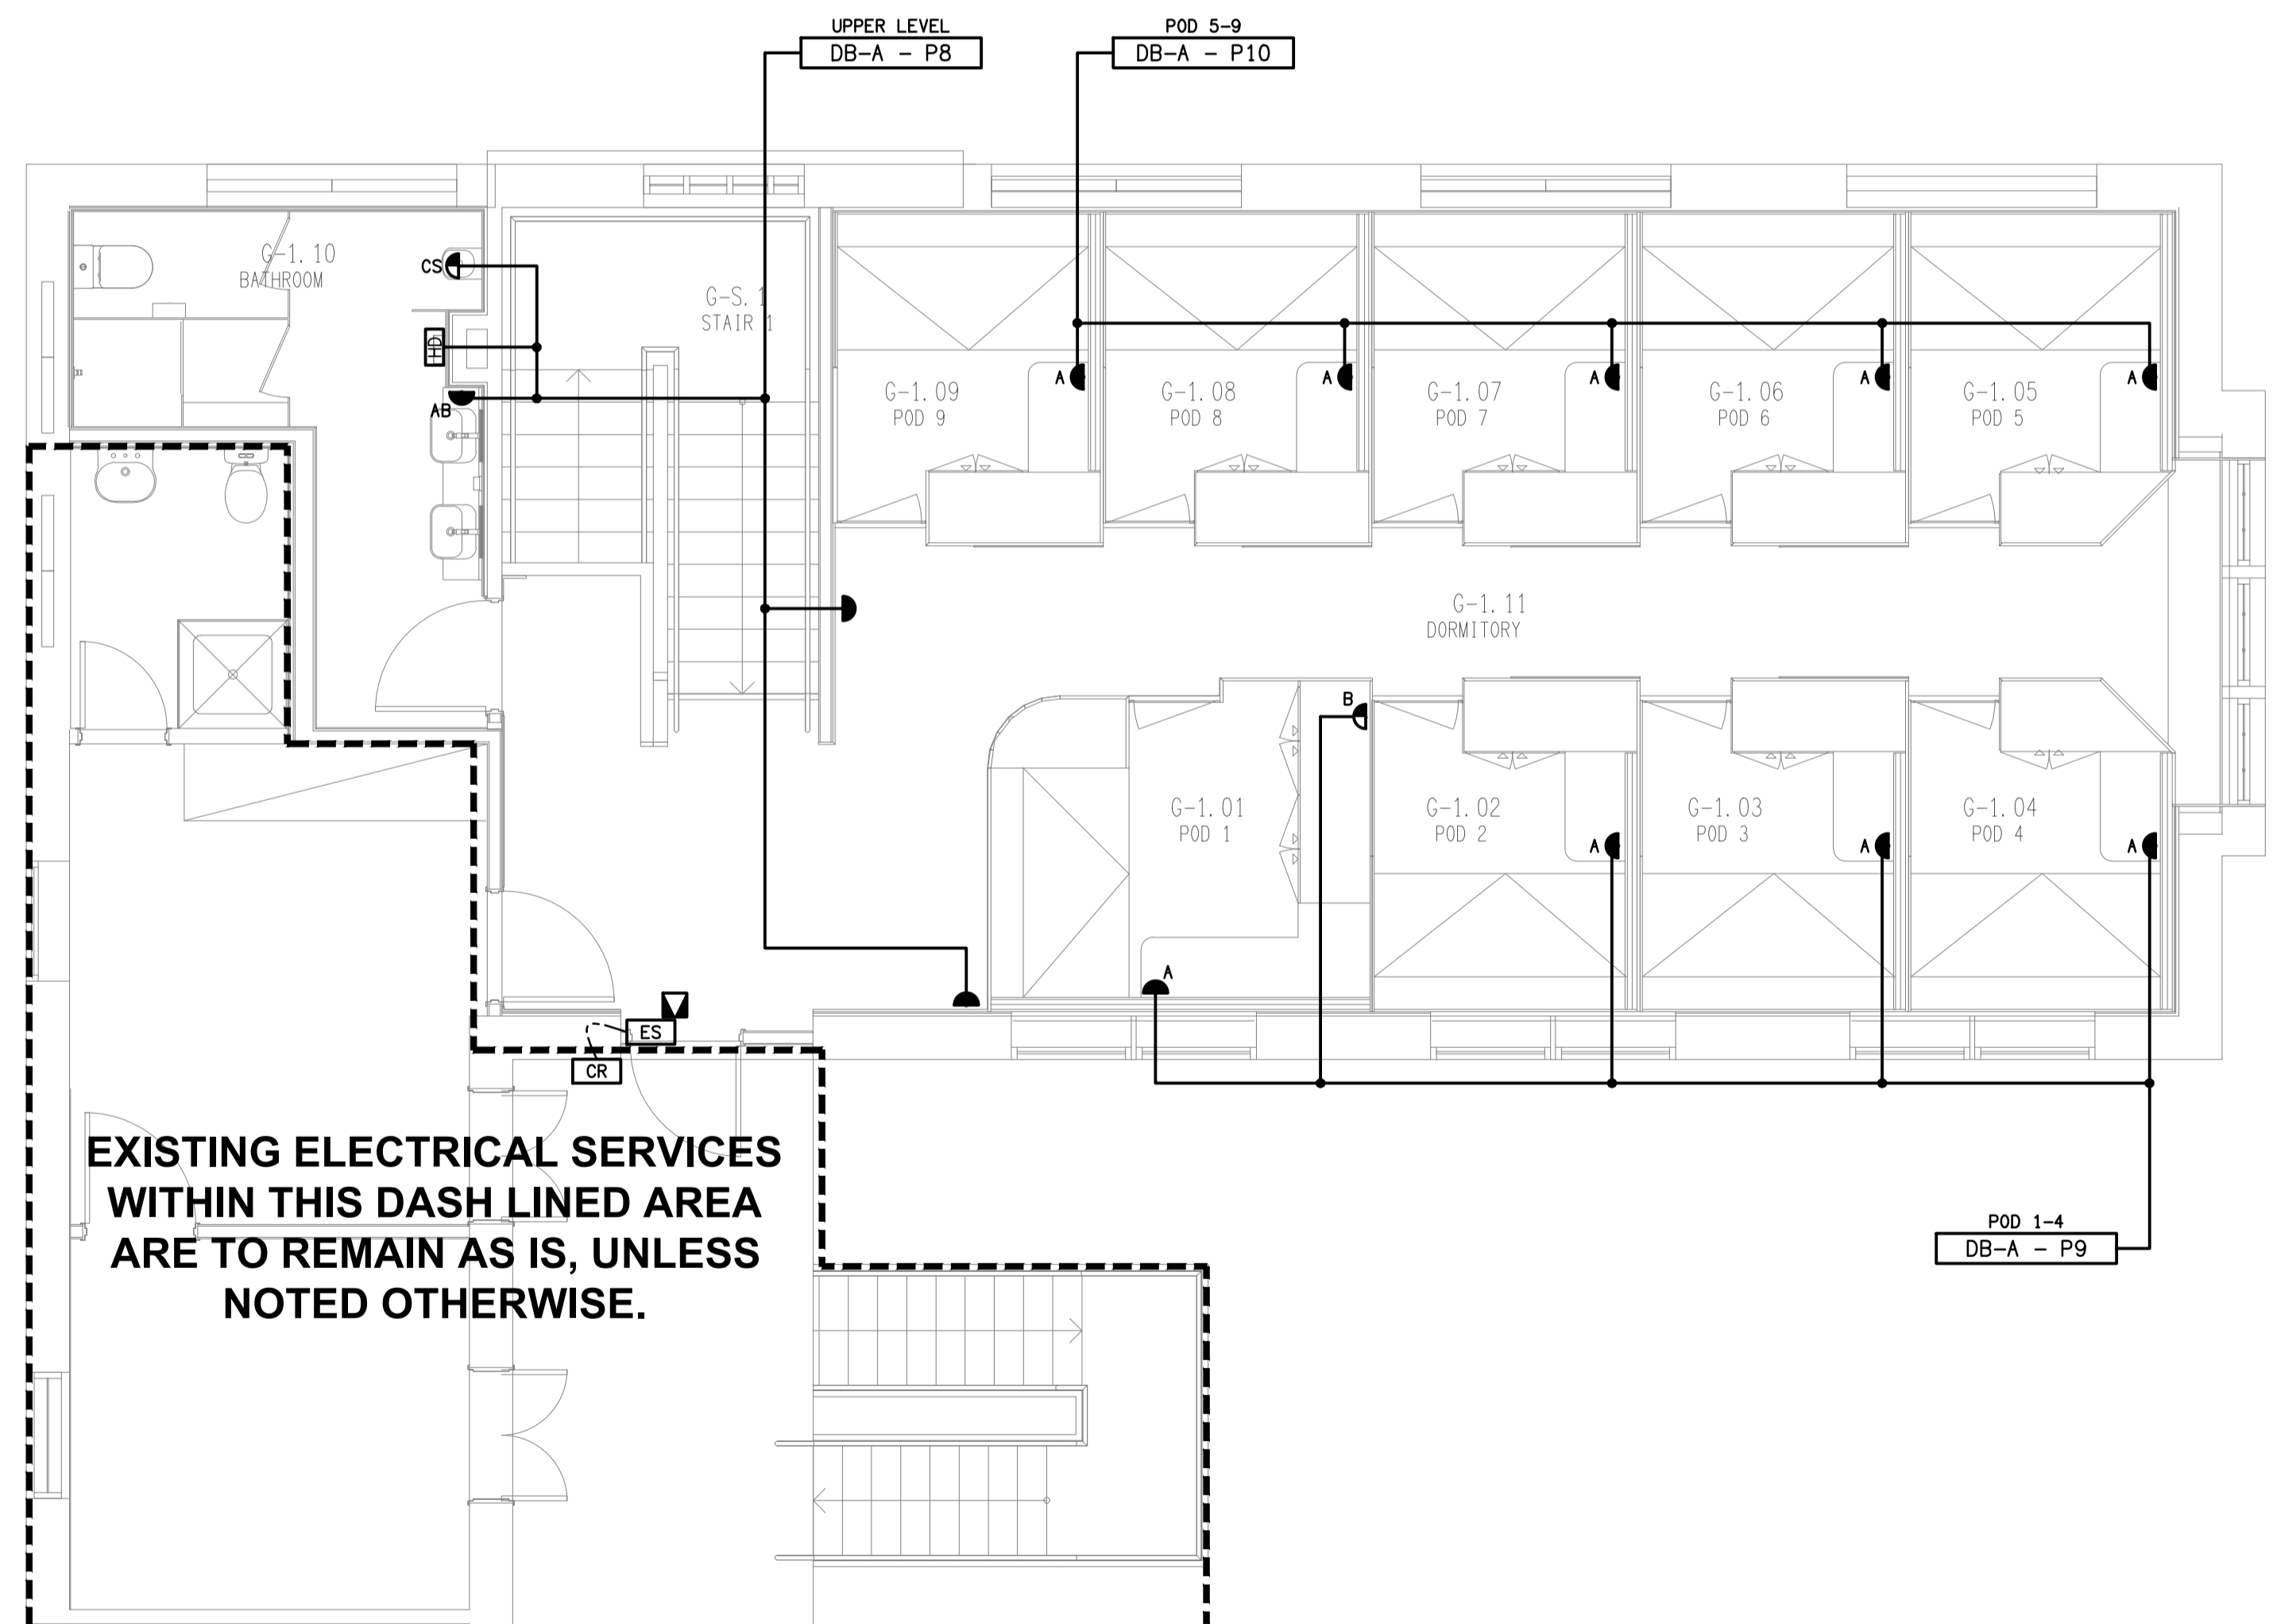

EXISTING ELECTRICAL SERVICES WITHIN THIS DASH LINED AREA ARE TO REMAIN AS IS, UNLESS NOTED OTHERWISE.

GERALD WING
UPPER LEVEL FLOOR PLAN
SCALE 1:50

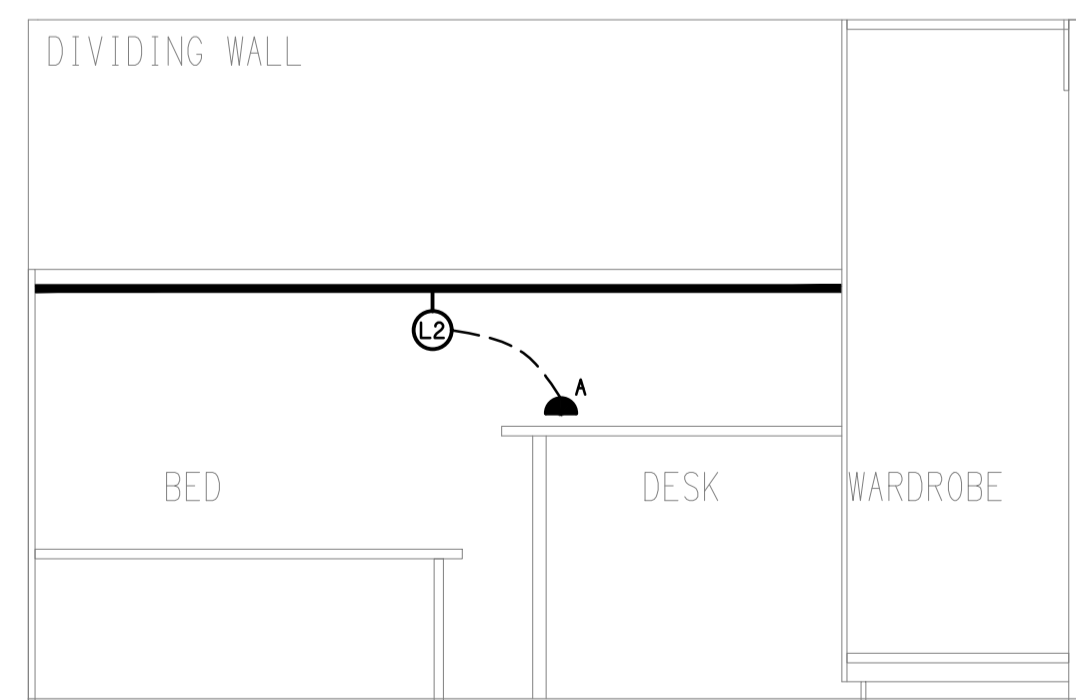

DETAIL A
TYPICAL BEDROOM POD 1 ELEVATION
SCALE 1:20

| | | |
|------|--------------|------------|
| G | CONSTRUCTION | 30/09/2024 |
| REV. | DESCRIPTION: | DATE: |

| | | | |
|-------------------------------------|---------------------------|------------------------|--------------------|
| DRAWING: ELECTRICAL SERVICES | | | |
| GERALD WING UPPER LEVEL PLANS | | | |
| SCALE: 1:50 UNO | PROJECT NO: C3247a | DRAWING NO: E07 | REVISION: G |
| | AT A1 | | |

ELECTRICAL DESIGN GROUP BRISBANE PTY LTD
ACN 092 710 793
TRADING AS:
ELECTRICAL DESIGN GROUP

THE COPYRIGHT OF THIS DRAWING REMAINS THE PROPERTY OF THE ELECTRICAL DESIGN GROUP.
USE FIGURED DIMENSIONS IN PREFERENCE TO SCALE.
ALL DIMENSIONS TO BE VERIFIED ONSITE.

ELECTRICAL DESIGN GROUP
ELECTRICAL BUILDING SERVICES CONSULTANTS
BRISBANE GOLD COAST

P.O. Box 15, Sherwood Q.4075
Phone: (07) 3278 4375
Email: brisbane@edg.net.au
Web: www.edg.net.au

PROJECT:
ANGLICAN CHURCH GRAMMAR SCHOOL
YEAR 7 BOARDING

OAKLANDS PARADE, EAST BRISBANE