


LINETYPES:
 - - - - - CABLE ACCESS THROUGH THE JOINERY SKIRTING KICK.
 - - - - - CABLE ACCESS THROUGH THE JOINERY FALSE WALL.

DONALDSON
 UPPER LEVEL FLOOR PLAN
 SCALE 1:50

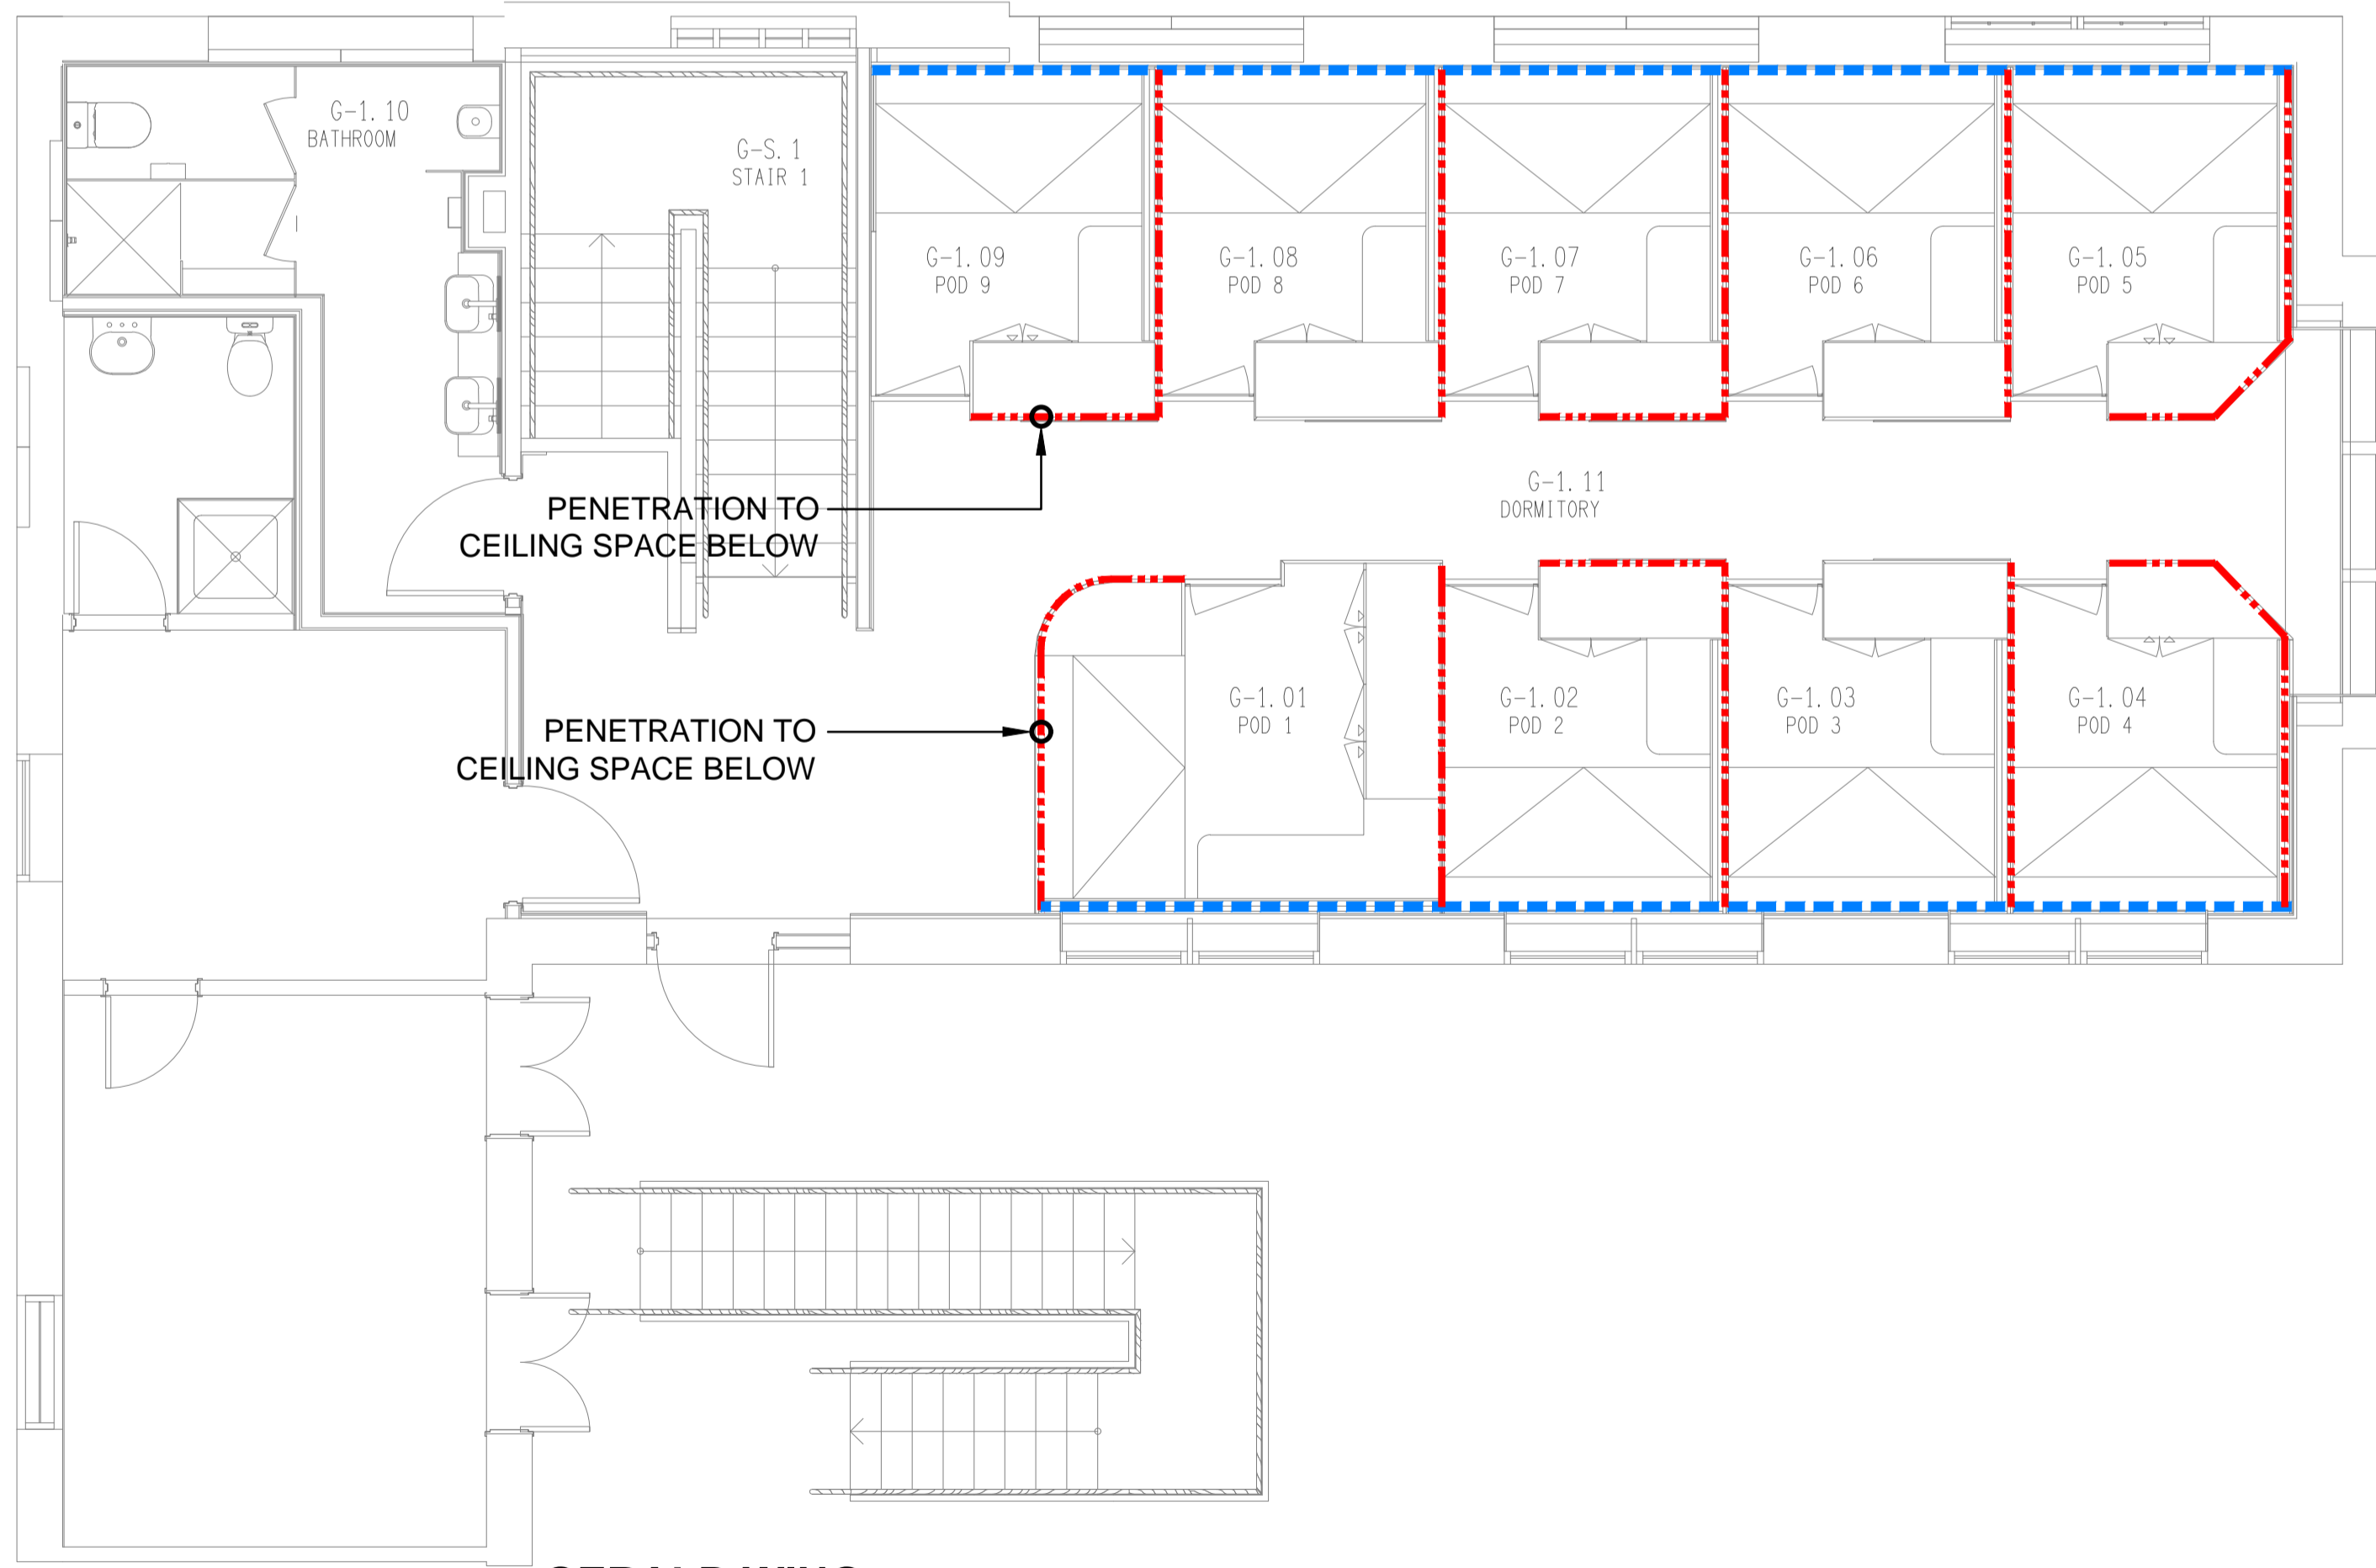

GERALD WING
 UPPER LEVEL FLOOR PLAN
 SCALE 1:50

ELECTRICAL DESIGN GROUP BRISBANE
 PTY LTD
 ACN 092 710 793
 TRADING AS:
 ELECTRICAL DESIGN GROUP

THE COPYRIGHT OF THIS DRAWING
 REMAINS THE PROPERTY OF THE
 ELECTRICAL DESIGN GROUP.
 USE FIGURED DIMENSIONS
 IN PREFERENCE TO SCALE.
 ALL DIMENSIONS TO BE
 VERIFIED ONSITE.

ELECTRICAL DESIGN GROUP
 ELECTRICAL BUILDING SERVICES CONSULTANTS
 BRISBANE GOLD COAST
 P.O.Box 15, Sherwood Q.4075
 Phone: (07) 3278 4375
 Email: brisbane@edg.net.au
 Web: www.edg.net.au

PROJECT:
**ANGLICAN CHURCH GRAMMAR SCHOOL
 YEAR 7 BOARDING**
 OAKLANDS PARADE, EAST BRISBANE

D	CONSTRUCTION	24/07/2024
REV:	DESCRIPTION:	DATE:
DRAWING: ELECTRICAL SERVICES CABLE ACCESS PLANS		
SCALE: 1:50	AT A1	PROJECT NO: C3247a
		DRAWING NO: E08
		REVISION: D