




**DETAIL A1**  
ENTRY S35 ELEVATION  
SCALE 1:50

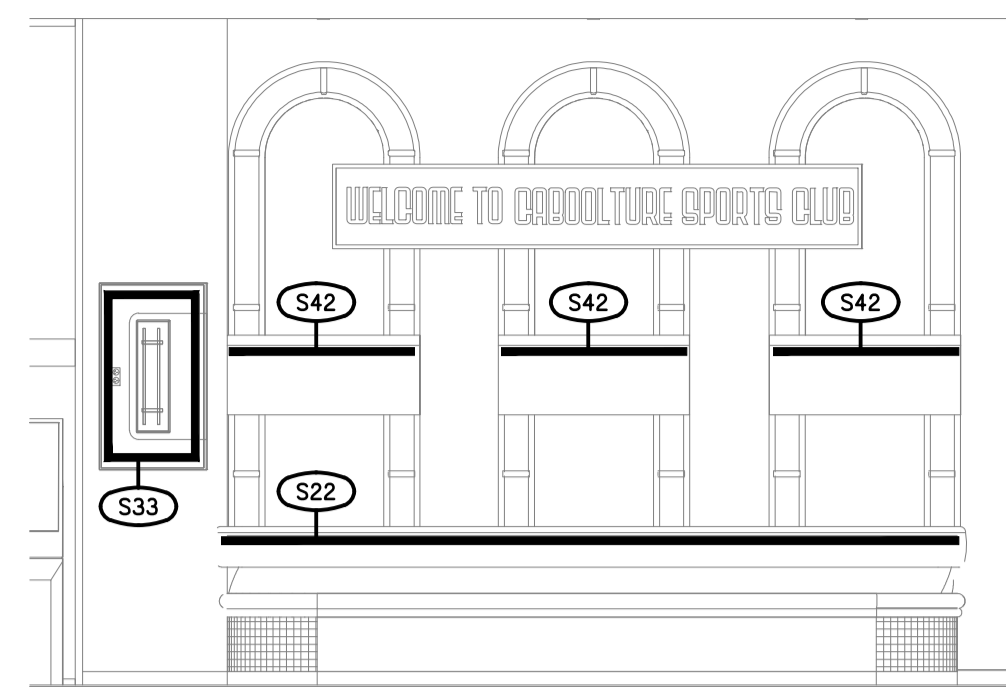

**DETAIL A2**  
ENTRY S22 & S40 ELEVATION  
SCALE 1:50

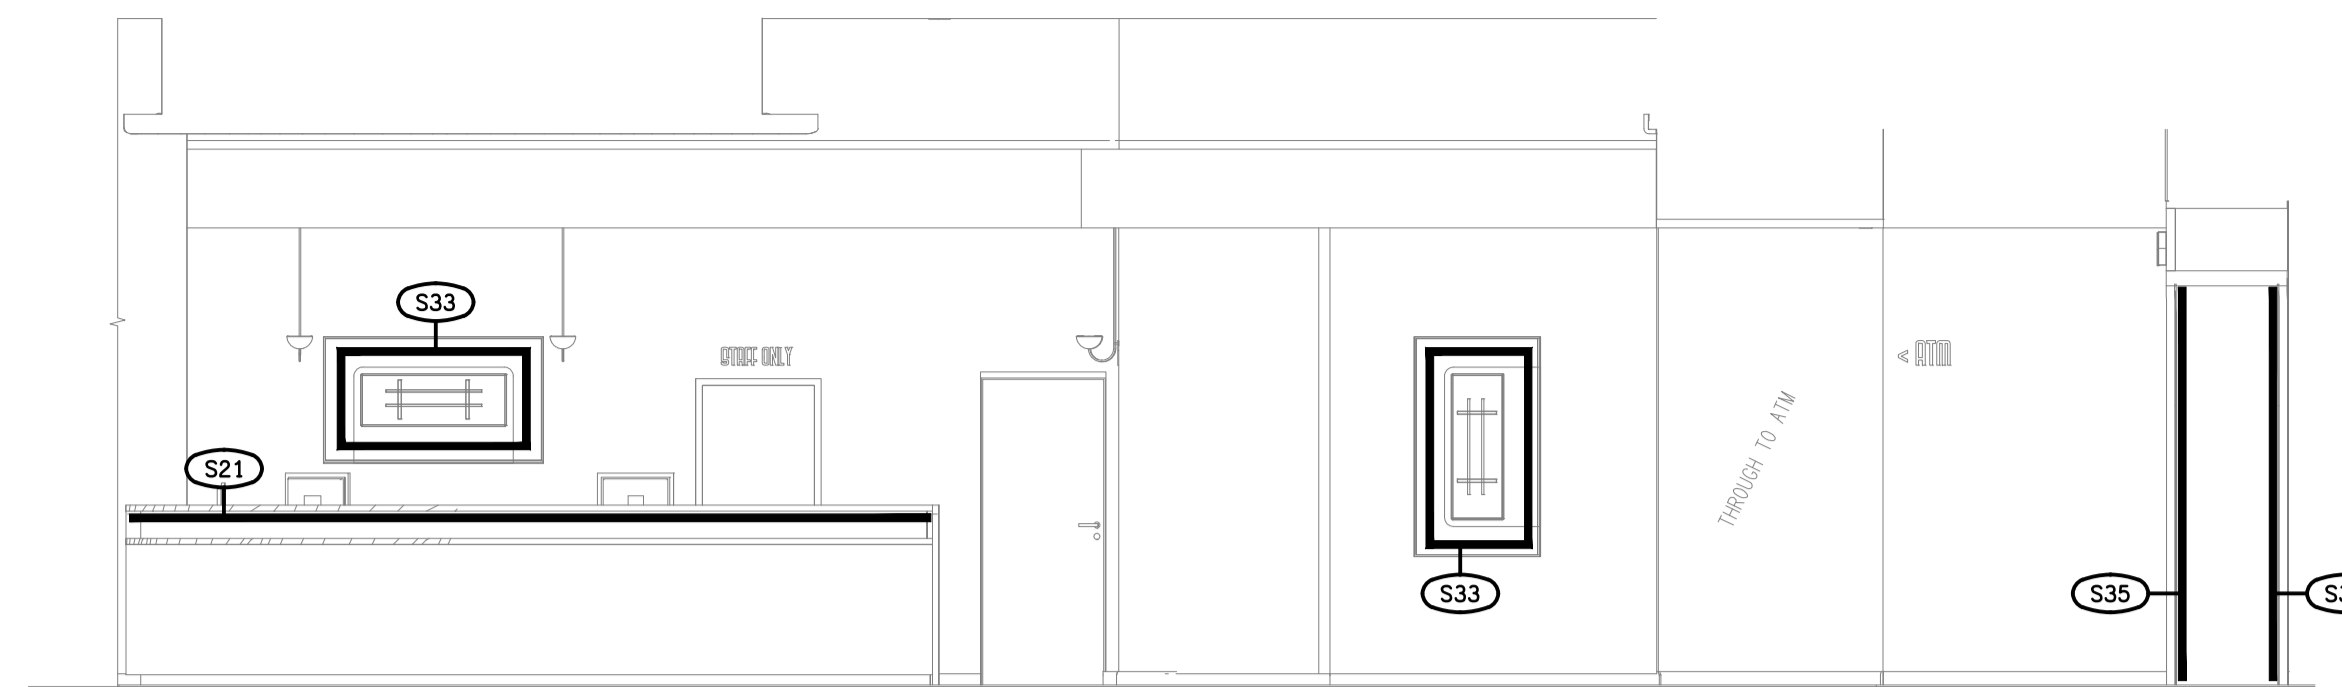

**DETAIL A3**  
RECEPTION S21 & S35 ELEVATION  
SCALE 1:50

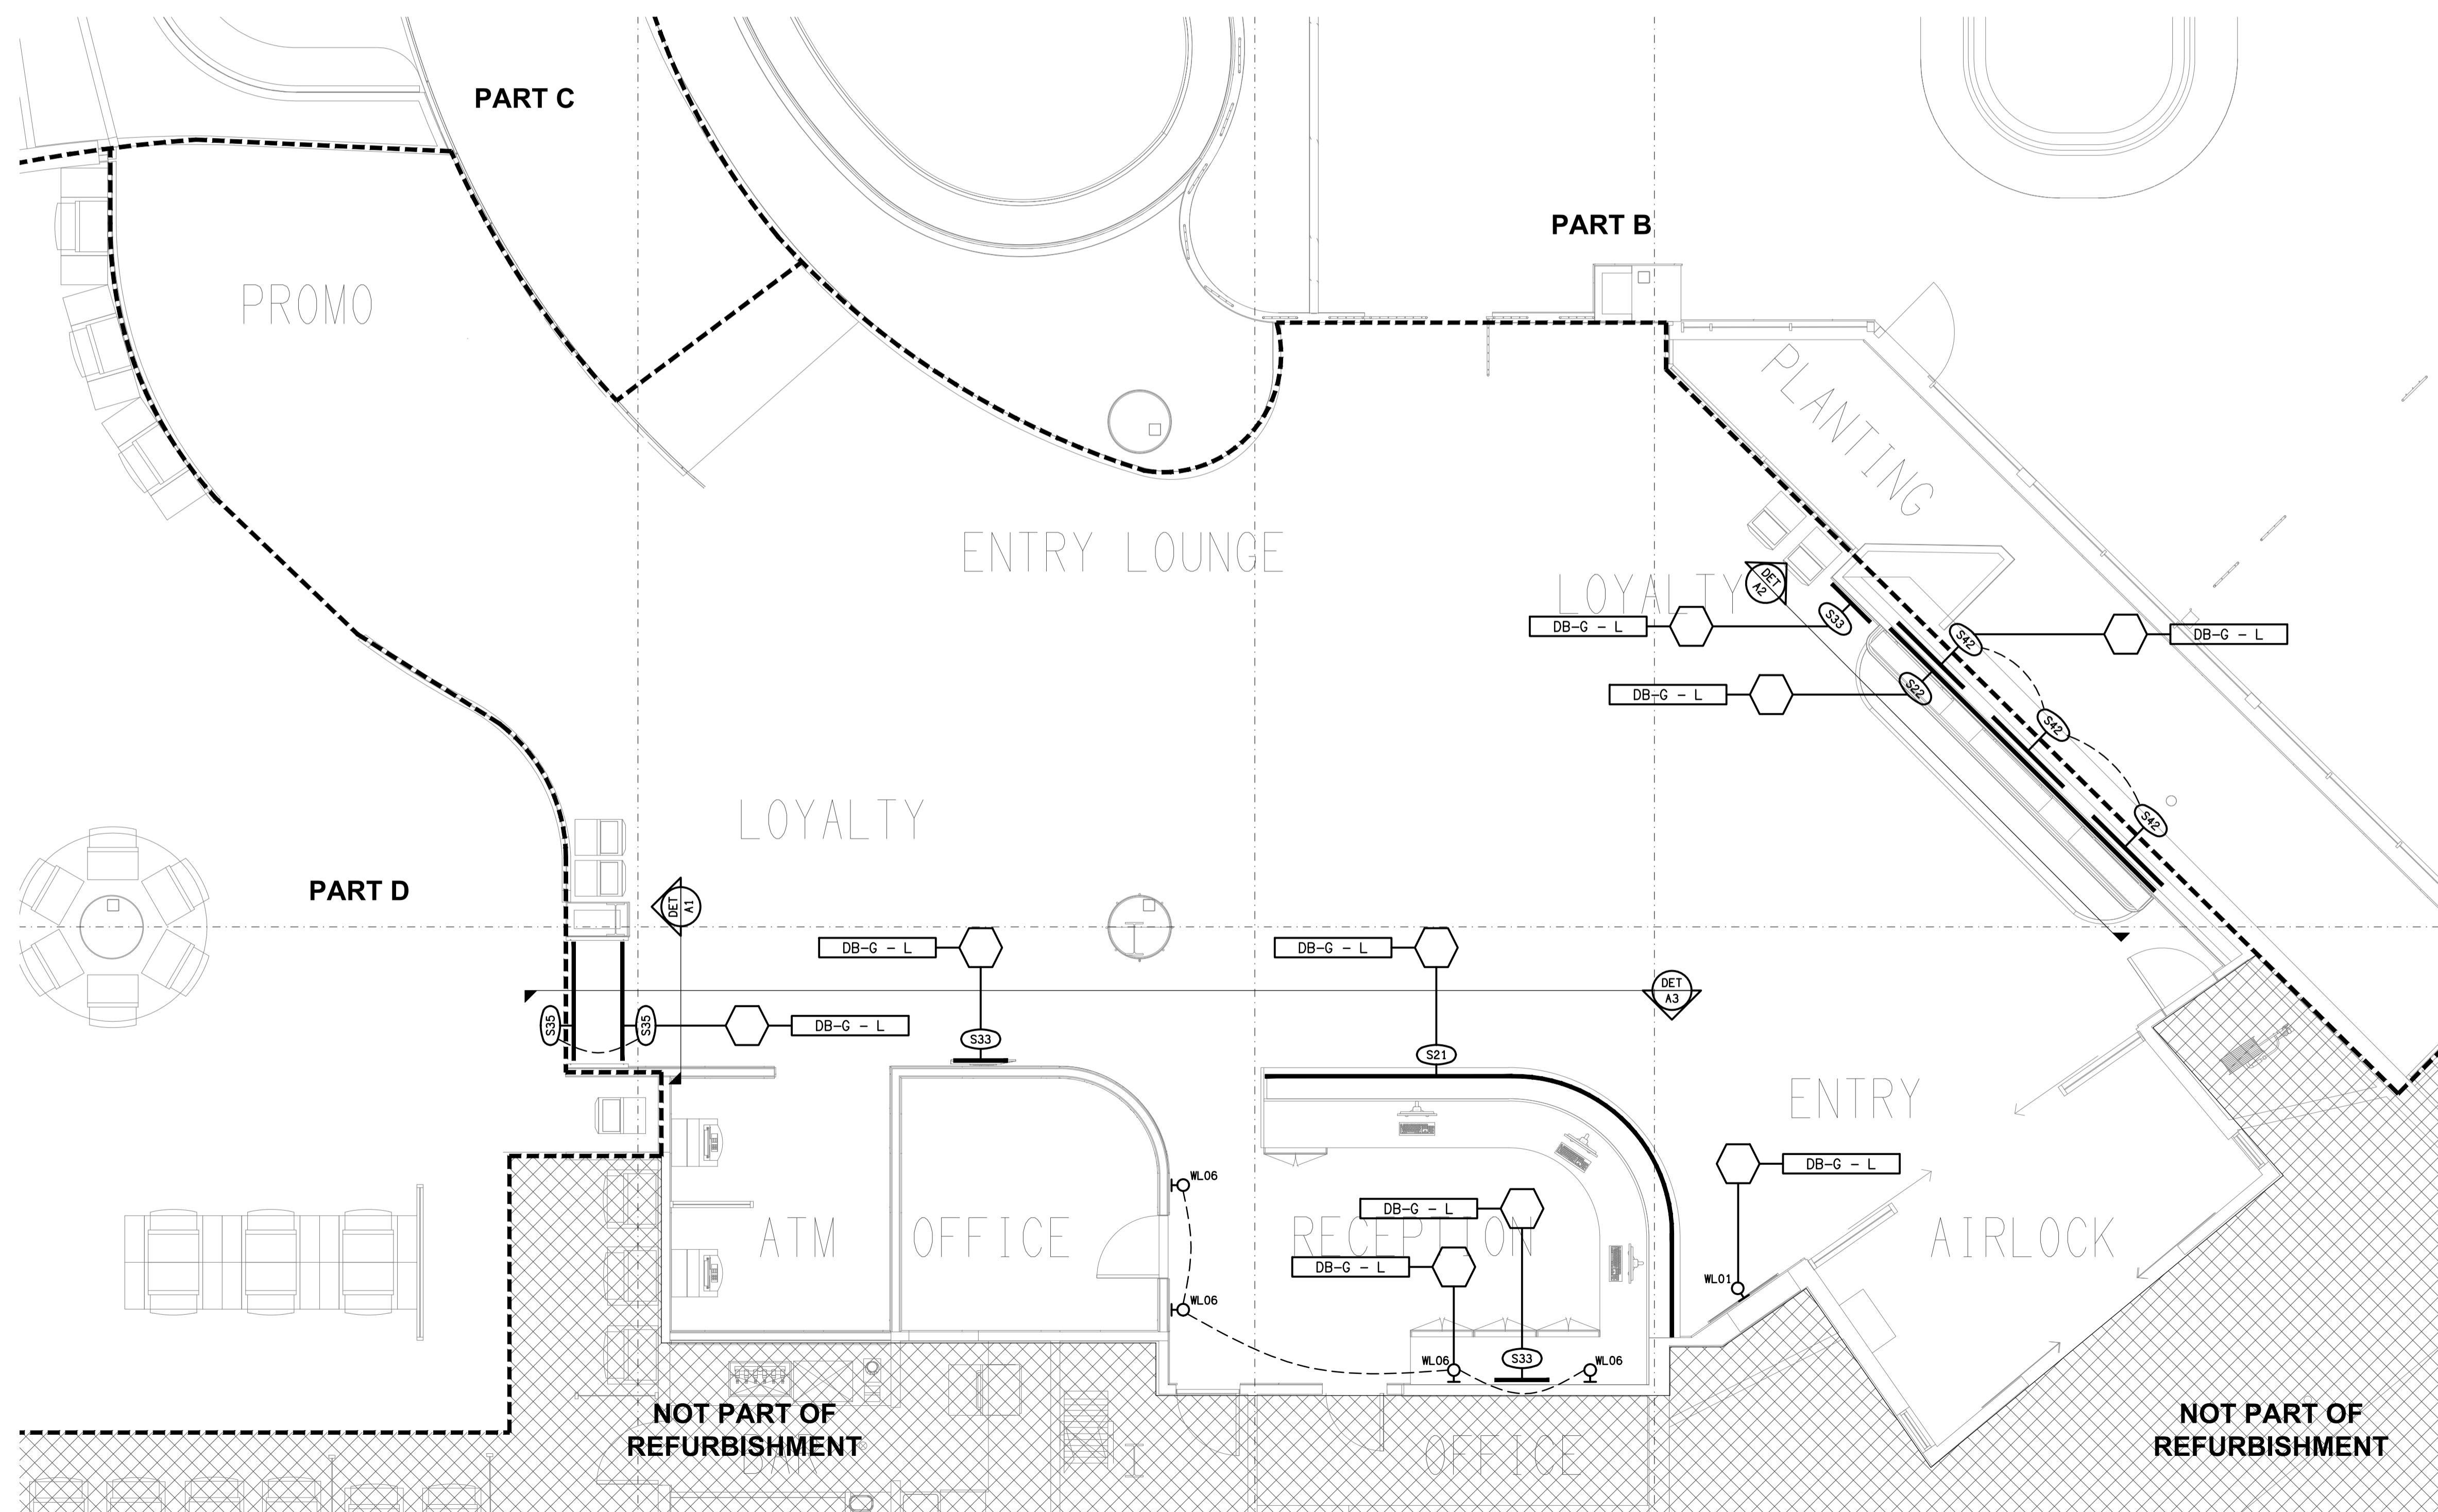

B	75% DEVELOPMENT	02/10/2024
REV:	DESCRIPTION:	DATE:

**ELECTRICAL DESIGN GROUP**  
ELECTRICAL BUILDING SERVICES CONSULTANTS

BRISBANE: P.O. Box 15, Sherwood Qld 4075  
Phone: (07) 3278 4375  
Email: brisbane@edg.net.au  
Web: www.edg.net.au

ELECTRICAL DESIGN GROUP BRISBANE / TRADING AS: ELECTRICAL DESIGN GROUP  
PTY LTD / ACN 092 710 793

PROJECT: CABOOLTURE SPORTS CLUB REFURBISHMENT

SITE ADDRESS: 19-27 STATION ROAD, MORAYFIELD

SCALE: 1:50 SHEET SIZE: AT A1

DRAWING TITLE: ELECTRICAL SERVICES GROUND LEVEL PART A JOINERY & WALL LIGHTING PLAN

PROJECT NO. DRAWING NO. REVISION:

**C3264a E10 B**