


DETAIL C14
BISTRO GREENWALL
SCALE 1:50

THE COPYRIGHT OF THIS DRAWING REMAINS THE PROPERTY OF THE ELECTRICAL DESIGN GROUP.

USE FIGURED DIMENSIONS IN PREFERENCE TO SCALE.

ALL DIMENSIONS TO BE VERIFIED ONSITE.

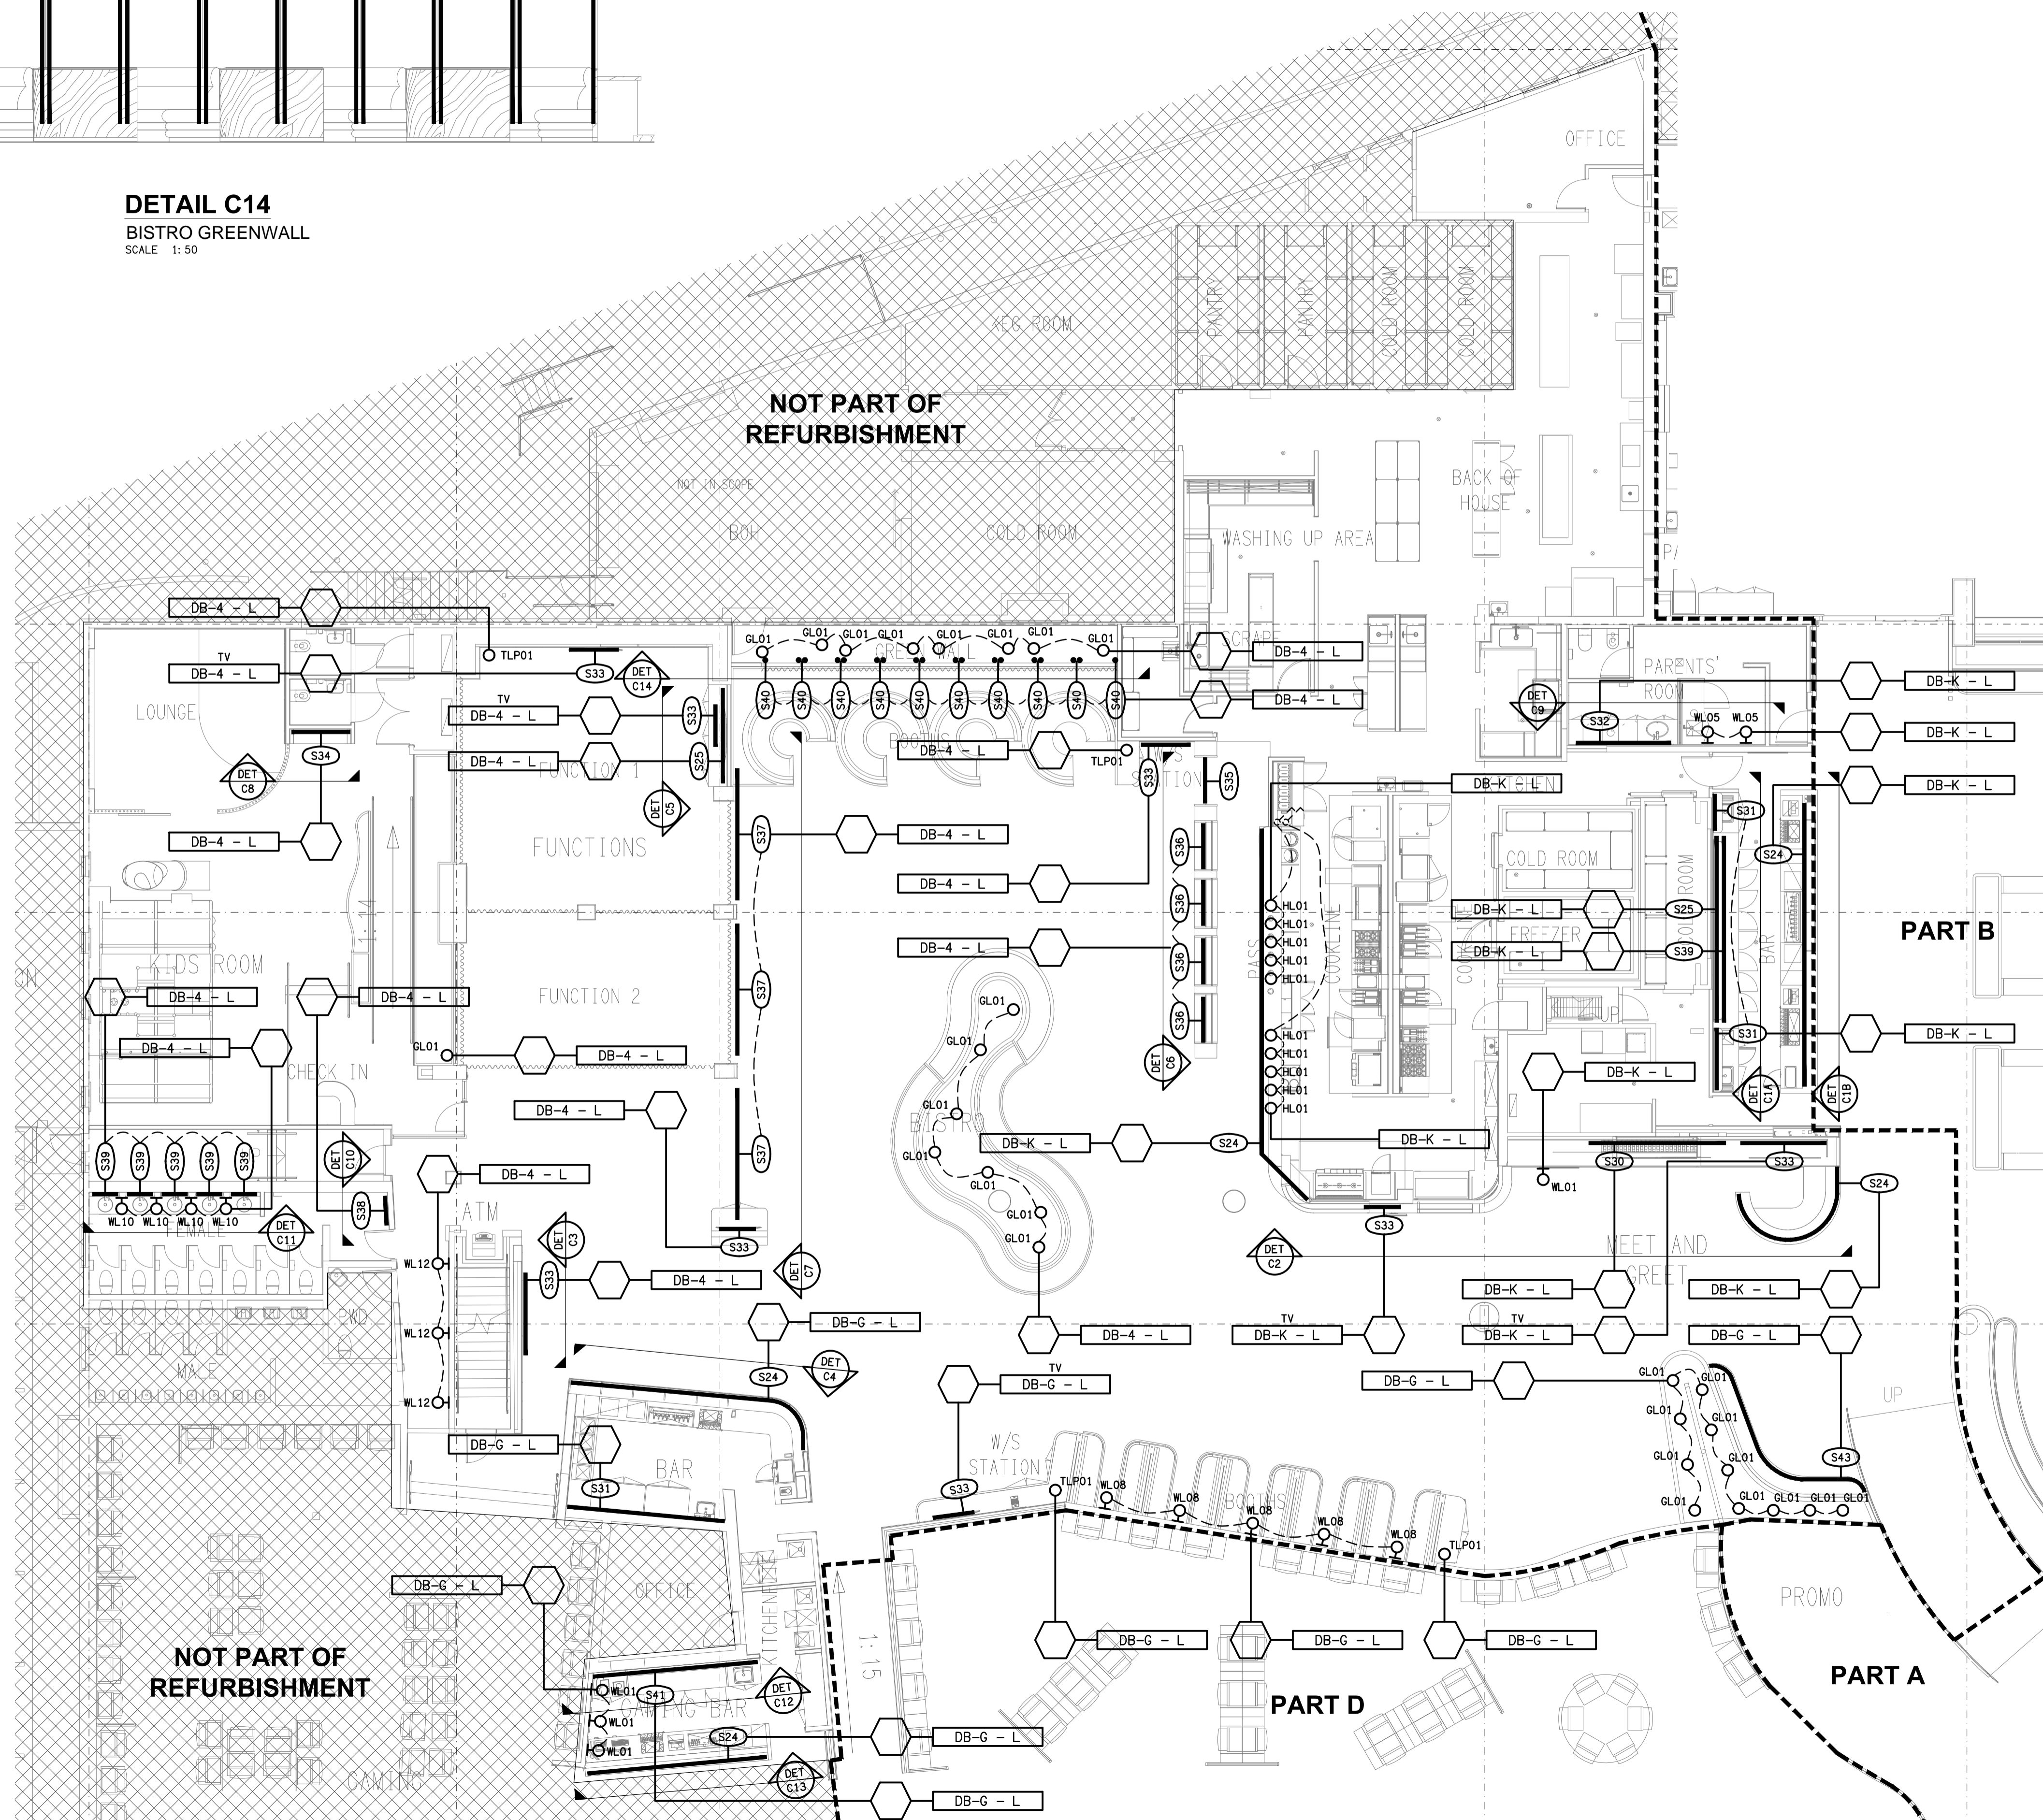

B	75% DEVELOPMENT	02/10/2024
REV:	DESCRIPTION:	DATE:

ELECTRICAL DESIGN GROUP
ELECTRICAL BUILDING SERVICES CONSULTANTS

BRISBANE: P.O. Box 15 Sherwood Qld 4075
Phone: (07) 3278 4375
Email: brisbane@edg.net.au
Web: www.edg.net.au

ELECTRICAL DESIGN GROUP BRISBANE / TRADING AS:
PTY LTD ACN 092 710 793 / ELECTRICAL DESIGN GROUP

PROJECT:
CABOOLTURE SPORTS CLUB REFURBISHMENT

SITE ADDRESS:
19-27 STATION ROAD, MORAYFIELD

SCALE: 1:100 UNO SHEET SIZE: AT A1

DRAWING TITLE:
**ELECTRICAL SERVICES
GROUND LEVEL PART C
JOINERY & WALL
LIGHTING PLAN**

PROJECT NO. DRAWING NO. REVISION:
C3264a E12 B