

NOTES

THE FOLLOWING CIRCUITS ARE EXISTING TO BE MODIFIED / EXTENDED AS NECESSARY TO SUPPLY THE NOMINATED OUTLETS:

- DB-2 - L15.
- DB-2 - L20.
- DB-2 - L35.
- DB-4 - L5.
- DB-4 - L10.
- DB-4 - L11.

PROVIDE THE FOLLOWING NEW CIRCUITS AS 20 AMP RCBO PROTECTED 2.5MM SINGLE PHASE TO SUPPLY THE NOMINATED OUTLETS:

- DB-4 - L22.
- DB-4 - L23.

THE FOLLOWING PHILIPS DYNALITE CHANNELS ARE EXISTING TO BE MODIFIED / EXTENDED AS NECESSARY TO CONTROL THE NOMINATED SERVICES:


- CHANNEL 150 - DALI.
- CHANNEL 151 - DALI.
- CHANNEL 211 - DALI.
- CHANNEL 212 - DALI.
- CHANNEL 230 - DALI.
- CHANNEL 231 - DALI.
- CHANNEL 232 - DALI.
- CHANNEL 234 - DALI.
- CHANNEL 235 - DALI.

UTILISE THE FOLLOWING EXISTING SPARE PHILIPS DYNALITE CHANNELS TO CONTROL THE NOMINATED SERVICES:

- CHANNEL 167 - SWITCHED.
- CHANNEL 168 - SWITCHED.
- CHANNEL 169 - SWITCHED.
- CHANNEL 240 - SWITCHED.

PROVIDE THE FOLLOWING NEW PHILIPS DYNALITE CHANNELS TO CONTROL THE NOMINATED SERVICES:

- CHANNEL 245 - SWITCHED.
- CHANNEL 246 - SWITCHED.

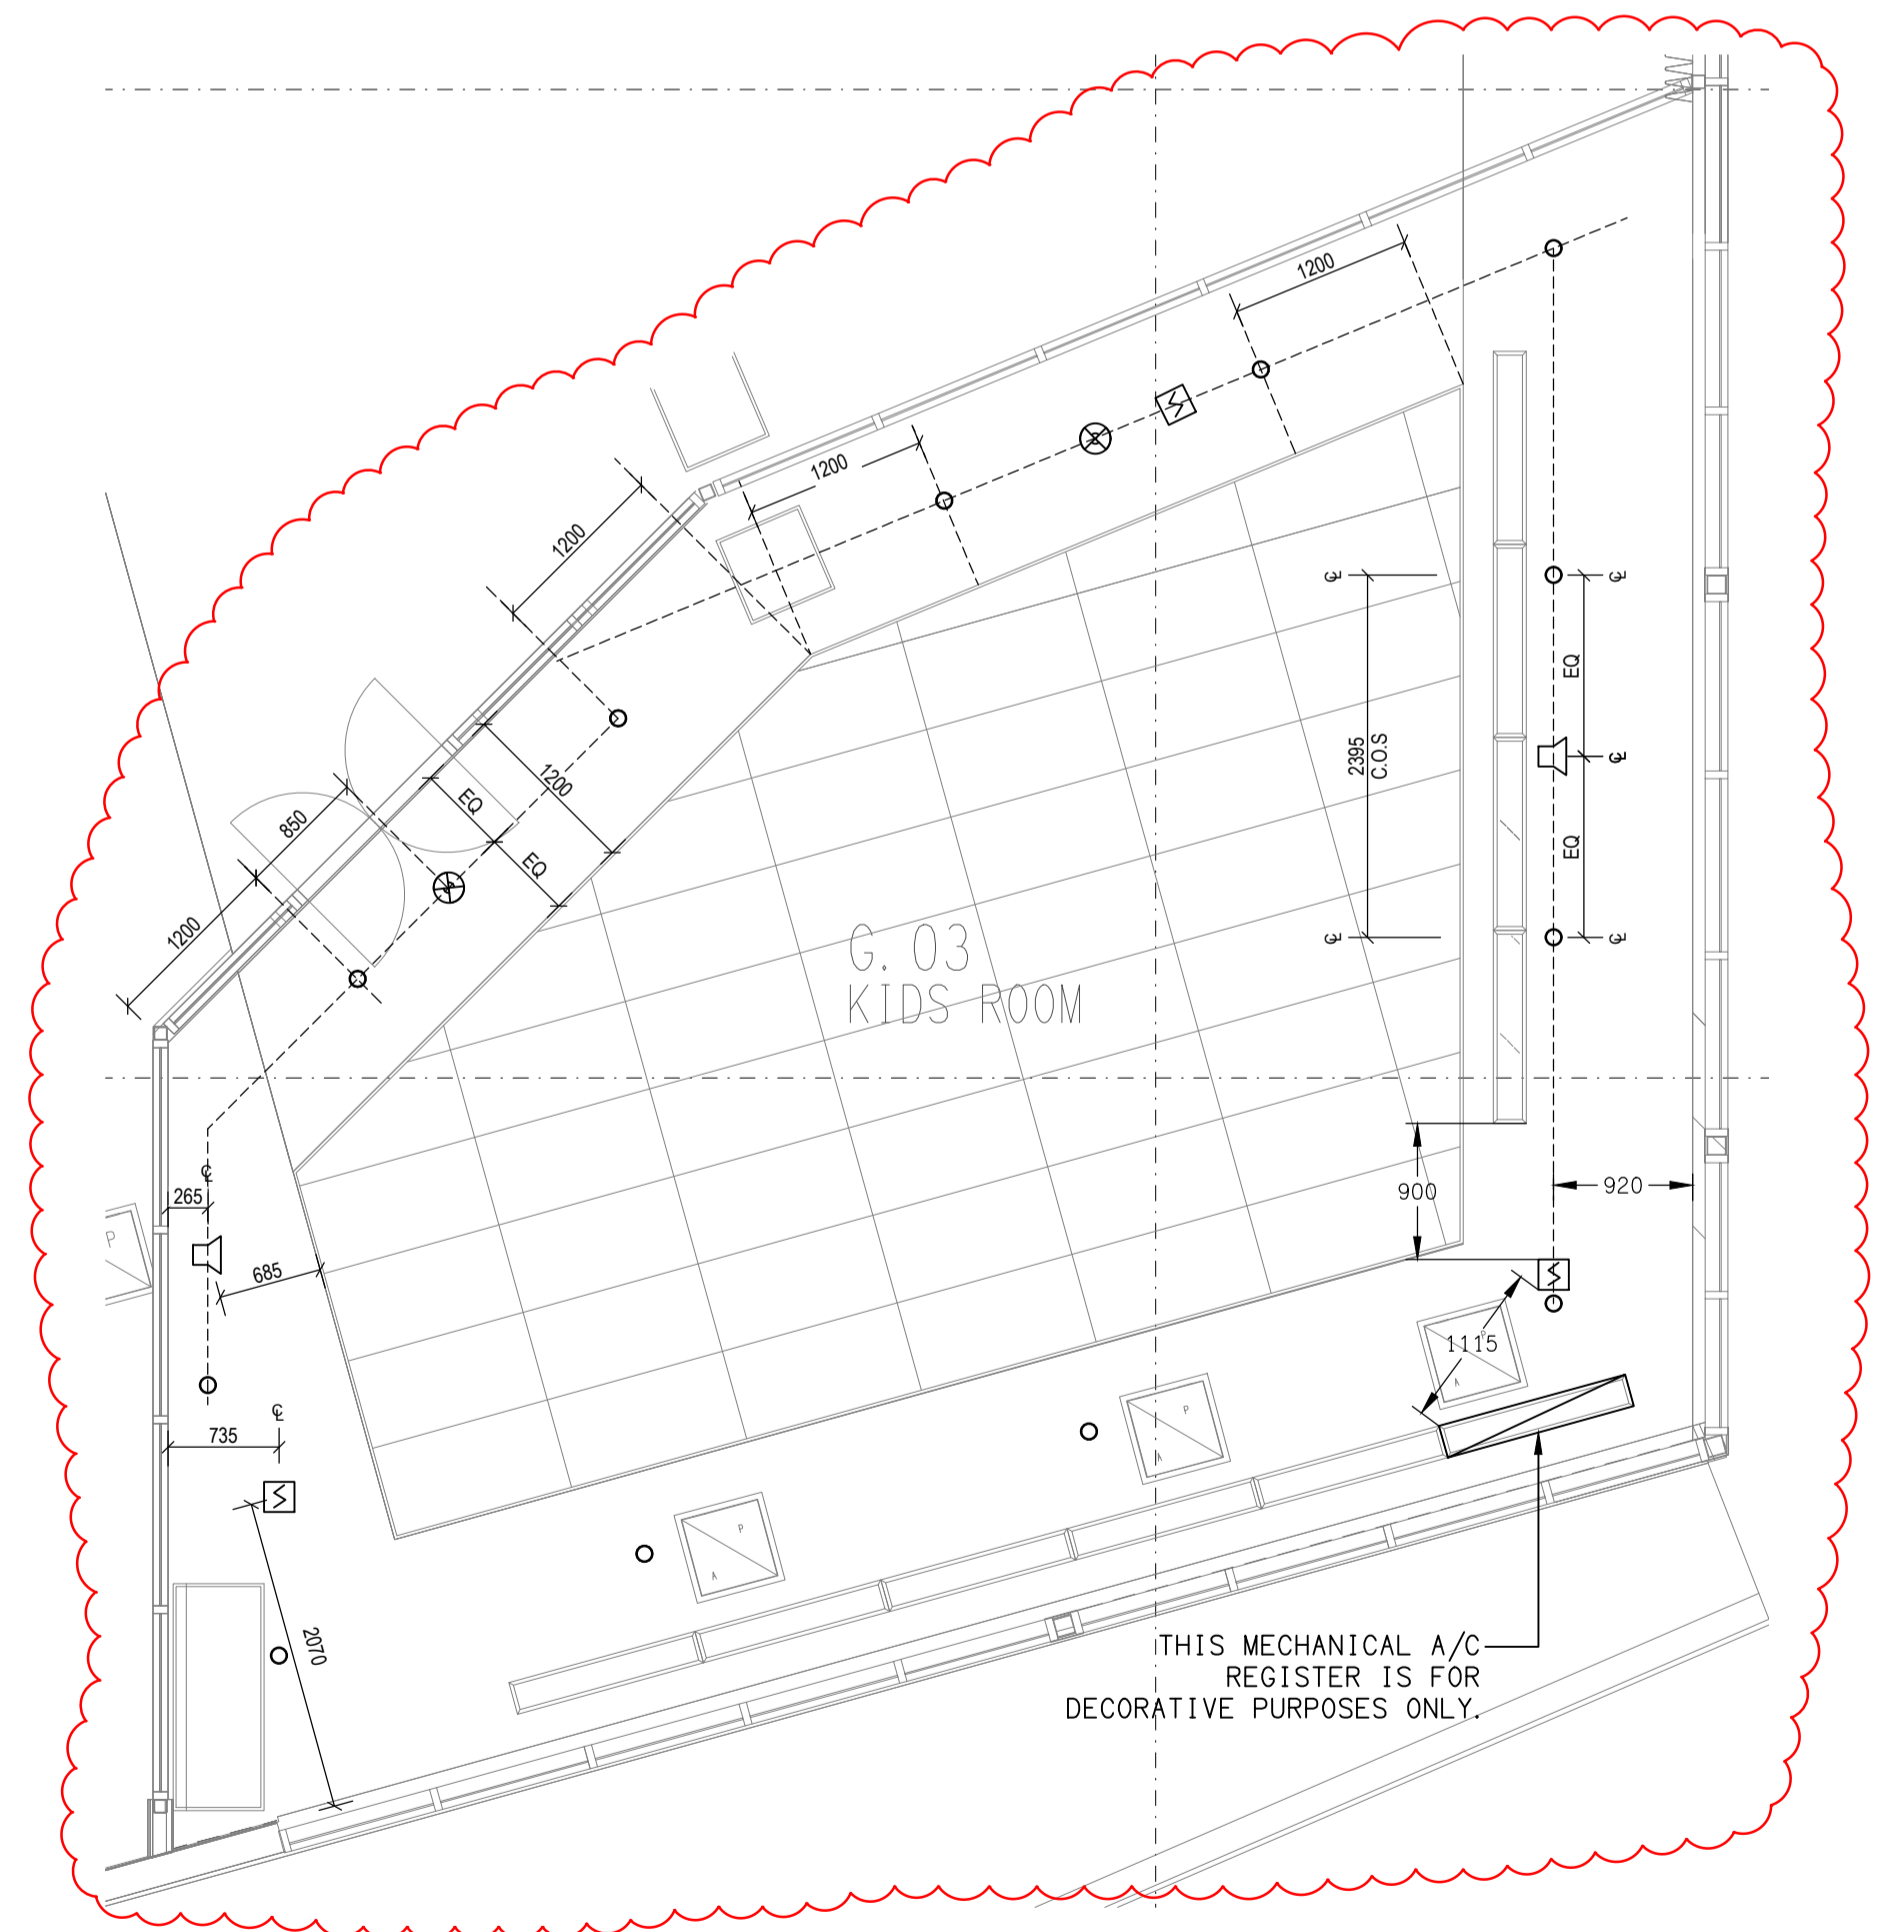

DETAIL A
KIDS ROOM CEILING LAYOUT
SCALE 1:50

ELECTRICAL DESIGN GROUP BRISBANE
PTY LTD
ACN 092 710 793
TRADING AS:
ELECTRICAL DESIGN GROUP

THE COPYRIGHT OF THIS DRAWING
REMAINS THE PROPERTY OF THE
ELECTRICAL DESIGN GROUP.

USE FIGURED DIMENSIONS
IN PREFERENCE TO SCALE.

ALL DIMENSIONS TO BE
VERIFIED ONSITE.

ELECTRICAL DESIGN GROUP
ELECTRICAL BUILDING SERVICES CONSULTANTS
BRISBANE GOLD COAST

P.O. Box 15, Sherwood Q.4075
Phone: (07) 3278 4375
Email: brisbane@edg.net.au
Web: www.edg.net.au

PROJECT:
**BROTHERS LEAGUES CLUB, IPSWICH
BISTRO & KIDS ROOM**

WILDEY STREET, IPSWICH

3	CONSTRUCTION	10/10/2024
REV:	DESCRIPTION:	DATE:

DRAWING:
**ELECTRICAL SERVICES
GROUND LEVEL REFLECTED CEILING PLAN**

SCALE: 1:100	AT A1	PROJECT NO: C3269a	DRAWING NO: E05	REVISION: 3
-----------------	-------	------------------------------	---------------------------	-----------------------