



MSB NOTES


- UPGRADE THE EXISTING CARPARK SITE ENERGEX POWER SUPPLY TO 80 AMP THREE PHASE WITH A NEW STEEL PROPERTY POLE AND POLE MOUNTED MAIN SWITCHBOARD. ARRANGE FOR THE NEW SUPPLY WITH ENERGEX AND RETAIL METERS TO BE PROVIDED.
- RECONNECT THE EXISTING CIRCUITS TO THE NEW MSB WITH NEW SWITCHGEAR AND CONTROLS THAT REFLECT THE EXISTING IN CAPACITY AND FUNCTION. PROVIDE A NEW 3 PHASE 80 AMP SUPPLY TO THE NEW KIA EV CHARGER.
- THE EXISTING SERVICES MADE REDUNDANT BY THE NEW PROPERTY POLE AND MAIN SWITCHBOARD ARE TO BE REMOVED.
- PROVIDE THE SITE MAIN SWITCHBOARD (MSB) AS FOLLOWS:
- POLE MOUNTED.
 - NATIONAL ELECTRICITY MARKET (NEM) COMPLIANT RETAIL METERING.
 - POWDER COATED LIGHT GREY ENCLOSURE AND DOORS.
 - LOCKABLE DOOR.
 - GLOSS WHITE ESCUTCHEONS.
 - ALL COMPONENTS ARE TO BE LABELLED WITH NON-STICK LABELS.

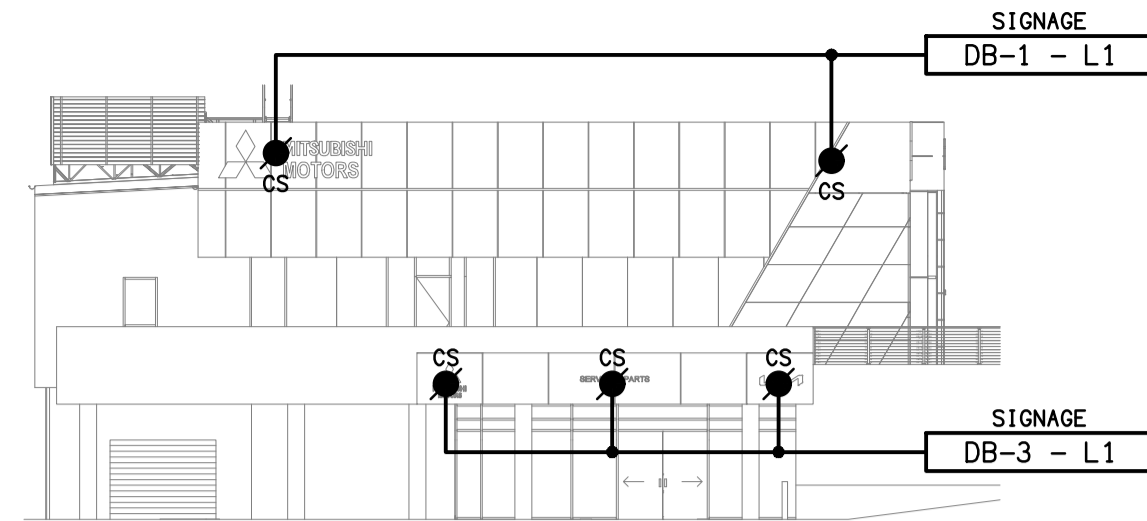


DETAIL A
NORTH WEST EXTERNAL BUILDING ELEVATION
SCALE 1:200

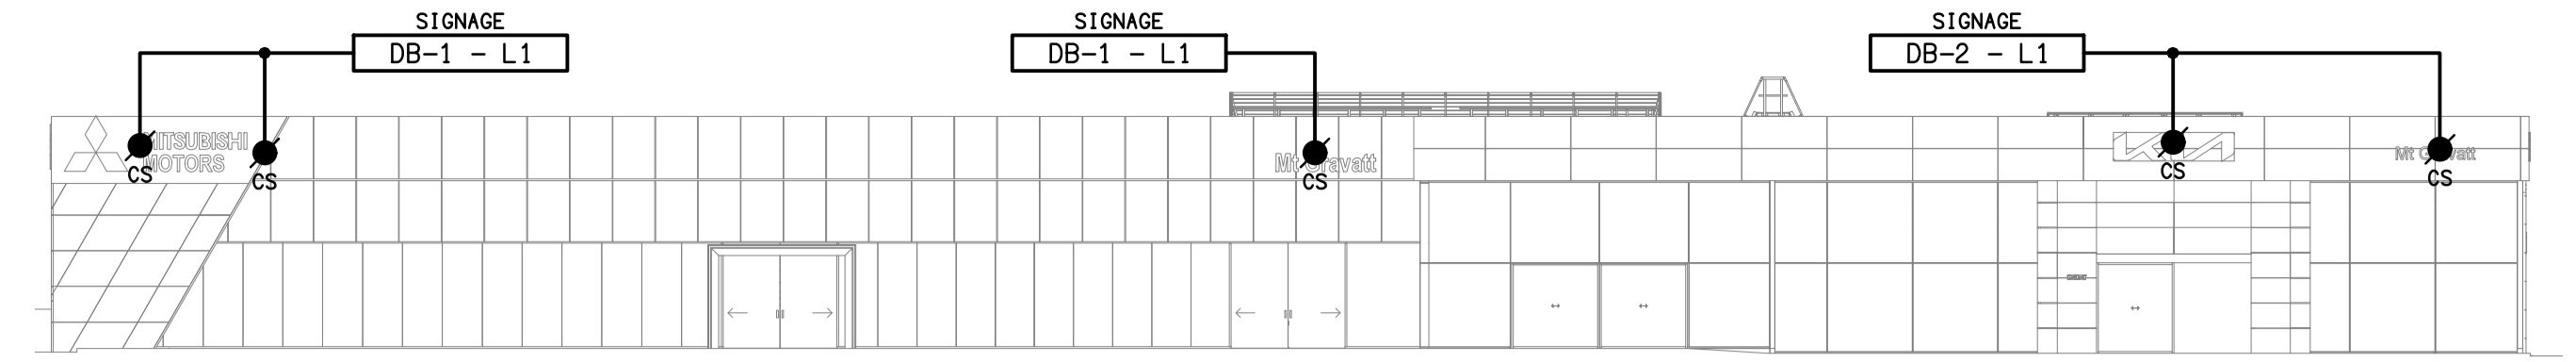


DETAIL B
SOUTH WEST EXTERNAL BUILDING ELEVATION
SCALE 1:200

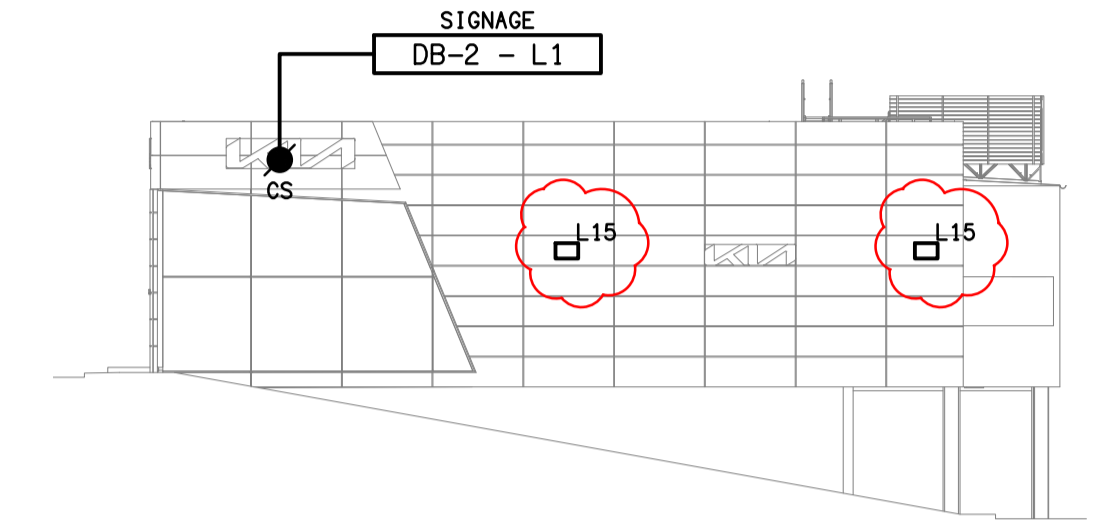


DETAIL C
SOUTH EAST EXTERNAL BUILDING ELEVATION
SCALE 1:200

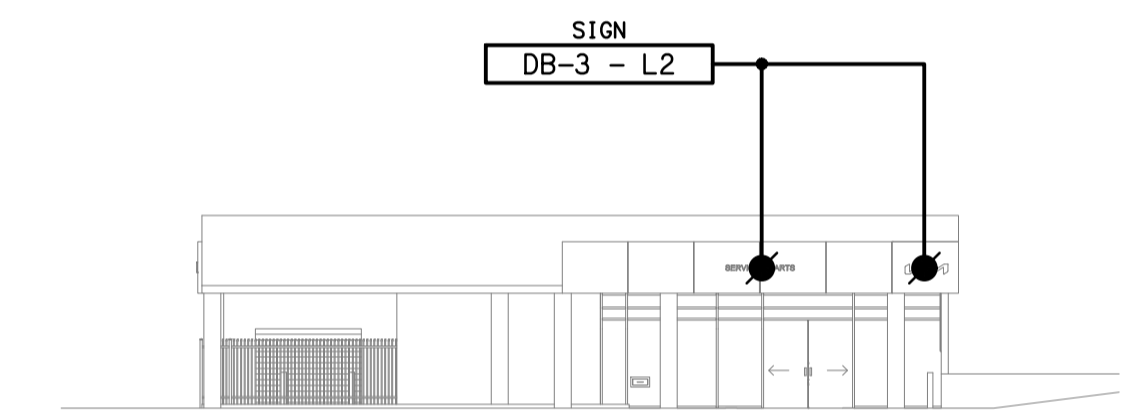


DETAIL D
EXTERNAL BUILDING ELEVATION
SCALE 1:200

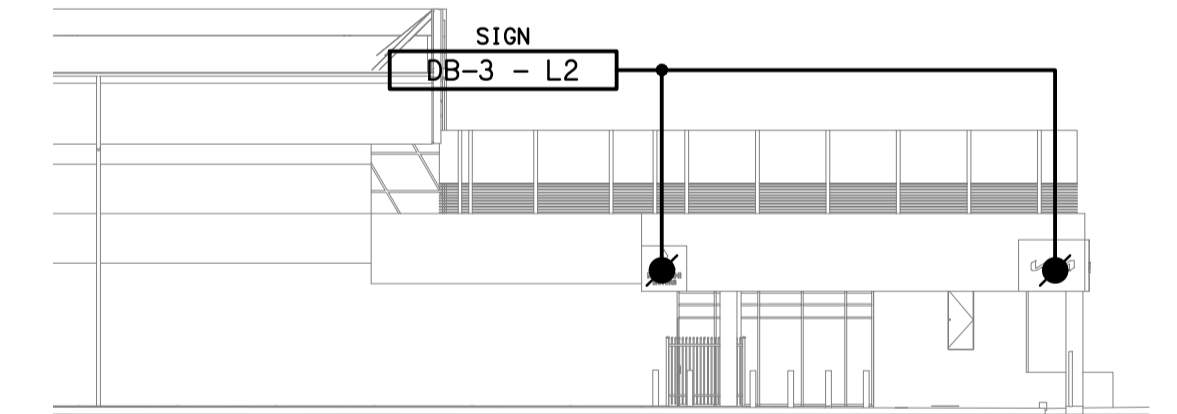

DETAIL E
EXTERNAL BUILDING ELEVATION
SCALE 1:200

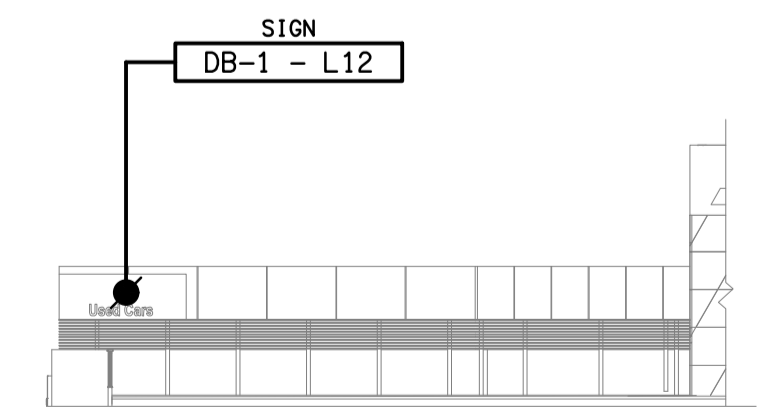

DETAIL F
EXTERNAL BUILDING ELEVATION
SCALE 1:200

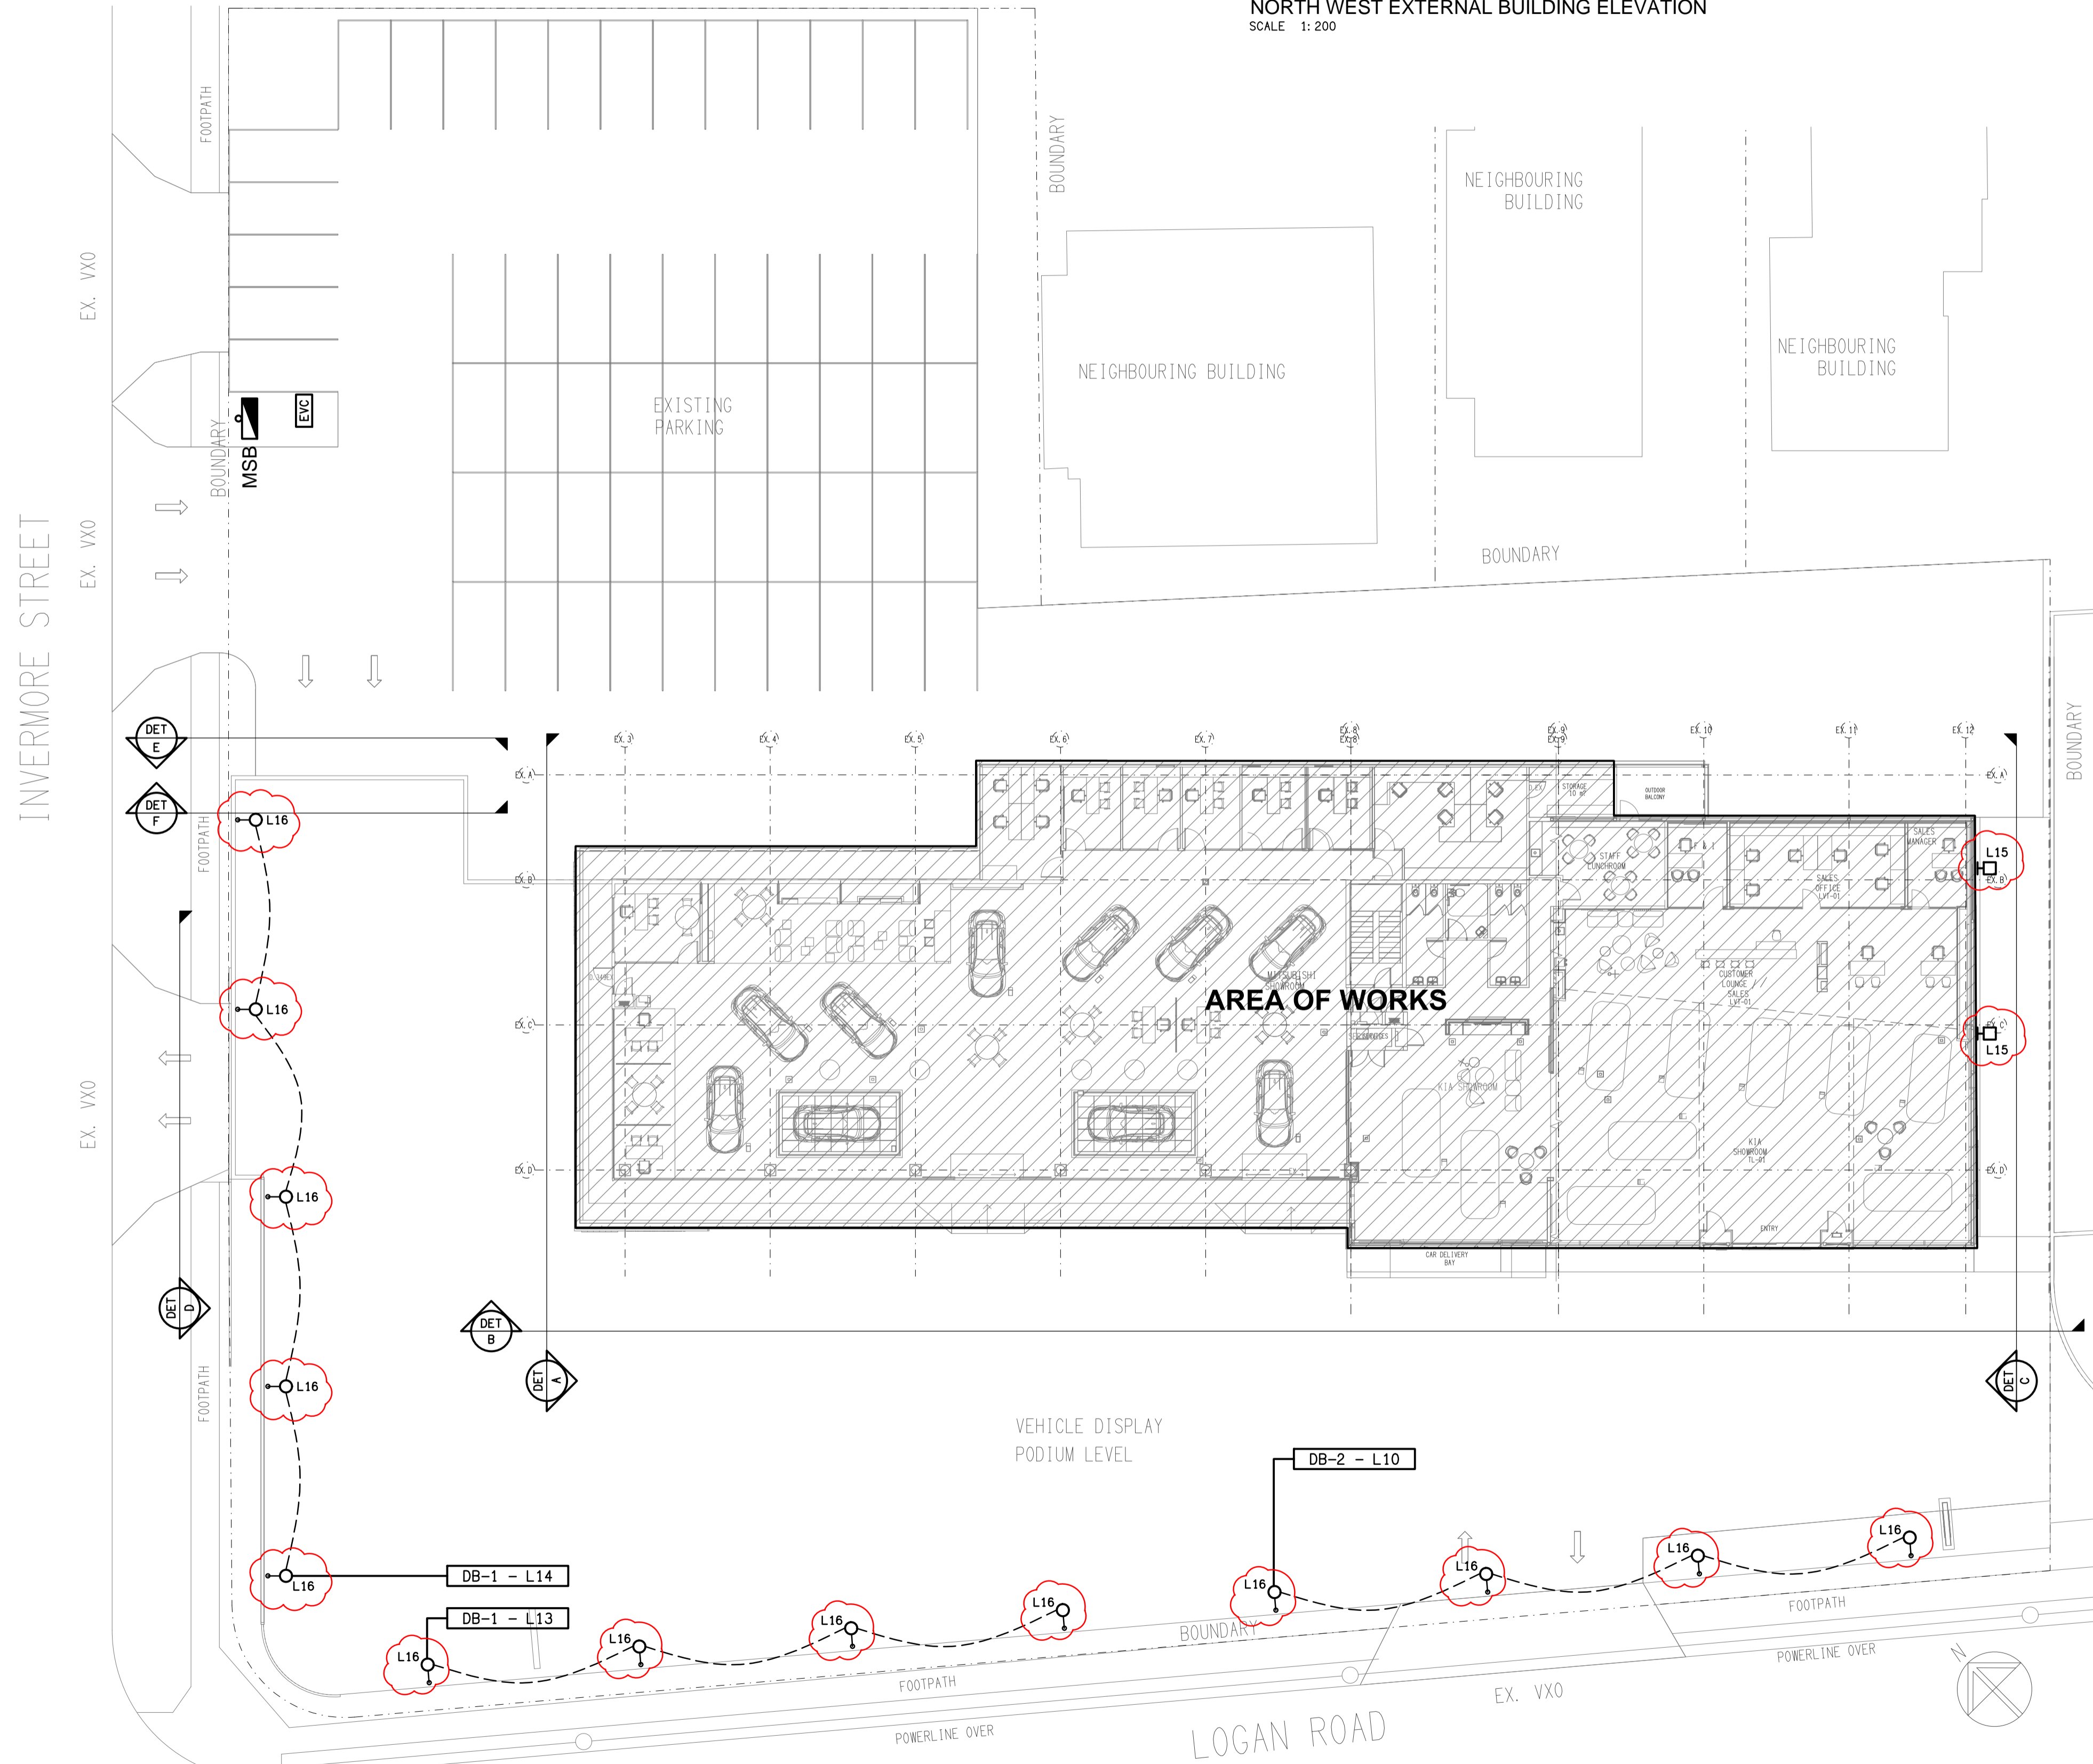

ELECTRICAL DESIGN GROUP BRISBANE
PTY LTD
ACN 092 710 793
TRADING AS:
ELECTRICAL DESIGN GROUP

THE COPYRIGHT OF THIS DRAWING
REMAINS THE PROPERTY OF THE
ELECTRICAL DESIGN GROUP.
USE FIGURED DIMENSIONS
IN PREFERENCE TO SCALE.
ALL DIMENSIONS TO BE
VERIFIED ONSITE.

ELECTRICAL DESIGN GROUP
ELECTRICAL BUILDING SERVICES CONSULTANTS
BRISBANE GOLD COAST
P.O. Box 15, Sherwood Q.4075
Phone: (07) 3278 4375
Email: brisbane@edg.net.au
Web: www.edg.net.au

PROJECT:
EAGERS MT GRAVATT - MITSUBISHI & KIA
1332 LOGAN ROAD, MT GRAVATT

D	TENDER	18/11/2024
REV.	DESCRIPTION:	DATE:
DRAWING: ELECTRICAL SERVICES SITE PLAN		
SCALE: 1:200	AT A1	PROJECT NO: C3284a
		DRAWING NO: E02
		REVISION: D