


FLOOR PLAN
ALFA / FIAT & JEEP
SCALE: 1:50

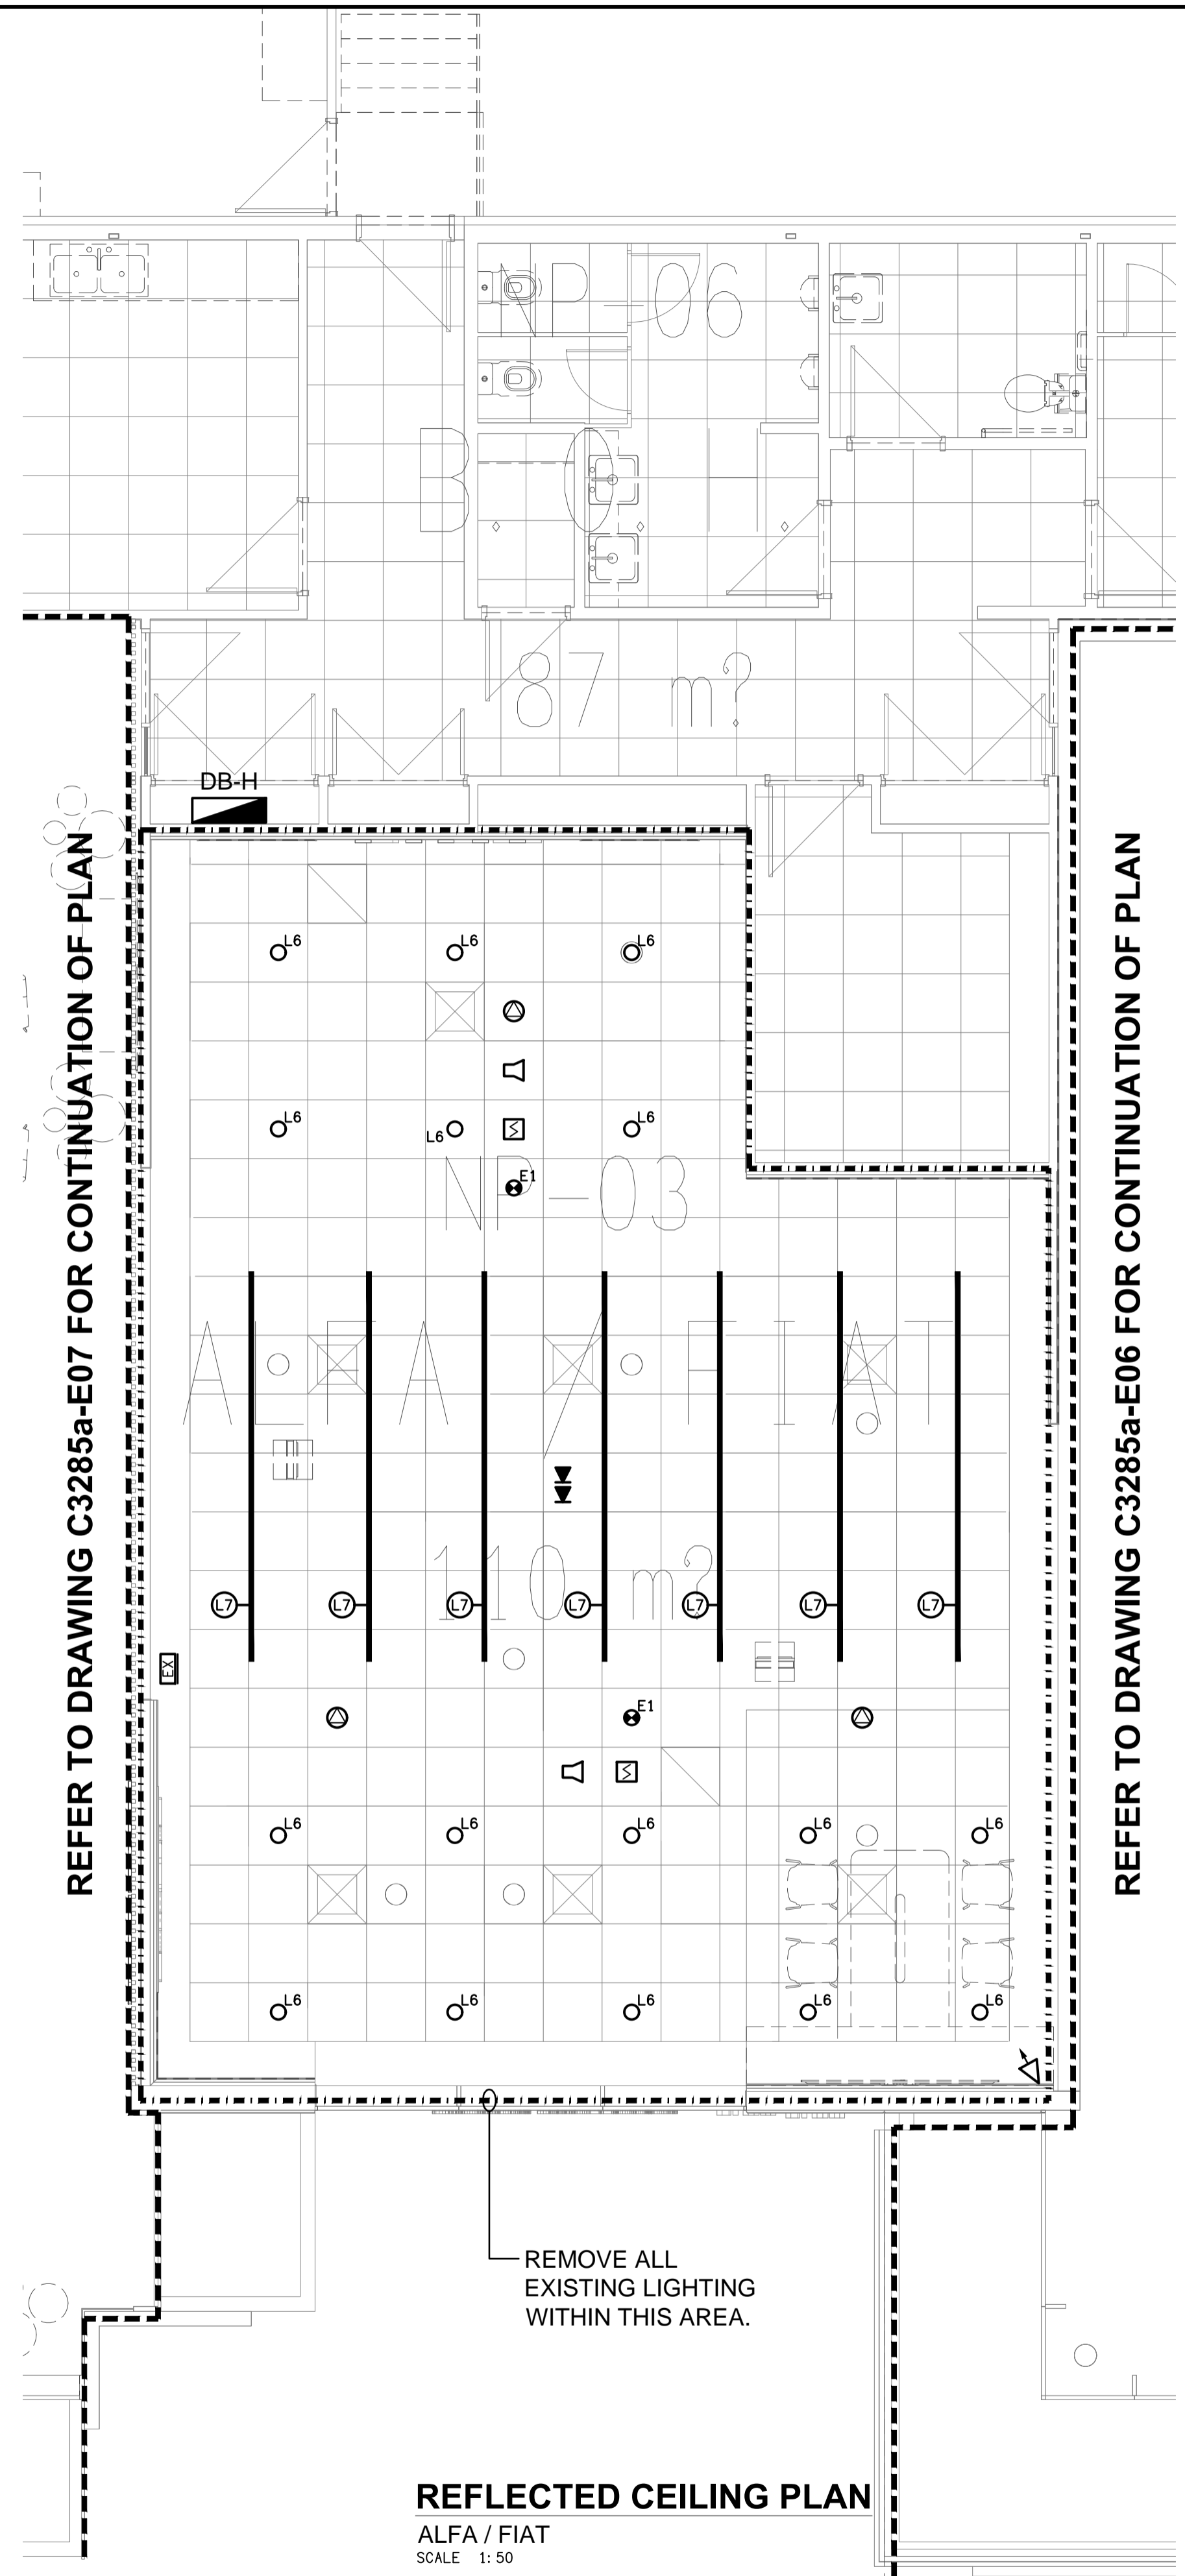

REFLECTED CEILING PLAN
ALFA / FIAT
SCALE: 1:50

ELECTRICAL DESIGN GROUP BRISBANE PTY LTD
ACN 092 710 793
TRADING AS:
ELECTRICAL DESIGN GROUP

THE COPYRIGHT OF THIS DRAWING REMAINS THE PROPERTY OF THE ELECTRICAL DESIGN GROUP.
USE FIGURED DIMENSIONS IN PREFERENCE TO SCALE.
ALL DIMENSIONS TO BE VERIFIED ONSITE.

ELECTRICAL DESIGN GROUP
ELECTRICAL BUILDING SERVICES CONSULTANTS
BRISBANE GOLD COAST
P.O. Box 15, Sherwood Q.4075
Phone: (07) 3278 4375
Email: brisbane@edg.net.au
Web: www.edg.net.au

PROJECT:
EAGERS ASPLEY AUTOMALL
1442 GYMPIE ROAD, ASPLEY, QUEENSLAND

B	TENDER	29/08/2024
REV:	DESCRIPTION:	DATE:
DRAWING: ELECTRICAL SERVICES ALFA / FIAT & JEEP FLOOR PLAN & REFLECTED CEILING PLAN		
SCALE: 1:50	PROJECT NO: C3285a	DRAWING NO: E05
AT A1	REVISION: B	