
 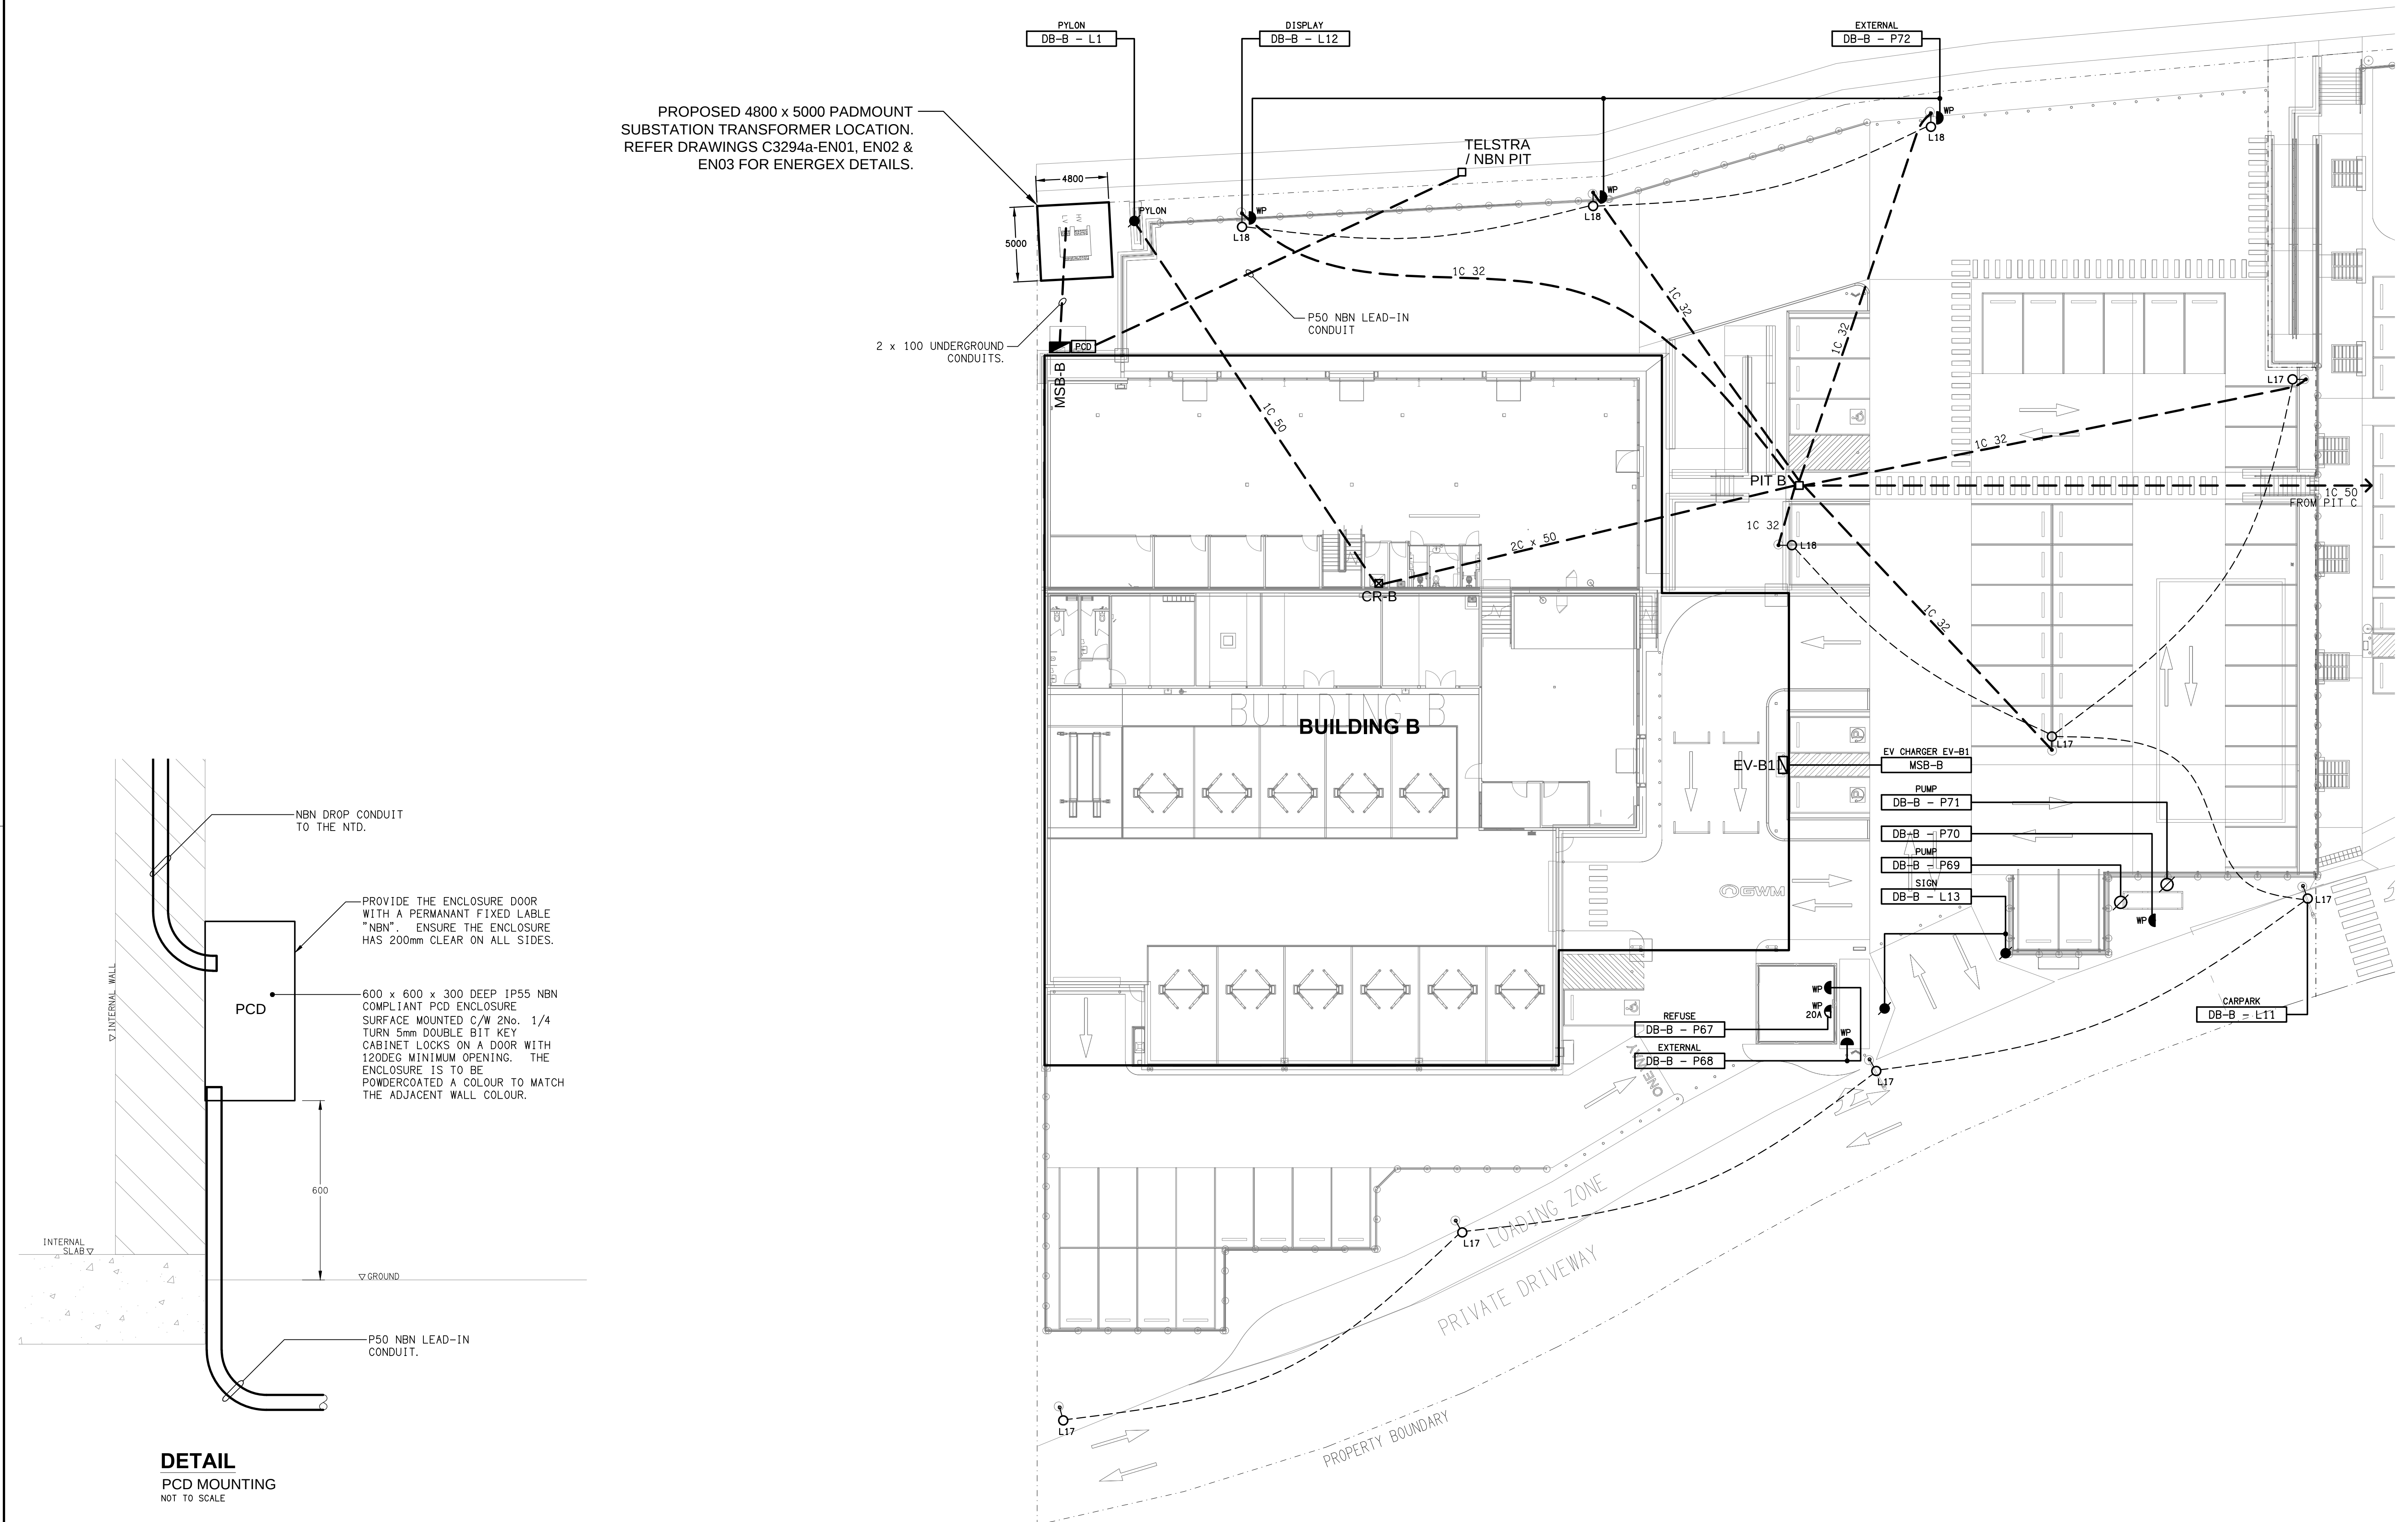




ELECTRICAL DESIGN GROUP BRISBANE PTY LTD ACN 092 710 793 TRADING AS: ELECTRICAL DESIGN GROUP	THE COPYRIGHT OF THIS DRAWING REMAINS THE PROPERTY OF THE ELECTRICAL DESIGN GROUP. USE FIGURED DIMENSIONS IN PREFERENCE TO SCALE. ALL DIMENSIONS TO BE VERIFIED ONSITE.		Rohrig (Qld) Pty Ltd ABN 67 093 753 970 QBSA LIC NO 740842 250 Abbotsford Road, Bowen Hills Qld 4006 PO Box 86 Albion DC Qld 4010 T+61 (7) 3257 4411 F+61 (7) 3257 2211 www.rohrig.com.au	 ELECTRICAL DESIGN GROUP ELECTRICAL BUILDING SERVICES CONSULTANTS BRISBANE GOLD COAST P.O.Box 15, Sherwood Q.4075 Phone: (07) 3278 4375 Email: trisbane@edg.net.au Web: www.edg.net.au	PROJECT: LLEWELLYN MOTORS SPRINGFIELD - LOT 32 LOT 32 AUGUSTA PARKWAY, AUGUSTINE HEIGHTS	DRAWING: ELECTRICAL SERVICES SITE PLAN SCALE: 1:200 AT A1	PROJECT NO: C3294a	DRAWING NO: E03	REVISION: 1
--	--	---	--	--	---	---	--------------------------------------	-----------------------------------	-------------------------------