
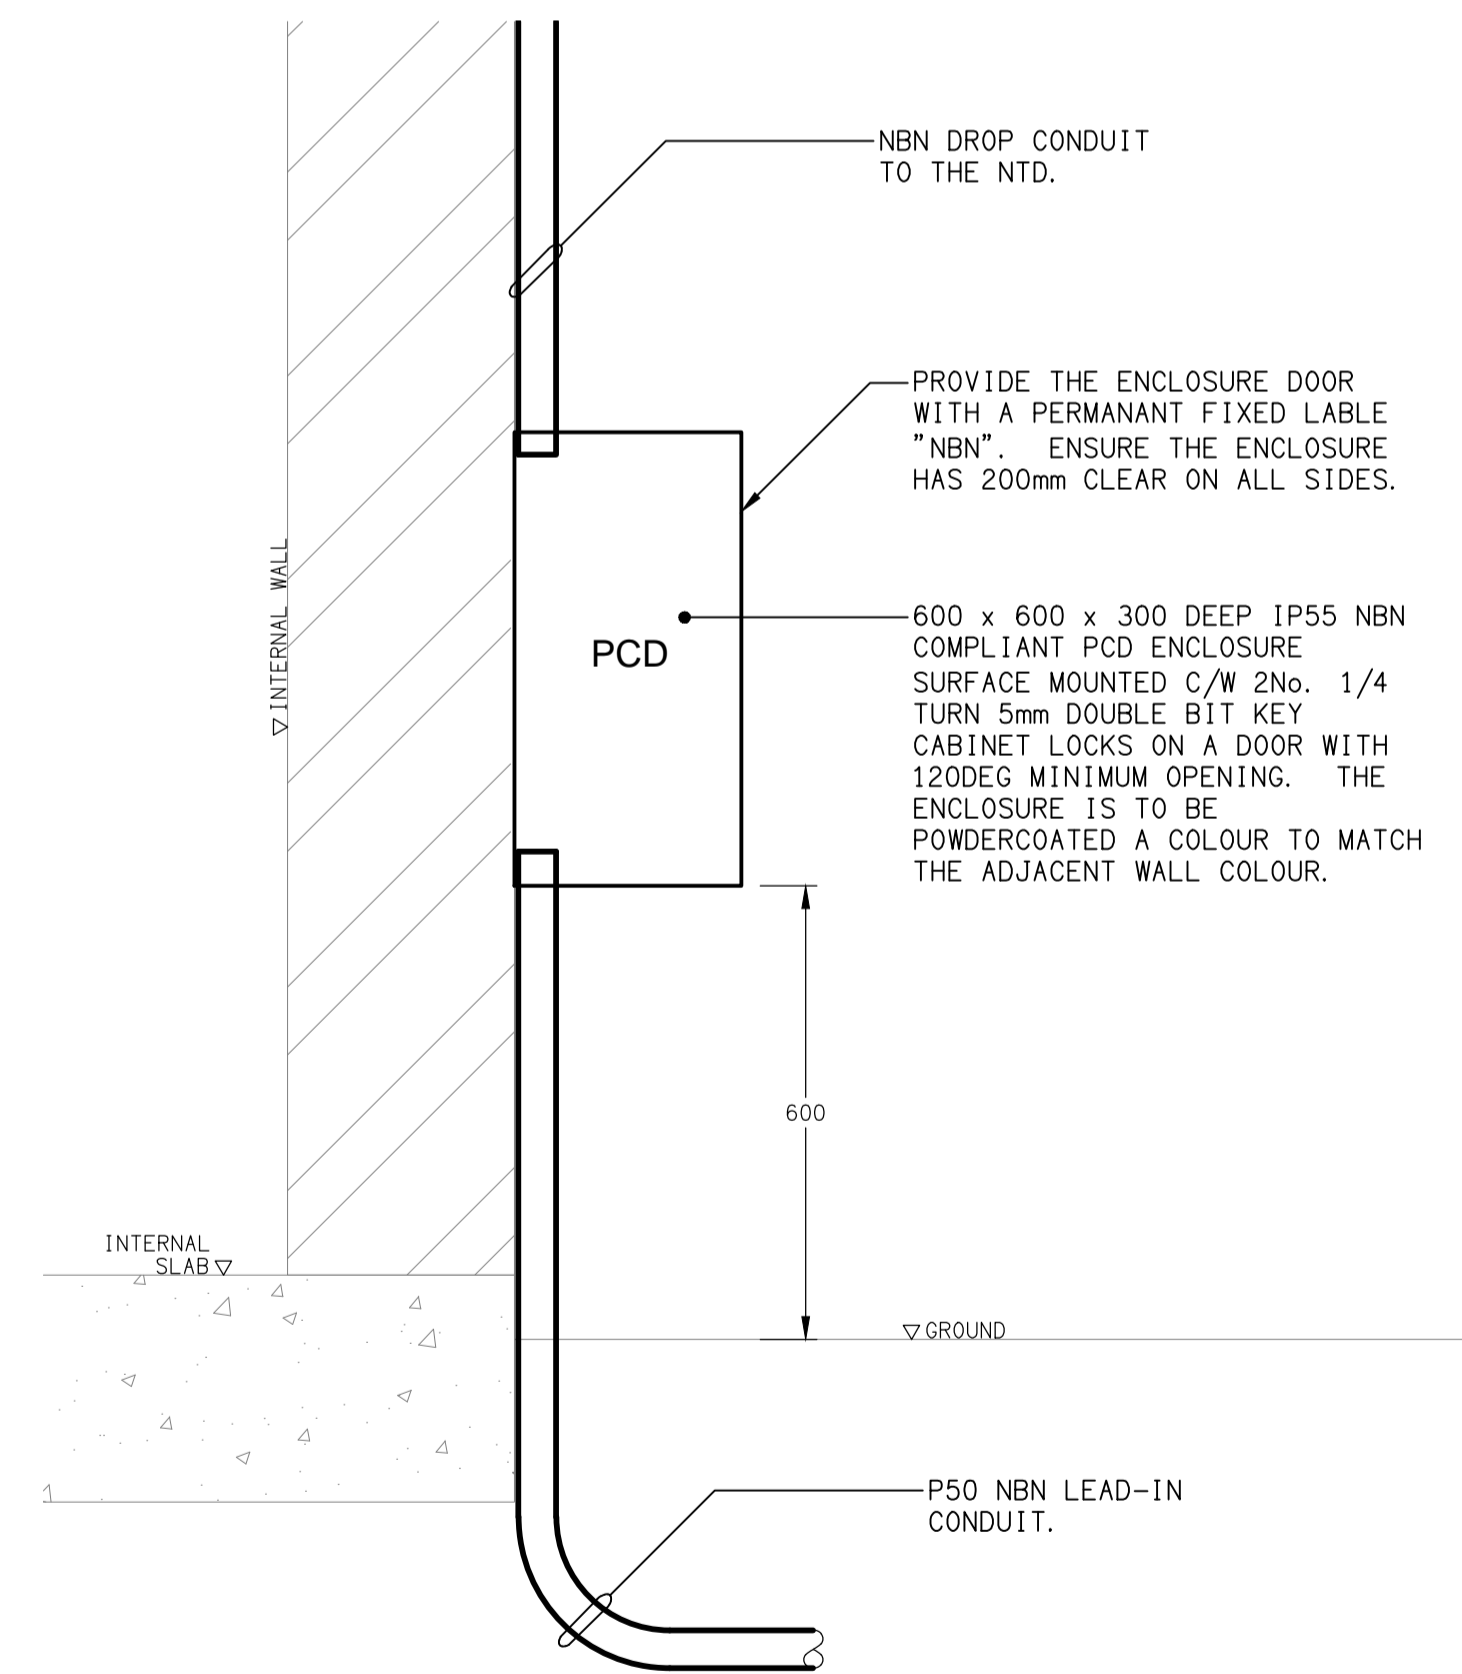


AUGUSTA PARKWAY

PROPOSED 4800 x 5000 PADMOUNT SUBSTATION TRANSFORMER LOCATION. REFER DRAWINGS C3294a-EN01, EN02 & EN03 FOR ENERGEX DETAILS.

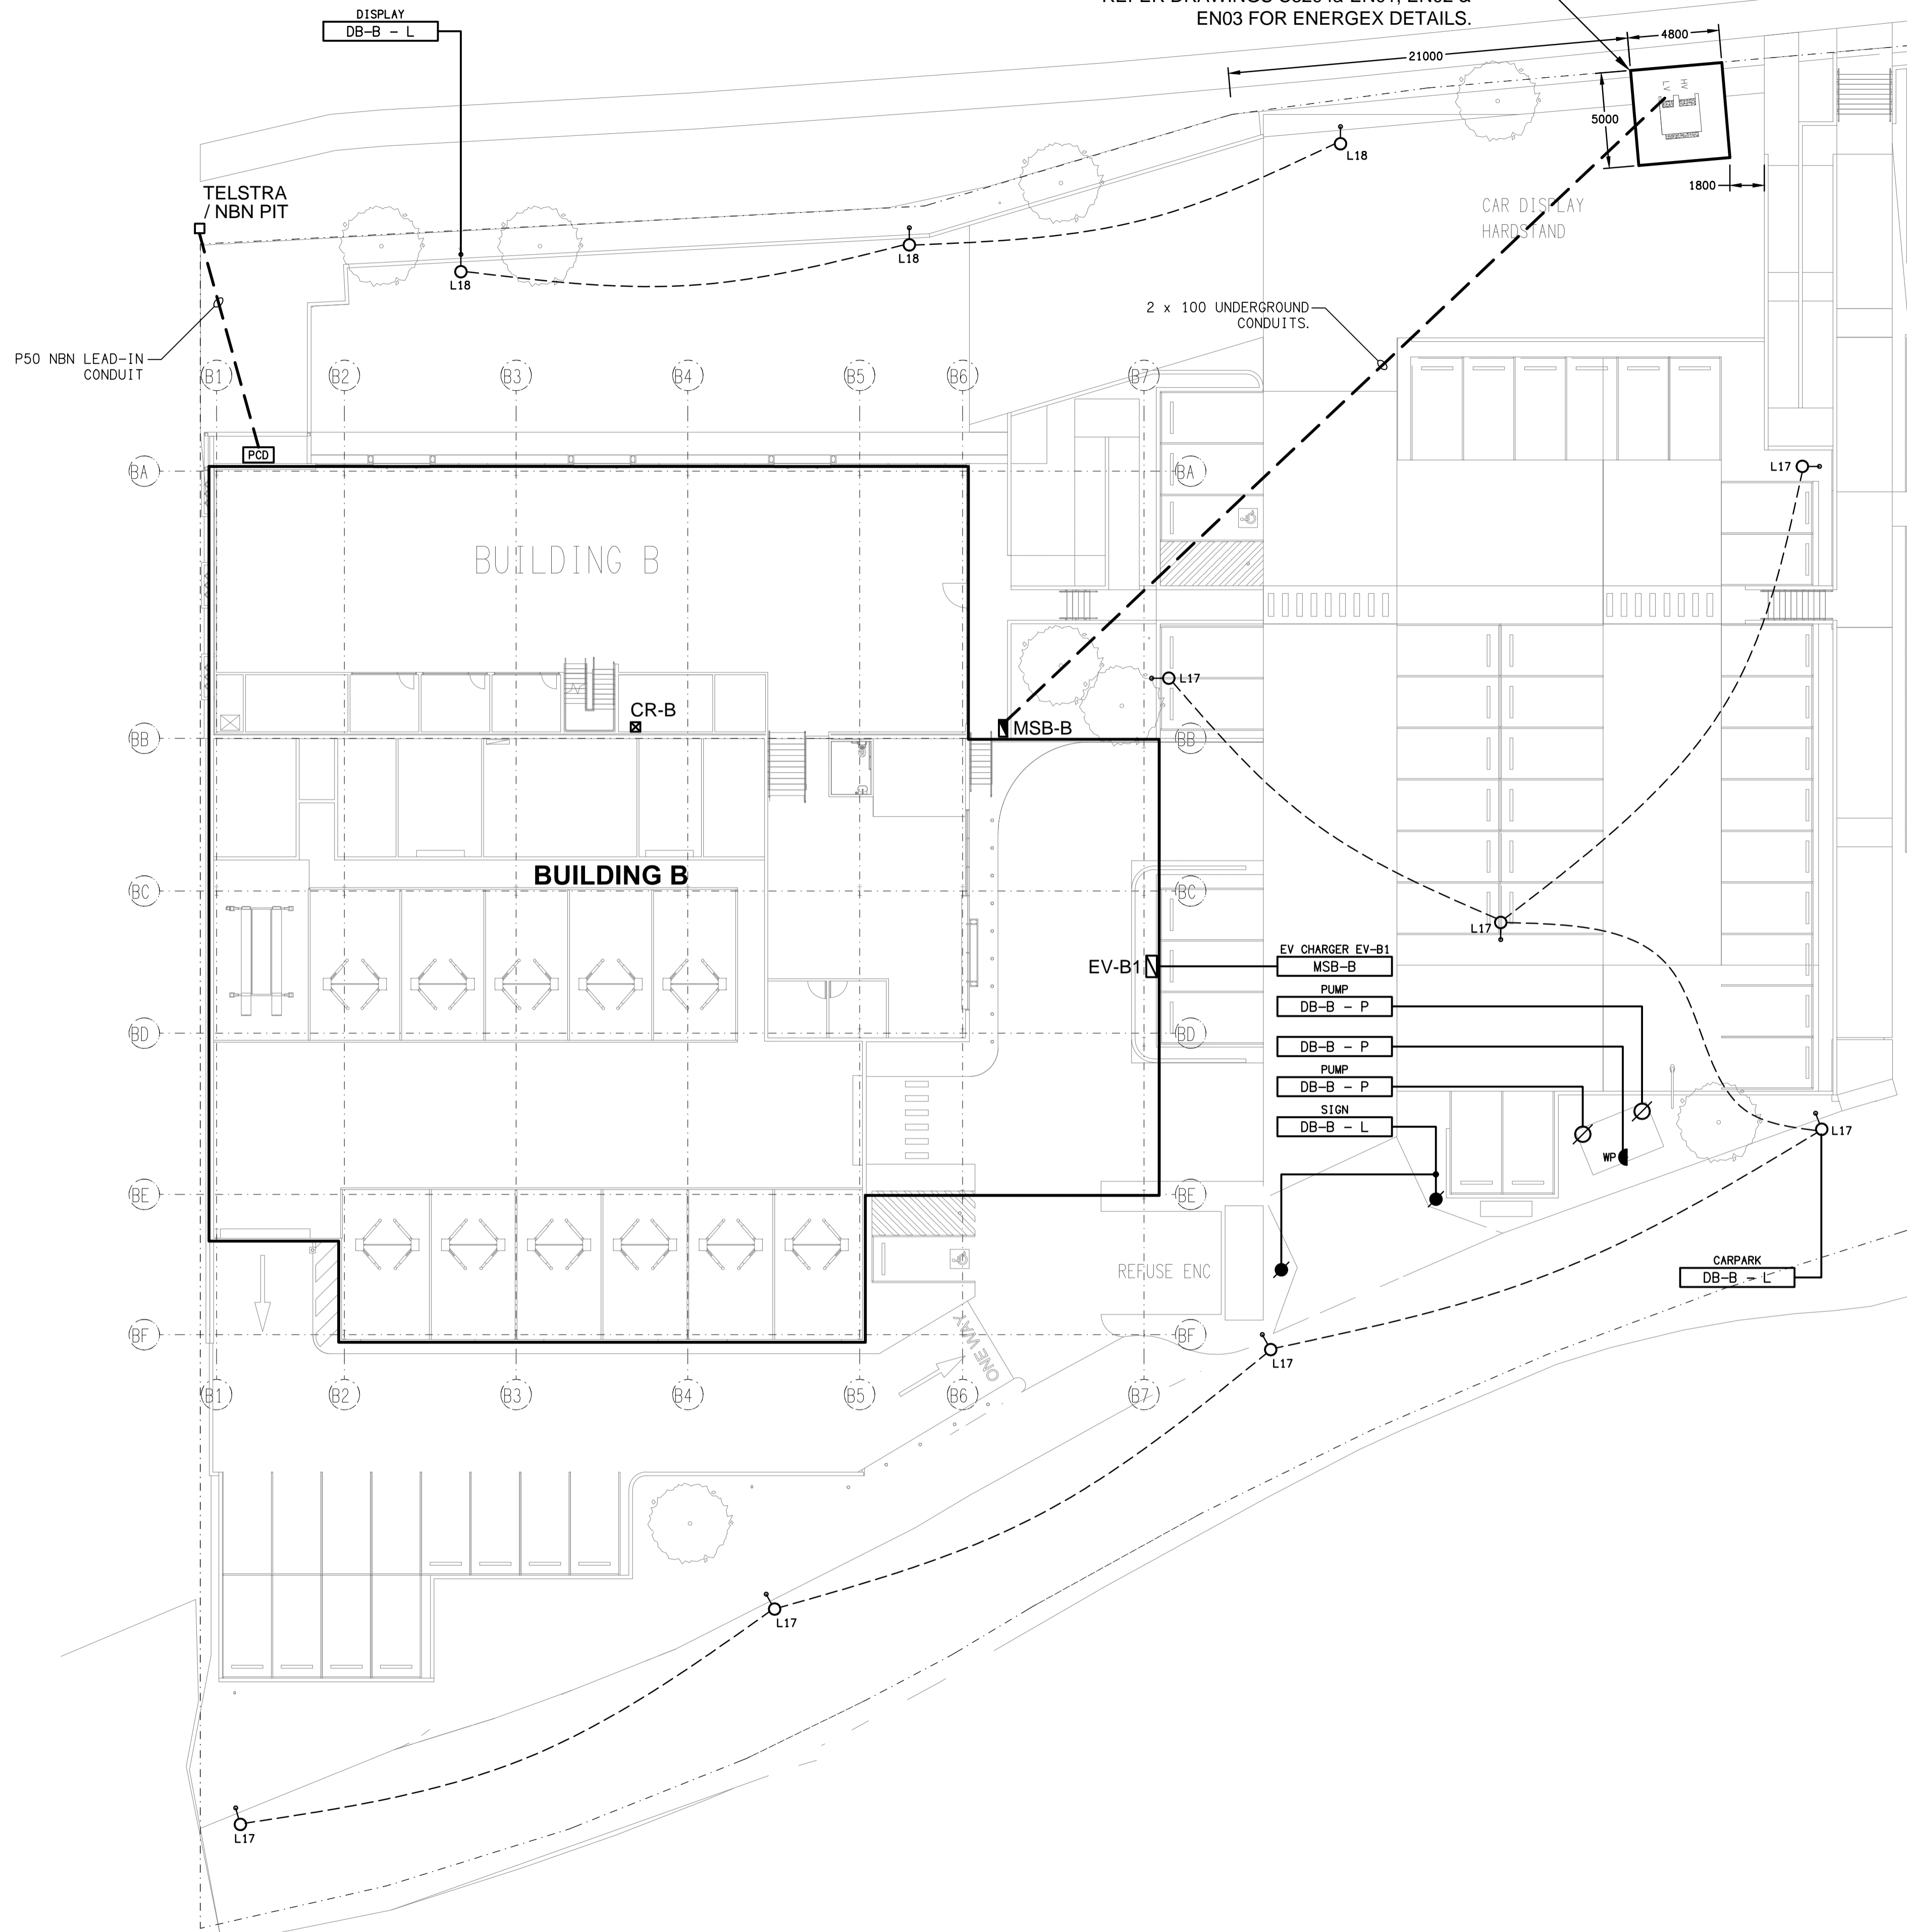

ELECTRICAL DESIGN GROUP BRISBANE PTY LTD
ACN 092 710 793
TRADING AS:
ELECTRICAL DESIGN GROUP

THE COPYRIGHT OF THIS DRAWING REMAINS THE PROPERTY OF THE ELECTRICAL DESIGN GROUP.
USE FIGURED DIMENSIONS IN PREFERENCE TO SCALE.
ALL DIMENSIONS TO BE VERIFIED ONSITE.



Rohrig (Qld) Pty Ltd
ABN 67 093 753 970
QBSA LIC NO 740842
250 Abbotsford Road, Bowen Hills Qld 4006
PO Box 86 Albion DC Qld 4010
T+61 (7) 3257 4411 F+61 (7) 3257 2211
www.rohrig.com.au

ELECTRICAL DESIGN GROUP
ELECTRICAL BUILDING SERVICES CONSULTANTS
BRISBANE GOLD COAST

P.O. Box 15, Sherwood Q.4075
Phone: (07) 3278 4375
Email: brisbane@edg.net.au
Web: www.edg.net.au

PROJECT:
LLEWELLYN MOTORS SPRINGFIELD - LOT 32

LOT 32 AUGUSTA PARKWAY, AUGUSTINE HEIGHTS

| | | |
|------|--------------|------------|
| A | PRELIMINARY | 07/11/2024 |
| REV. | DESCRIPTION: | DATE: |

DRAWING:
ELECTRICAL SERVICES
SITE PLAN

SCALE:
1:200

AT A1

PROJECT NO:
C3294a

DRAWING NO:
E03

REVISION:
A