



REFLECTED CEILING PLAN
MEZZANINE LEVEL
SCALE 1: 100

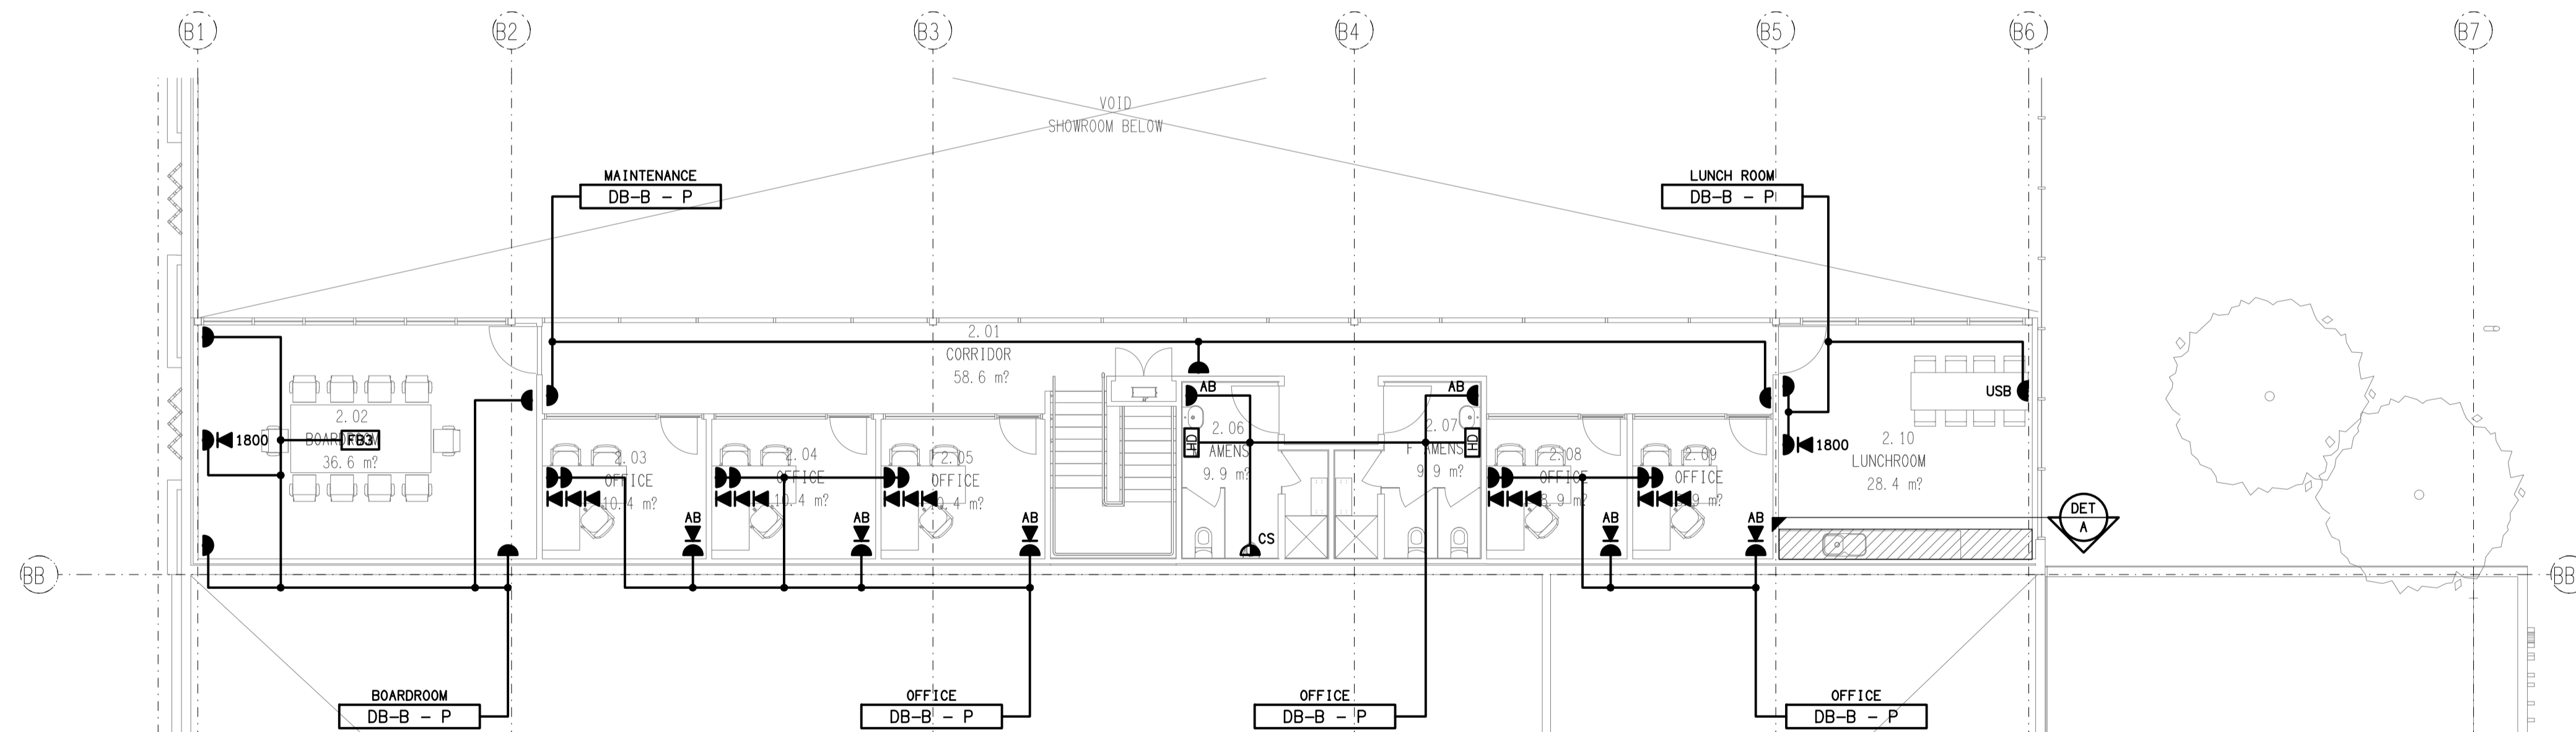

FLOOR PLAN
MEZZANINE LEVEL
SCALE 1: 100

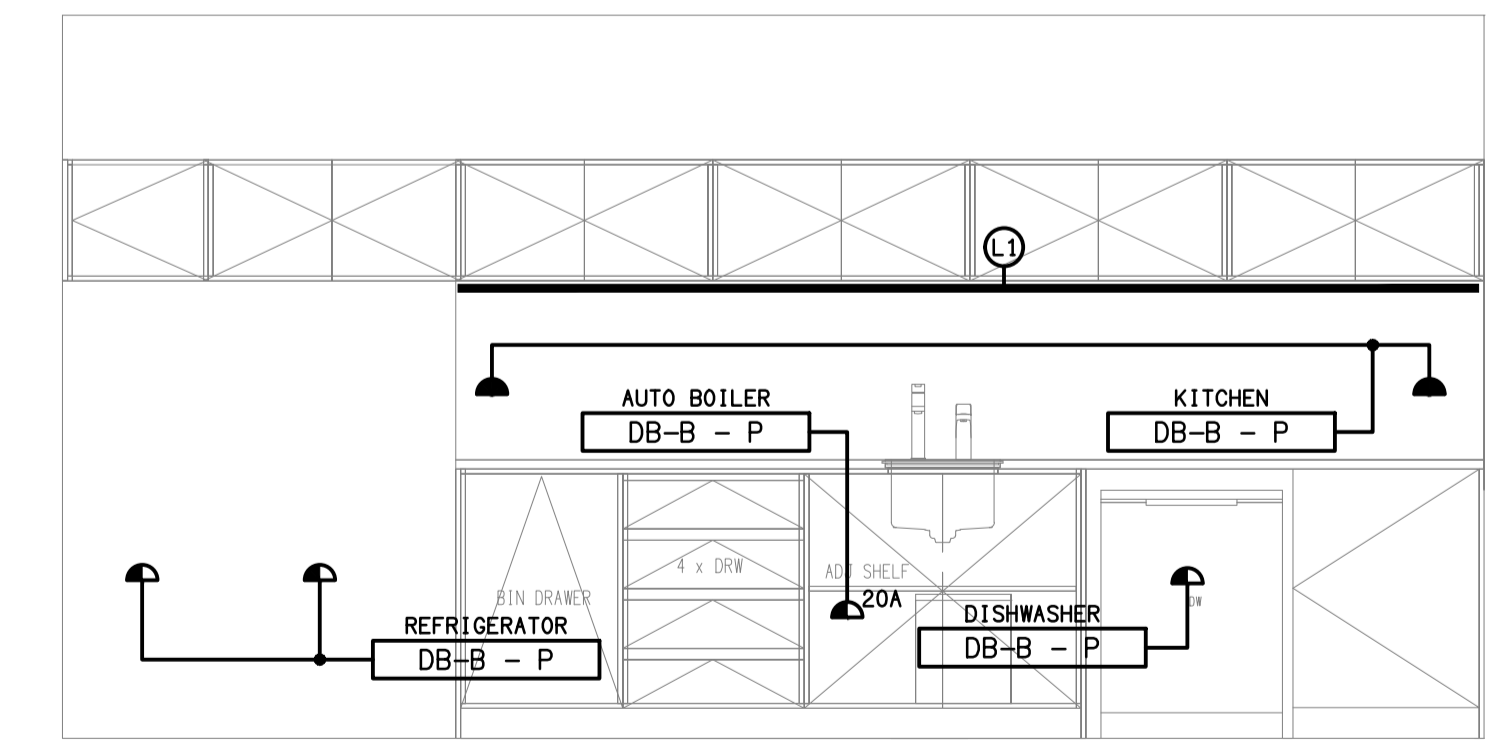

DETAIL A
LUNCH ROOM KITCHENETTE ELEVATION
SCALE 1: 25

ELECTRICAL DESIGN GROUP BRISBANE
PTY LTD
ACN 092 710 793

TRADING AS:
ELECTRICAL DESIGN GROUP

THE COPYRIGHT OF THIS DRAWING
REMAINS THE PROPERTY OF THE
ELECTRICAL DESIGN GROUP.

USE FIGURED DIMENSIONS
IN PREFERENCE TO SCALE.

ALL DIMENSIONS TO BE
VERIFIED ONSITE.



Rohrig (Qld) Pty Ltd
ABN 67 093 753 970
QBSA LIC NO 740842
250 Abbotsford Road, Bowen Hills Qld 4006
PO Box 86 Albion DC Qld 4010
T+61 (7) 3257 4411 F+61 (7) 3257 2211
www.rohrig.com.au

ELECTRICAL DESIGN GROUP
ELECTRICAL BUILDING SERVICES CONSULTANTS
BRISBANE GOLD COAST

P.O. Box 15, Sherwood Q.4075
Phone: (07) 3278 4375
Email: brisbane@edg.net.au
Web: www.edg.net.au

PROJECT:
LLEWELLYN MOTORS SPRINGFIELD - LOT 32

LOT 32 AUGUSTA PARKWAY, AUGUSTINE HEIGHTS

A	PRELIMINARY	07/11/2024
REV:	DESCRIPTION:	DATE:

DRAWING:
ELECTRICAL SERVICES
MEZZANINE LEVEL
FLOOR & REFLECTED CEILING PLANS

SCALE: 1:100 UNO	PROJECT NO: C3294a	DRAWING NO: E06	REVISION: A
---------------------	------------------------------	---------------------------	-----------------------