

NOTE:
THERE ARE NO HYDRANTS WITHIN 25m OF THE PADMOUNT SUBSTATION TRANSFORMER.

PROPOSED 4800 x 5000 PADMOUNT SUBSTATION TRANSFORMER LOCATION.

CLOSEST COMMUNICATIONS PIT (TELSTRA / NBN) 25m PLUS FROM PADMOUNT SUBSTATION TRANSFORMER.

1 x 100mm DIA WHITE AND 6 x 125mm DIA ORANGE CONDUITS WITHIN THE ENERGEX FOOTPATH ZONE.

UNDERGROUND CONDUIT

MSB-B

BUILDING B

LOADING ZONE
PRIVATE DRIVEWAY

PROPERTY BOUNDARY

SITE PLAN
PROPOSED PADMOUNT SUBSTATION
SCALE 1: 250

NOTE:
AS PER THE CITY OF IPSWICH HISTORICAL FLOOD INFORMATION PACK, THE SITE IS NOT SUBJECT TO FLOODING AND DOES NOT HAVE A DEFINED Q100 FLOOD LEVEL.

building in background


ADJACENT SITE

FENCE


DETAIL B
PADMOUNT SECTION VIEW
SCALE 1: 50

NOTE:
DO NOT RUN PRIVATE SERVICE CABLE THROUGH CULVERT

AUGUSTA PARKWAY

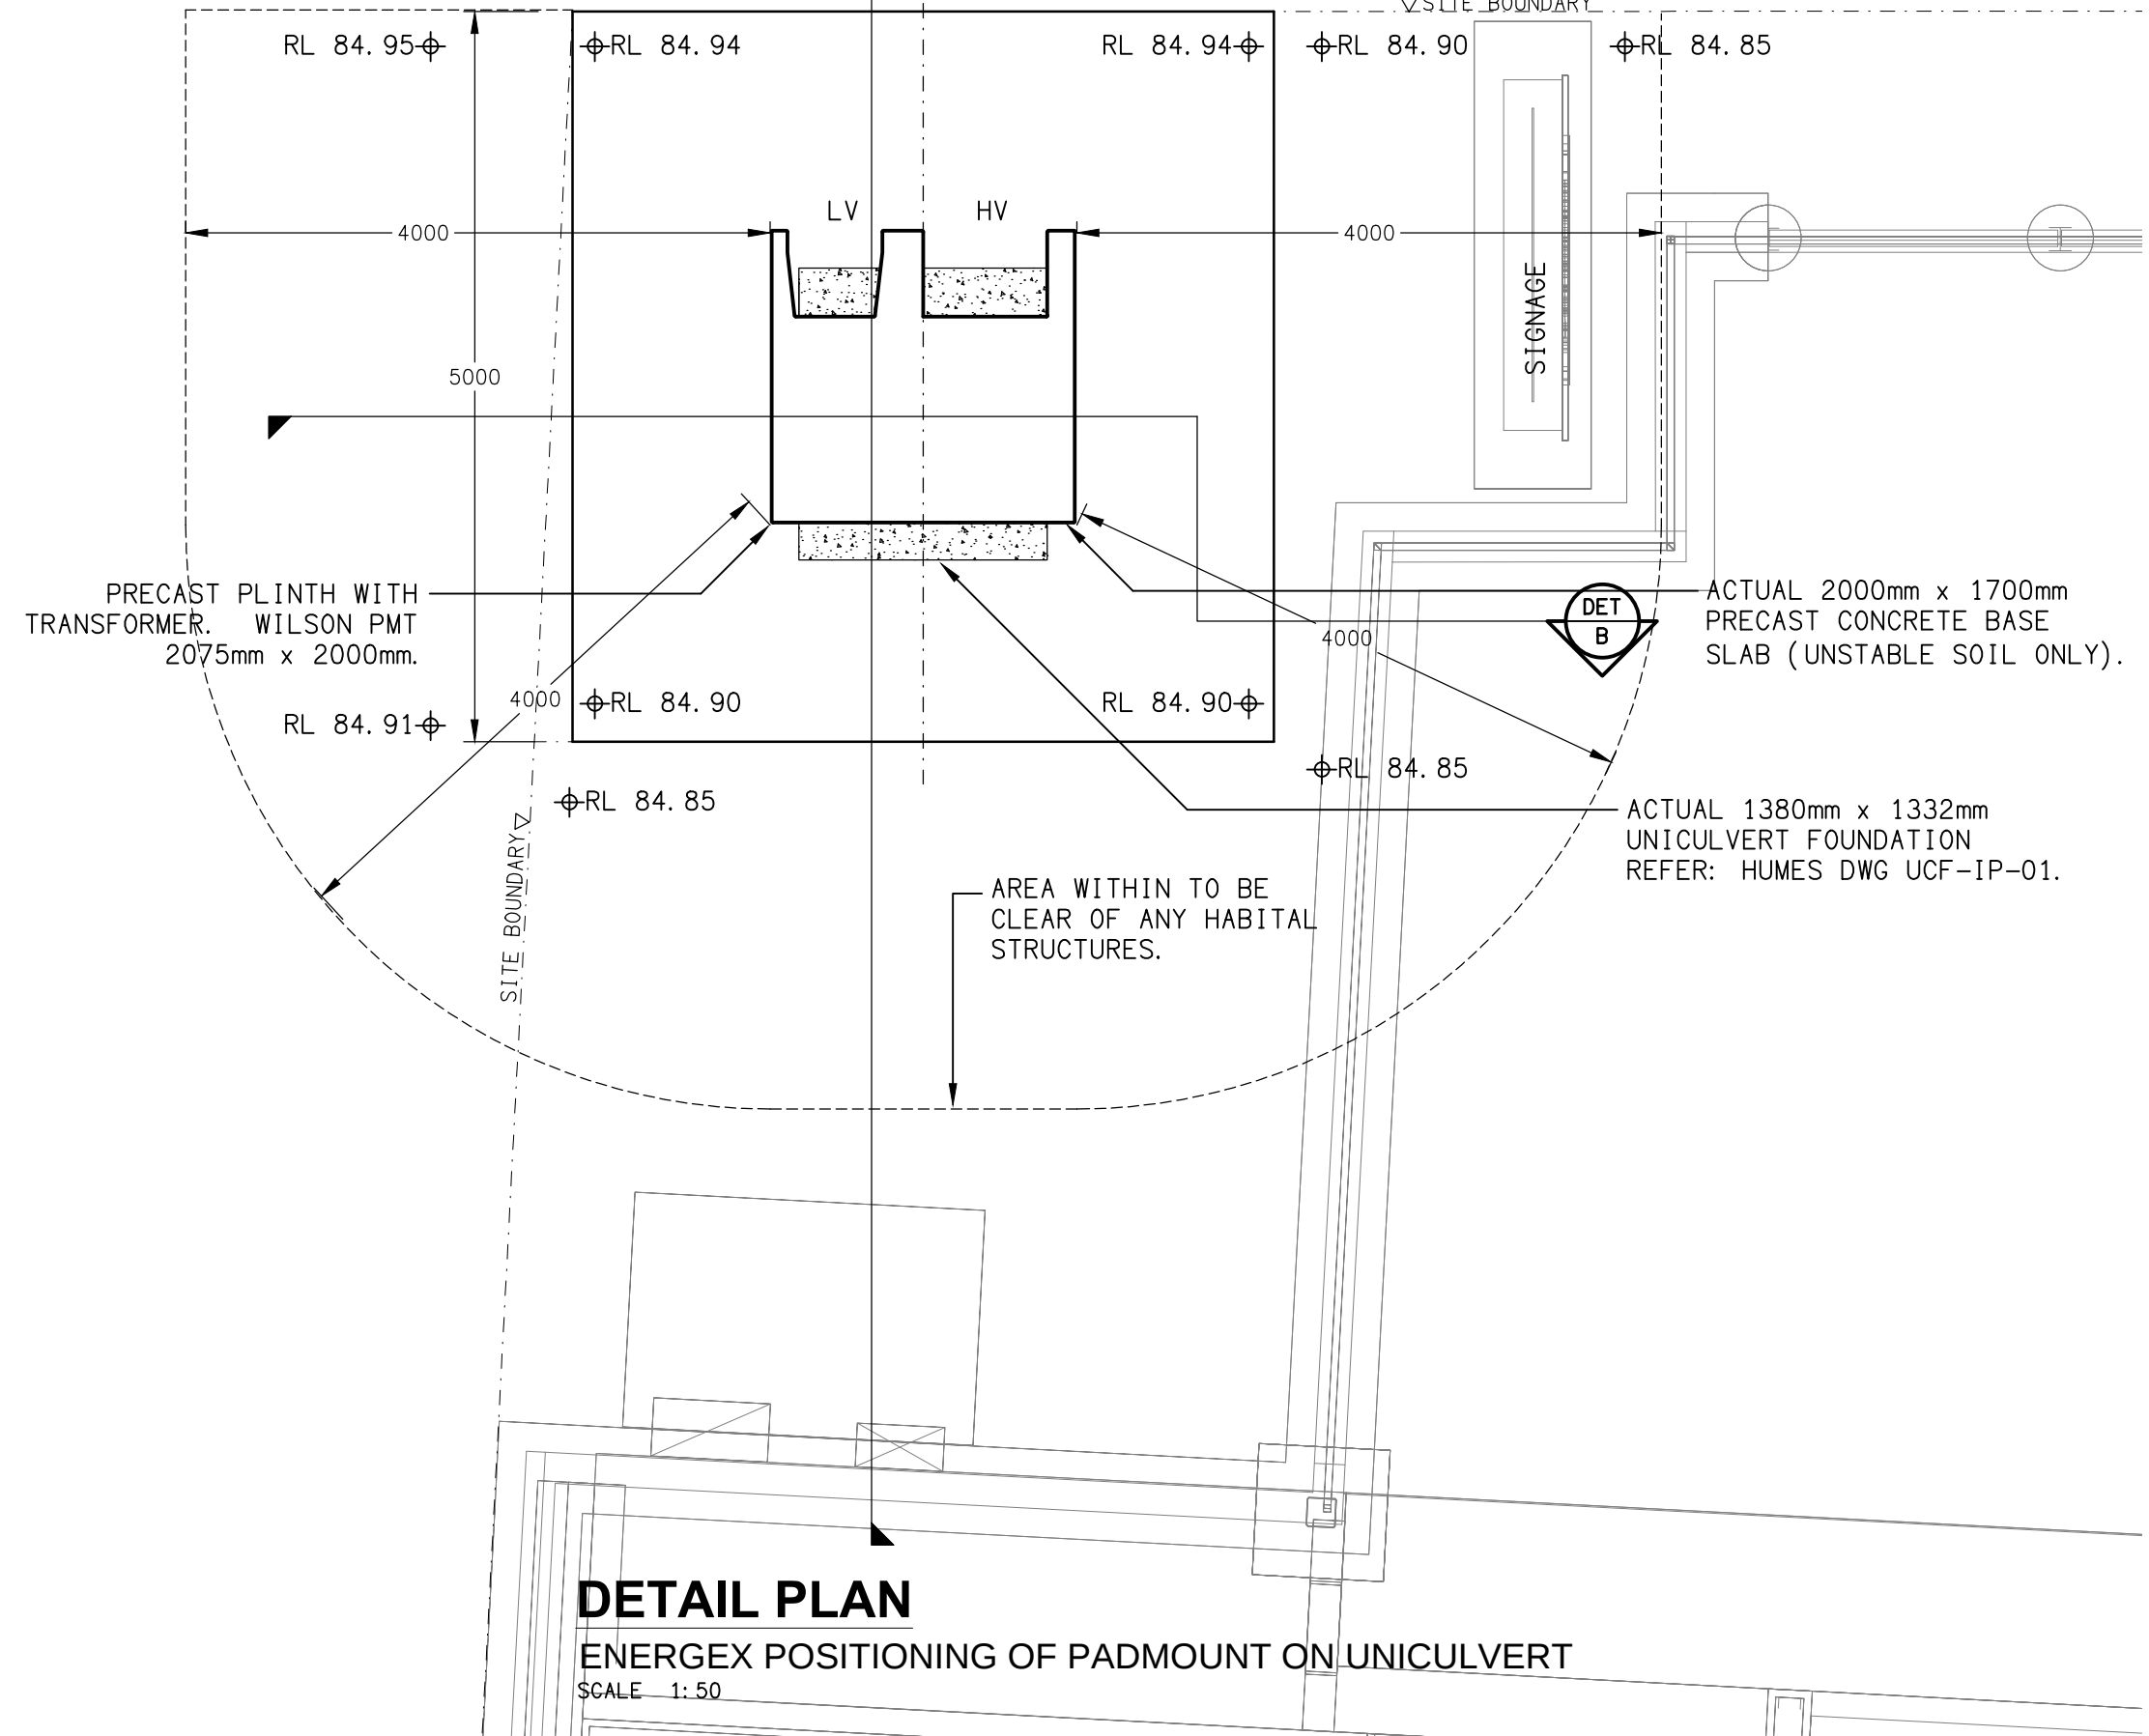

DETAIL PLAN
ENERGEX POSITIONING OF PADMOUNT ON UNICULVERT
SCALE 1: 50

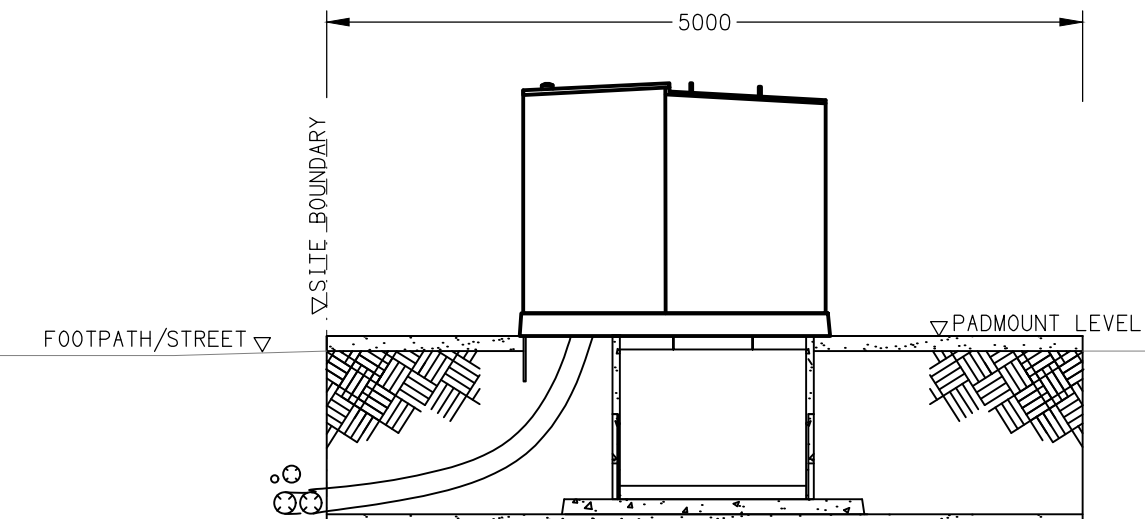

DETAIL A
PADMOUNT SECTION VIEW
SCALE 1: 50



CULVERT INSPECTION REQUIRED BEFORE TRANSFORMER IS DELIVERED
- 5 BUSINESS DAYS PRIOR NOTICE NEEDED.
CONTACT: PAUL HAWKINS PH: 0419 756 501 EMAIL: ProjectCoordinationsesth@energex.com.au

TRANSFORMER WILL NOT BE ENERGISED UNTIL ALL REQUIREMENTS ARE MET.

ELECTRICAL DESIGN GROUP BRISBANE
PTY LTD
ACN 092 710 793
TRADING AS:
ELECTRICAL DESIGN GROUP

THE COPYRIGHT OF THIS DRAWING
REMAINS THE PROPERTY OF THE
ELECTRICAL DESIGN GROUP.
USE FIGURED DIMENSIONS
IN PREFERENCE TO SCALE.
ALL DIMENSIONS TO BE
VERIFIED ONSITE.



Rohrig (Qld) Pty Ltd
ABN 67 093 753 970
QBSA LIC NO 740842
250 Abbotsford Road, Bowen Hills Qld 4006
PO Box 86 Albion DC Qld 4010
T+61 (7) 3257 4411 F+61 (7) 3257 2211
www.rohrig.com.au



ELECTRICAL DESIGN GROUP
ELECTRICAL BUILDING SERVICES CONSULTANTS
BRISBANE GOLD COAST
P.O.Box 15, Sherwood Q.4075
Phone: (07) 3278 4375
Email: brisbane@edg.net.au
Web: www.edg.net.au

PROJECT:
LLEWELLYN MOTORS SPRINGFIELD - LOT 32
LOT 32 AUGUSTA PARKWAY, AUGUSTINE HEIGHTS

2	AS CONSTRUCTED	13/07/2026
REV.	DESCRIPTION:	DATE:
DRAWING:	ELECTRICAL SERVICES ENERGEX PADMOUNT SUBSTATION SITE PLAN & DETAILS	
SCALE:	PROJECT NO:	DRAWING NO:
1:250 & 1:50	AT A1	C3294a
		EN01
		2