


FLOOR PLAN
EXISTING LEVEL 1
SCALE 1: 100

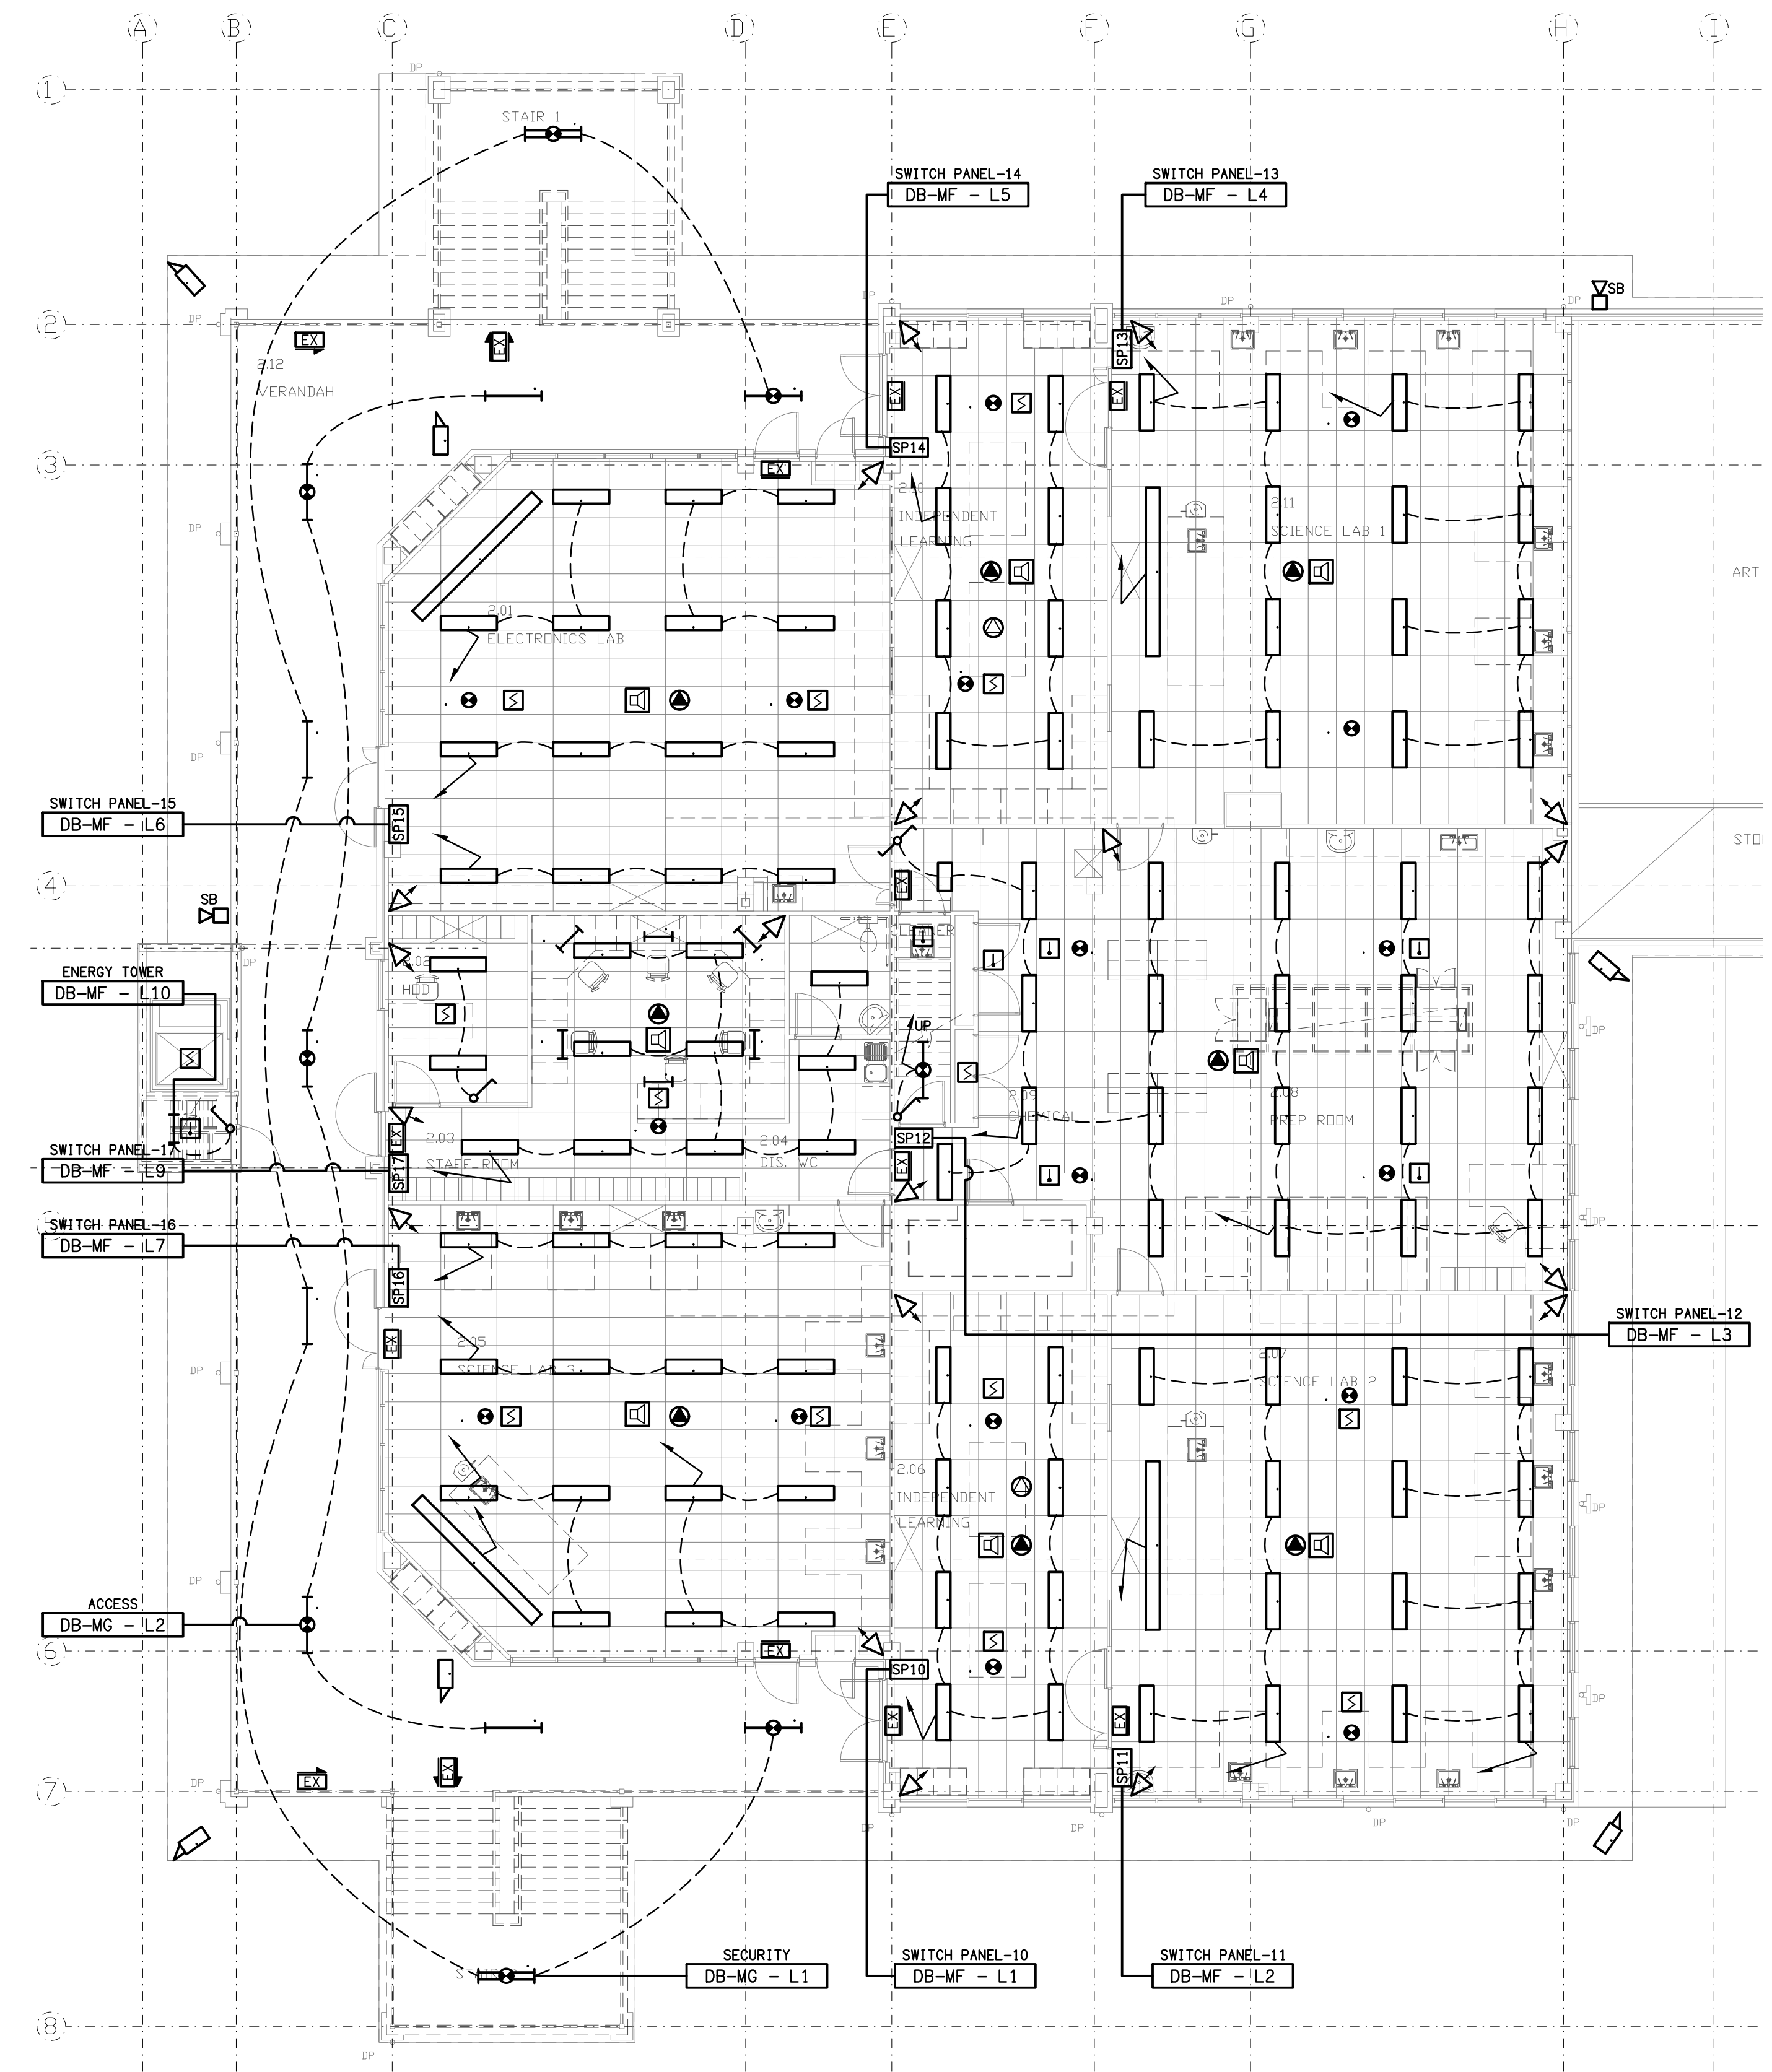

REFLECTED CEILING PLAN
EXISTING LEVEL 1
SCALE 1: 100

ELECTRICAL DESIGN GROUP BRISBANE
PTY LTD
ACN 092 710 793
TRADING AS:
ELECTRICAL DESIGN GROUP

THE COPYRIGHT OF THIS DRAWING
REMAINS THE PROPERTY OF THE
ELECTRICAL DESIGN GROUP.
USE FIGURED DIMENSIONS
IN PREFERENCE TO SCALE.
ALL DIMENSIONS TO BE
VERIFIED ONSITE.

ELECTRICAL DESIGN GROUP
ELECTRICAL BUILDING SERVICES CONSULTANTS
BRISBANE GOLD COAST
P.O. Box 15, Sherwood Q.4075
Phone: (07) 3278 4375
Email: brisbane@edg.net.au
Web: www.edg.net.au

PROJECT:
**ST JOHNS ANGLICAN COLLEGE
FOREST LAKE - MAST LOFT CONVERSION**
COLLEGE AVENUE, FOREST LAKE

B	TENDER	09/07/2024
REV:	DESCRIPTION:	DATE:
DRAWING: ELECTRICAL SERVICES LEVEL 1 EXISTING PLANS		
SCALE: 1:100	AT A1	PROJECT NO: C3305a
		DRAWING NO: E02
		REVISION: B