



EXISTING PLAN
MEZZANINE LEVEL
SCALE 1:50

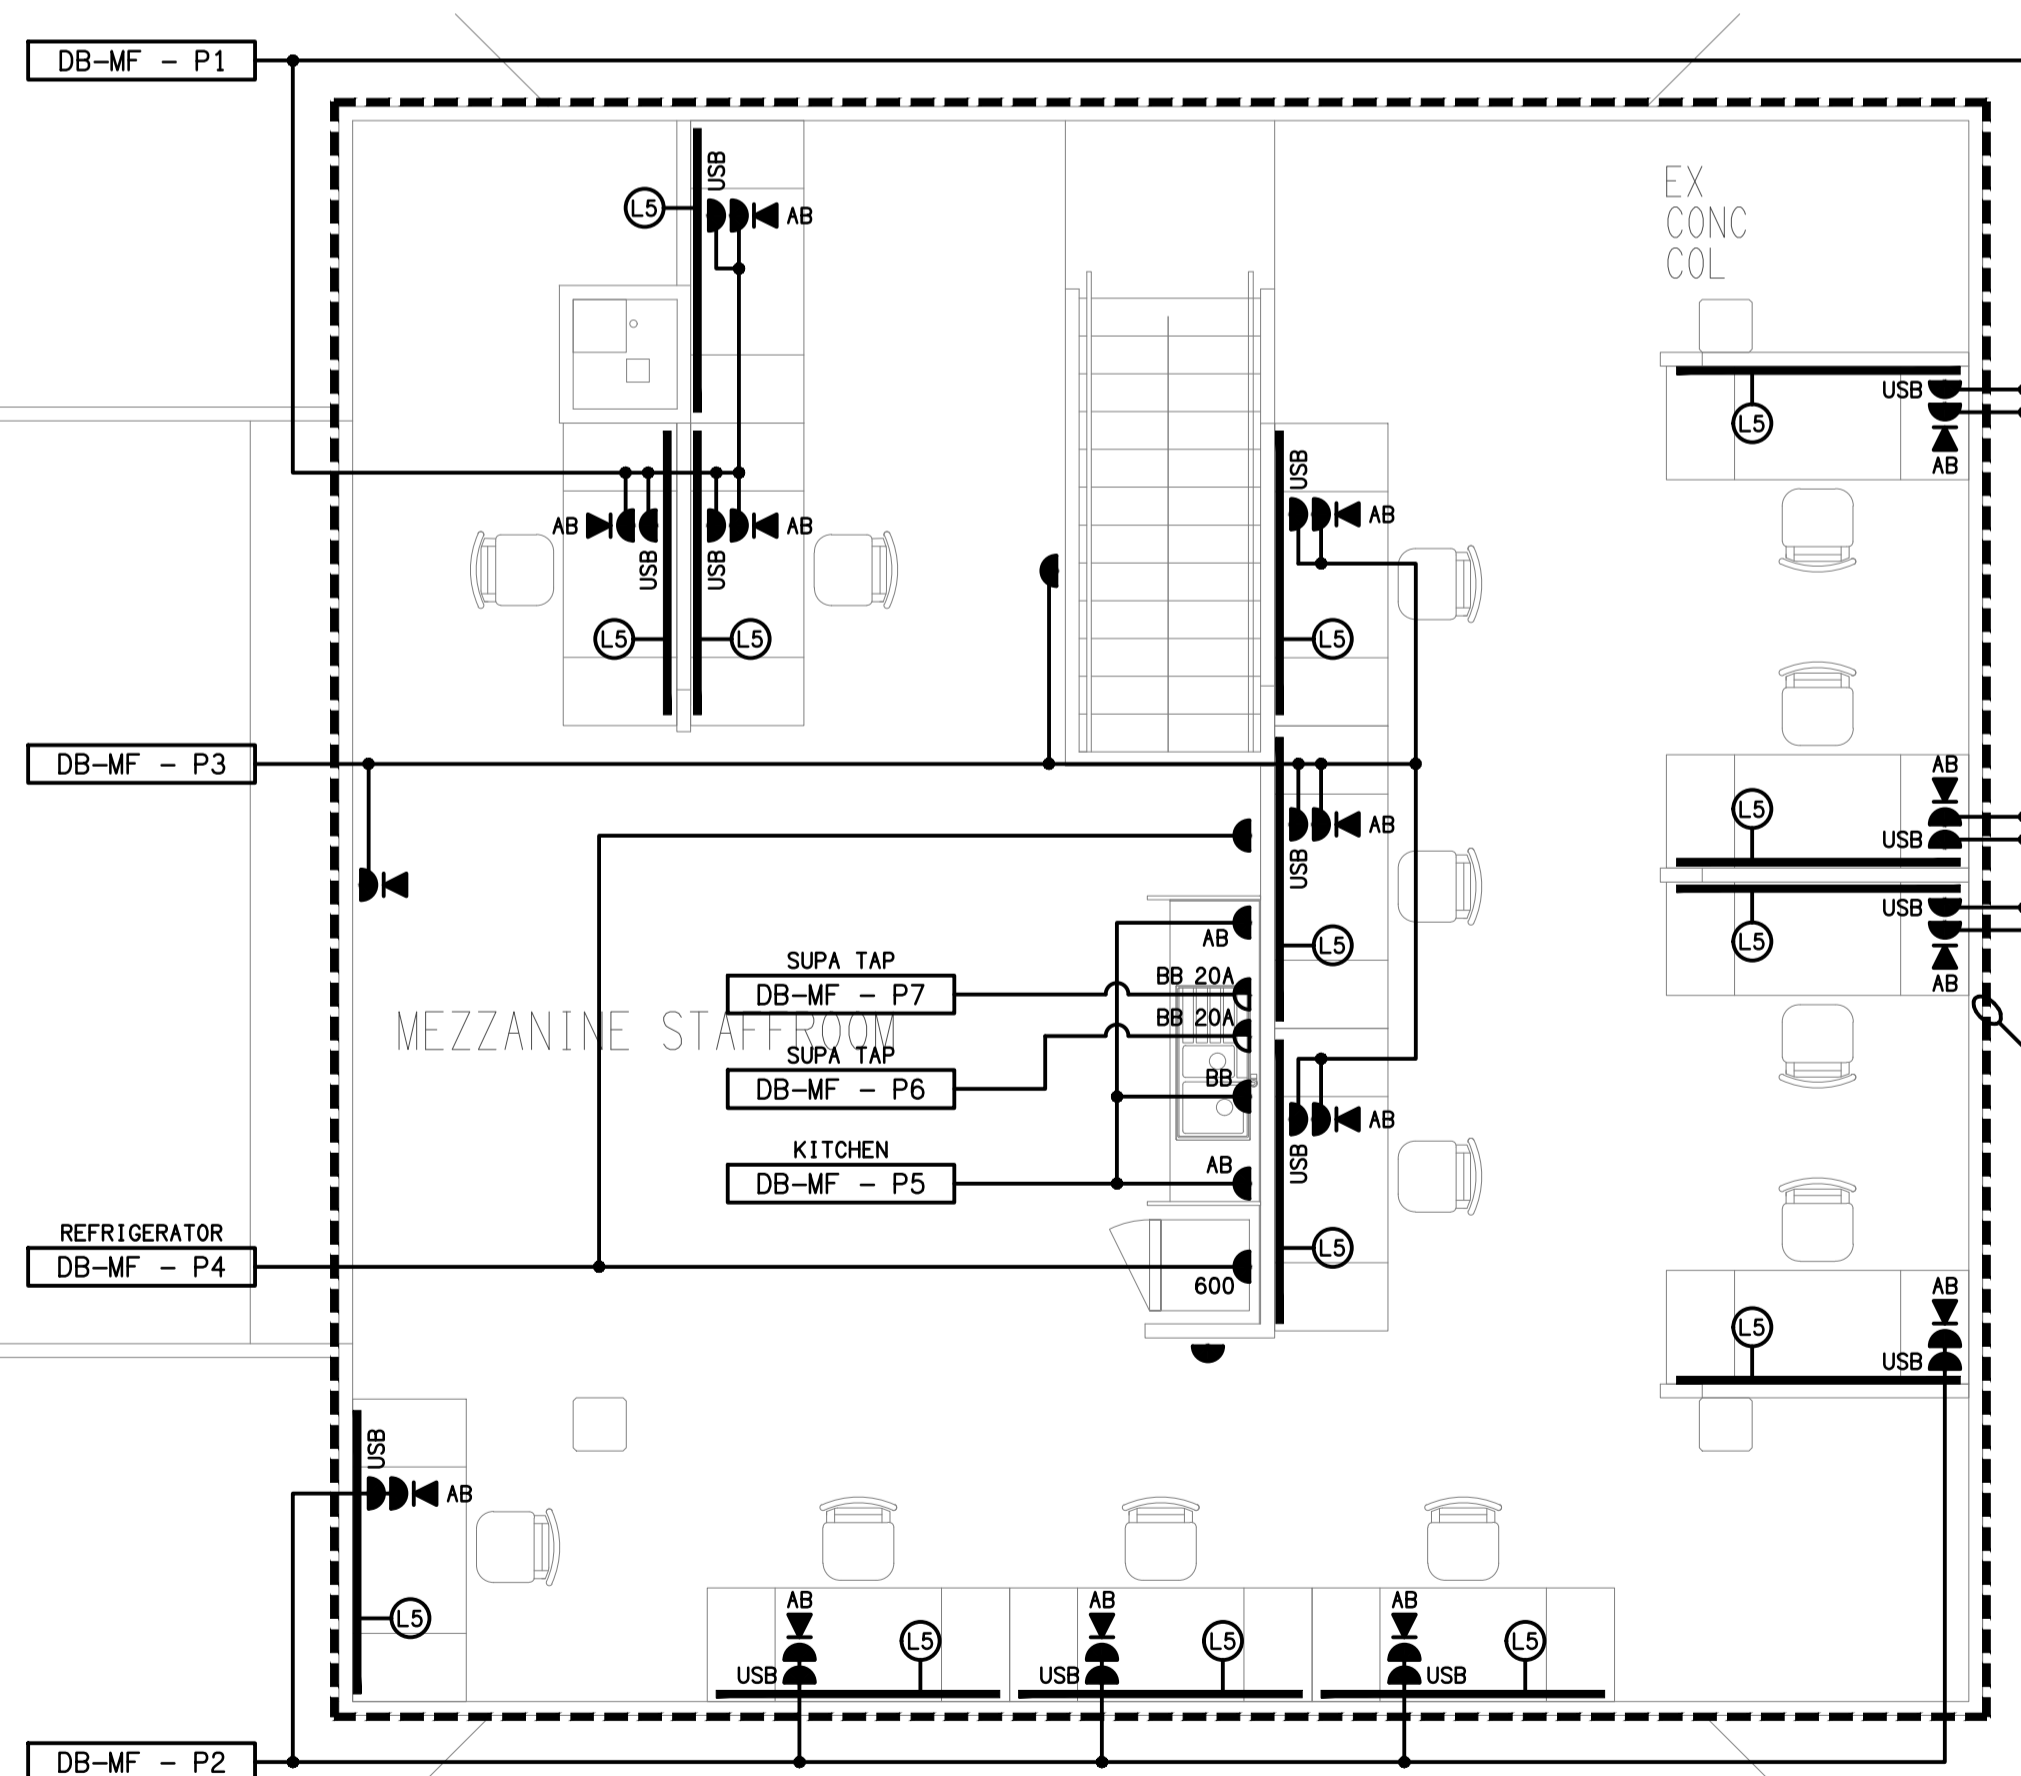

FLOOR PLAN
PROPOSED MEZZANINE LEVEL
SCALE 1:50

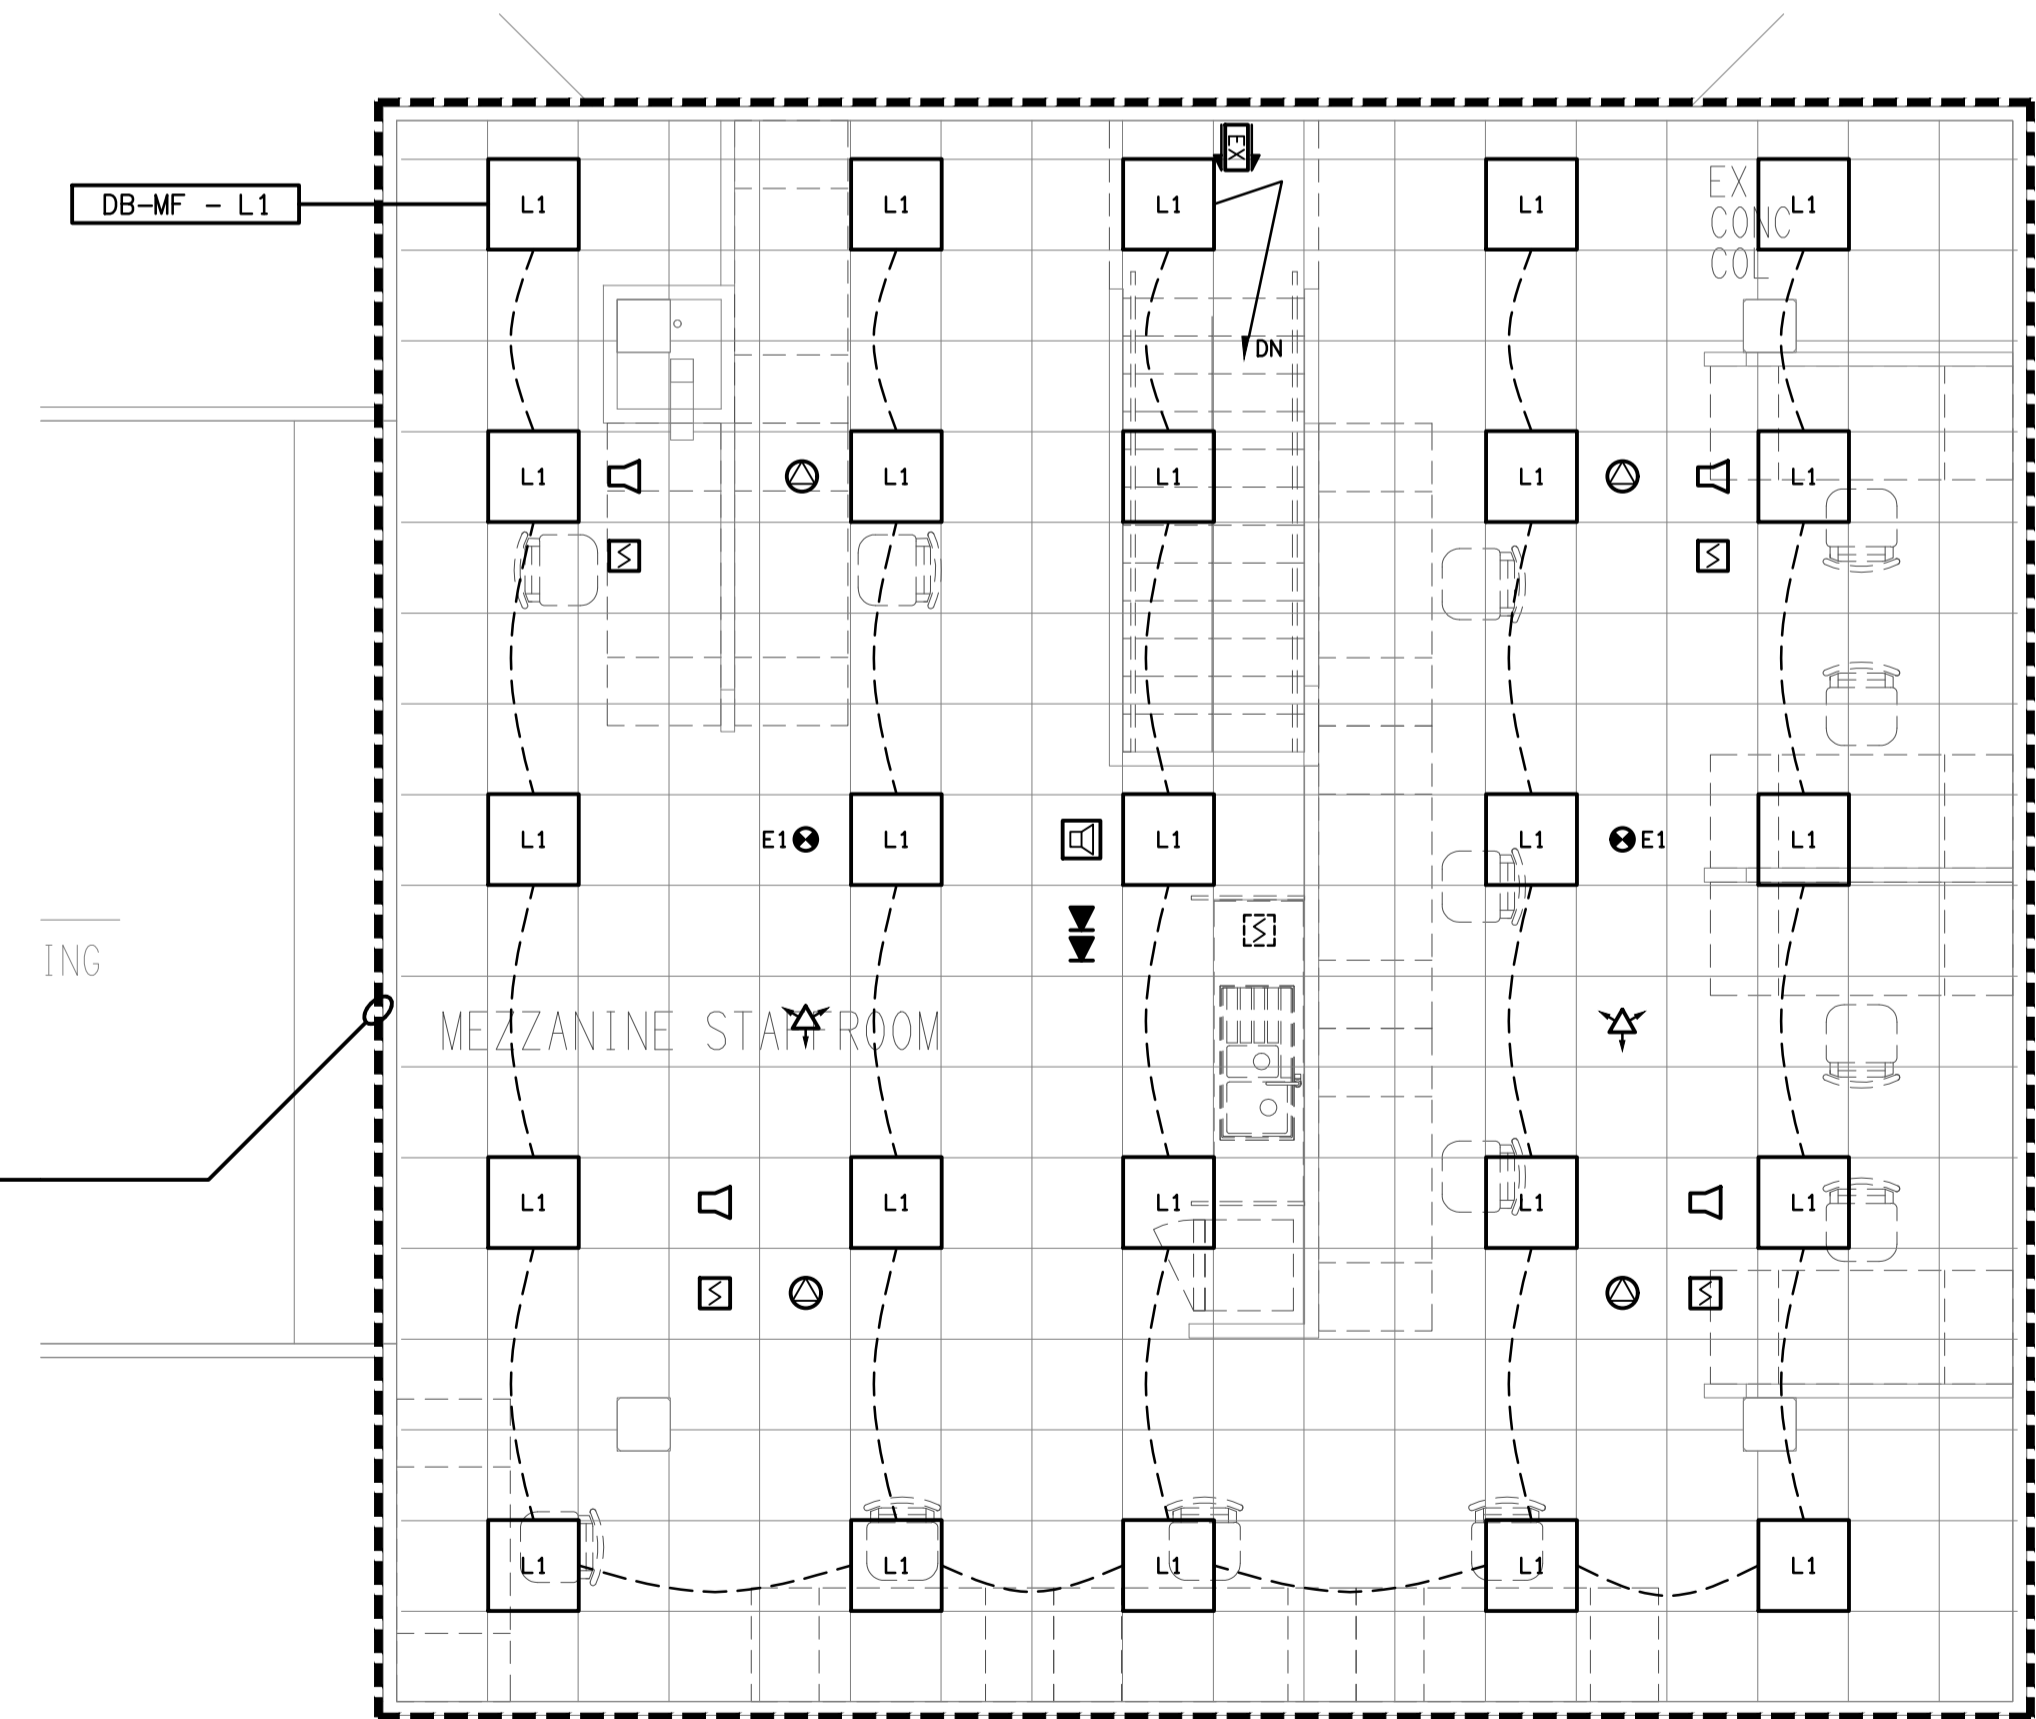

REFLECTED CEILING PLAN
PROPOSED MEZZANINE LEVEL
SCALE 1:50

EXISTING ELECTRICAL SERVICES WITHIN THIS DASH LINED AREA TO BE REMOVED, UNLESS NOTED OTHERWISE.

ELECTRICAL DESIGN GROUP BRISBANE
PTY LTD
ACN 092 710 793
TRADING AS:
ELECTRICAL DESIGN GROUP

THE COPYRIGHT OF THIS DRAWING
REMAINS THE PROPERTY OF THE
ELECTRICAL DESIGN GROUP.

USE FIGURED DIMENSIONS
IN PREFERENCE TO SCALE.

ALL DIMENSIONS TO BE
VERIFIED ONSITE.

ELECTRICAL DESIGN GROUP
ELECTRICAL BUILDING SERVICES CONSULTANTS
BRISBANE GOLD COAST

P.O. Box 15, Sherwood Q.4075
Phone: (07) 3278 4375
Email: brisbane@edg.net.au
Web: www.edg.net.au

PROJECT:
**ST JOHNS ANGLICAN COLLEGE
FOREST LAKE - MAST LOFT CONVERSION**

COLLEGE AVENUE, FOREST LAKE

| | | |
|------|--------------|------------|
| B | TENDER | 09/07/2024 |
| REV. | DESCRIPTION: | DATE: |

DRAWING:
**ELECTRICAL SERVICES
MEZZANINE PLANS**

SCALE:
1:50

AT A1

PROJECT NO:
C3305a

DRAWING NO:
E04

REVISION:
B